

ARCHITECTS
INTERIORS
PLANNERS


55 GREEN STREET
PORTSMOUTH, NH 03801
T 603.436.2551
F 603.436.6973
www.jsainc.com

NEILL & GUNTER, Inc.
Design and Consulting Engineers
Scarborough, Maine

RENOVATIONS TO
RICHARD'S 3rd FLOOR

MAINE MEDICAL CENTER
Portland, Maine

Scale: 1/4"=1'-0"
Project Number: 03-103
Date: MAY 25, 2004
Revisions:

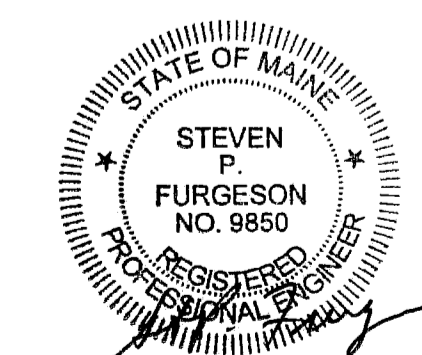

5/25/04

CONSTRUCTION
DOCUMENTS


M-2A

Copyright 2002, JSA, Inc

DRAWING KEYNOTES

TAG	NOTES
①	20"x16" EXHAUST DUCT UP IN CHASE TO INTERMEDIATE MECHANICAL FLOOR.
②	7"φ SUPPLY DUCT UP IN CHASE TO INTERMEDIATE MECHANICAL FLOOR.
③	MOUNT SUPPLY GRILL IN FACE OF ARCHITECTURAL SOFFITT.
④	6"φ SUPPLY DUCT UP IN CHASE TO INTERMEDIATE FLOOR. 1 1/2"φ HWS/R UP IN CHASE TO INTERMEDIATE FLOOR.
⑤	SEE VAV TERMINAL REHEAT COIL PIPING DETAIL FOR HOOKUP. (TYP.)
⑥	DUCTWORK & PIPE ROUTING TO RICHARDS 3rd FLOOR PLAN (WEST) SOILED UTILITY ROOM. DUCT & PIPE LOCATION IS DIAGRAMMATIC. CEILING SPACE IS CONGESTED. CONTRACTOR TO VERIFY IN FIELD.

MATCHLINE: SEE DRAWING M1.01B FOR CONTINUATION

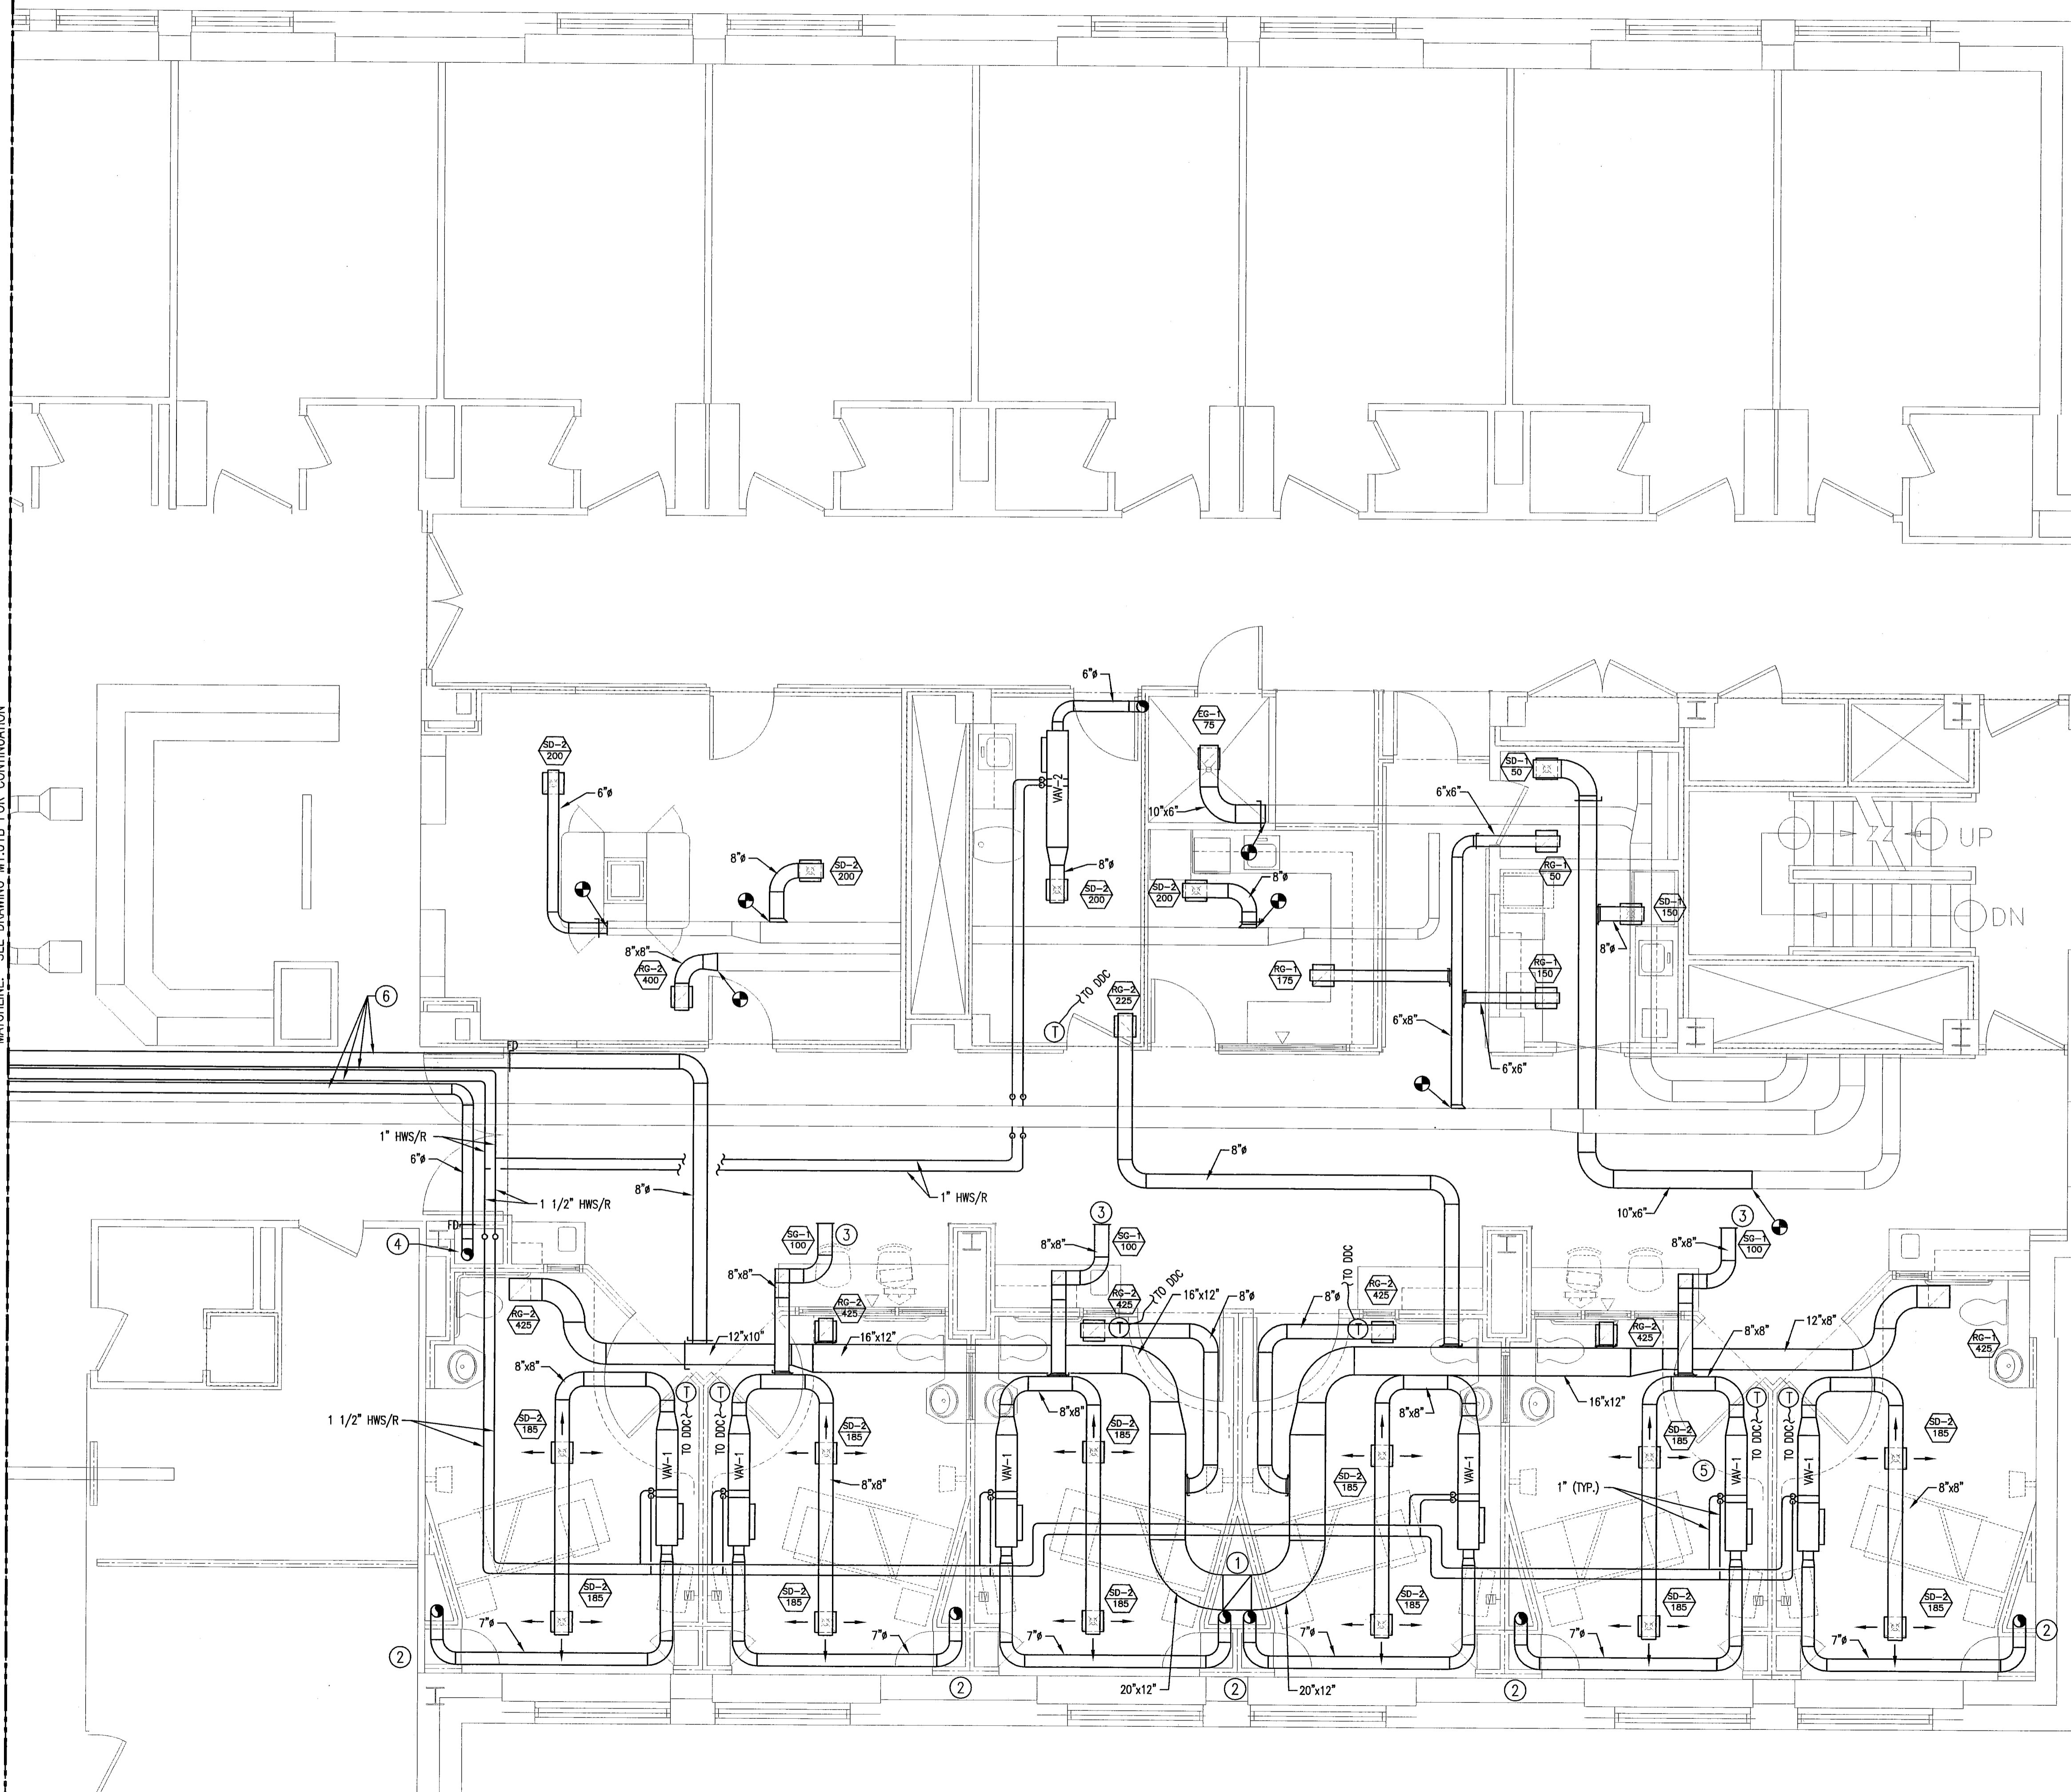

L:\25485\Cadd\ConeDoc5-25-04\25485M004.dwg May 24, 2004 - 3:53pm



Neill and Gunter

RICHARDS 3rd FLOOR PLAN (EAST) - MECHANICAL
CAD FILE 25485M004