



ARCHITECTS
INTERIORS
PLANNERS


55 GREEN STREET
PORTSMOUTH, NH 03801
T 603.436.2551
F 603.436.6973
www.jsainc.com

NEILL & GUNTER, Inc.
Design and Consulting Engineers
Scarborough, Maine

RENOVATIONS TO RICHARD'S 3rd FLOOR

MAINE MEDICAL CENTER
Portland, Maine



Scale: 1/8"=1'-0"
Project Number: 03-103
Date: MAY 25, 2004
Revisions:

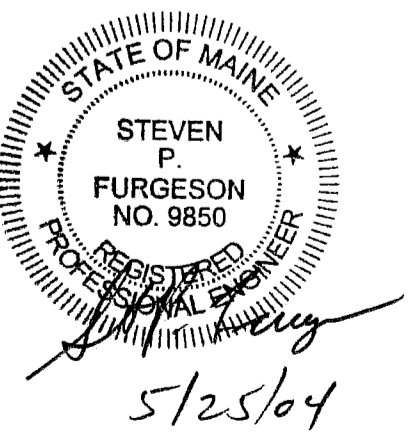

CONSTRUCTION
DOCUMENTS

PD-2

© Copyright 2002, JSA, Inc

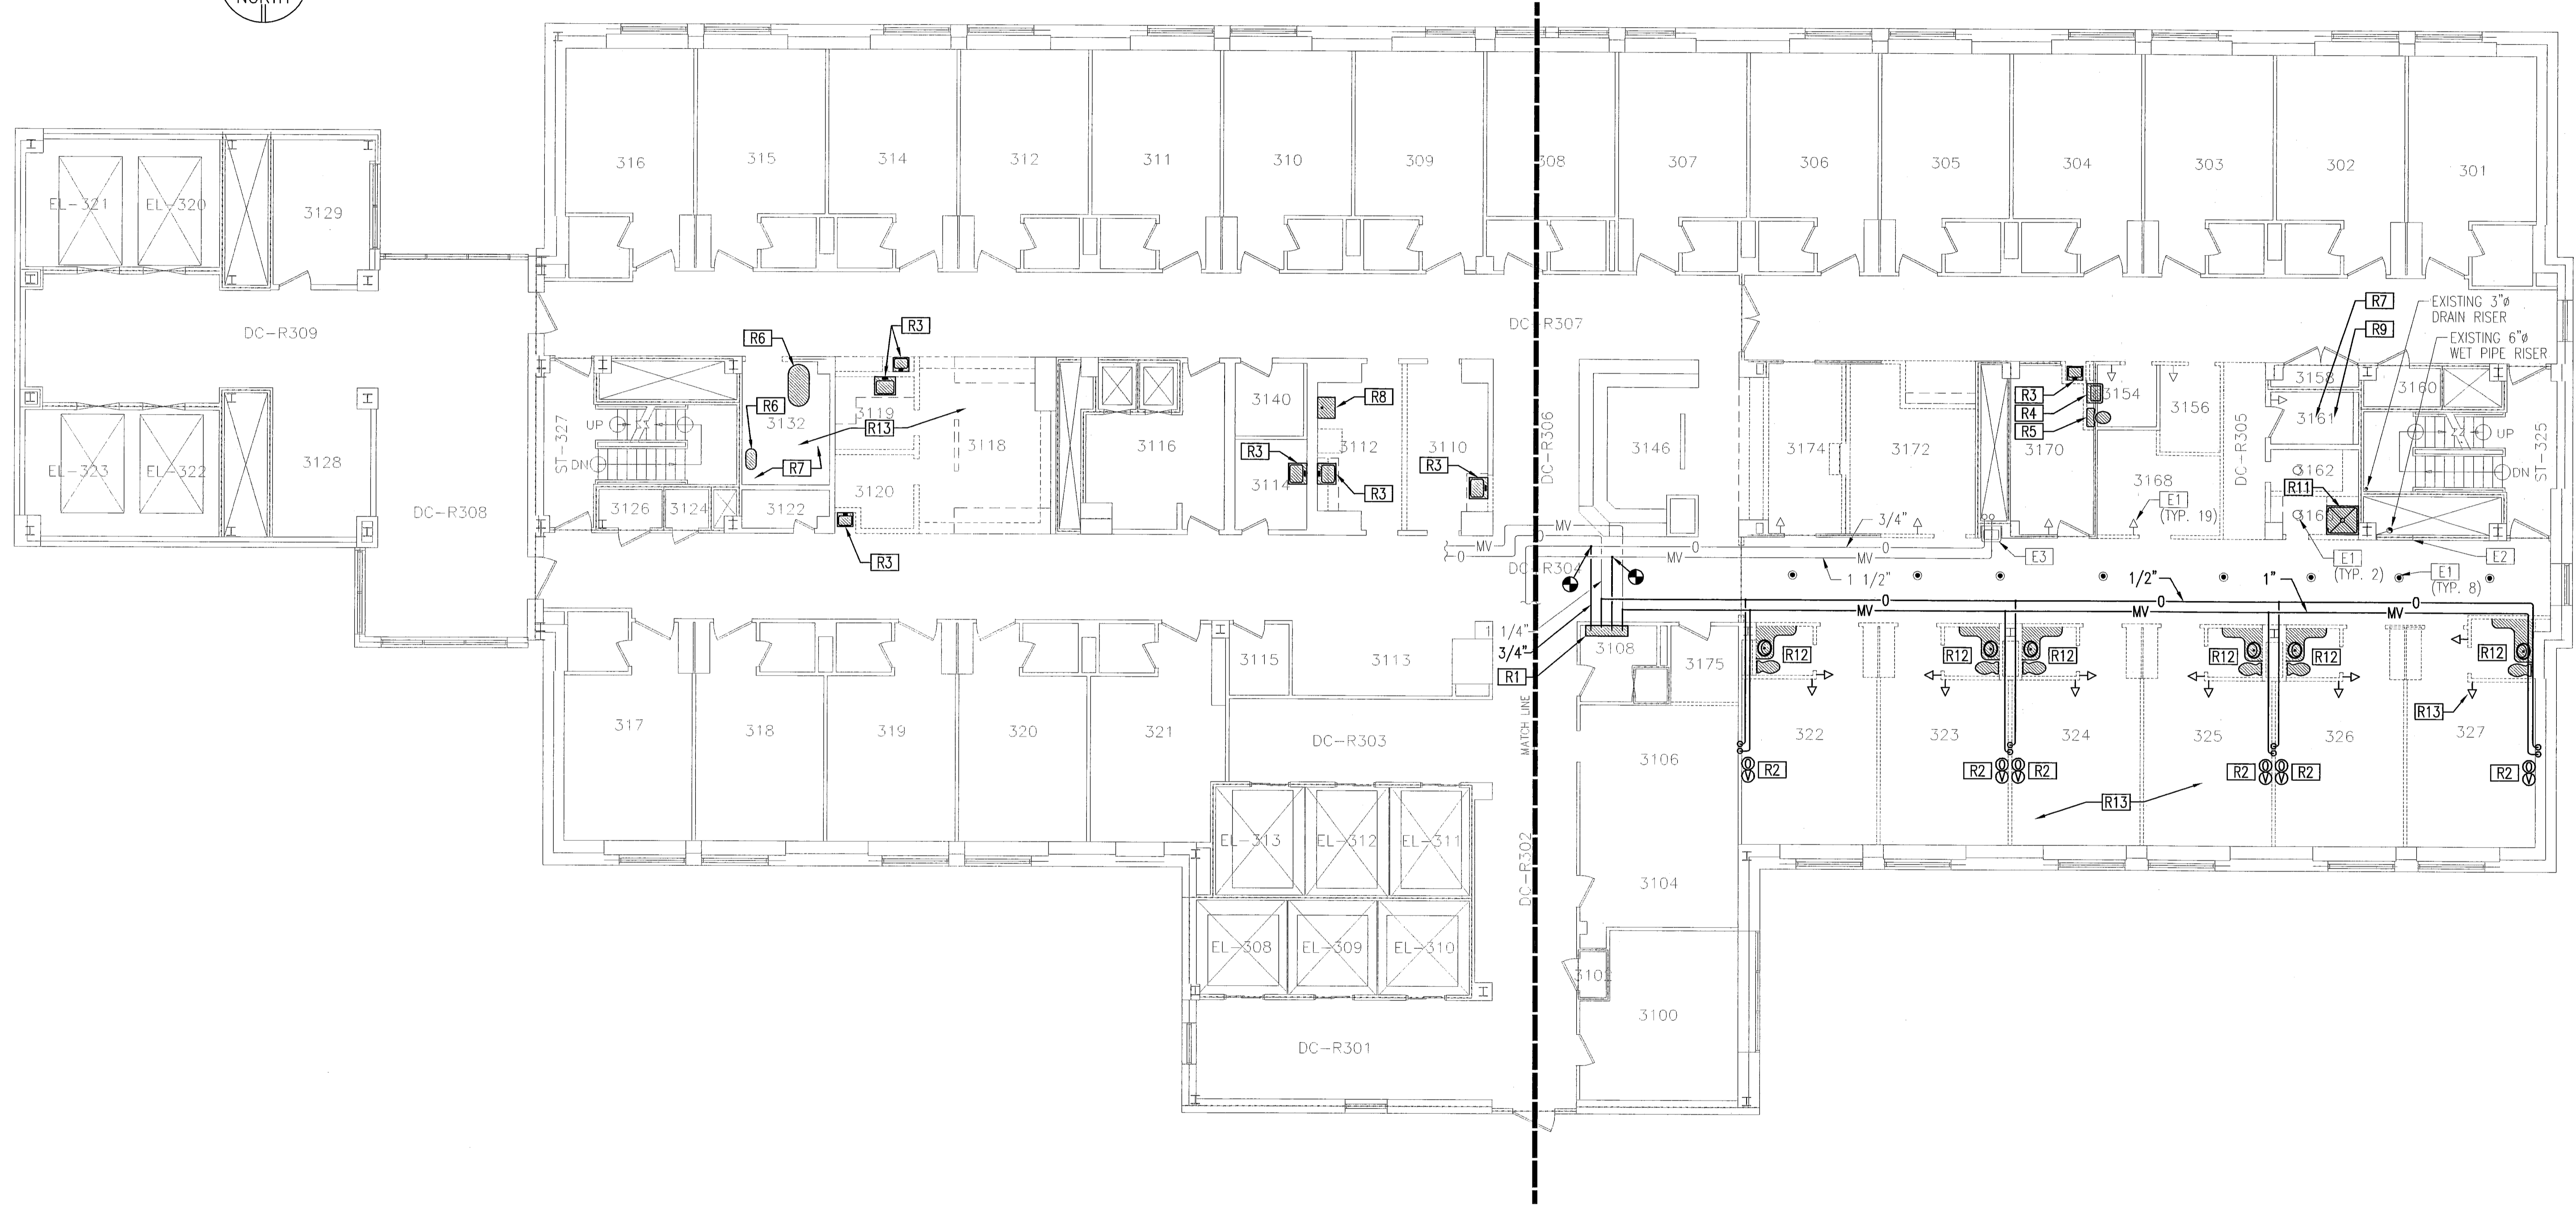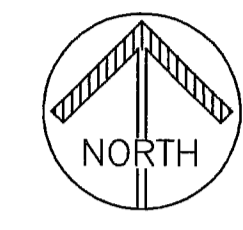

L:\25485\Cadd\Construct\025-04\25485P002.dwg May 24, 2004 - 4:16pm



Neill and Gunter

RICHARDS 3rd FLOOR PLAN - PLUMBING DEMOLITION

CAD FILE 25485P002