



ARCHITECTS  
INTERIORS  
PLANNERS


55 GREEN STREET  
PORTSMOUTH, NH 03801  
T 603.436.2551  
F 603.436.6973  
www.jsainc.com

NEILL & GUNTER, Inc.  
Design and Consulting Engineers  
Scarborough, Maine

RENOVATIONS TO  
RICHARD'S 3rd FLOOR

MAINE MEDICAL CENTER  
Portland, Maine



Scale: 1/8"=1'-0"  
Project Number: 03-103  
Date: MAY 25, 2004  
Revisions:

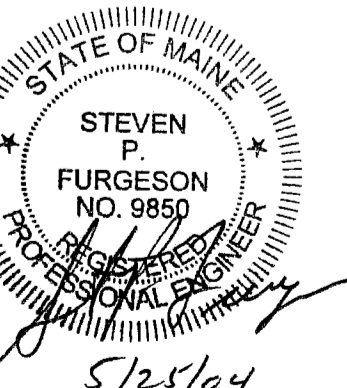

CONSTRUCTION  
DOCUMENTS

P-2

© Copyright 2002, JSA, Inc

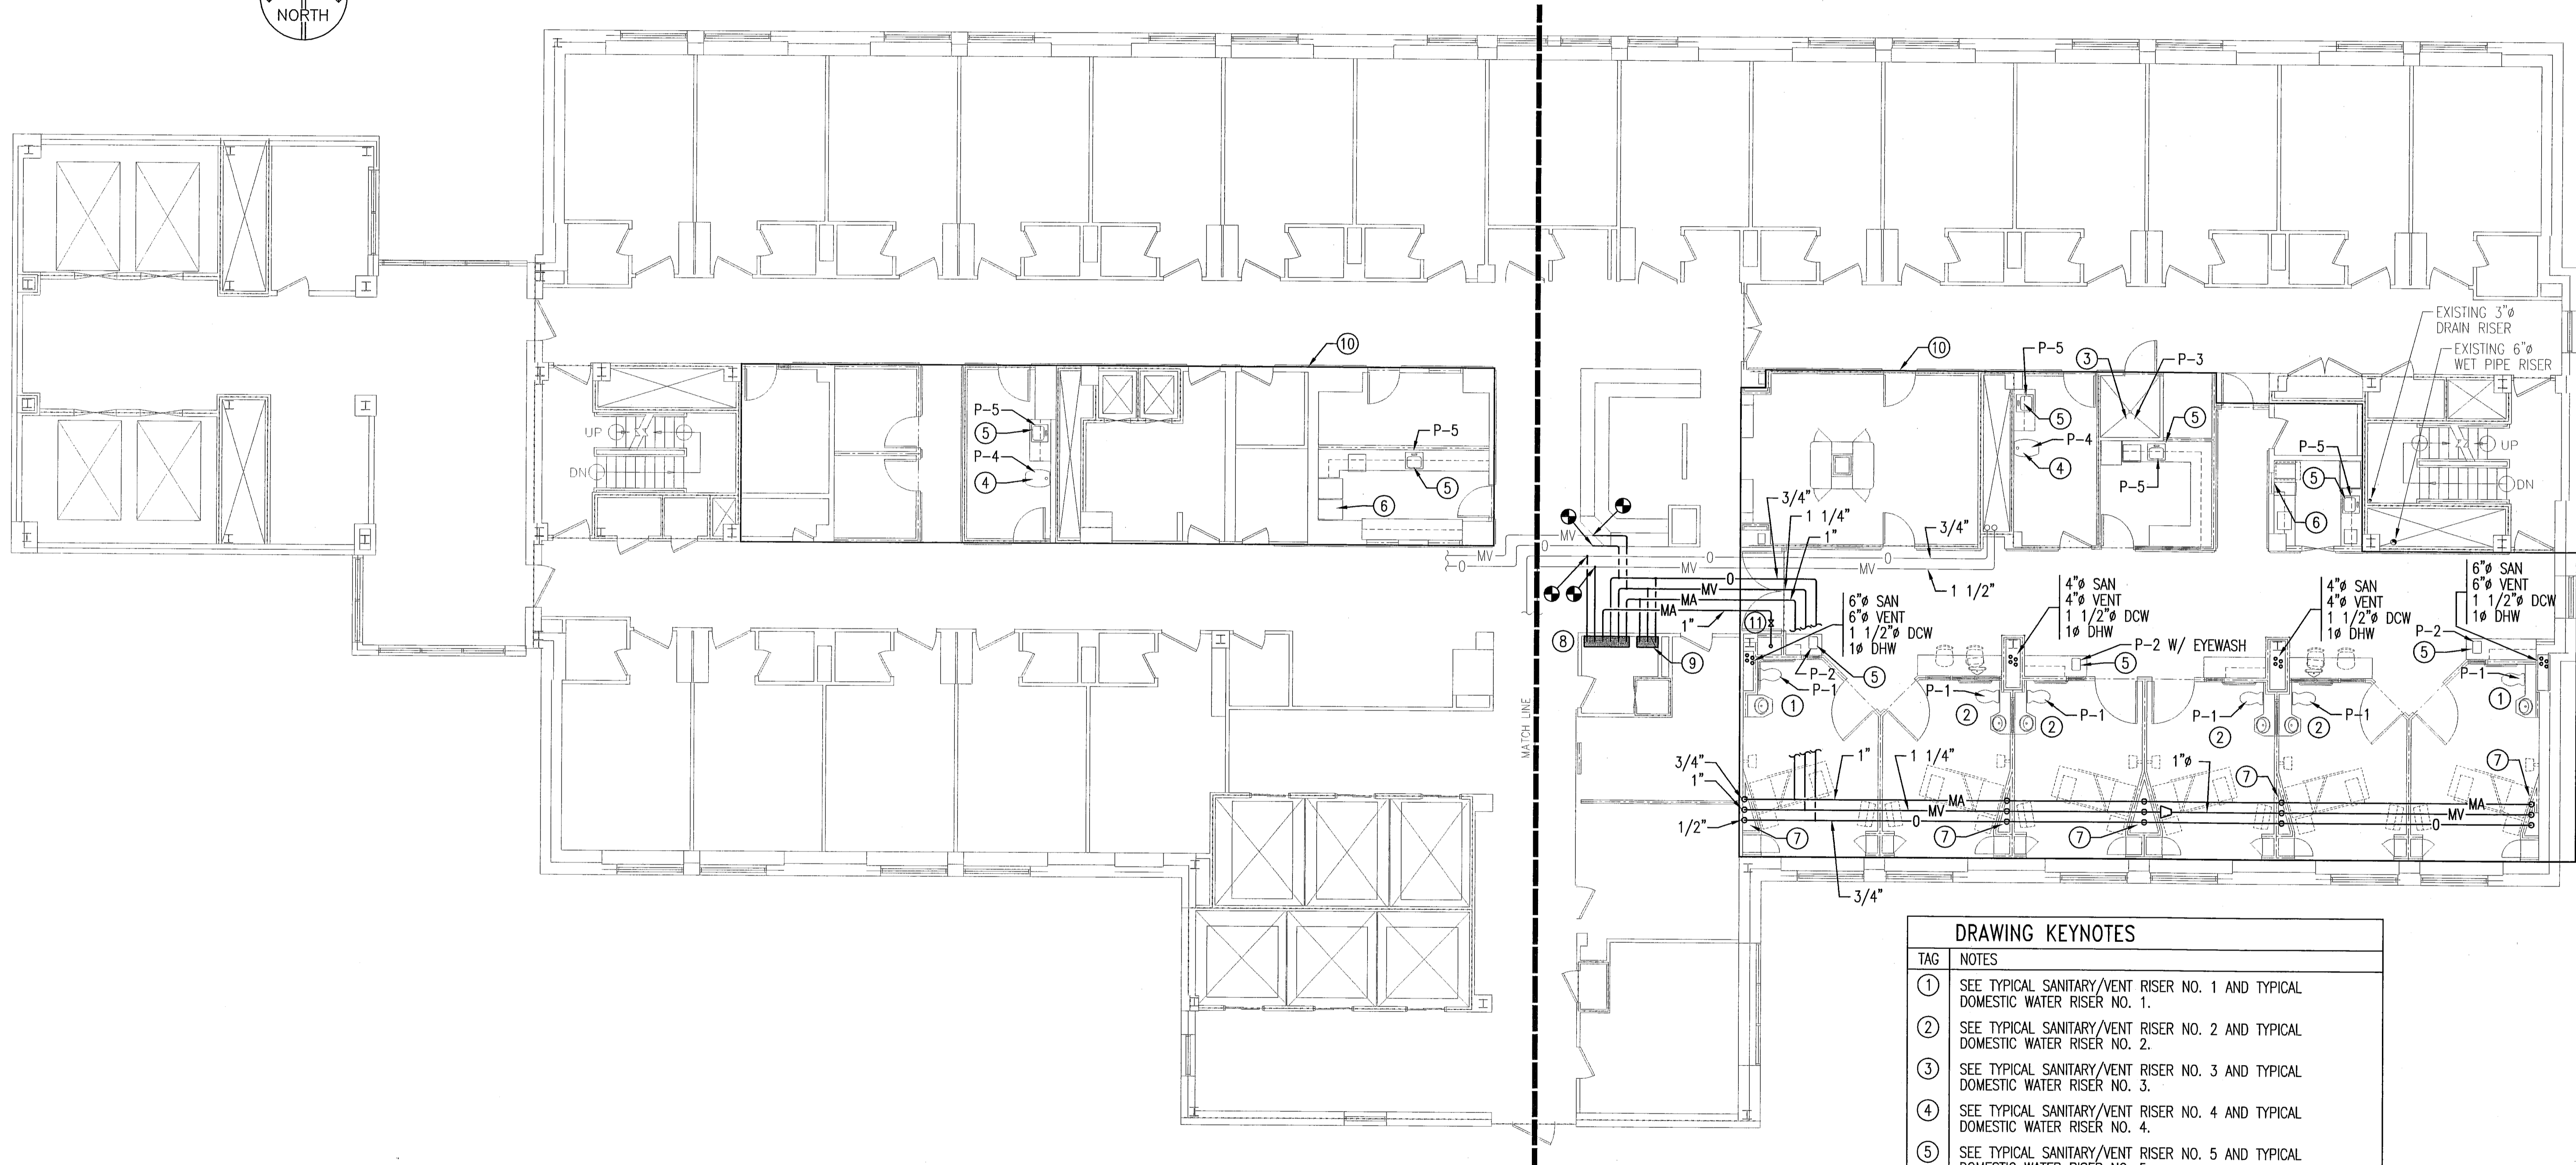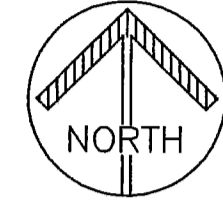

DRAWING KEYNOTES	
TAG	NOTES
①	SEE TYPICAL SANITARY/VENT RISER NO. 1 AND TYPICAL DOMESTIC WATER RISER NO. 1.
②	SEE TYPICAL SANITARY/VENT RISER NO. 2 AND TYPICAL DOMESTIC WATER RISER NO. 2.
③	SEE TYPICAL SANITARY/VENT RISER NO. 3 AND TYPICAL DOMESTIC WATER RISER NO. 3.
④	SEE TYPICAL SANITARY/VENT RISER NO. 4 AND TYPICAL DOMESTIC WATER RISER NO. 4.
⑤	SEE TYPICAL SANITARY/VENT RISER NO. 5 AND TYPICAL DOMESTIC WATER RISER NO. 5.
⑥	PROVIDE COLD WATER HOOKUP AND INDIRECT WASTE FOR ICE MACHINE.
⑦	SEE DROP TO OUTLETS TYPICAL MEDICAL GAS HEADWALL CONNECTION DETAIL.
⑧	INSTALL NEW MEDICAL GAS VALVE BOX.
⑨	INSTALL NEW MEDICAL GAS ALARM PANEL.
⑩	FIRE PROTECTION CONTRACTOR TO DESIGN AND INSTALL WET PIPE SPRINKLER SYSTEM WITHIN THIS AREA.
⑪	INSTALL LOCKABLE MEDICAL GAS SHUTOFF VALVE IN MEDICAL AIR PIPE.



Neill and Gunter

RICHARDS 3rd FLOOR PLAN - PLUMBING

CAD FILE 25485P004