


ARCHITECTS
INTERIORS
PLANNERS

55 GREEN STREET
PORTSMOUTH, NH 03801
T 603.436.2551
F 603.436.6973
www.jsainc.com

DRAWING KEYNOTES	
TAG	NOTES
①	SEE TYPICAL SANITARY/VENT RISER NO. 1 AND TYPICAL DOMESTIC WATER RISER NO. 1.
②	SEE TYPICAL SANITARY/VENT RISER NO. 2 AND TYPICAL DOMESTIC WATER RISER NO. 2.
③	SEE TYPICAL SANITARY/VENT RISER NO. 3 AND TYPICAL DOMESTIC WATER RISER NO. 3.
④	NOT USED.
⑤	SEE DROP TO OUTLETS TYPICAL MEDICAL GAS HEADWALL CONNECTION DETAIL.
⑥	INSTALL NEW MEDICAL GAS VALVE BOX.
⑦	INSTALL NEW MEDICAL GAS ALARM PANEL.
⑧	FIRE PROTECTION CONTRACTOR TO DESIGN AND INSTALL WET PIPE SPRINKLER SYSTEM WITHIN THIS AREA.
⑨	INSTALL LOCKABLE SHUTOFF VALVE IN NEW MEDICAL AIR PIPE.

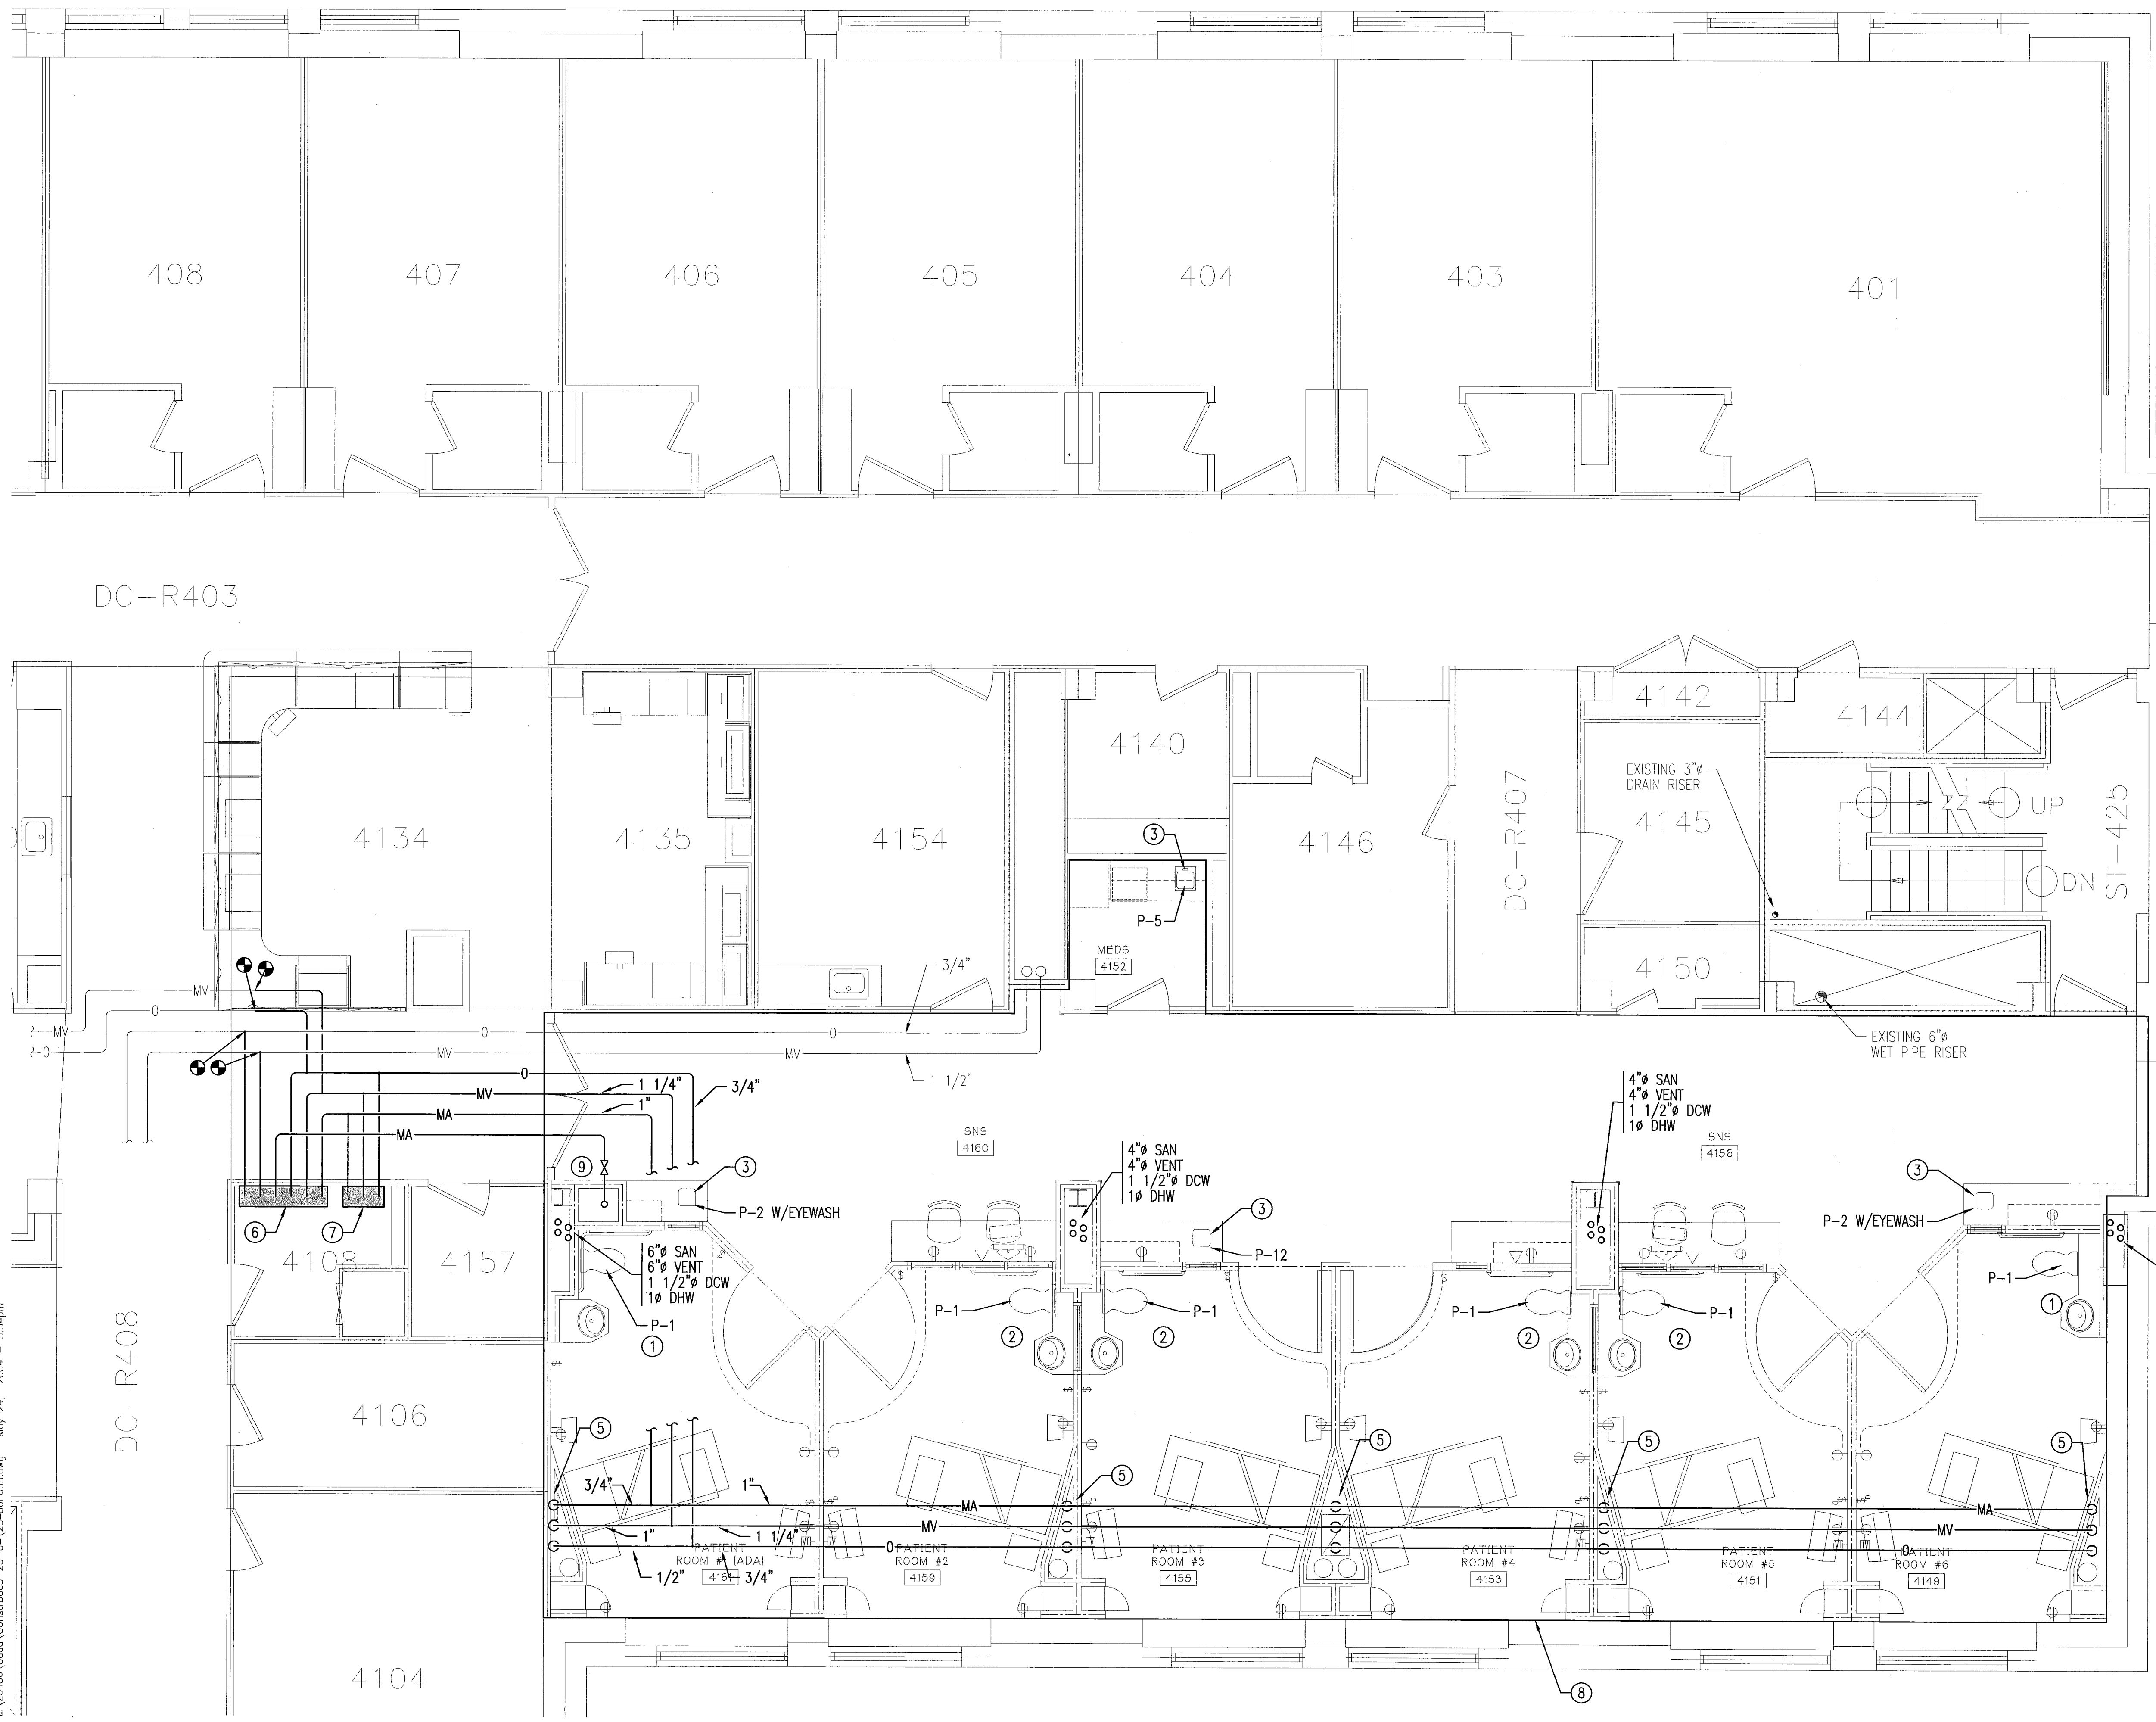


NEILL & GUNTER, Inc.
Design and Consulting Engineers
Scarborough, Maine

**RENOVATIONS TO
RICHARD'S 4th FLOOR
INTERMEDIATE CARE
UNITS**

MAINE MEDICAL CENTER
Portland, Maine

Scale: 1/4"=1'-0"
Project Number: 02-021
Date: MAY 25, 2004
Revisions:

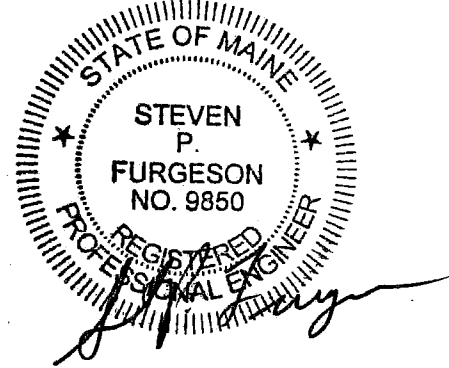

CONSTRUCTION
DOCUMENTS



RICHARDS 4th FLOOR PLAN - PLUMBING
CAD FILE 25486P005

P-2

L:\25486\Cadd\Constr\Doc5-25-04\25486P005.dwg May 24, 2004 - 3:34pm