


General Notes:  
 1. ALL CEILING HEIGHTS SHALL BE 9'-0" UNLESS OTHERWISE NOTED  
 2. ALL SOFFIT HEIGHTS SHALL BE 7'-2" UNLESS OTHERWISE NOTED.  
 3. ALL CEILING GRIDS ARE CENTERED IN ROOMS UNLESS NOTED OTHERWISE.  
 4. ABBREVIATION  $\frac{1}{2}$  FT  $\perp$  DEFINES THE USE OF A FULL TILE

**REFLECTED CEILING LEGEND**  
 -SEE REFLECTED CEILING PLAN FOR CEILING HEIGHTS.

	RECESSED 2'x4' FLUORESCENT LIGHT		EXIT SIGN
	RECESSED 2'x2' FLUORESCENT LIGHT		SPEAKER
	RECESSED PROCEDURE LIGHT FIXTURE		NURSE CALL
	RECESSED 1'x4' FLUORESCENT LIGHT		FIRE ALARM/HORN
	DOWN LIGHT		SMOKE DETECTOR
	SURFACE MOUNTED STRIP LIGHT		HEAT DETECTOR
	DOWN LIGHT (WALL WASHER)		EMERGENCY LIGHTING
	PENDANT LIGHT FIXTURE		SPRINKLER
	SURFACE MOUNTED FIXTURE		CEILING MOUNTED PROCEDURE/SURGICAL FIXTURE
	WALL SCONCE		WALL VALANCE
	TRACK LIGHTING		SURFACE MOUNTED 2'x4' FLUORESCENT LIGHT
	COVE LIGHT FIXTURE		SURFACE MOUNTED 2'x2' FLUORESCENT LIGHT
	PERIMETER SLOT LIGHT		SURFACE MOUNTED 1'x4' FLUORESCENT LIGHT
	WALL SURFACE MOUNTED FIXTURE		CEILING HEIGHT SYMBOL
	2'x2' ACOUSTIC TILE		2'x4' ACOUSTIC TILE
	GYPSUM WALLBOARD CEILING OR SOFFIT		2'x2' WOOD VENEER CEILING TILE
	METAL PANEL (MP-1A)		METAL PANEL (MP-1B)
	PERFORATED ACOUSTIC METAL CEILING		MECHANICAL SUPPLY DIFFUSER
	MECHANICAL RETURN REGISTER		MECHANICAL EXHAUST
	RADIANT HEAT PANEL		MECHANICAL LINEAR DIFFUSER/RETURN
	ACCESS PANEL		CURTAIN TRACK
	M TRACK		

FOR PERMIT ONLY  
NOT FOR CONSTRUCTION

PERMIT 09/24/04 PERMIT SET - NOT FOR CONSTRUCTION  
 Issue Log

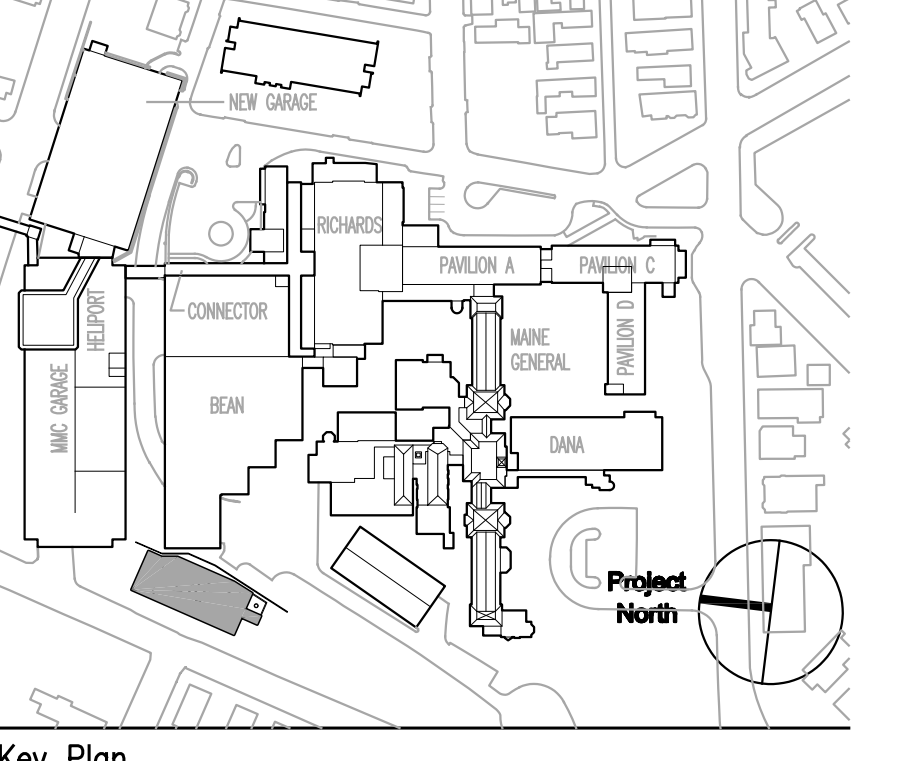


**TRO**  
 ARCHITECTURE  
 PLANNING  
 ENGINEERING  
 INTERIOR DESIGN

The Ritchie Organization  
 80 Bridge Street  
 Newton, MA 02459-1104  
 617-552-0400

Maine Medical Center  
 Central Utility Plant  
 Portland, Maine

Drawing Title  
**SECOND LEVEL REFLECTED CEILING PLAN**

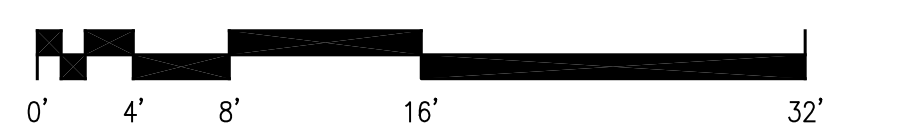

Commission No.	4677	Date Issued	
Scale	1/8" = 1'-0"	Sheet Number	
Drawn By			
Approved By			
Filename	4677A302.dwg		
Copyright	© 2004 The Ritchie Organization		

**A302**