



A5 BUILDING SECTION - LOOKING NORTH THROUGH EMERGENCY GENERATORS
SCALE: 1/8" = 1'-0"

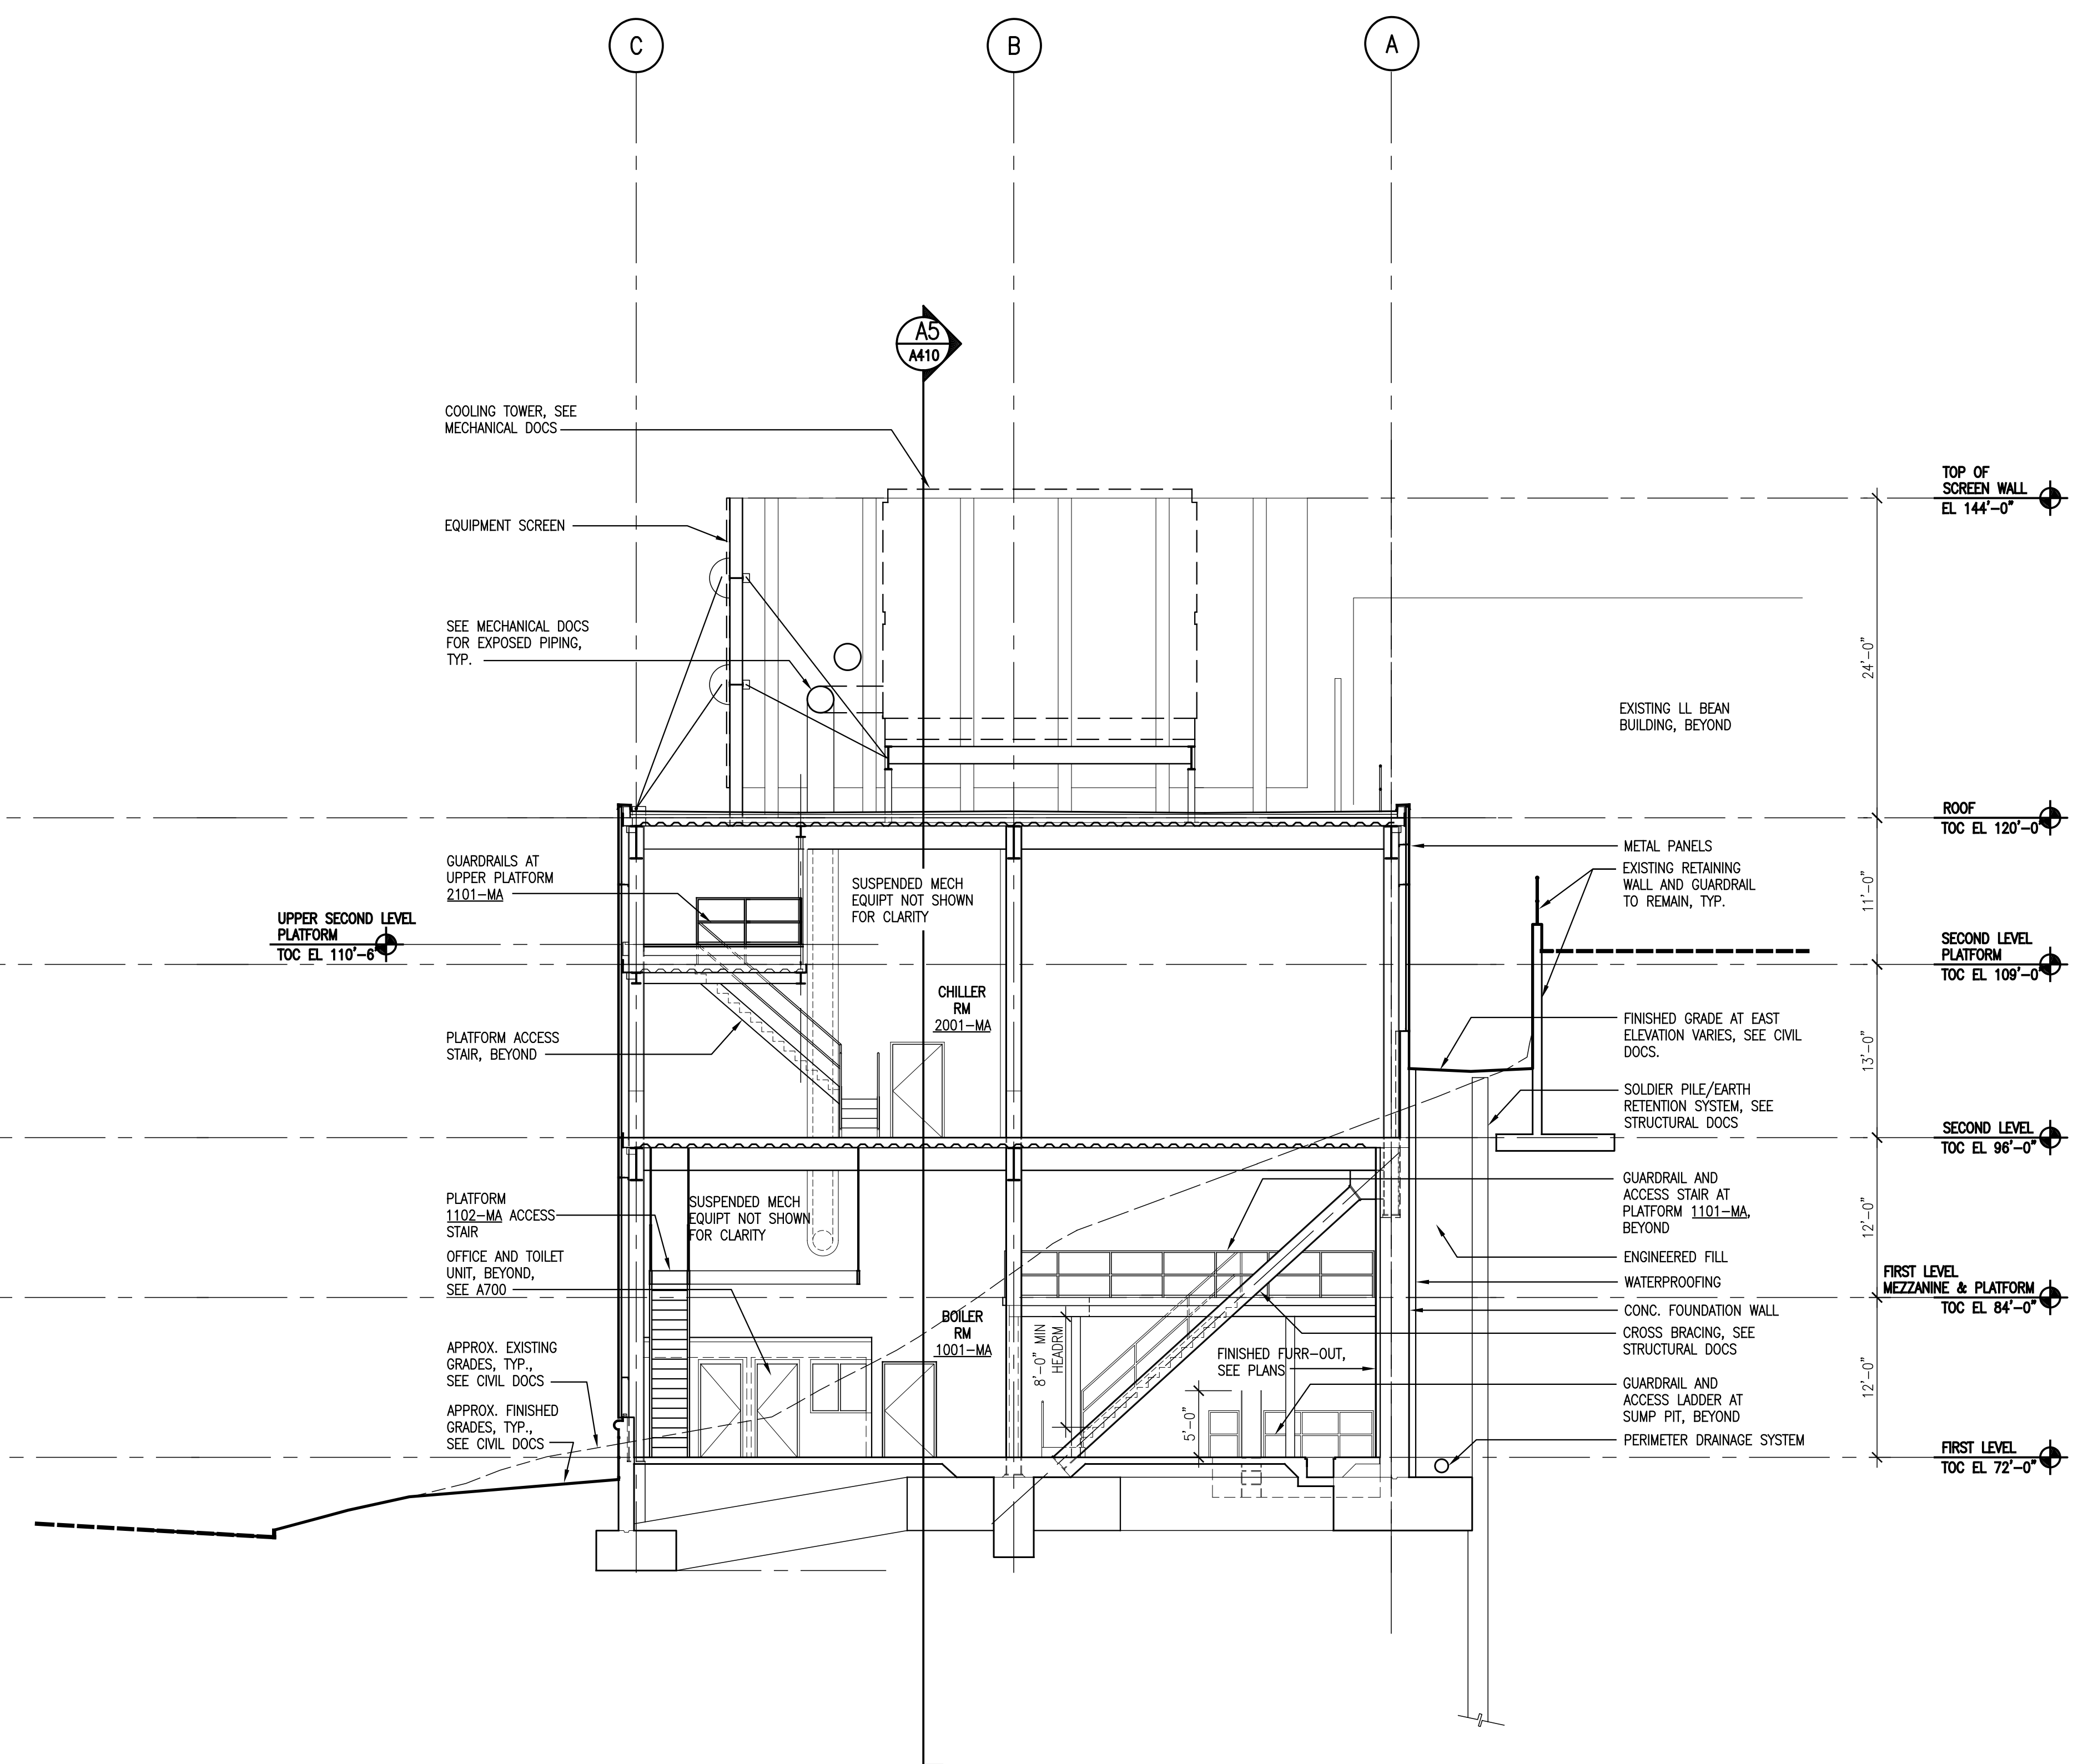

F5 BUILDING SECTION - LOOKING NORTH THROUGH BOILERS/CHILLERS
SCALE: 1/8" = 1'-0"

FOR PERMIT ONLY - NOT FOR CONSTRUCTION

PERMIT 08/24/04 PERMIT SET - NOT FOR CONSTRUCTION
Issue Log

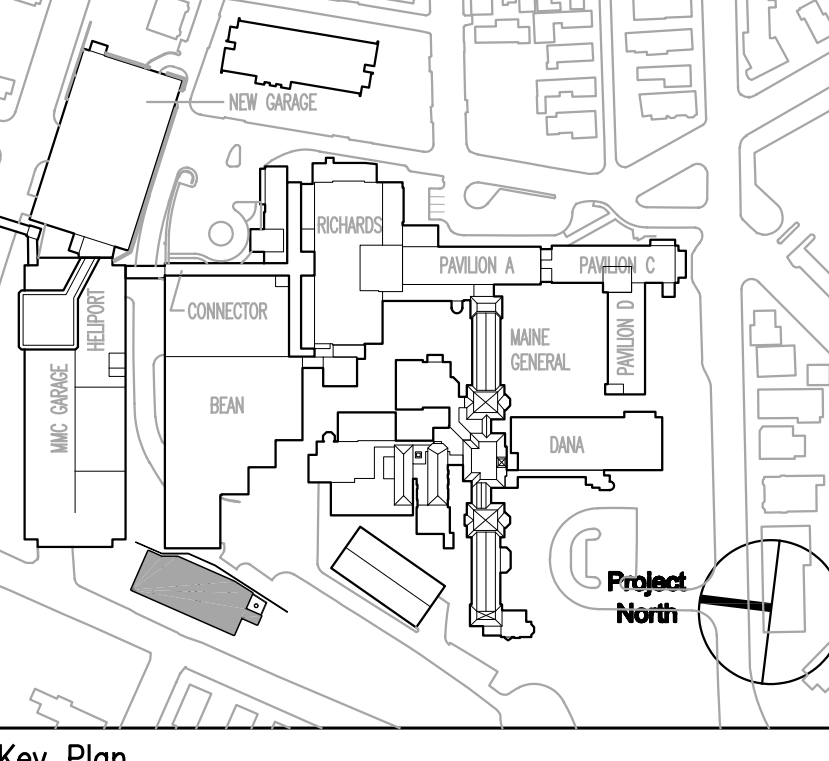


Key Plan

TRO
ARCHITECTURE
PLANNING
ENGINEERING
INTERIOR DESIGN
The Ritchie Organization
80 Bridge Street
Newton, MA 02459-1154
617-552-0400

Maine Medical Center
Central Utility Plant
Portland, Maine

Drawing Title
BUILDING SECTIONS 2

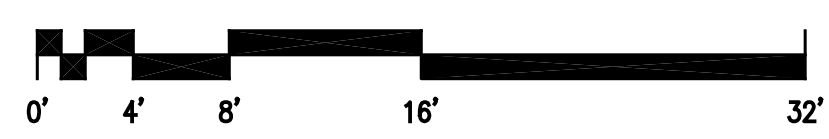

Commission No.	4677	Date Issued	
Scale	1/8" = 1'-0"	Sheet Number	
Drawn By		Approved By	
Filename	4677M11.dwg		
Copyright	© 2004 The Ritchie Organization		

A411