


FOR PERMIT ONLY
NOT FOR CONSTRUCTION

PERMIT 08/24/04 PERMIT SET - NOT FOR CONSTRUCTION
Issue Log

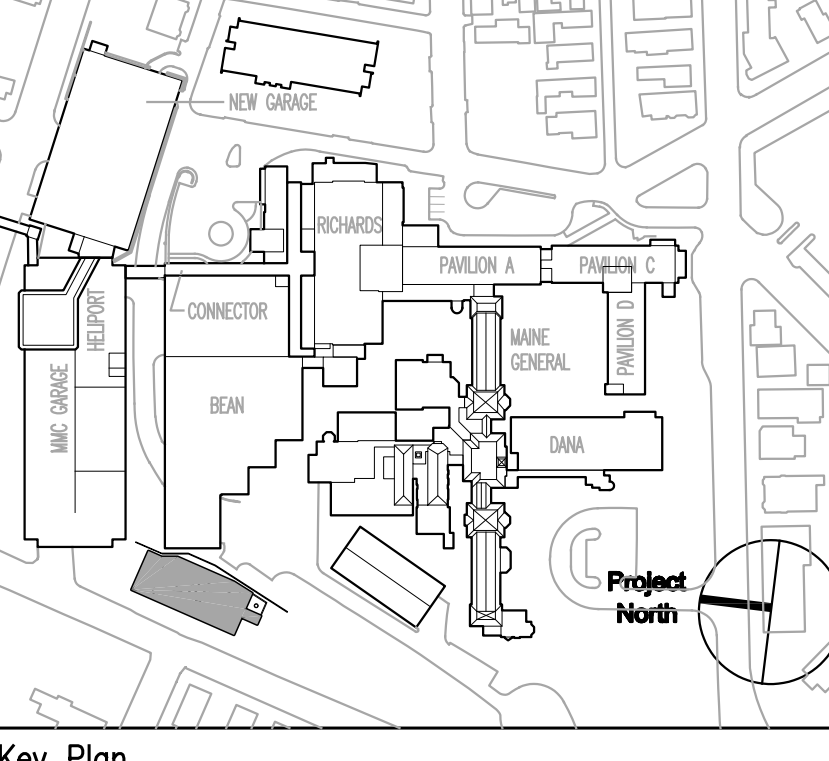

TRO
ARCHITECTURE
PLANNING
ENGINEERING
INTERIOR DESIGN
The Ritchie Organization
80 Bridge Street
Newton, MA 02459-1154
617-552-0400

Maine Medical Center
Central Utility Plant
Portland, Maine

Drawing Title
**WALL SECTIONS
NO. 2**

Commission No.	4677	Date Issued	
Scale	3/8" = 1'-0"	Sheet Number	A501
Drawn By		Approved By	
Checked By		Checked By	
File Name	4677A501.dwg		
Copyright	© 2004 The Ritchie Organization		