



2 LEVEL 2 LIGHTING PLAN - GENERATOR PLANT
1/8"=1'-0"

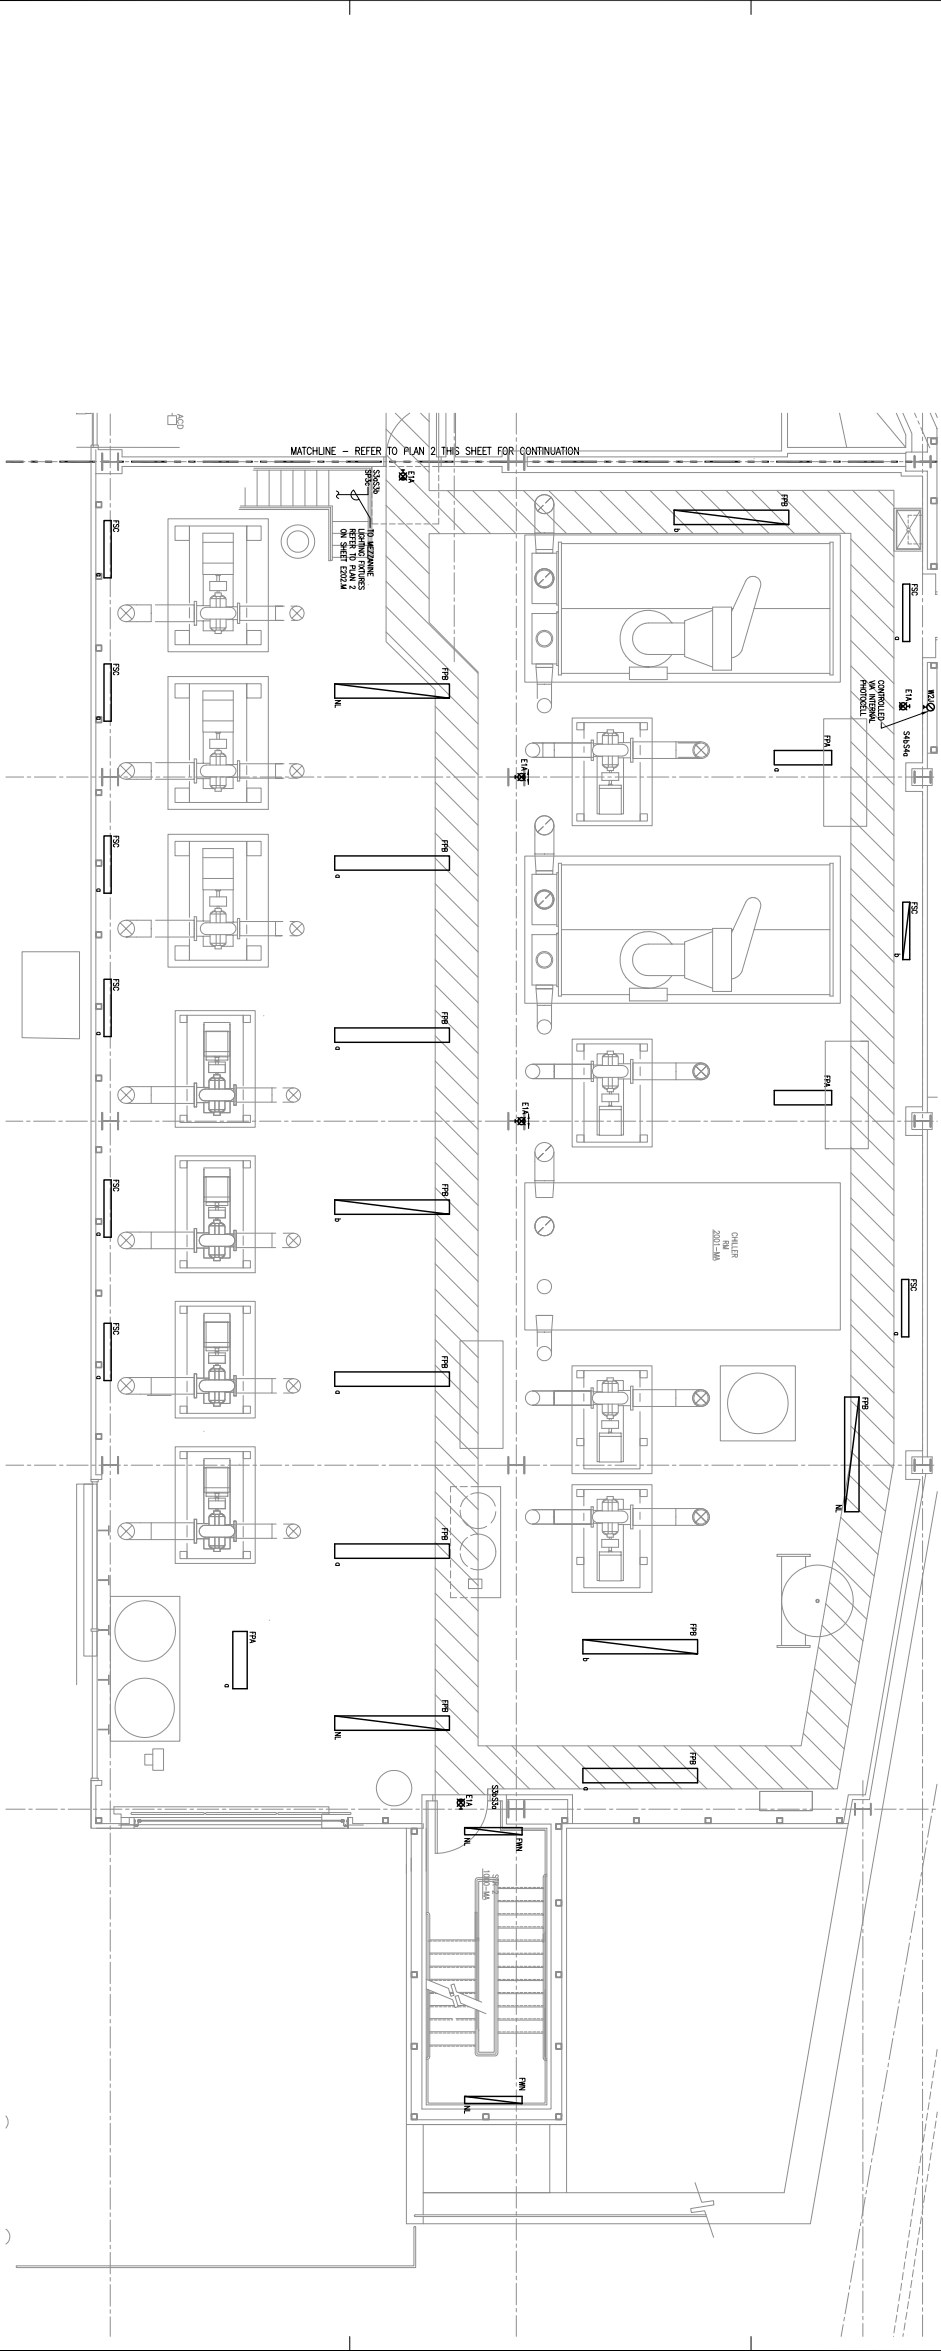

1 LEVEL 2 LIGHTING PLAN - CHILLER PLANT
1/8"=1'-0"

General Notes:

SCALE SHEET
FOR PERMIT ONLY
NOT FOR CONSTRUCTION
DATE: 09/24/14
PROJECT SET - NET FOR CONSTRUCTION
SCALE LOG

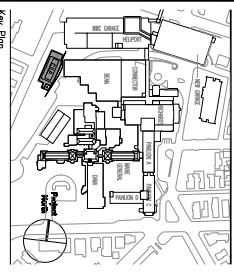

PRO
A ARCHITECTURE
PLANNING
ENGINEERING
1477 BROAD ST., SUITE 200
PORTLAND, ME 04103
PHONE: 603.733.4100
WWW.PROARCHITECTURE.COM

Maine Medical Center
Central Utility Plant
Portland, Maine

PROJECT NO.
**ELECTRICAL - CENTRAL
UTILITY PLANT LEVEL 2
LIGHTING PLANS**

Commission No. 4277
Scale Number
DATE: 09/24/14
PROJECT NO. 42757-202-18
DRAWING NO. 14
E202