
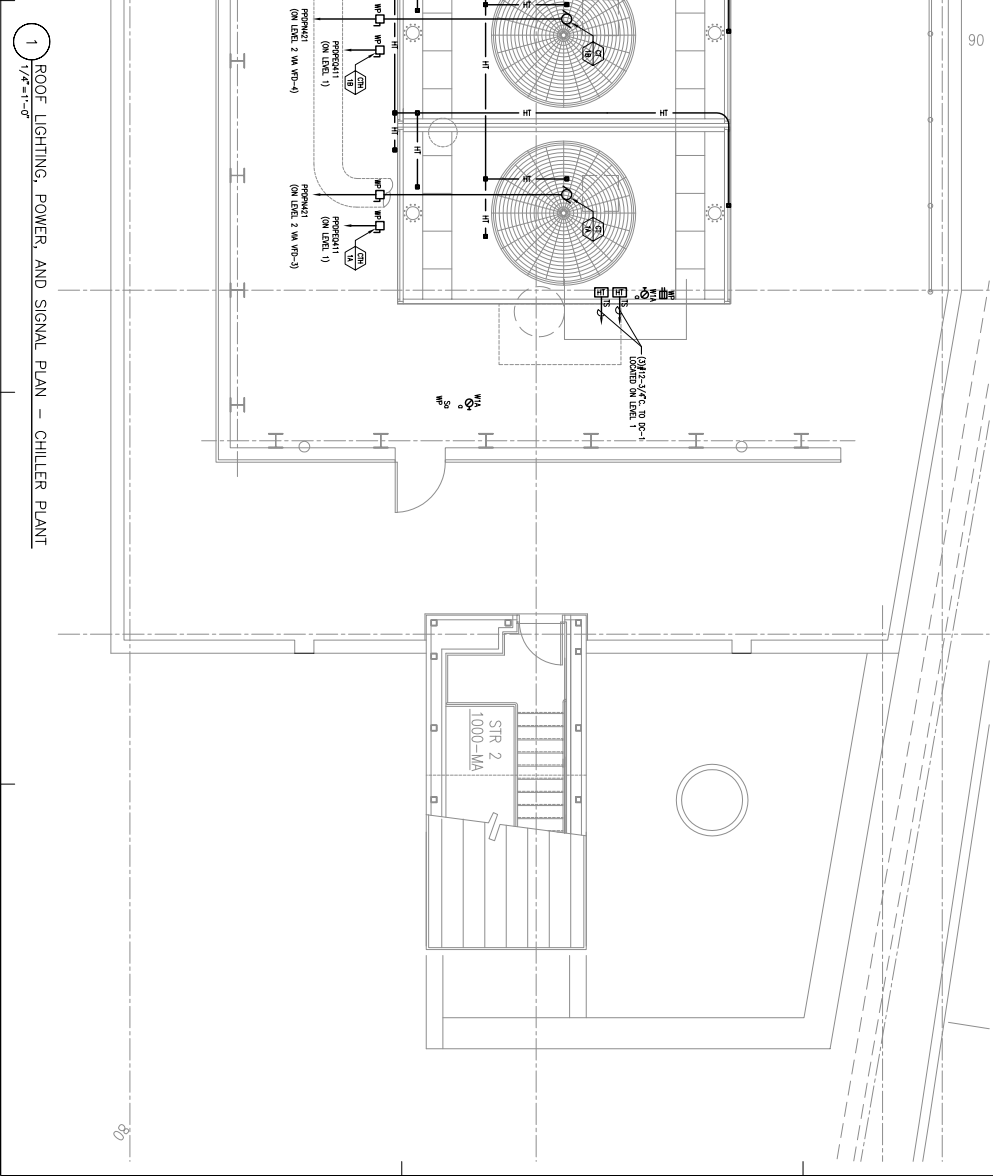
 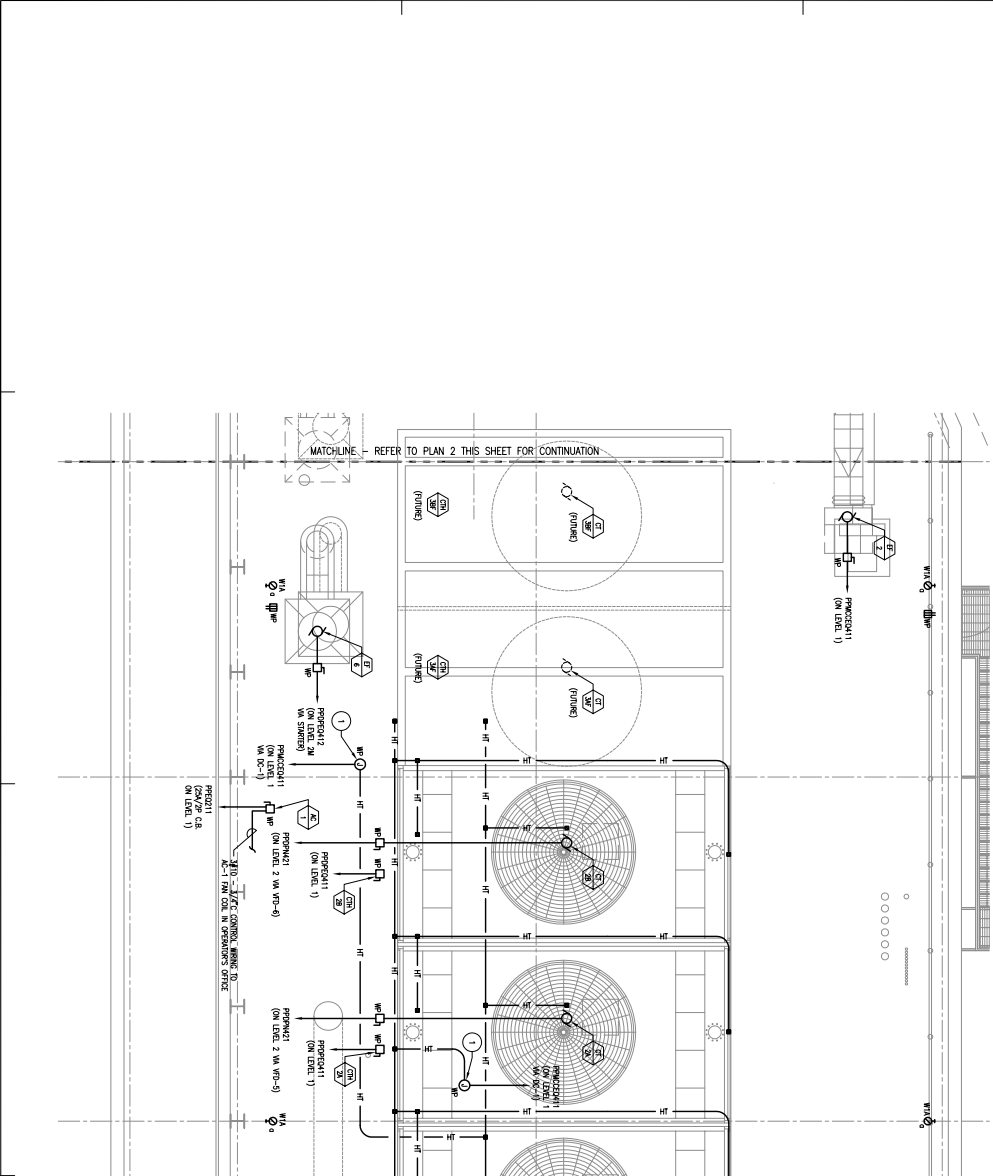



General Notes:
 UNLESS NOTED OTHERWISE, REFER TO MAINE DATA SCHEDULE ON SHEET E100 FOR ELEVATION, APPROXIMATE PROJECTION AND ASSUMED FINISHES FOR ALL CONSTRUCTION.
DRAWING NOTES:
 1. MATCHLINE - REFER TO PLAN 1 THIS SHEET FOR CONTINUATION
 2. MATCHLINE - REFER TO PLAN 2 THIS SHEET FOR CONTINUATION
 3. ALL TRUNK CABLES FOR CHILLER AND GENERATOR ARE TO BE INSTALLED IN RIGID CONDUIT. ALL RIGID CONDUIT SHALL BE INSTALLED IN ACCORDANCE WITH THE NATIONAL ELECTRICAL CODE (NEC) AND ALL OTHER APPLICABLE CODES AND REGULATIONS. ALL TRUNK CABLES SHALL BE INSTALLED IN ACCORDANCE WITH THE NATIONAL ELECTRICAL CODE (NEC) AND ALL OTHER APPLICABLE CODES AND REGULATIONS.
 4. ALL TRUNK CABLES SHALL BE INSTALLED IN ACCORDANCE WITH THE NATIONAL ELECTRICAL CODE (NEC) AND ALL OTHER APPLICABLE CODES AND REGULATIONS.

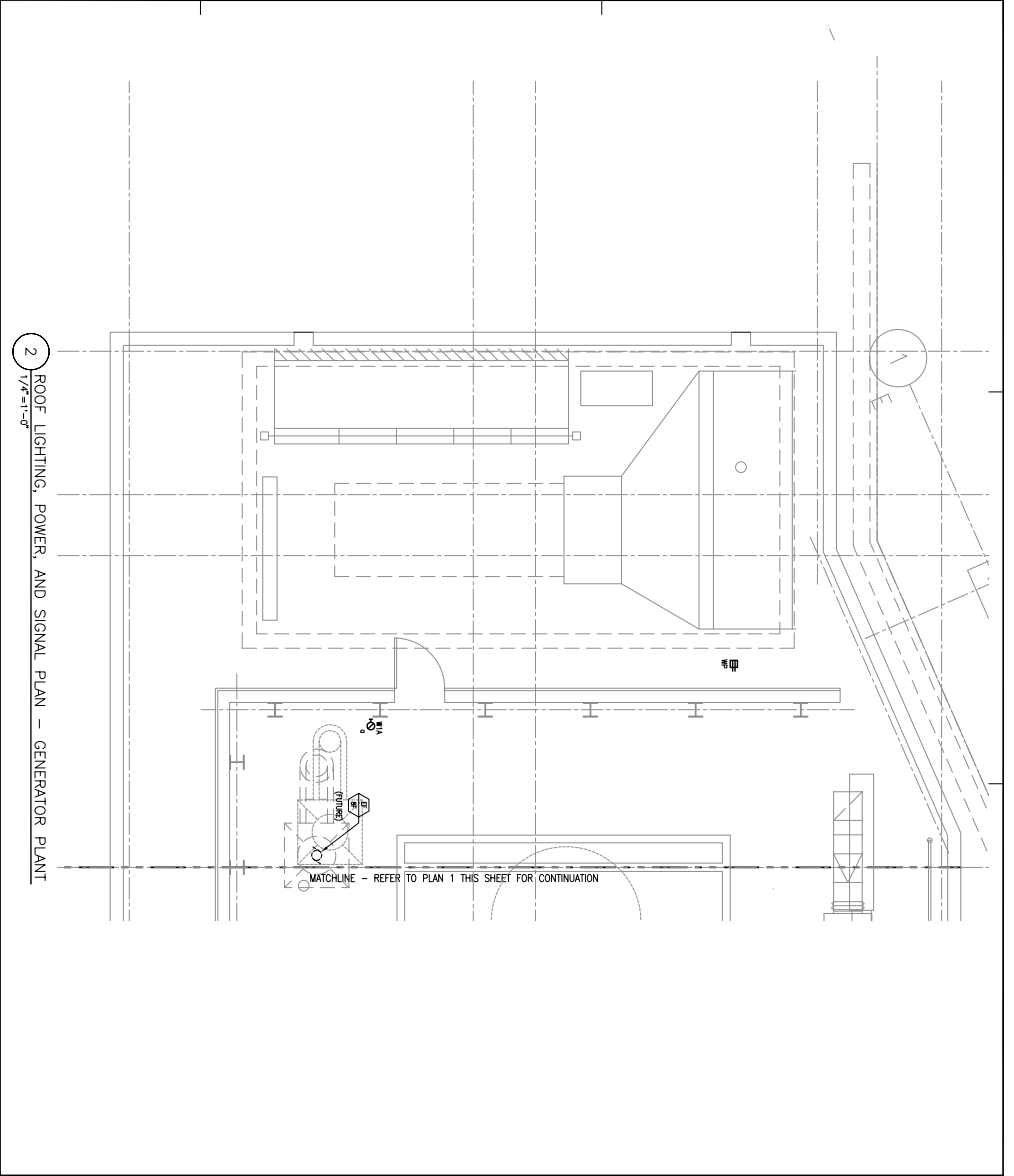

PRO
 A ARCHITECTURE
 PLANNING
 SHOWROOM
 1477 BROAD ST. PORTLAND, ME 04102
 TEL: 603-761-1100
 WWW.PROARCHITECTURE.COM

MAINE Medical Center
 Central Utility Plant
 Portland, Maine

**ELECTRICAL - CENTRAL
 UTILITY PLANT ROOF LIGHTING,
 POWER, AND SIGNAL PLANS**

Project No. 4377 - Data Center
 Scale: 1/8" = 1'-0"
 Date: 08/24/24
 Drawing No. E303
 Project: 08/24/24

ISSUE DATE: 08/24/24
FOR PERMIT ONLY - NOT FOR CONSTRUCTION

FORM: 08/24/24
 FINGER SET - NOT FOR CONSTRUCTION
 Scale: 1/8" = 1'-0"

Key: 1 - 1000-MA