







 
General Notes:

GENERAL NOTES:

1. ALL WORK SHALL BE DONE IN ACCORDANCE WITH THE LATEST EDITION OF THE NATIONAL ELECTRICAL CODE (NEC) AND ALL APPLICABLE LOCAL, STATE AND FEDERAL REGULATIONS.

DRAWING NOTES:

1. ALL WORK SHALL BE DONE IN ACCORDANCE WITH THE LATEST EDITION OF THE NATIONAL ELECTRICAL CODE (NEC) AND ALL APPLICABLE LOCAL, STATE AND FEDERAL REGULATIONS.

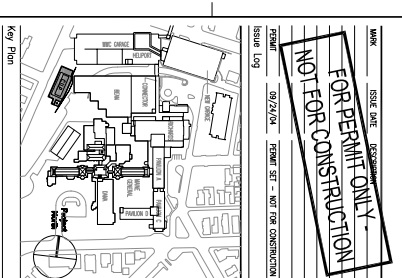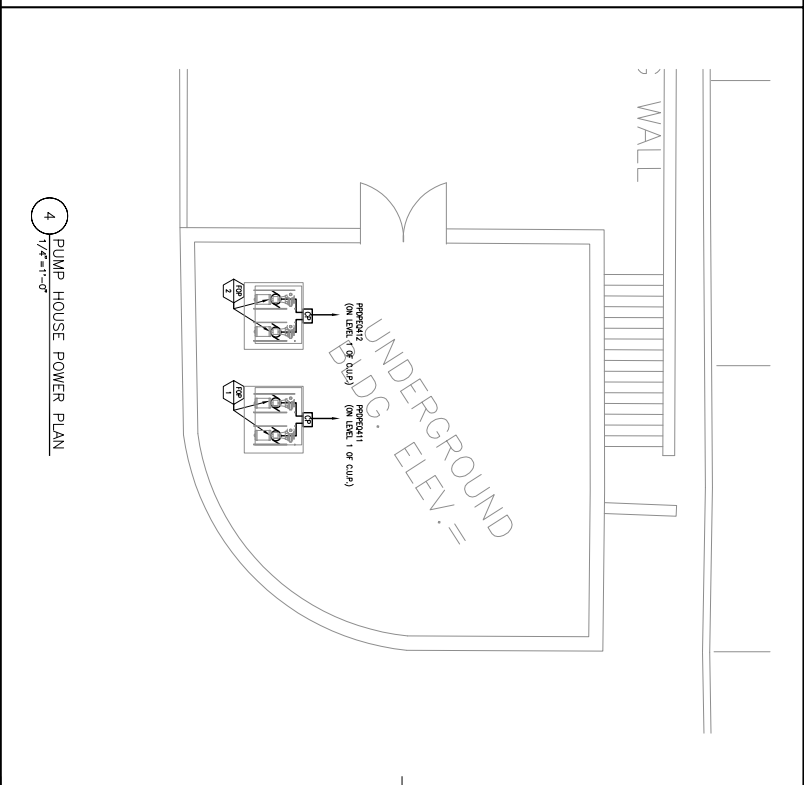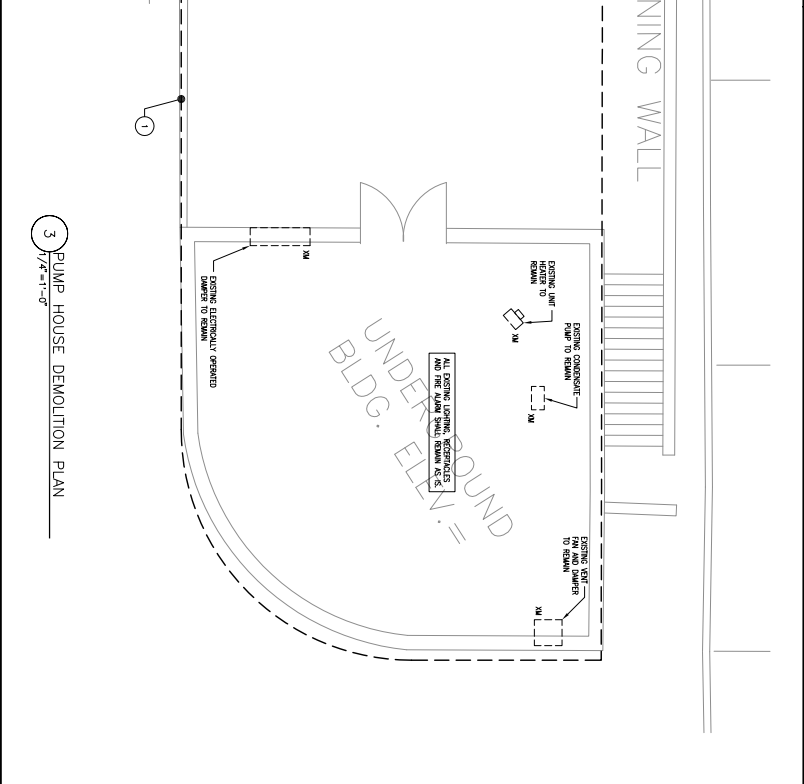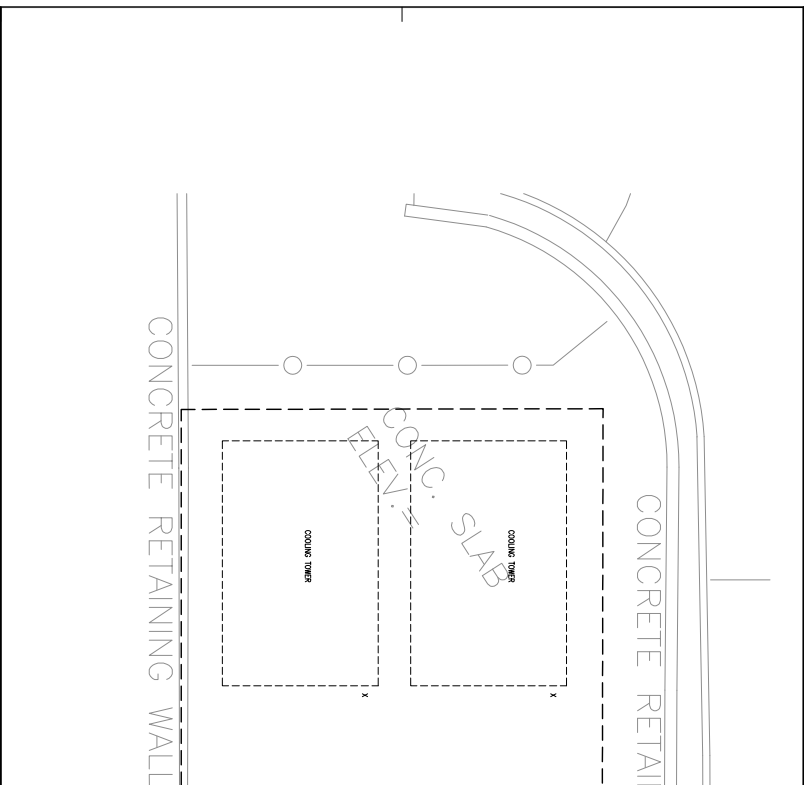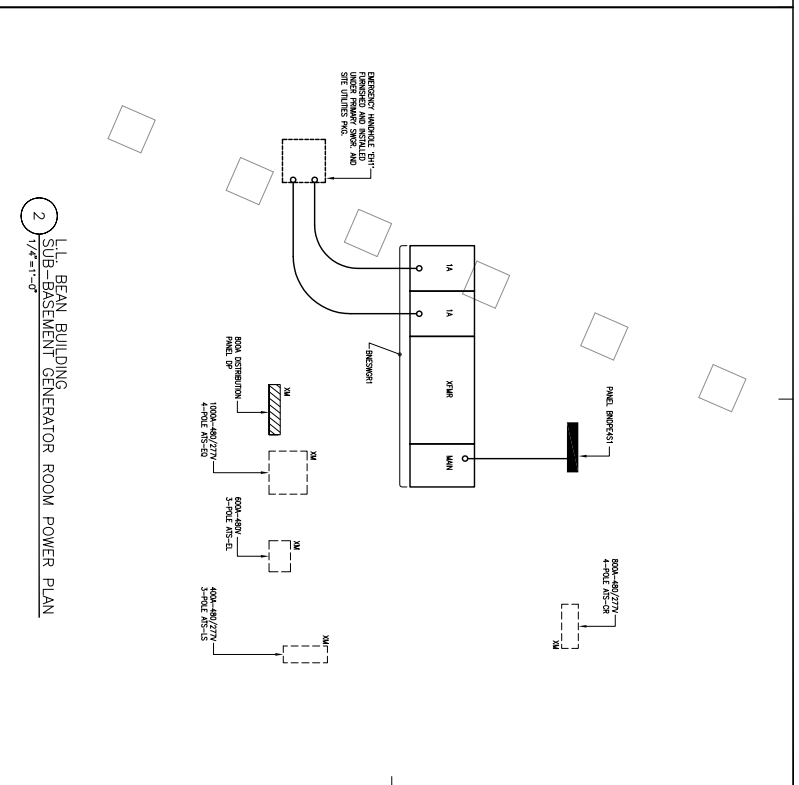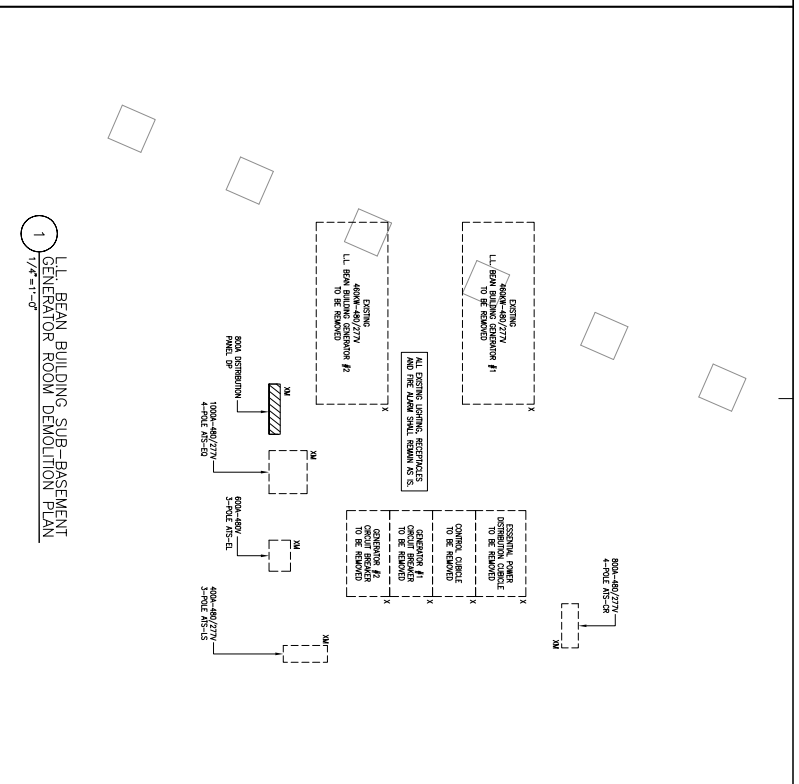

TRO
A ARCHITECTURE
PLANNING
SHOEWALKING
LITERATURE
The Maine Medical Center
1000 Main Street
Portland, ME 04103
Tel: 603-633-1234

Maine Medical Center
Central Utility Plant
Portland, Maine

ELECTRICAL PART PLANS SHEET 1

Commission No. 4877
Scale: 1/8" = 1'-0"
Sheet Number: E500