


MEDIUM VOLTAGE FEEDER SCHEDULE				
NO.	CONDUCTORS	GROUND	COUNT	NOTES
M10	3 - 1000 (24K 5 M)	1 - 2/0	5"	
M11	4 - 750 (24K 5 M)	1 - #1	5"	
M12	3 - 4/0 (3 M)	1 - #1	5"	
M13	3 - 4/0 (3 M)	1 - #1	5"	

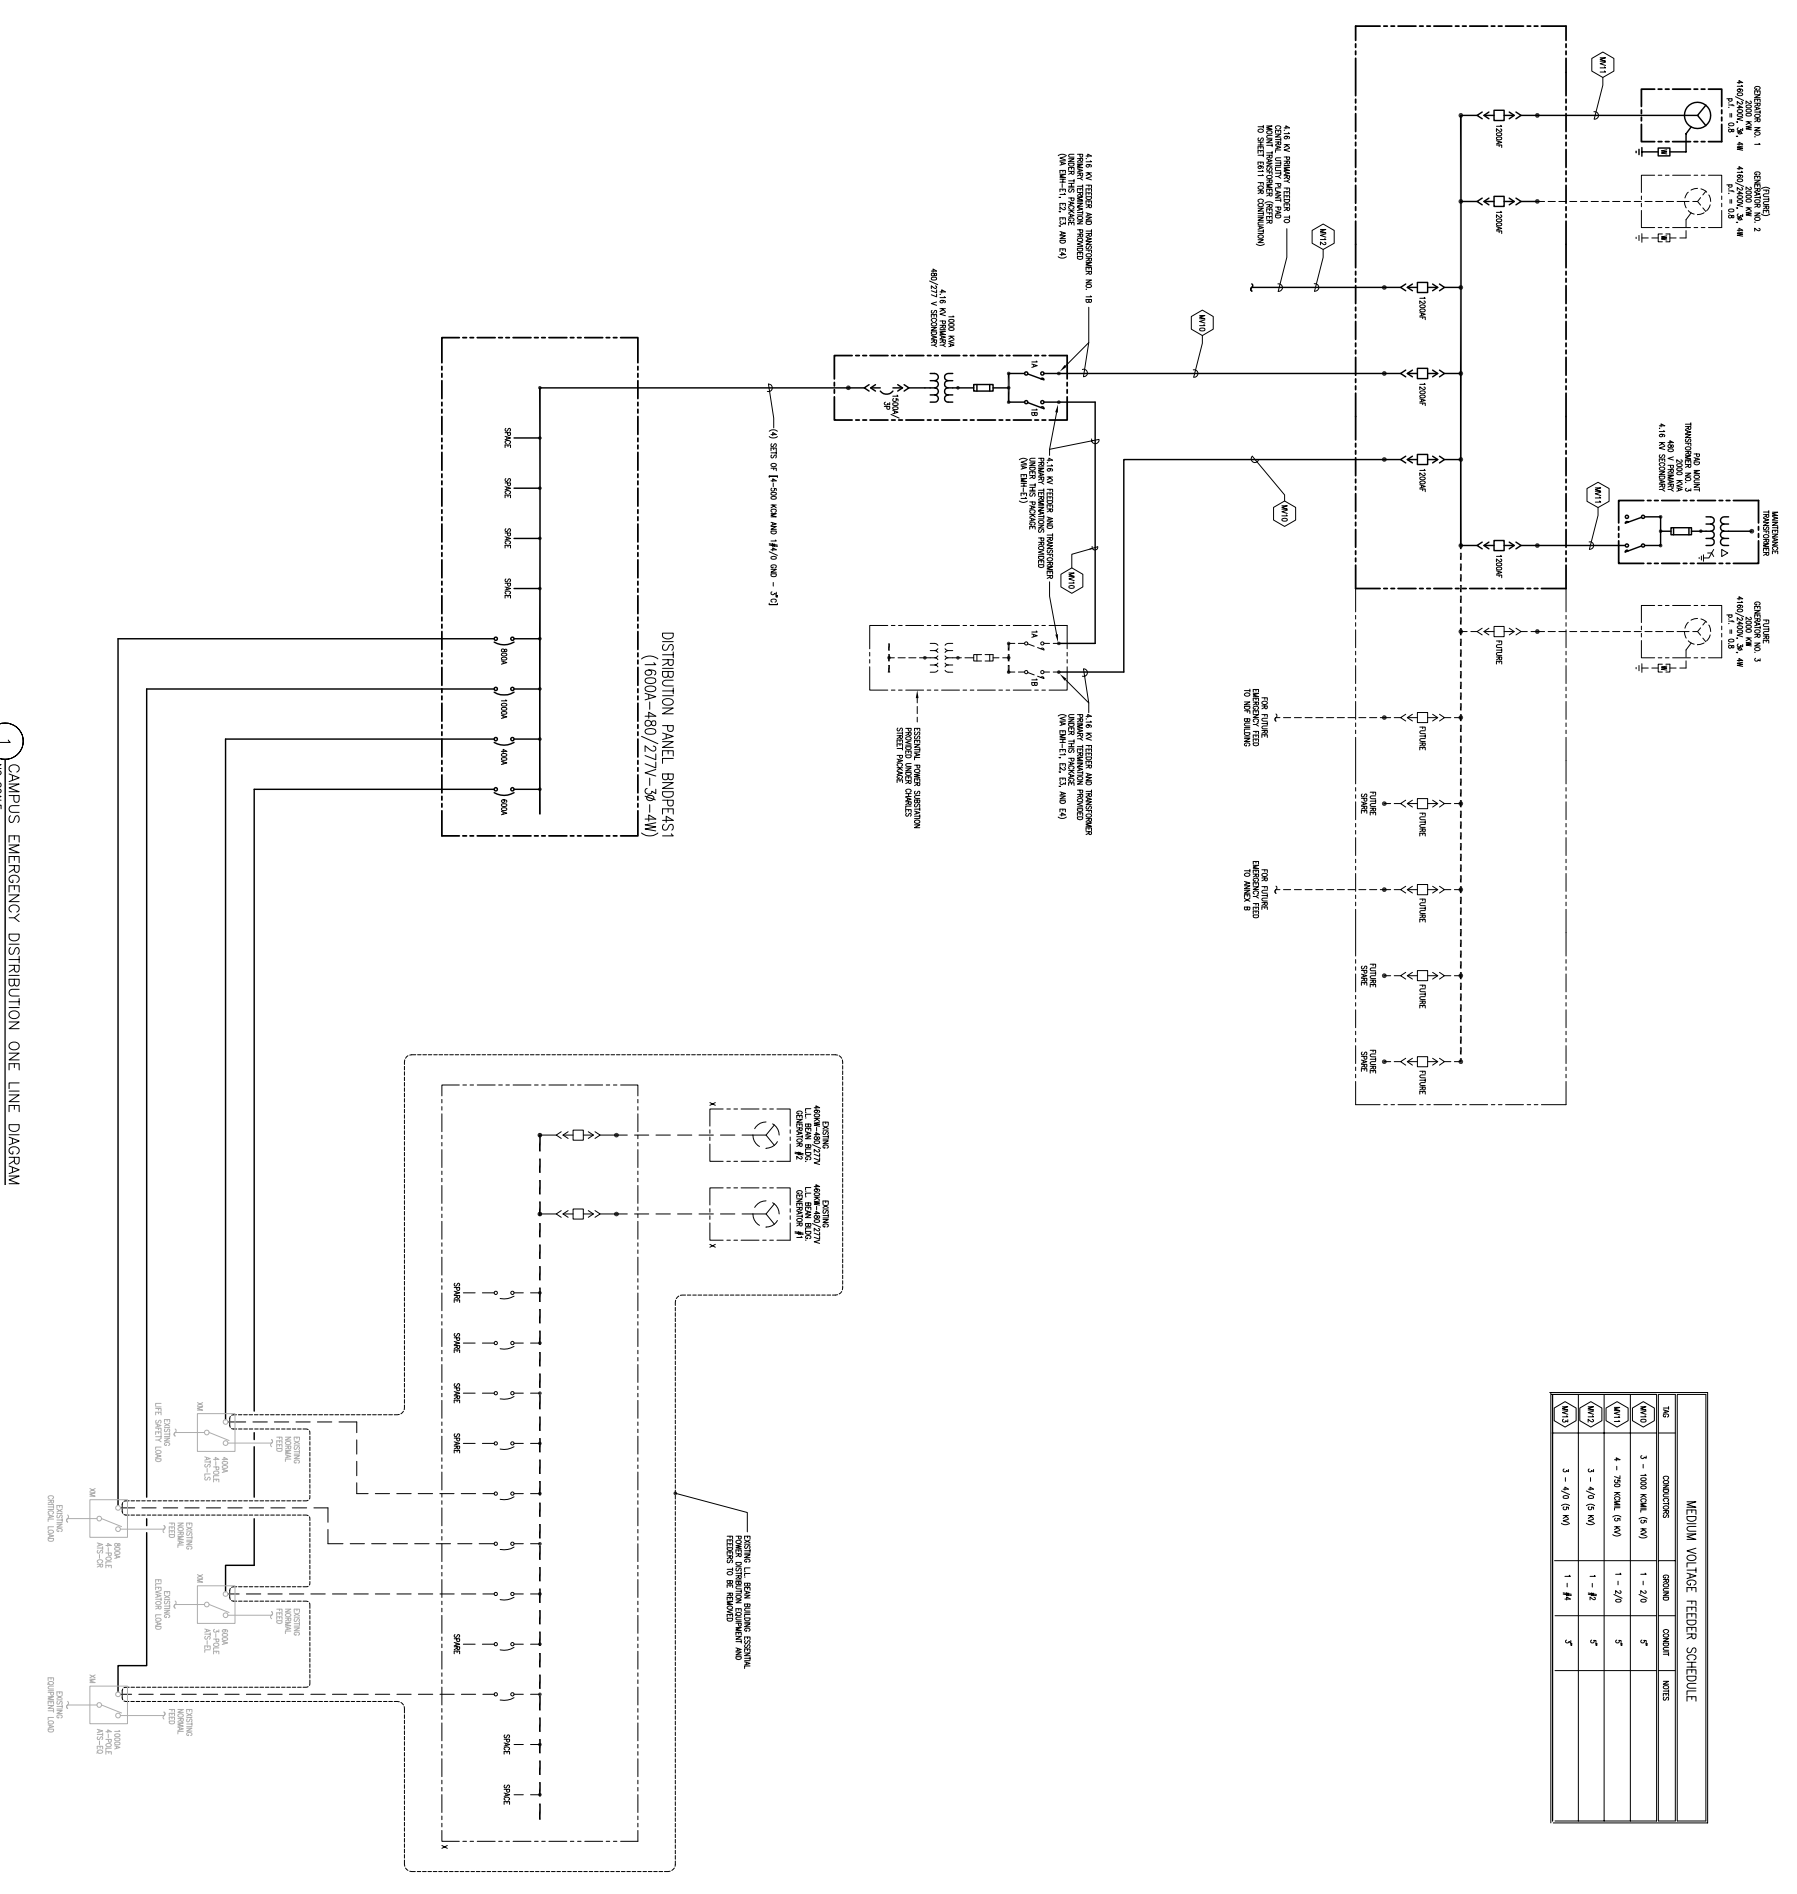

1 CAMPUS EMERGENCY DISTRIBUTION ONE LINE DIAGRAM
NO SCALE

MADE TO ORDER
FOR PERMIT ONLY
NOT FOR CONSTRUCTION

DATE: 09/24/14
PROJECT: FEEDER SET - NET FOR CONSTRUCTION

SCALE: AS SHOWN

PROJECT NO: 14-0000000000

DATE: 09/24/14

PROJECT: FEEDER SET - NET FOR CONSTRUCTION

SCALE: AS SHOWN

PRO
A ARCHITECTURE
PLANNING
ENGINEERING
CONSTRUCTION
MANAGEMENT
CORPORATION
1177 South Congress
Suite 100
Miami, FL 33130
Tel: 305.375.1100
Fax: 305.375.1101

MAINE MEDICAL CENTER
Central Utility Plant
Portland, Maine

PROJECT NO: 14-0000000000
DATE: 09/24/14
PROJECT: FEEDER SET - NET FOR CONSTRUCTION
SCALE: AS SHOWN

E610

0' 10' 20' 30' 40' 50' 60'