

General Notes:

1. ALL NOTES REFER TO PERMITS AND SPECIFICATIONS.
2. ALL NOTES REFER TO PERMITS AND SPECIFICATIONS.
3. ALL NOTES REFER TO PERMITS AND SPECIFICATIONS.
4. ALL NOTES REFER TO PERMITS AND SPECIFICATIONS.

PRO
 A ARCHITECTURE
 SHOWNING
 1477
 The Maine State Capitol
 Portland, ME 04103

MAINE MEDICAL CENTER
 Central Utility Plant
 Portland, Maine


ELECTRICAL
 CENTRAL UTILITY PLANT
 ONE LINE DIAGRAM

Commission No. 4277
 Scale: 1/8" = 1'-0"
 Drawing No. E611

DATE: 08/24/24
 DRAWN BY: [Name]
 CHECKED BY: [Name]

FOR PERMIT ONLY
 NOT FOR CONSTRUCTION

Scale: 1/8" = 1'-0"

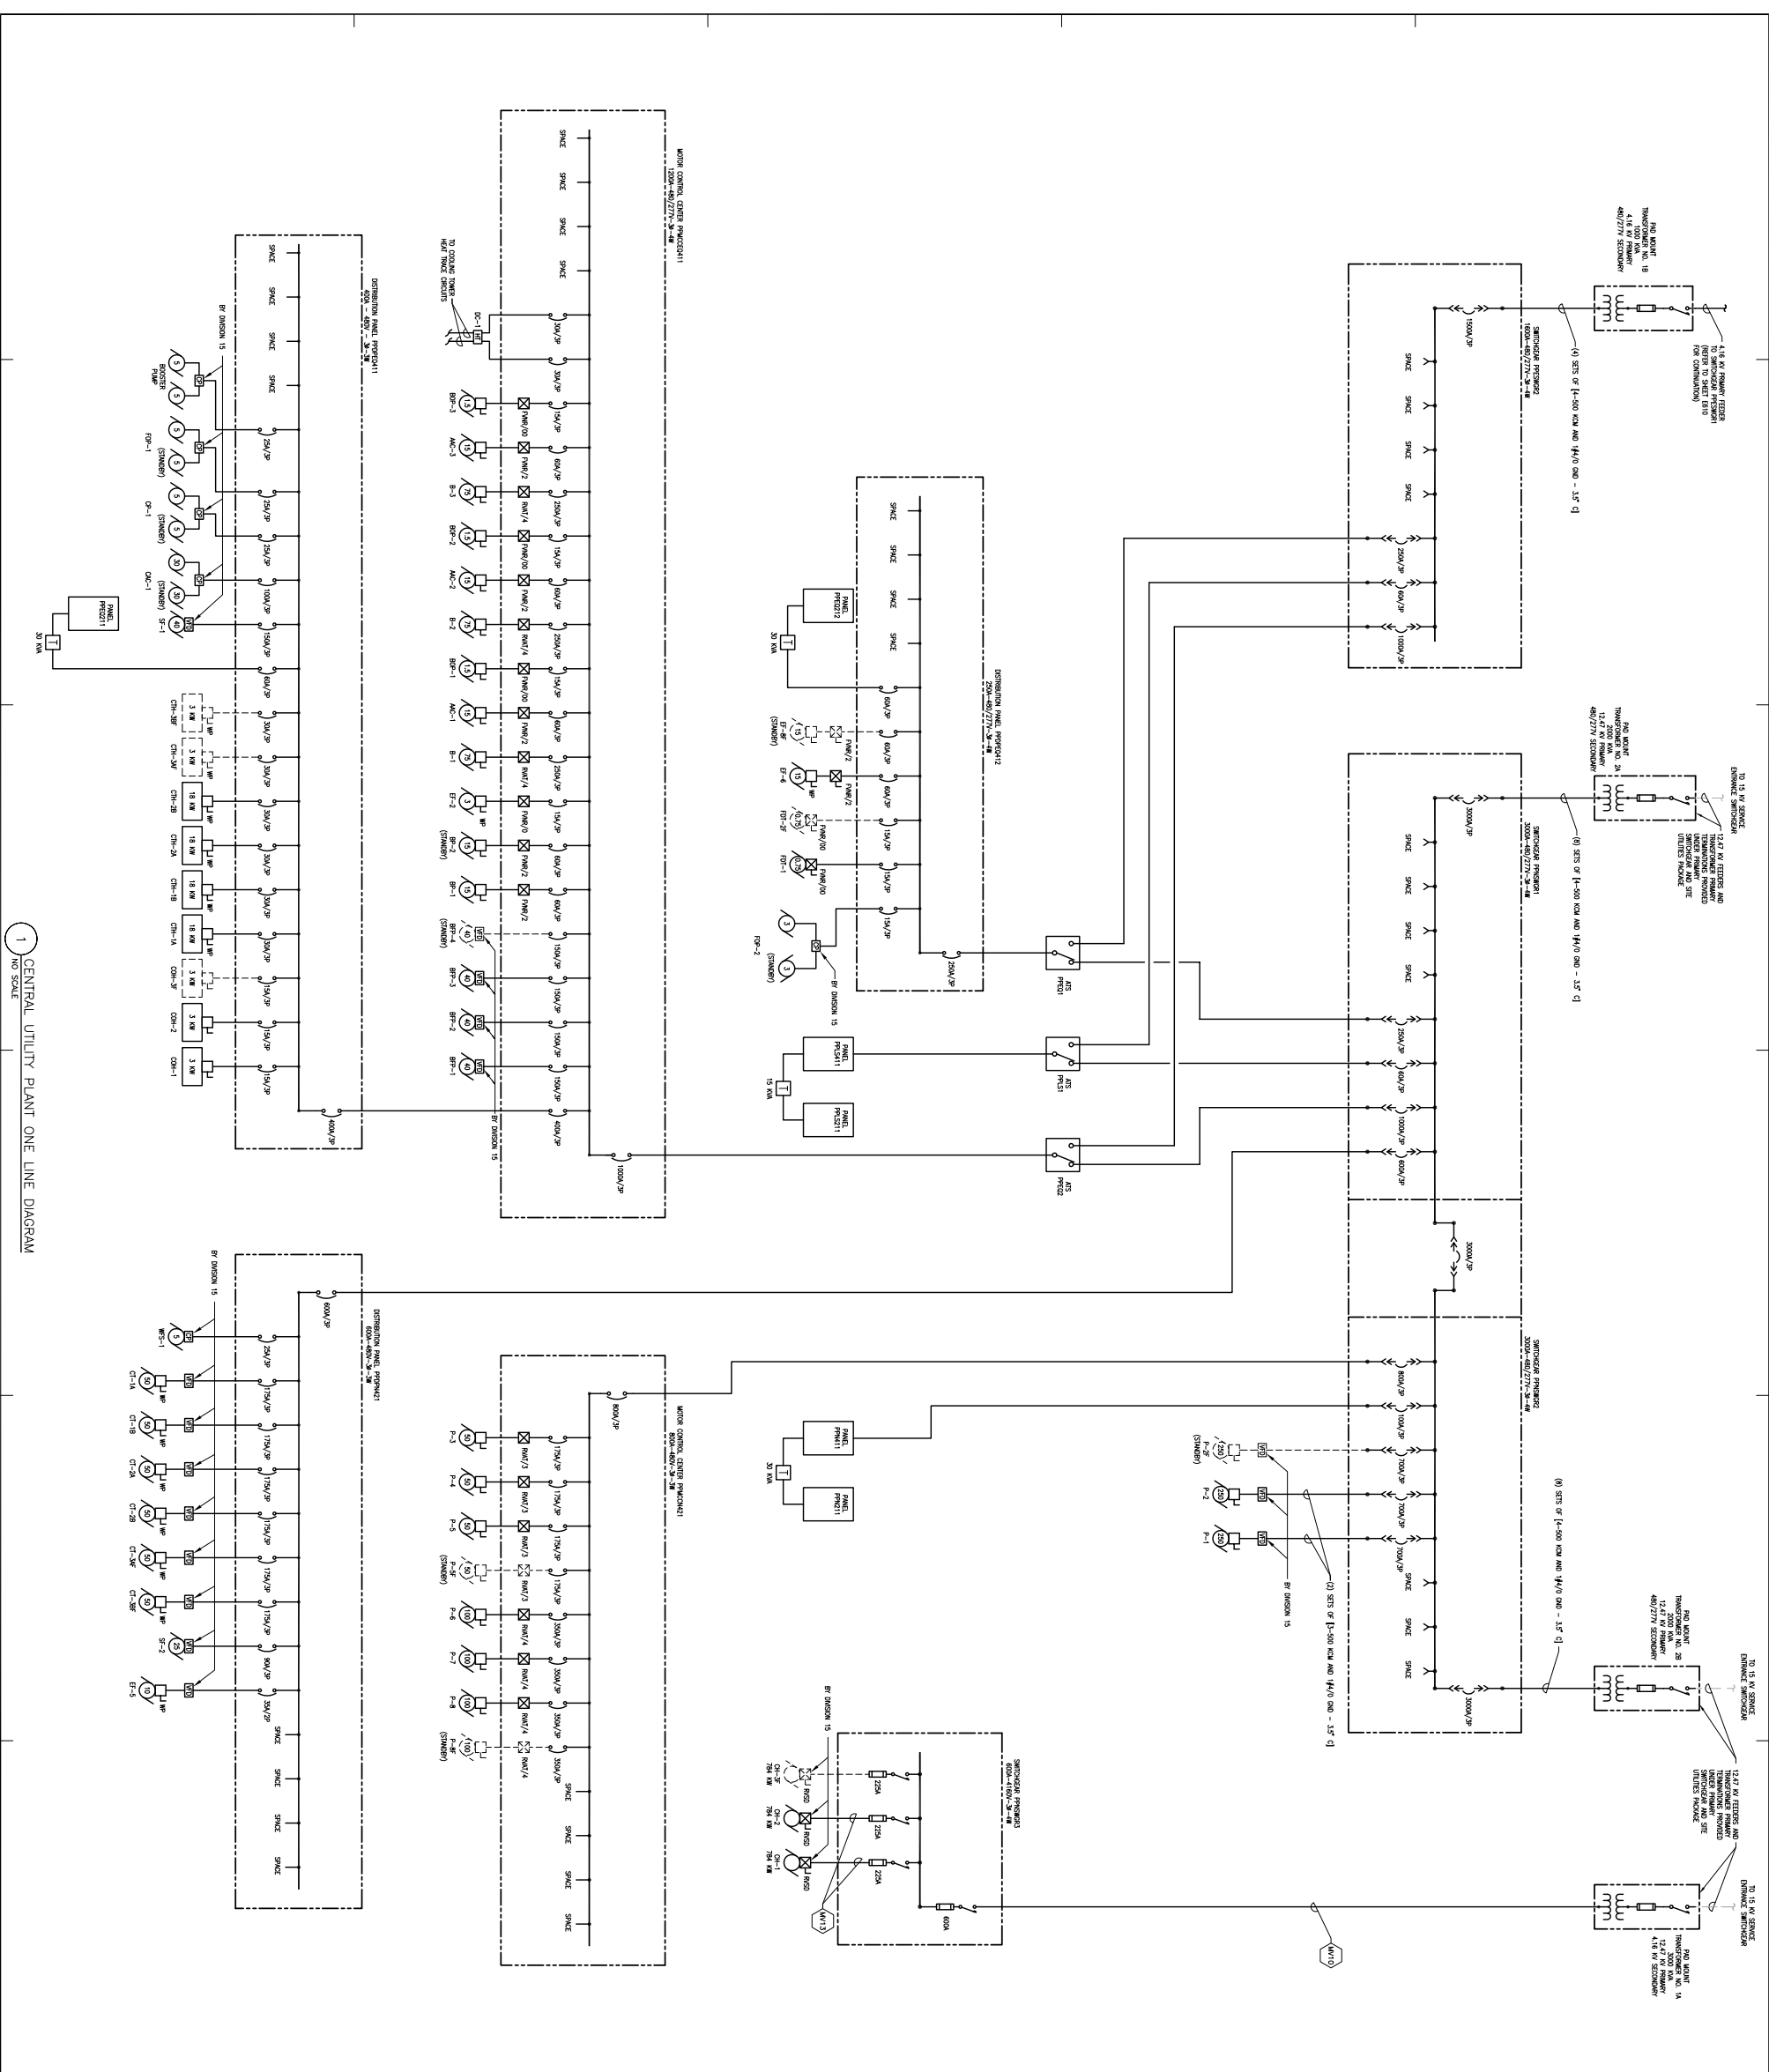

1 CENTRAL UTILITY PLANT ONE LINE DIAGRAM
 NO SCALE