


**2**  
FIRE ALARM SYSTEM RISER

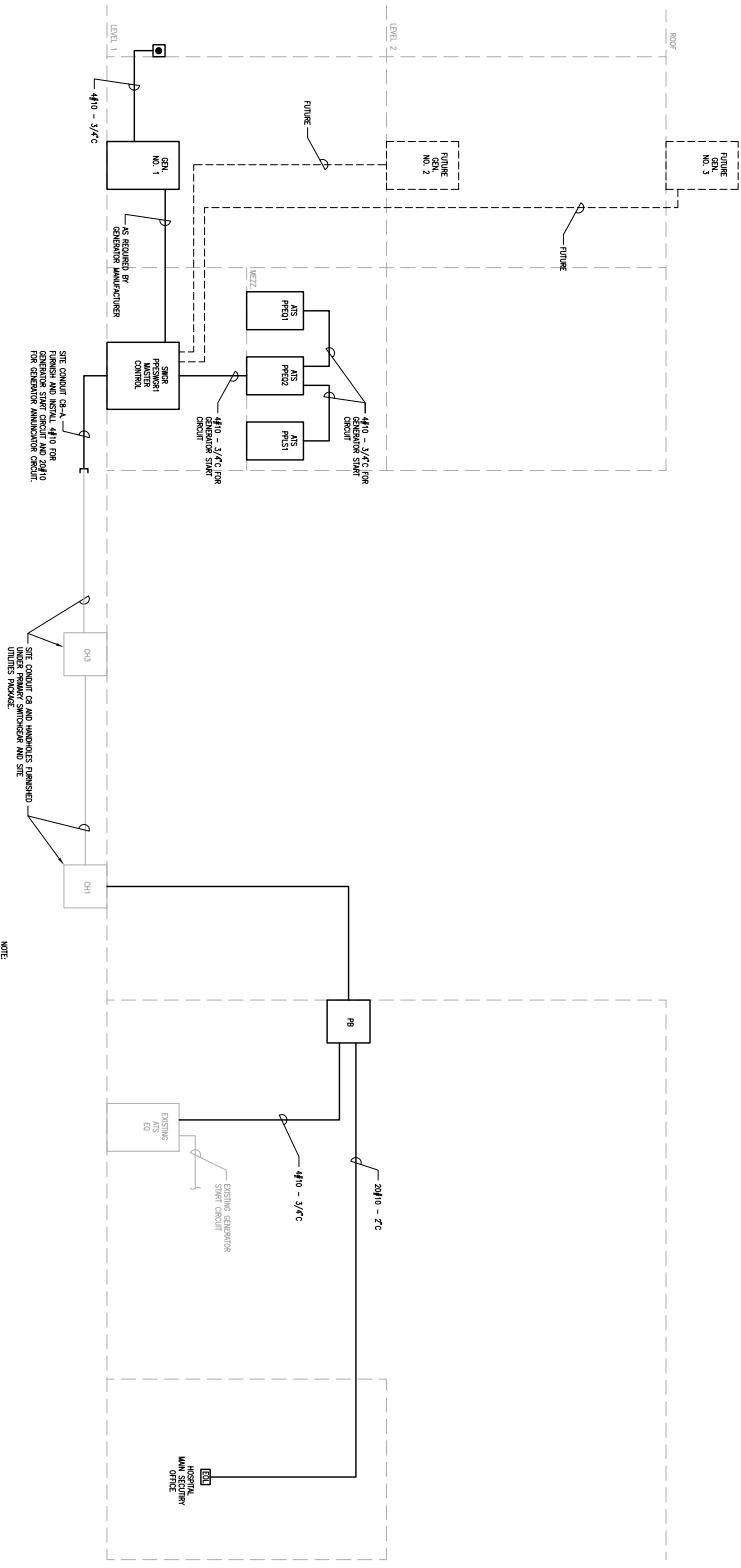

**1**  
GENERATOR START CIRCUIT WIRING DIAGRAM

ISSUE DATE: 09/24/14  
**FOR PERMIT ONLY**  
**NOT FOR CONSTRUCTION**

Scale Log: 9/24/14 FERRIS ST - NET FIRE CONSTRUCTION

PROJECT NO: 46172-S02B  
PROJECT NAME: The Maine Center  
1000 Mt. Vernon St  
Portland, ME 04102

**TRO**  
A ELECTRICAL ENGINEERING & PLANNING FIRM  
1477 SW 6th Street  
Portland, ME 04102  
Telephone: 781-381-4110  
Fax: 781-381-4111

Site: 0' 0' 0'

**Maine Medical Center**  
Central Utility Plant  
Portland, Maine

**ELECTRICAL**  
**LOW VOLTAGE**  
**RISER DIAGRAMS**

Commission No.: 4677 Data Number: 4677  
Drawn By: SRS  
Checked By: SRS  
Reviewed By: DRT/SRB  
Date: 09/24/14  
Project: 02010 - The Maine Center

E612