


LEVEL 1 PLAN

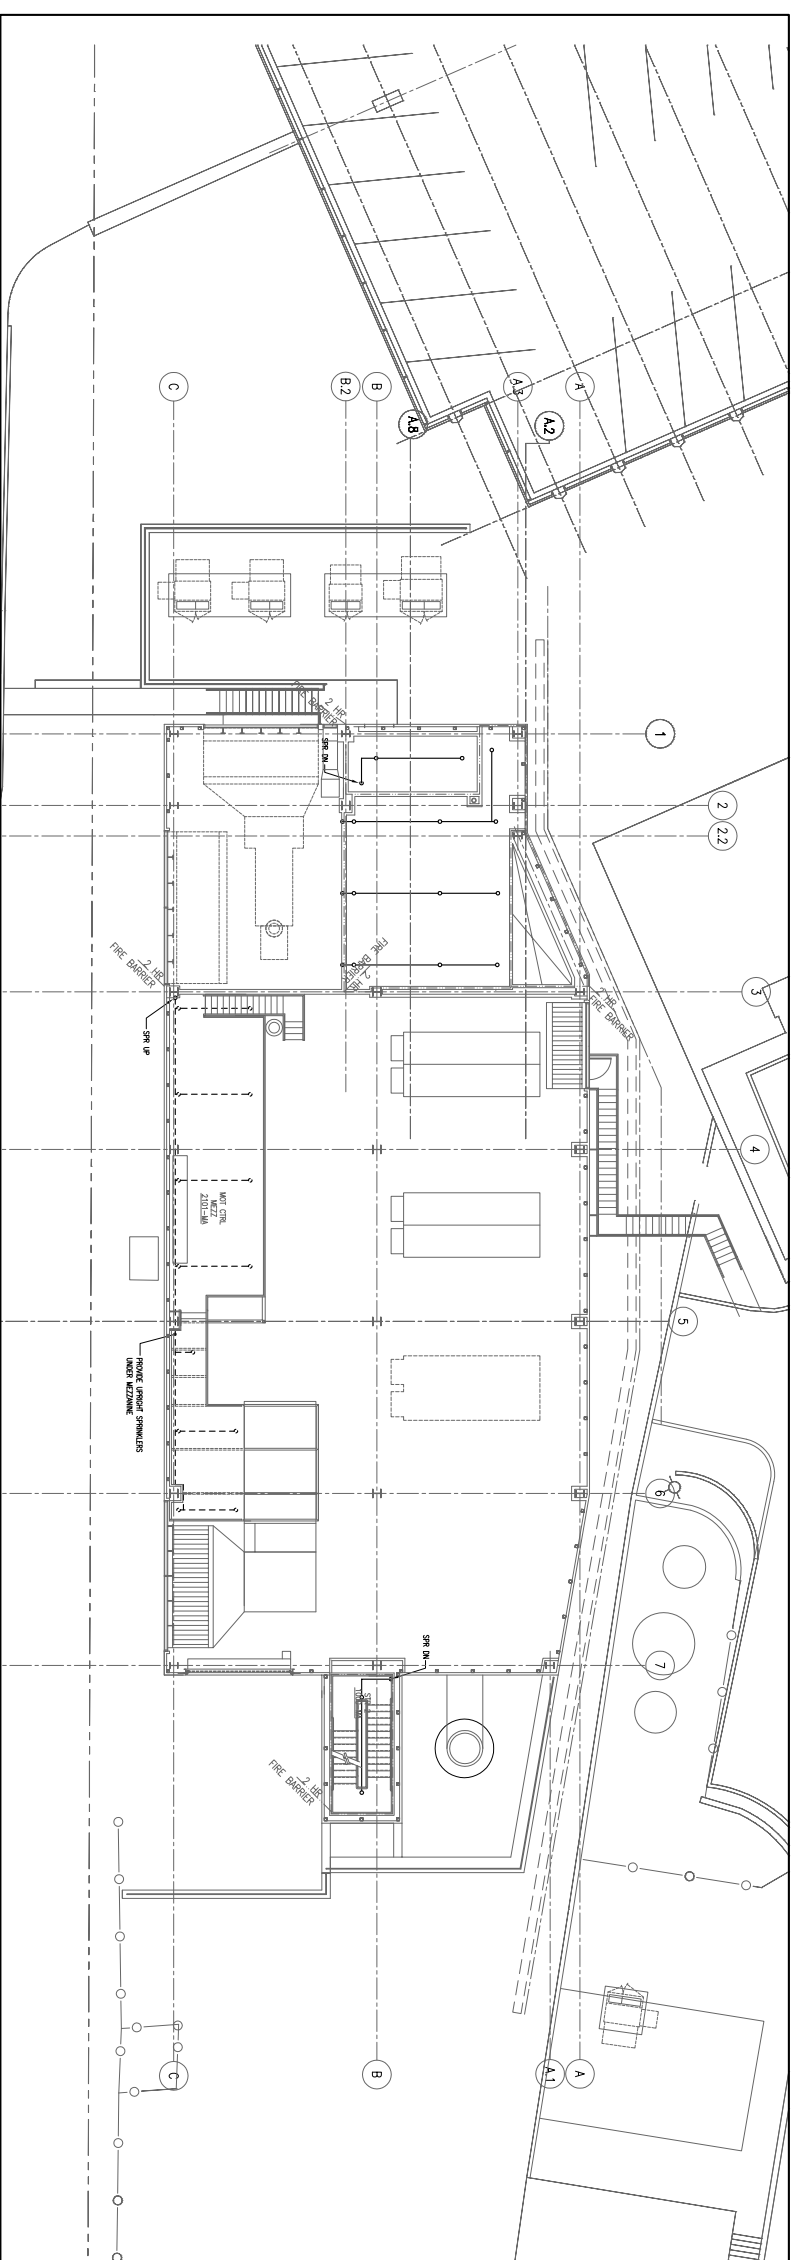

LEVEL 2 PLATFORM PLAN

SCALE: SEE SHEET
FOR PERMIT ONLY
NOT FOR CONSTRUCTION
 PROJECT NO. 09/21/14 FLOOR SET - NET FIRE CONSTRUCTION
 SCALE: 1/8" = 1'-0"

Key Plan

TRO
 A ARCHITECTURE
 PLANNING
 SHOWING
 THE BUILDING CONSTRUCTION
 NUMBER: 10/2014/001

Maine Medical Center
 Central Utility Plant
 Portland, Maine

FIRE PROTECTION
LEVEL 2 & PLATFORM PLAN

Commission No. 4377 Expiration Date 12/31/2015
 License No. 178-1-1-4 State Number
 Licensee Name: M. J. Licensee Address: 1000
 Licensee Phone: 43777202 Licensee Email: m.j.
 Licensee State: ME Licensee Expiration: 12/31/2015
FP202