



LEVEL 1 PLAN

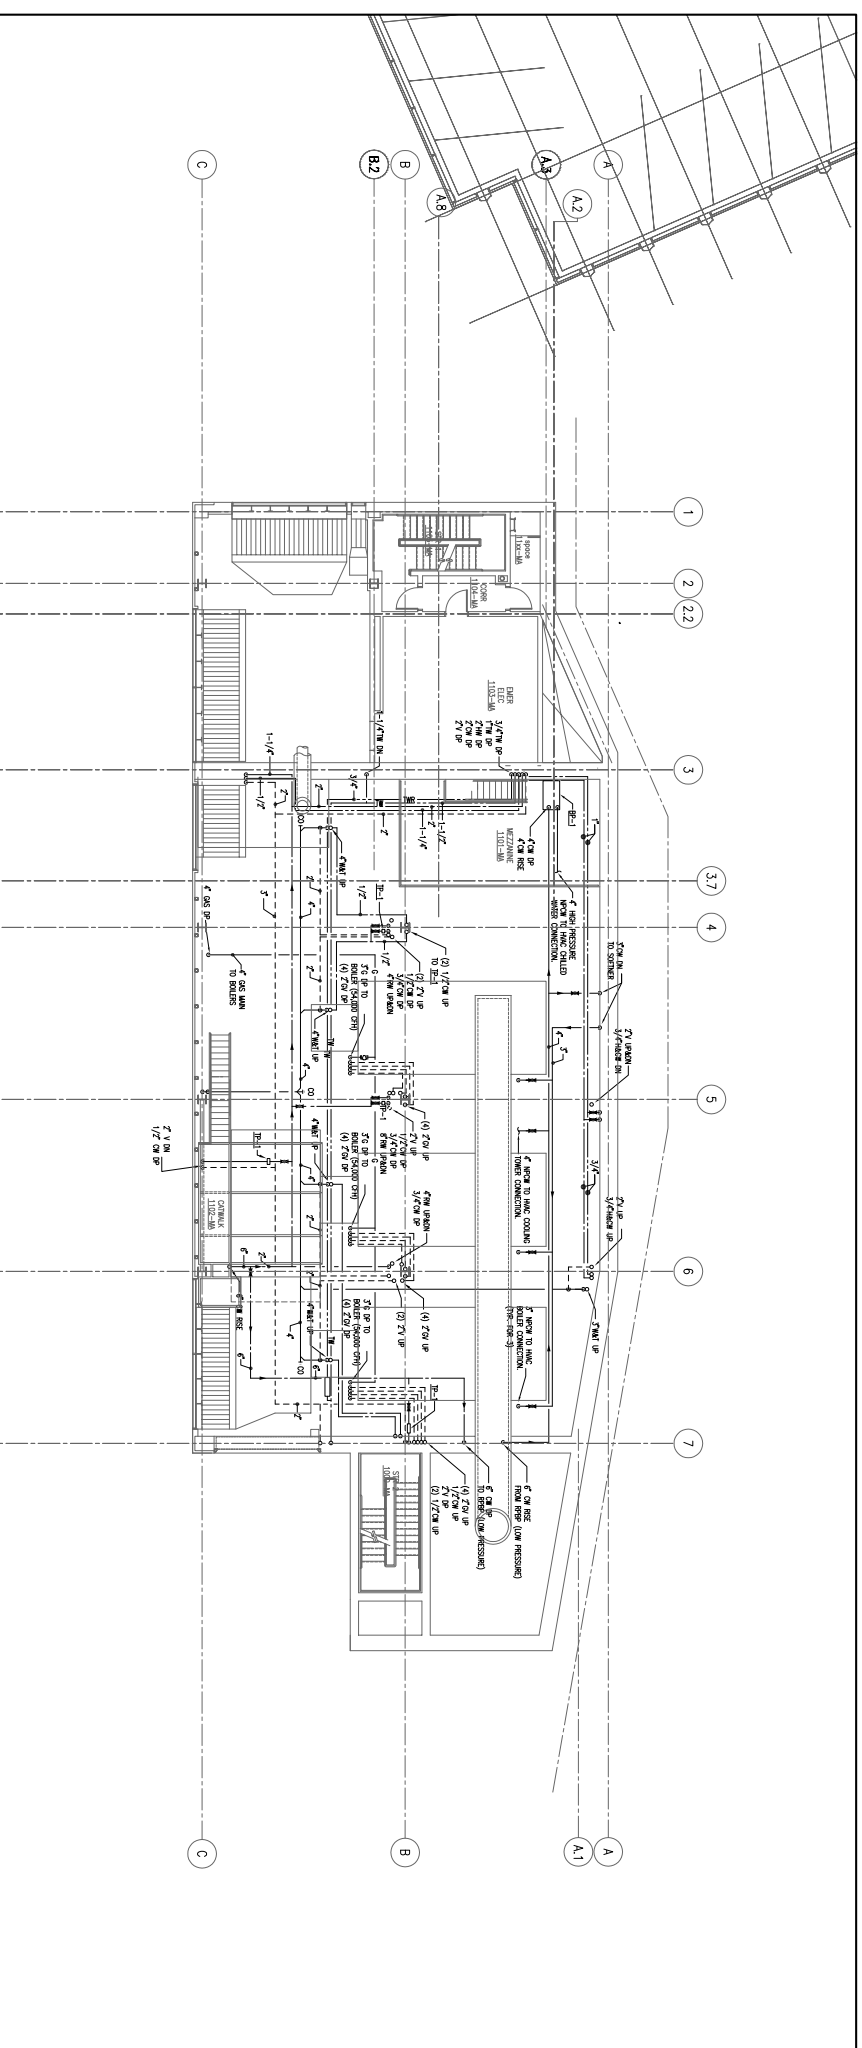

LEVEL 1 PLATFORM PLAN

ISSUE DATE: 08/21/18
FOR PERMIT ONLY
NOT FOR CONSTRUCTION

PROJECT LOG
 08/21/18 FEMER ST - NET FOR CONSTRUCTION

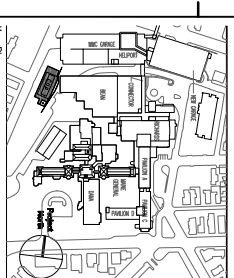

PRO
 ARCHITECTS
 PLANNING
 SHOWROOM
 1377 Main Street
 Portland, ME 04102
 Phone: 603.733.1100
 Fax: 603.733.1101
 Website: www.proarchitects.com

Maine Medical Center
 Central Utility Plant
 Portland, Maine

PLUMBING
LEVEL 1 & PLATFORM PLANS



Commission No. 4877
 License Number
 Scale: 1/8" = 1'-0"
 Date: 08/21/2018
 Project: FEMER ST - NET FOR CONSTRUCTION
 Designer: [Name]
P201