

144 Fore Street/P.O. Box 618  
Portland, Maine 04104  
Tel. (207) 772-3846  
Fax. (207) 772-1070  
www.smrtinc.com

ARCHITECTURE  
ENGINEERING  
PLANNING  
INTERIOR DESIGN  
COMMISSIONING


**SMRT**

PROJECT NORTH

STATE OF MAINE  
Dan Adams  
9838  
LICENSED PROFESSIONAL ENGINEER  
3/13/14

**E1 FLOOR PLAN**

1/4"=1'-0"

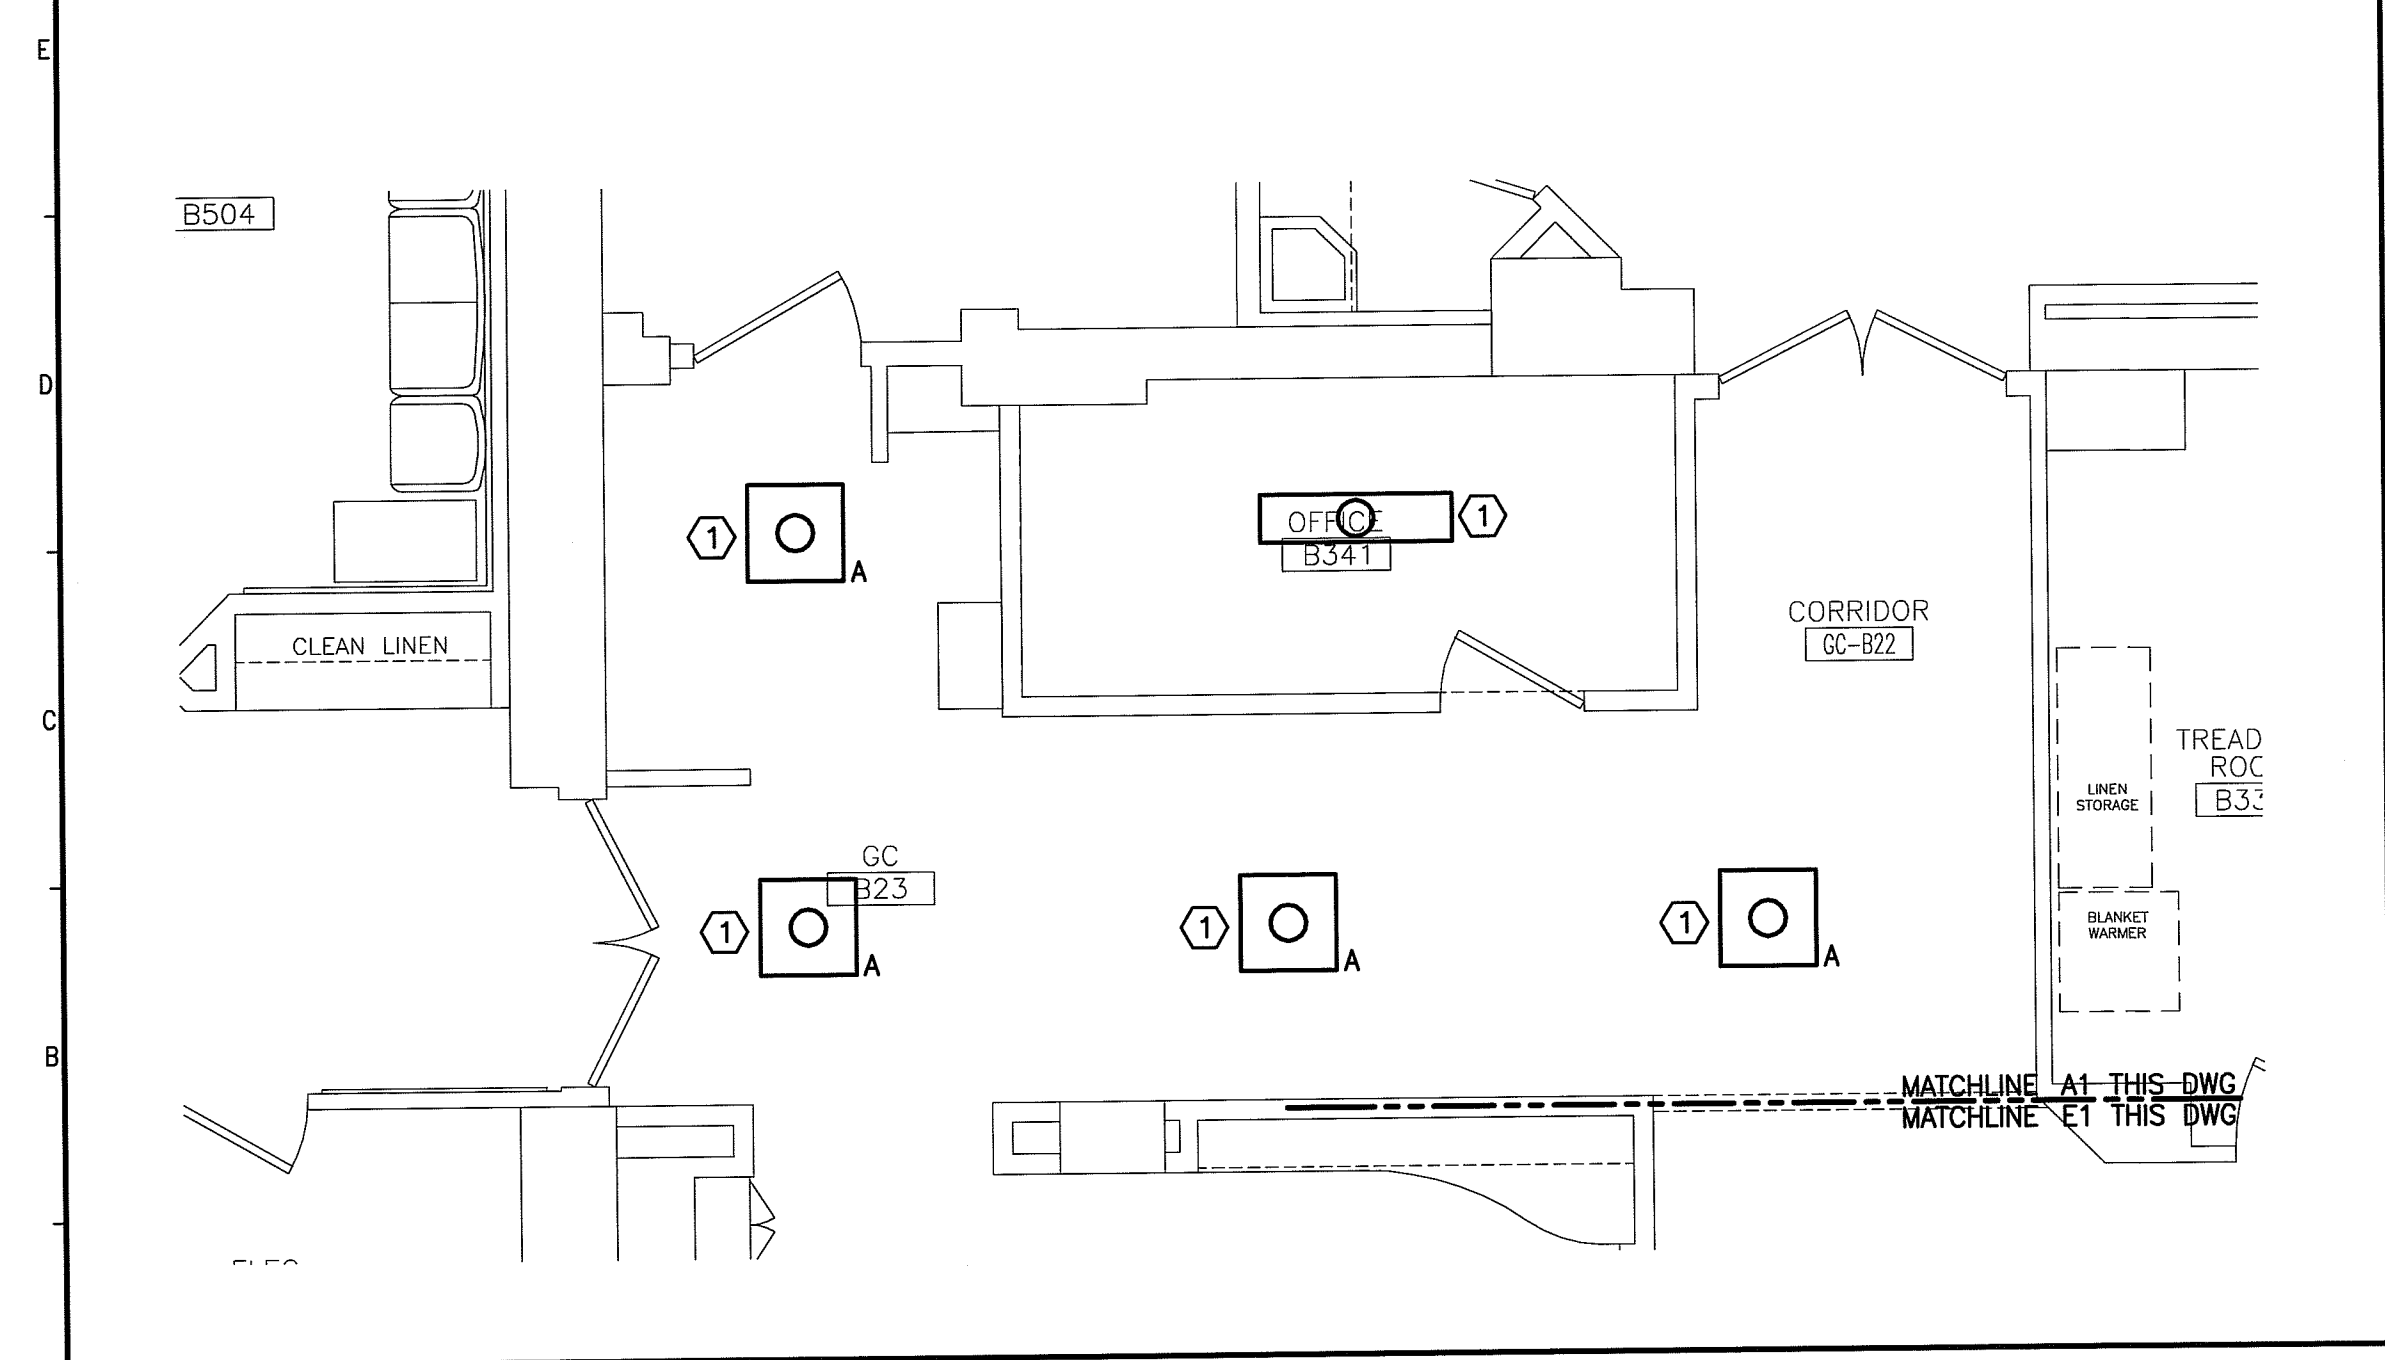

**A1 PART PLAN**

1/4"=1'-0"

**LIGHT FIXTURE SCHEDULE**

TYPE	DESCRIPTION	MFR.	LAMPS	MOUNTING	NOTES
A	2x2 DIRECT/INDIRECT FLUORESCENT WITH METAL PERFORATE OVERLAY 120V	EXISTING TO BE RELOCATED	-	CEILING RECESSED	
B	2x2 DIRECT/INDIRECT FLUORESCENT WITH METAL PERFORATE OVERLAY 120V	COLUMBIA STE22 SERIES	3-F24T5HO 3500K	CEILING RECESSED	SEE NOTE 2. FIXTURE WITH TWO BALLASTS TO ALLOW DUAL LEVEL SWITCHING.
C	2x2 DIRECT/INDIRECT FLUORESCENT WITH METAL PERFORATE OVERLAY 120V	COLUMBIA STE22 SERIES	2-F24T5HO 3500K	CEILING RECESSED	
D	6" ROUND APERTURE HIGH OUTPUT DOWNLIGHT WITH 45 DEGREE FLOOD DISTRIBUTION AND CLEAR ALZAK REFLECTOR. 120V	PRESCOLITE D6LED3 SERIES	15W LED 3500K	CEILING RECESSED	PROVIDE WITH LUTRON ECOSYSTEM DIMMING DRIVER FOR DIMMING DOWN TO 1%.
E	2x2 SPECIFICATION GRADE RECESSED TROFFER W/PATTERN A12 ACRYLIC LENS. 120V	COLUMBIA 4PS SERIES	2-F31U6T8 3500K	CEILING RECESSED	PROVIDE WITH 5% DIMMING BALLAST
F	4' FLUORESCENT STRIP. 120V	COLUMBIA CH SERIES	2-F32T8 3500K	CHAIN HUNG	
G	42" LOW PROFILE UNDER CABINET LIGHT. 120V	COLUMBIA UCS42 SERIES	2-F13T5 3500K	UNDER CABINET	
G1	33" LOW PROFILE UNDER CABINET LIGHT. 120V	COLUMBIA UCS33 SERIES	1-F13T5 & 1-F8T5 3500K	UNDER CABINET	

**NOTE:**

- 1. SEE SHEET E-001 FOR LEGEND AND GENERAL NOTES.

**KEYED NOTE:**

- ① RELOCATED LIGHTS AND EXIT SIGNS. EXTEND EXISTING WIRING FROM EXISTING DEVICE LOCATIONS SHOWN ON ED101 AS REQUIRED TO ACCOMMODATE NEW LOCATION.

MAINE MEDICAL CENTER  
NUCLEAR MEDICINE RENOVATIONS  
PORTLAND, MAINE

ISSUED FOR CONSTRUCTION  
3-13-14

CURRENT ISSUE STATUS:

GRAPHIC SCALE:  
0" 1"

SCALE: 1/4"=1'-0"

PROJECT MANAGER: DJV  
JC/DRAWN BY: CDS  
A/E OF RECORD: DJT  
CAD FILE: EL101-13128  
PROJECT NO: 13128  
DATE: 3-13-14

SHEET TITLE:  
**LIGHTING PLAN**

SHEET No.  
**EL101**  
© COPYRIGHT 2013 SMRT INC.