


F1 PLUMBING PLAN

1/4"=1'-0"

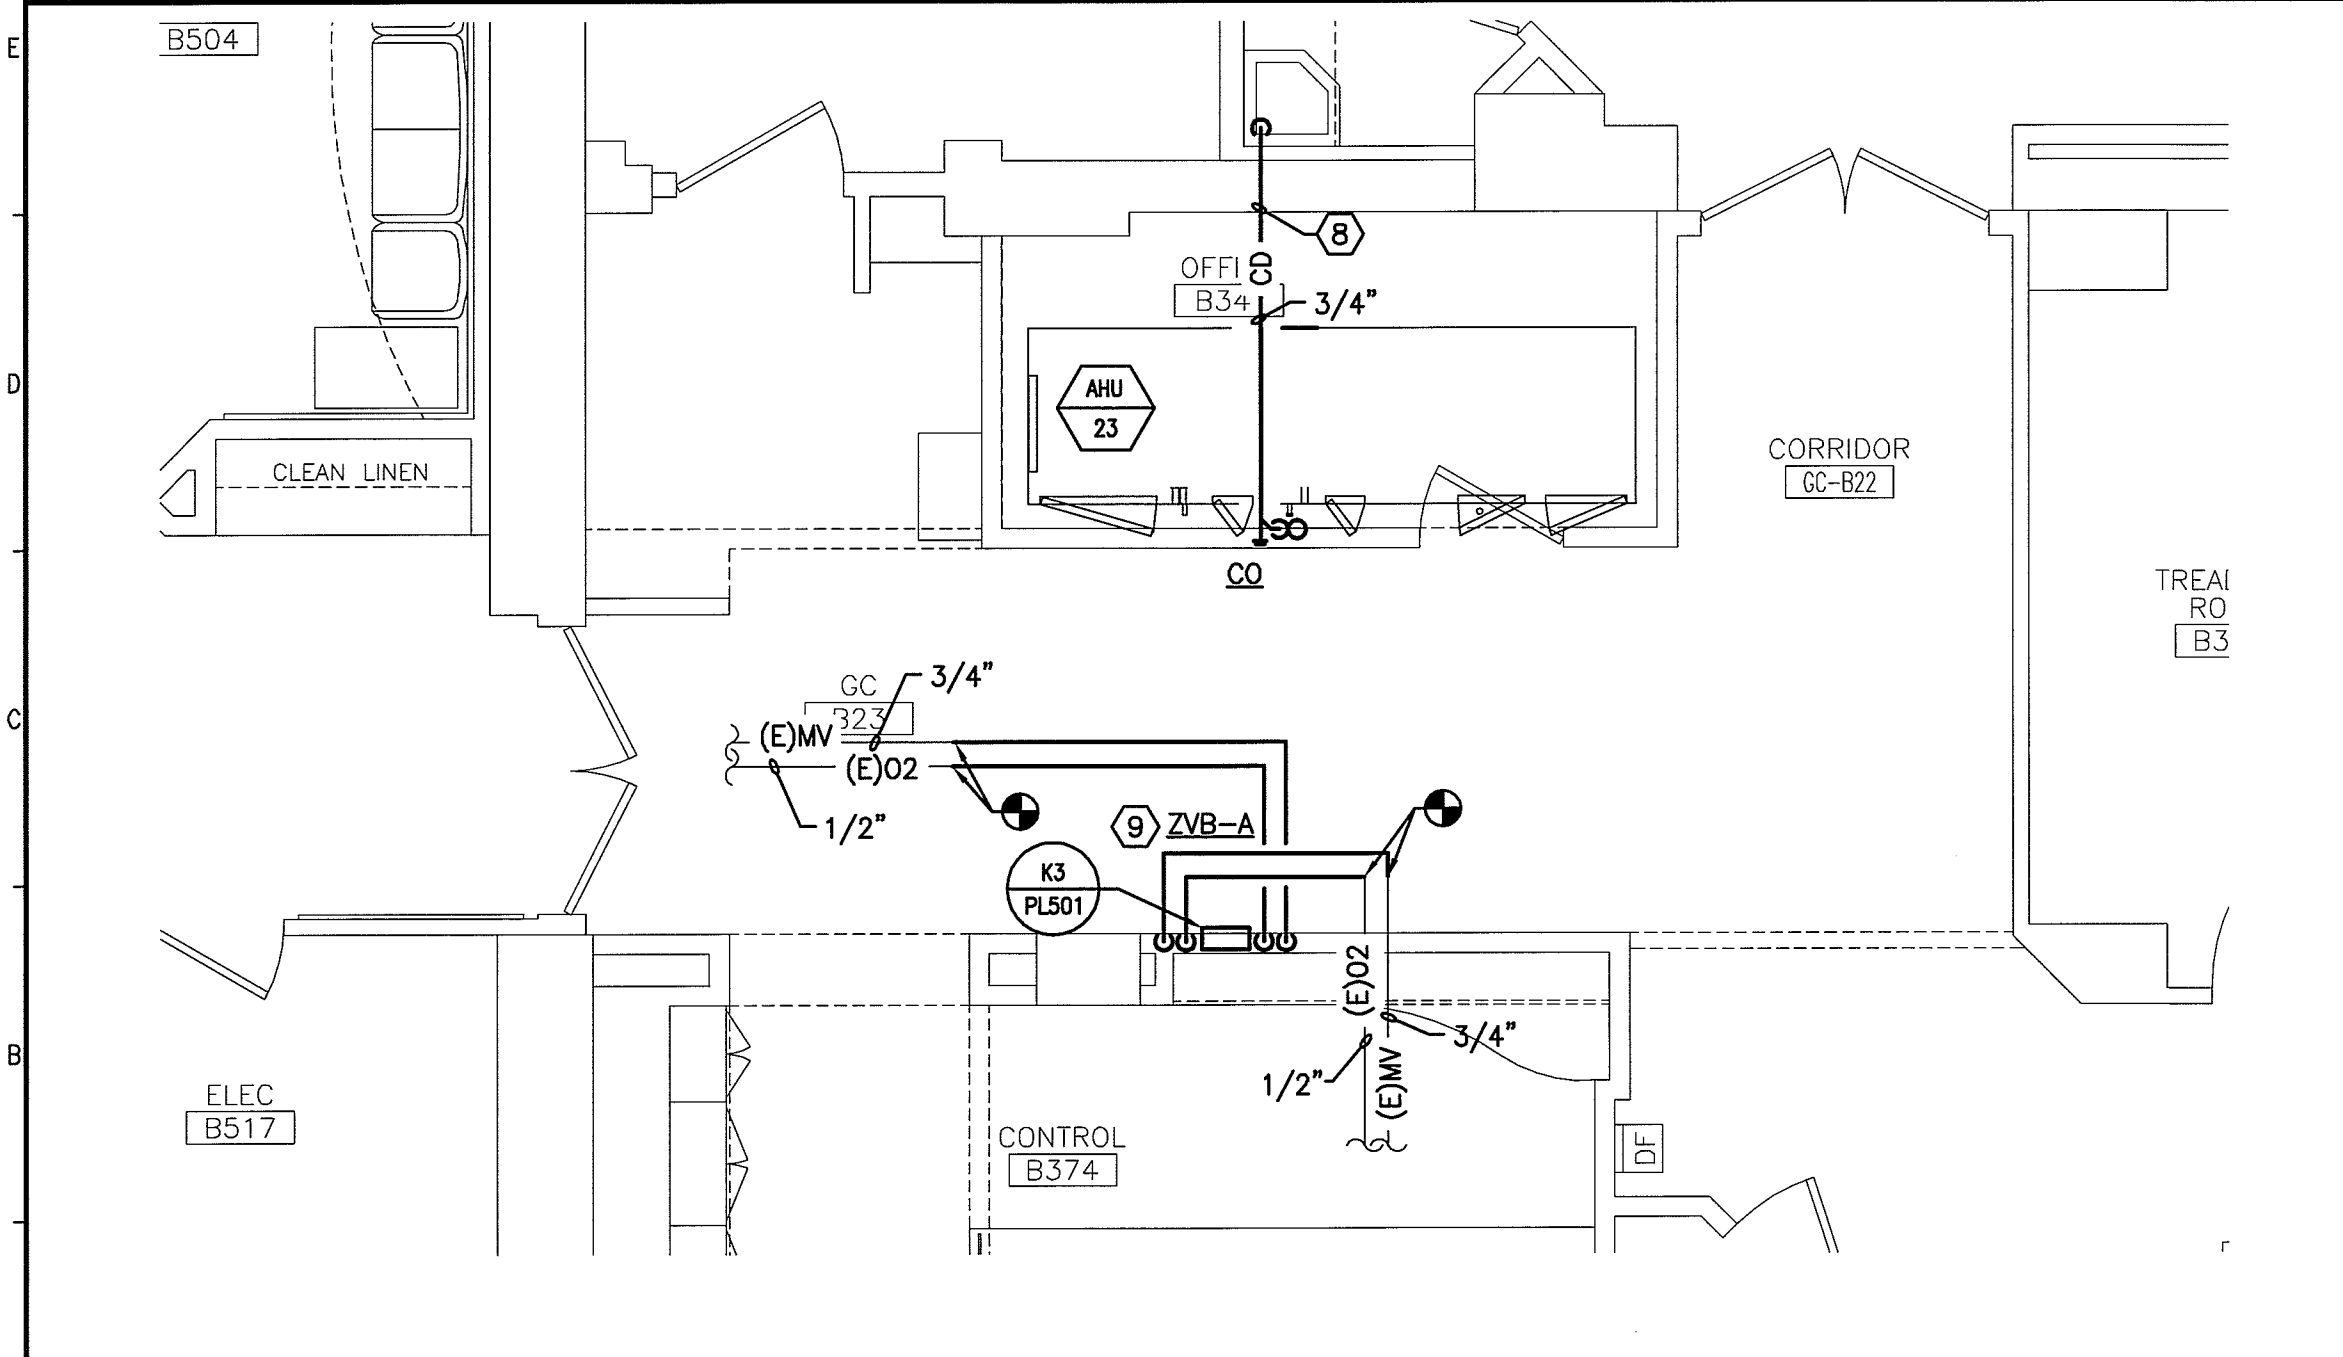

A1 PLUMBING PART PLAN

1/4"=1'-0"

GENERAL NOTES:




- SEE SHEET P-001 FOR LEGEND AND ABBREVIATIONS.
- REFER TO ARCHITECTURAL FOR EXACT MED GAS OUTLET LOCATIONS.

KEYED NOTES:

- PROVIDE NEW PERMANENTLY ENGRAVED LABEL STATING AREAS SERVED ON THE (E) ZVB.
- CTE 1/2" O2 AND 3/4" MV WITH A NEW 1/2" O2 AND 3/4" MV AND ROUTE TO ZVB-B.
- TRENCH FLOOR FOR NEW 4" UNDERGROUND S PIPE. PATCH FLOORS TO MATCH EXISTING. SEE DETAIL E3/PL501.
- RAISE VENT PIPING TO ACCOMMODATE NEW CEILING HEIGHT.
- RAISE CW AND HW PIPING ACCOMMODATE NEW CEILING HEIGHT.
- ROUTE 1/2" CW AND 1/2" HW-EACH TO SK-A AND TO EE-A MOUNTED ON WALL BENEATH COUNTER. PROVIDE SHUT-OFF VALVES AND UNIONS ON EE-A INLETS/OUTLET. PROVIDE WATTS #600 BRONZE CHECK VALVES ON EE-A INLETS. ROUTE 1/2" TW FROM EE-A TO EE-B.
- ROUTE 1/2" CW AND 1/2" HW-EACH TO SK-B AND TO EE-A MOUNTED ON WALL BENEATH COUNTER. PROVIDE SHUT-OFF VALVES AND UNIONS ON EE-A INLETS/OUTLET. PROVIDE WATTS #600 BRONZE CHECK VALVES ON EE-A INLETS. ROUTE 1/2" TW FROM EE-A TO EE-C.
- ROUTE 3/4" CD (1/4"/FT) UNDER AHU AND TO NEAREST MOP RECEPTOR. TURN DOWN 90° AND ROUTE TO 4" ABOVE FLOOD RIM AND SPILL TO MOP RECEPTOR.
- INSTALL NEW ZONE VALVE BOX ZVB-A WITHIN EXISTING WALL TO SERVE LINAC RM 376. PATCH WALLS TO MATCH EXISTING. PROVIDE PERMANENTLY ENGRAVED LABELS STATING AREA SERVED.
- ROUTE NEW SIGNAL WIRING TO ALARM PANEL AP-B LOCATED IN CONTROL ROOM 332. PROVIDE PERMANENTLY ENGRAVED LABELS STATING AREA SERVED.
- INSTALL NEW ZONE VALVE BOX ZVB-B WITHIN EXISTING WALL TO SERVE SPECT/CT RM 334. PATCH WALLS TO MATCH EXISTING. PROVIDE PERMANENTLY ENGRAVED LABELS STATING AREA SERVED.

144 Fore Street, P.O. Box 618
Portland, Maine 04104
tel. (207) 772-3846
fax. (207) 772-1070
www.smtinc.com

ARCHITECTURE
ENGINEERING
PLANNING
INTERIOR DESIGN
COMMISSIONING

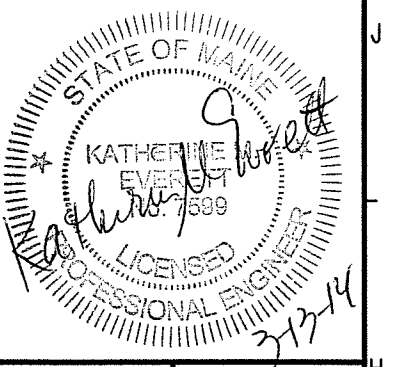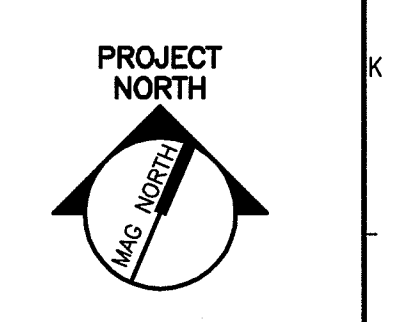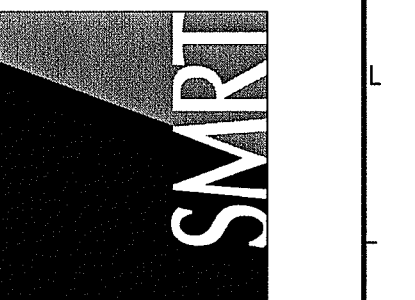

**MAINE MEDICAL CENTER
NUCLEAR MEDICINE RENOVATIONS**
PORTLAND, MAINE

**ISSUED FOR CONSTRUCTION
3-13-14**

CURRENT ISSUE STATUS:

DATE	DESCRIPTION	REV
3-13-14	ISSUED FOR CONSTRUCTION	0

GRAPHIC SCALE:
0" 1"

SCALE: 1/4"=1'-0"

PROJECT MANAGER: DJV
JC/DRAWN BY: MP
A/E OF RECORD: KME
CAD FILE: PL101-13128
PROJECT NO: 13128
DATE: 3-13-14

SHEET TITLE:
**PLUMBING
NEW WORK
PLAN**

SHEET No.
PL101
© COPYRIGHT 2013 SMT INC.