


# MAINE MEDICAL CENTER

22 Bramhall Street  
Portland, ME 04102

## SYMBIA T

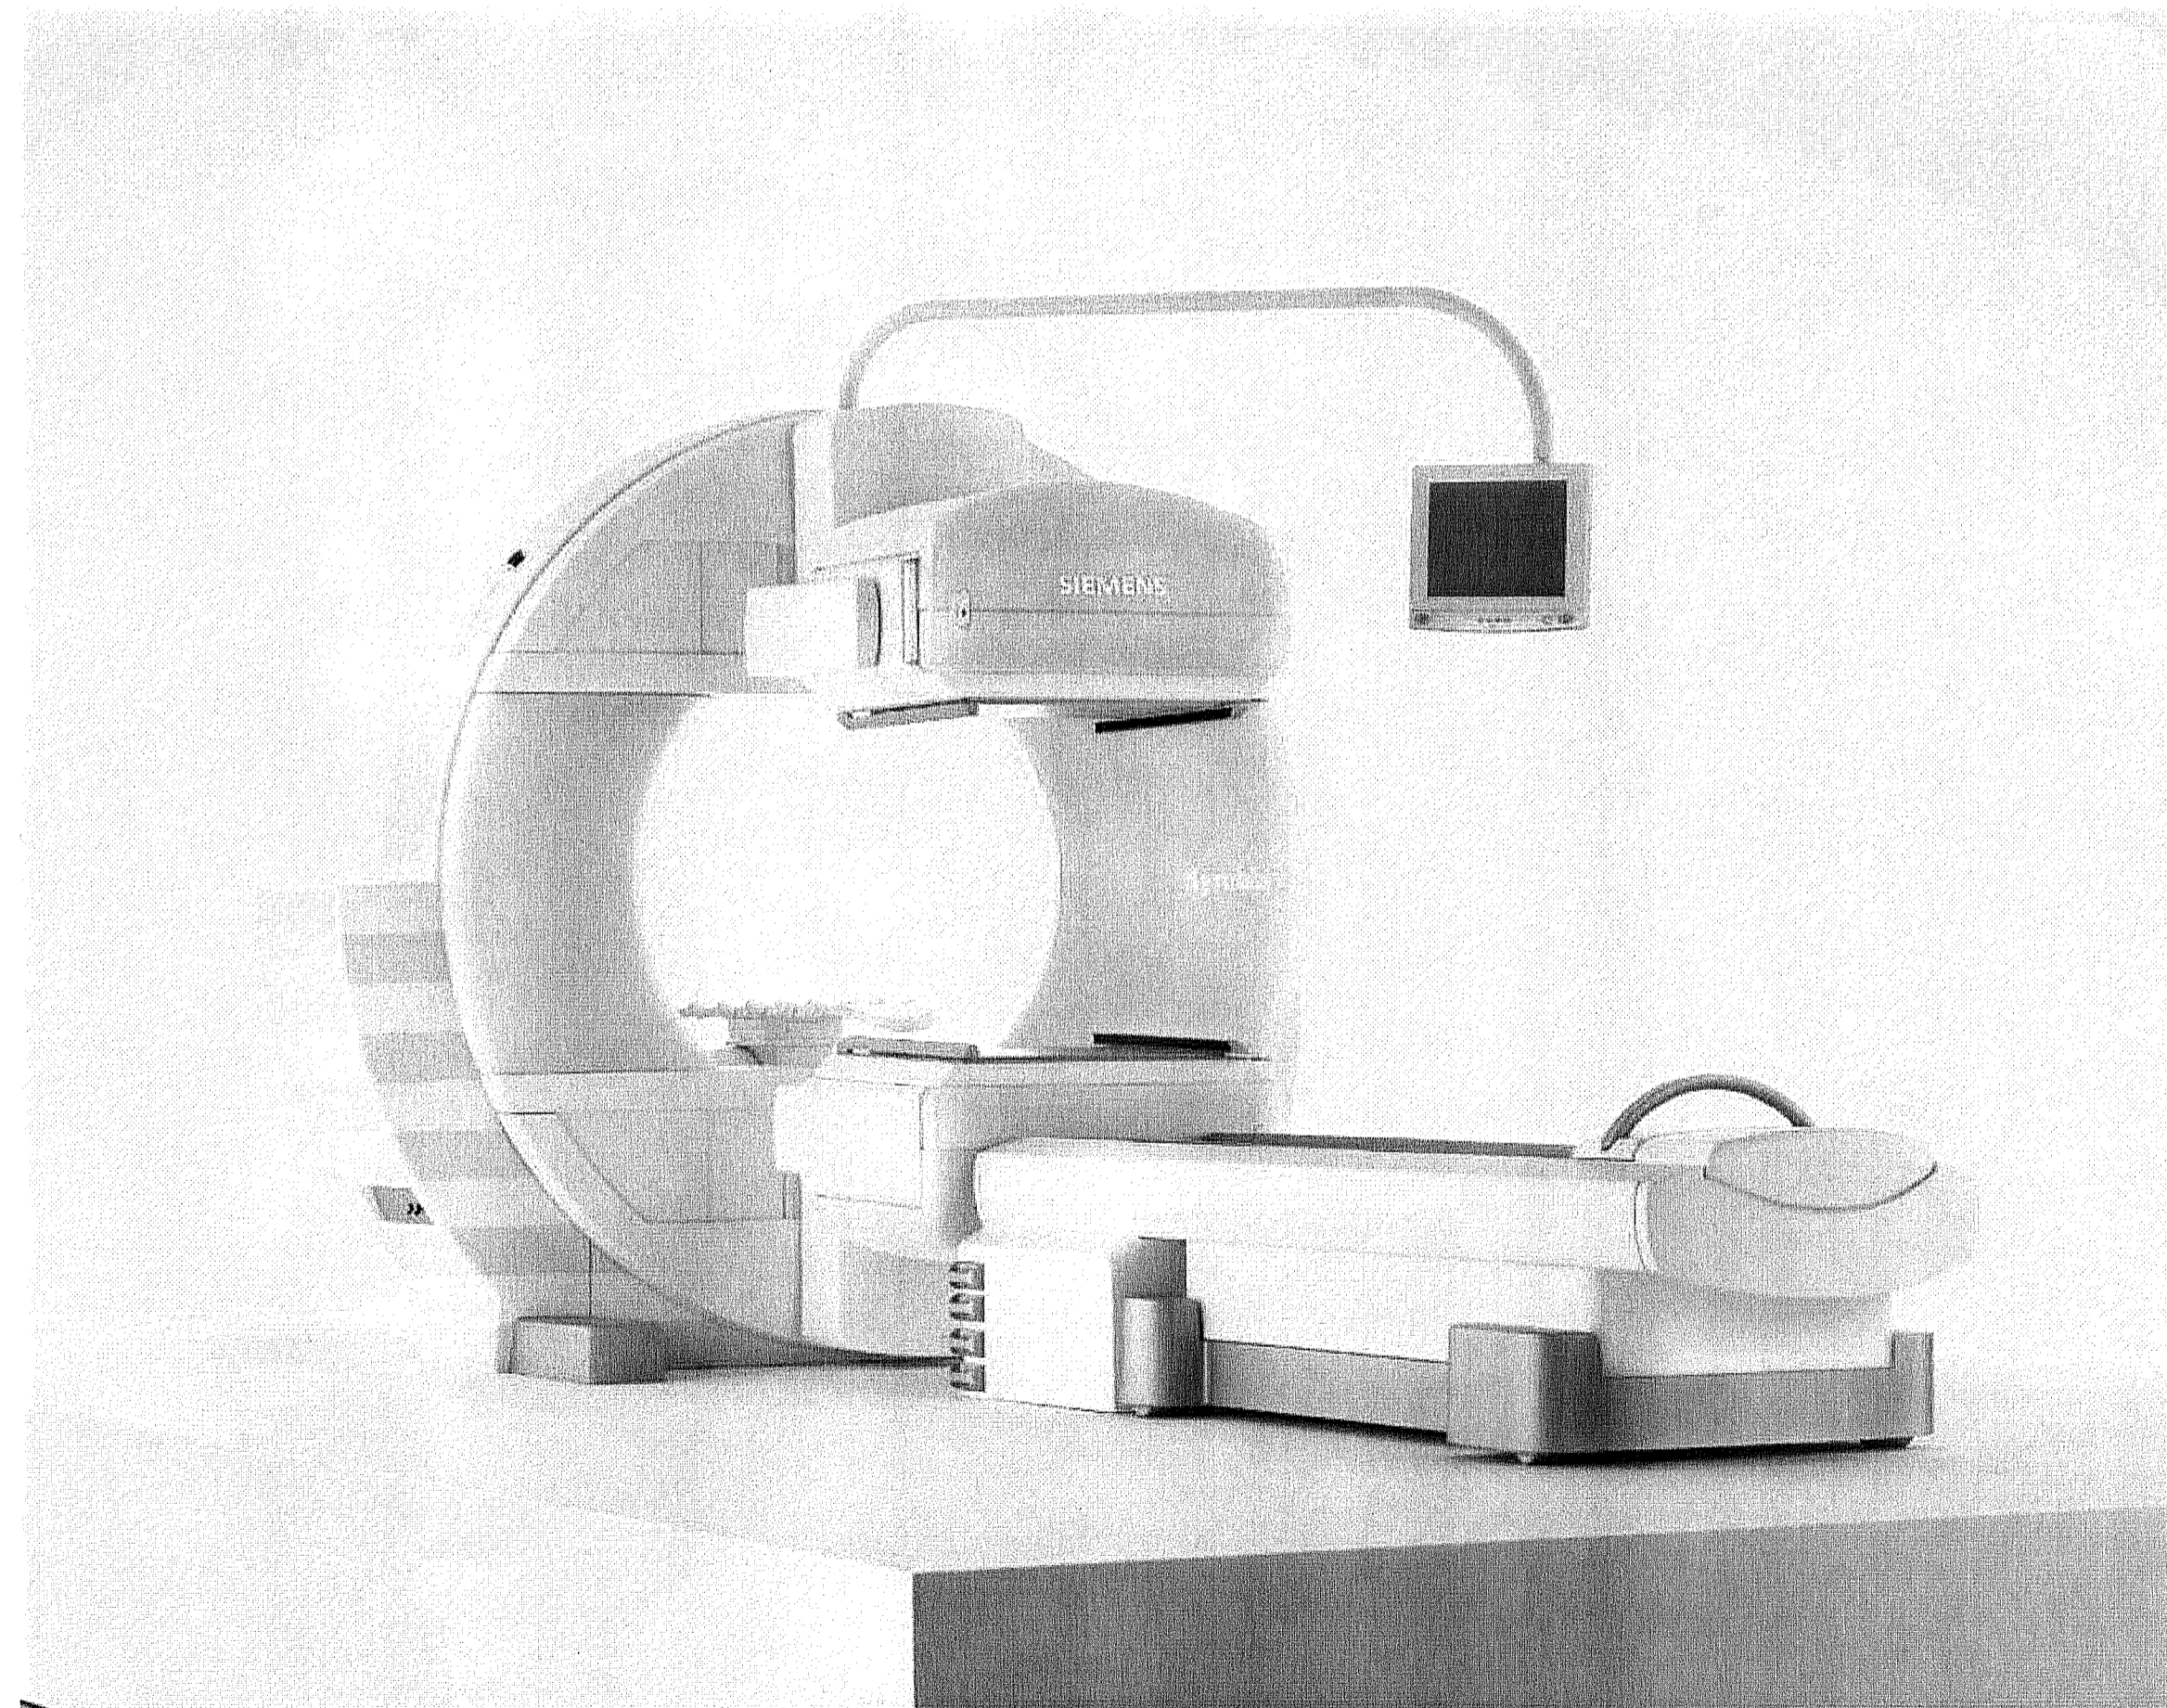

### Contents:

Sheet No.	Description
A-101	EQUIPMENT PLAN-LEGEND, DETAILS AND NOTES
A-102	SAFETY SERVICE CLEARANCE PLAN, DETAILS AND NOTES
S-101	STRUCTURAL PLAN-DETAILS AND NOTES
S-501	DETAILS AND NOTES
E-101	ELECTRICAL PLAN(S)-LEGEND AND NOTES
E-102	ELECTRICAL PLAN-LEGEND AND NOTES

### Project Contacts:

**Siemens**  
Project Manager  
Rich Deister  
Phone: (207) 712-3205  
rich.deister@siemens.com

**Maine Medical Center**  
Customer Contact  
Marshall Bartlett  
Phone: 207-662-2988

Planner  
Melanie Copley

Project #: 1303838

**SIEMENS**  
SIEMENS MEDICAL SOLUTIONS  
51 Valley Stream Parkway  
Malvern, PA 19355  
[www.usa.siemens.com/medical](http://www.usa.siemens.com/medical)