

REGISTER, DIFFUSER & GRILL SCHEDULE							
TAG	CFM	NECK SIZE	TYPE	DP	MAX NC	TYPICAL UNIT MFG & MODEL NO.	NOTES
S-1	300	10"x6"	SUPPLY	-	<20	PRICE SERIES 20	2
S-2	450	10"x6"	SUPPLY	0.04	<20	PRICE MODEL ASPD	1
R-1	450	12"x8"	RETURN	-	<20	PRICE SERIES 530	2

NOTES:
 1. T-BAR LAY-IN MOUNTING
 2. SURFACE MOUNTED WALL.
 3.

NOTE:


- SEE SHEET M-001 FOR LEGEND AND GENERAL NOTES.

DEMOLITION KEYED NOTES:


- REMOVE EXISTING SLOT DIFFUSER RING AND LAMINAR FLOW CENTER DIFFUSERS.
- REMOVE EXISTING RETURN GRILLE AND ASSOCIATED DUCTWORK COMPLETE.
- REMOVE EXISTING 6" RETURN AIR DUCT COMPLETE BACK TO MAIN AND CAP.
- REMOVE EXISTING SUPPLY AIR DUCT BACK TO POINT INDICATED.

KEYED NOTES:

- INSTALL (2) 10"x6" DOUBLE DEFLECTION SIDEWALL GRILLES (PRICE 20 SERIES).
- INSTALL 12"x8" GRILLE WITH OPPOSED BLADE DAMPER IN SIDEWALL (PRICE 530 SERIES).
- NEW 10" FLEX DUCT.
- REBALANCE EXISTING RETURN GRILLE TO 225 CFM.

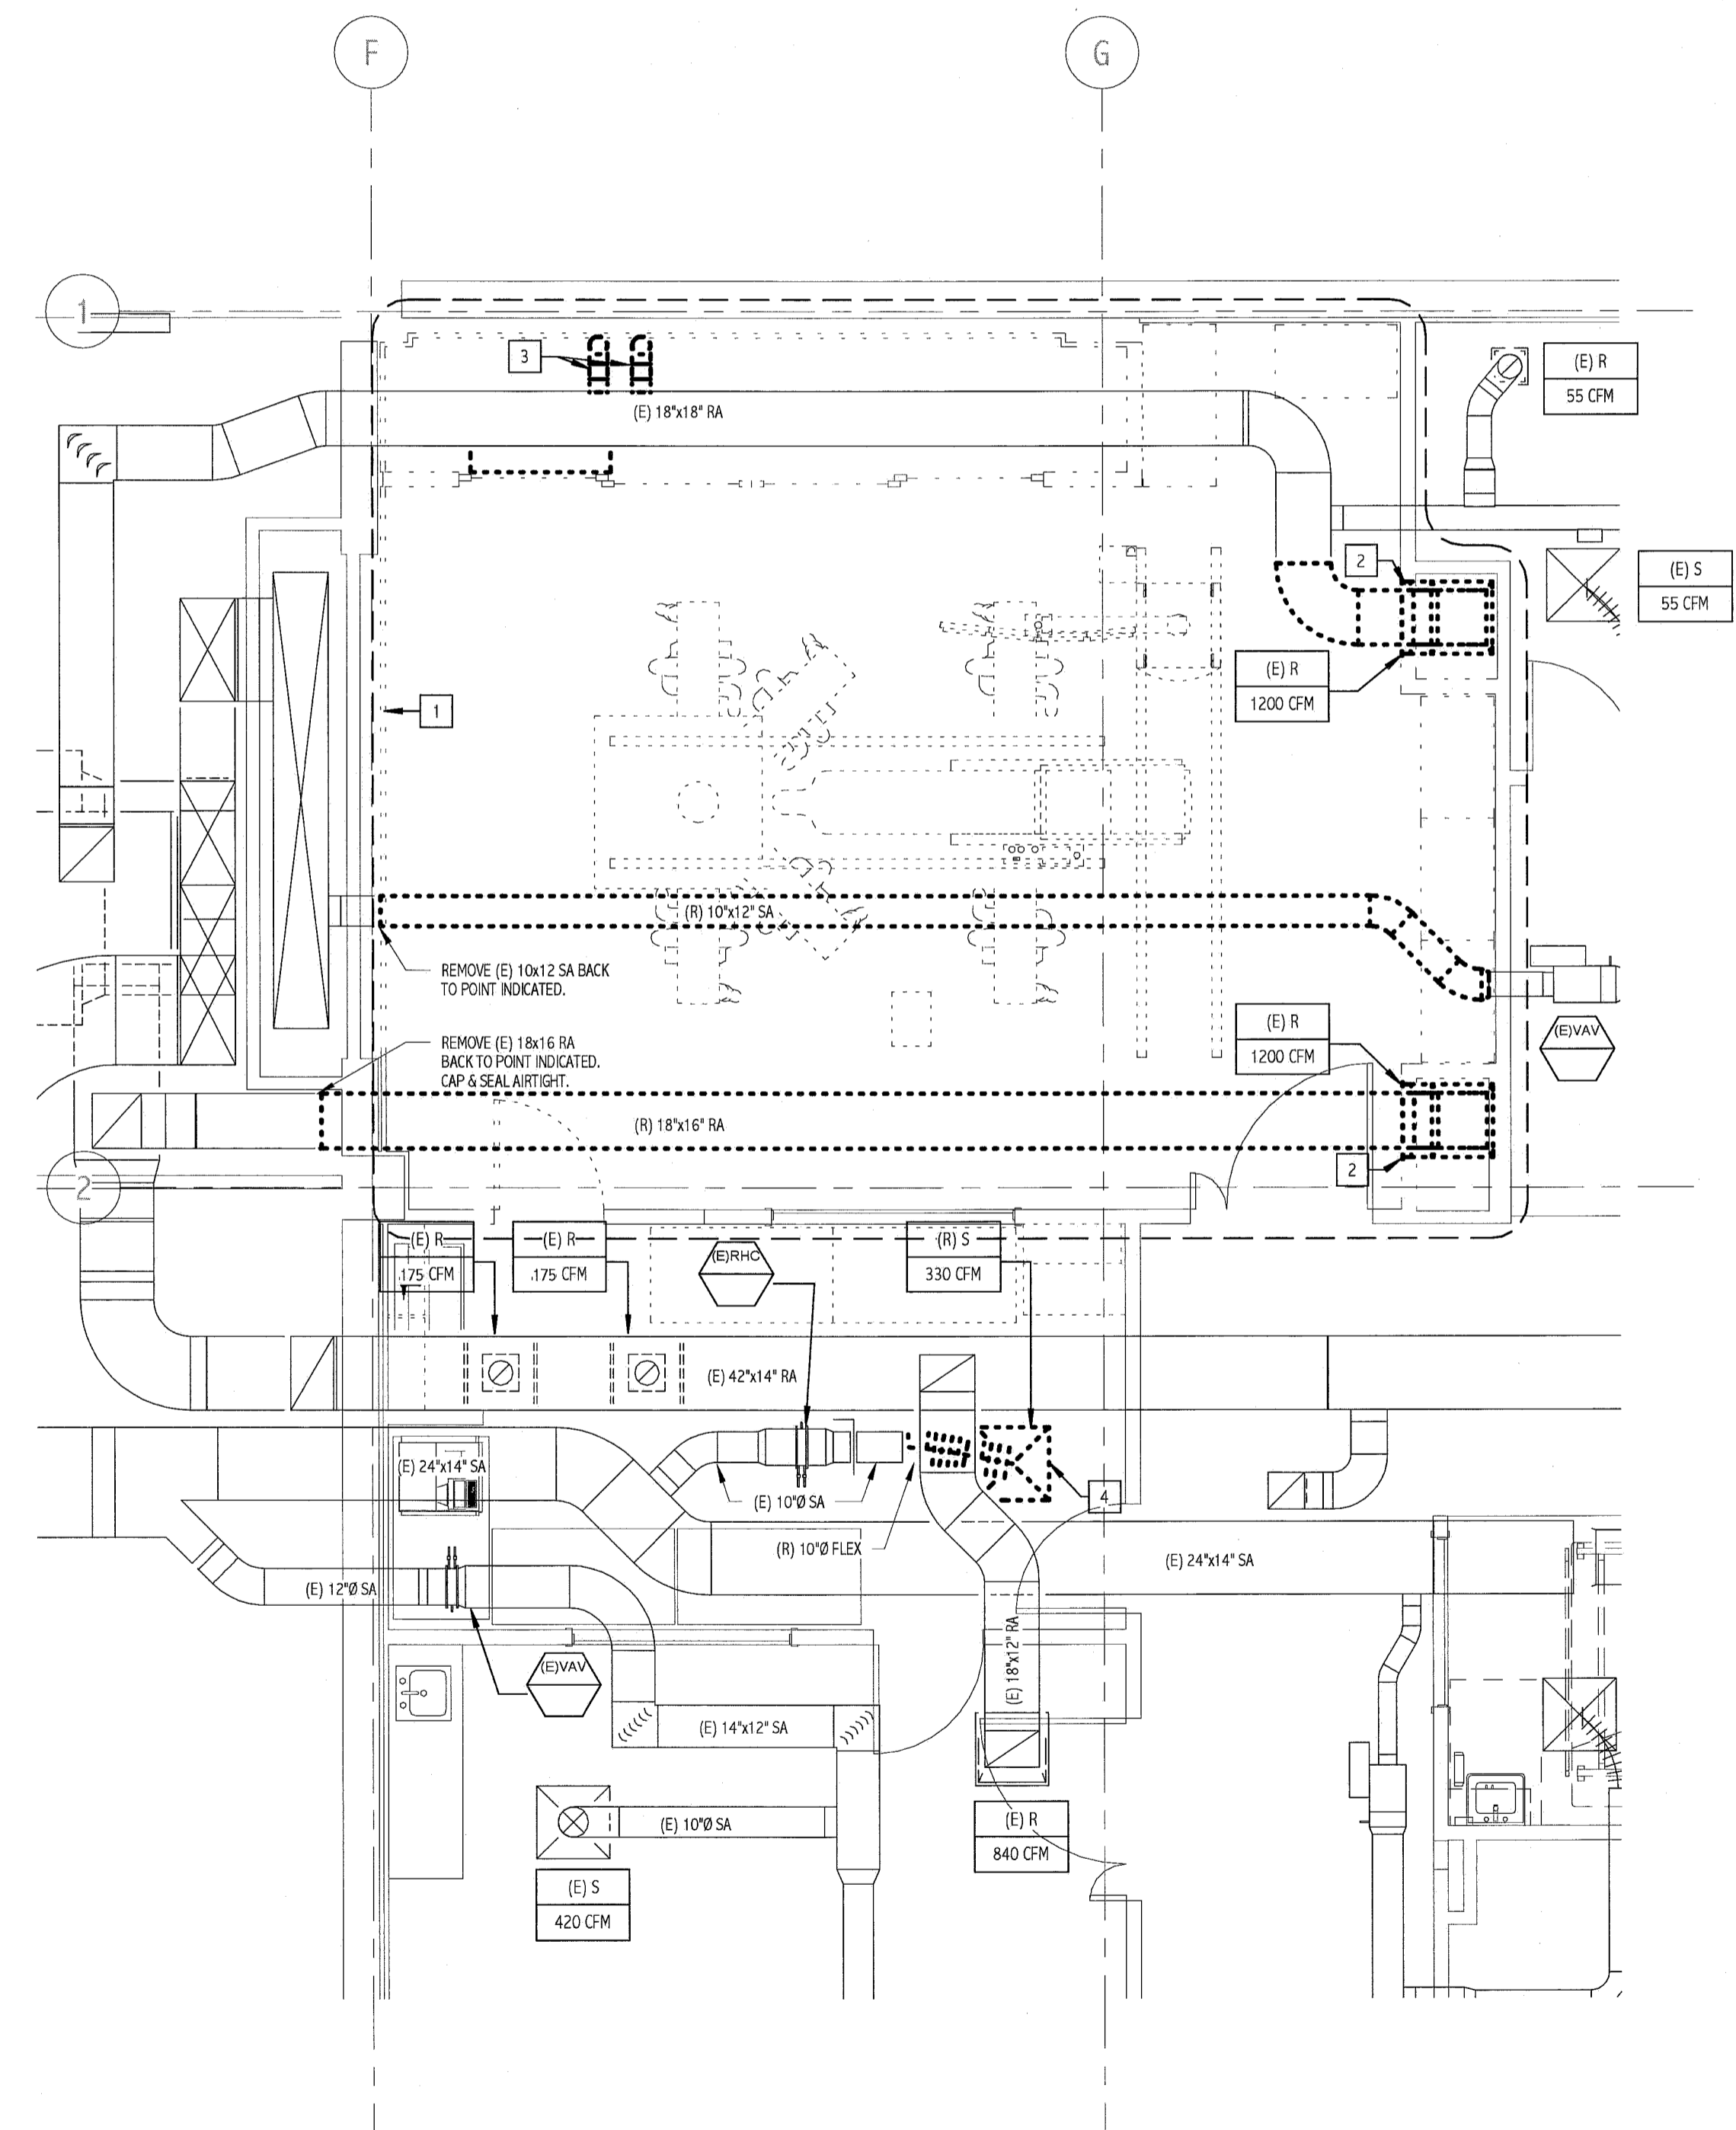

1 BASMENT DUCTWORK DEMOLITION PLAN
 1/4" = 1'-0"

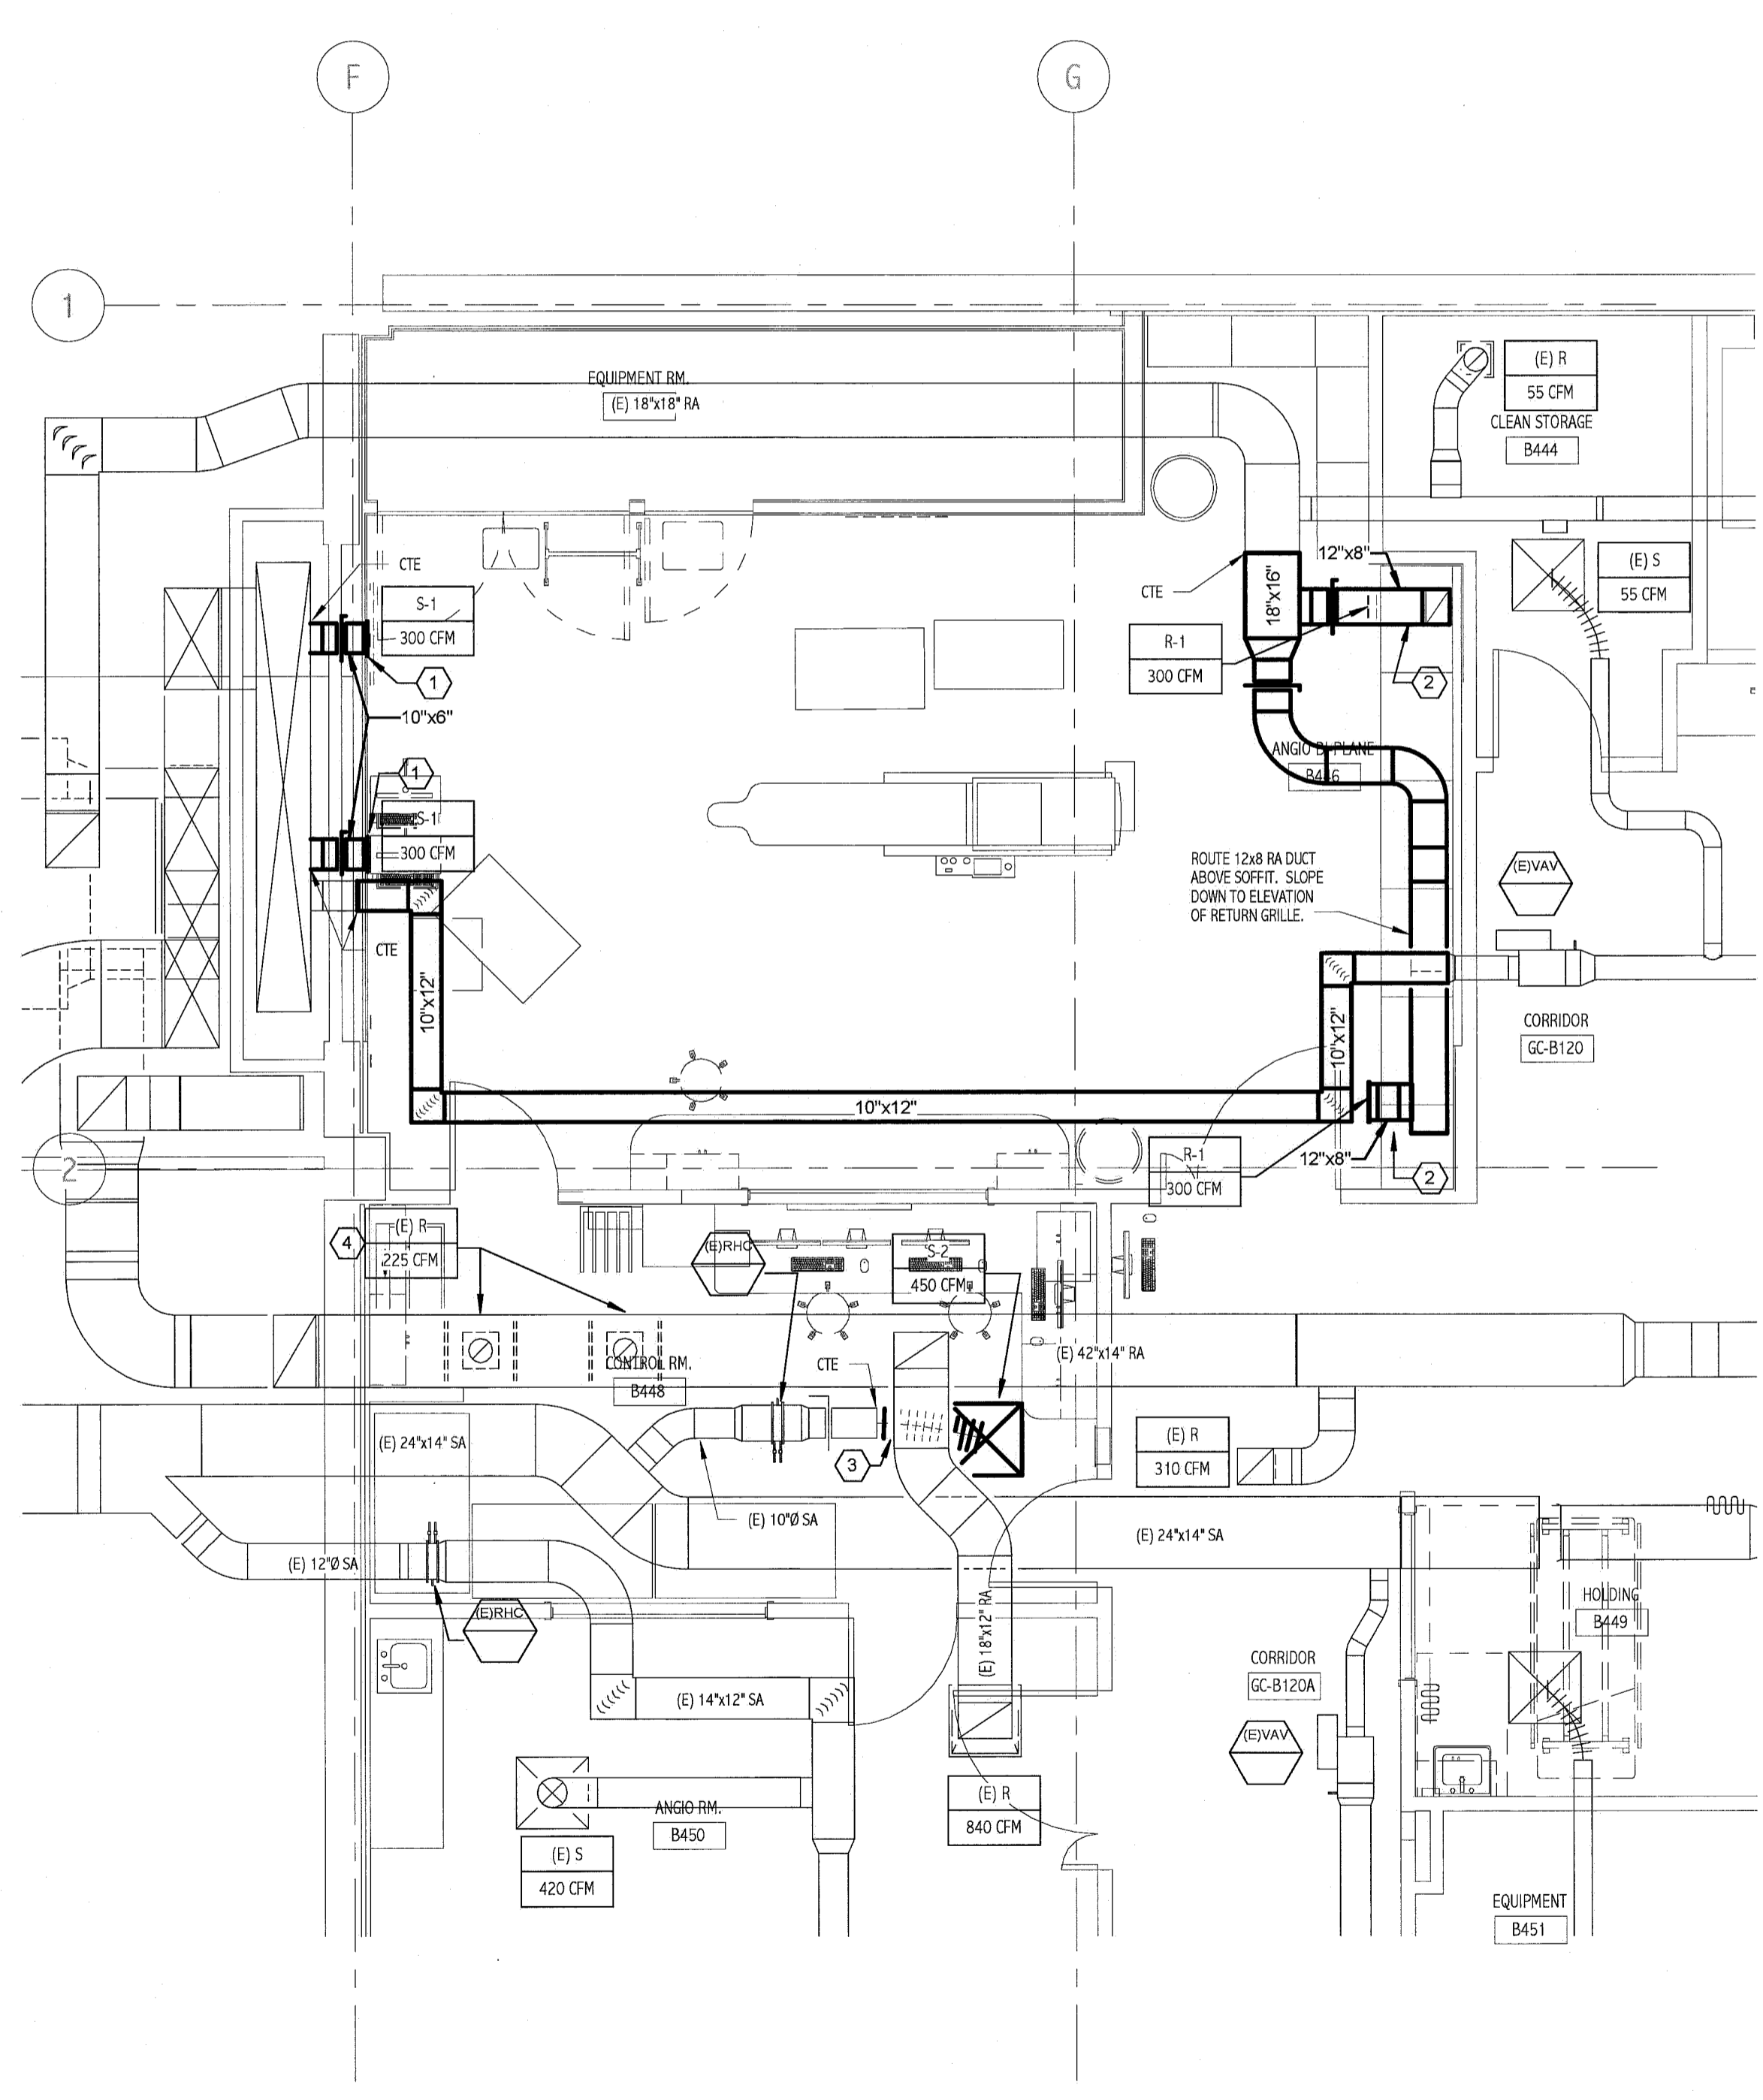

2 BASEMENT DUCTWORK PLAN
 1/4" = 1'-0"

144 First Street, Suite 618
 Portland, Maine 04104
 Tel: (207) 772-3846
 Fax: (207) 772-1070
 www.mhinc.com

ARCHITECTURE
 ENGINEERING
 PLANNING
 INTERIOR DESIGN
 COMMISSIONING

SMRT

STATE OF MAINE
 JUDICIAL BRANCH
 LICENSED PROFESSIONAL ENGINEER
 No. 9241
 6-14-11

PROJECT NORTH

Bramhall Radiology
 ANGIO BI-PLANE RENOVATIONS
 PORTLAND, ME

ISSUED FOR CONSTRUCTION
 06.14.11

REV	DESCRIPTION	DATE
0	ISSUED FOR CONSTRUCTION	06.14.11

GRAPHIC SCALE:
 0" = 1"

SCALE: As Indicated

PROJECT MANAGER: DIV
 ICDRAWN BY: KPB
 A/E OF RECORD: JAC
 PROJECT NO.: 11011
 DATE: 06.14.11

SHEET TITLE:
BASEMENT DUCTWORK PLANS

SHEET No.: **MH101**

© COPYRIGHT 2008 SMRT, INC.