

LIGHT FIXTURE SCHEDULE					
TYPE	DESCRIPTION	MFR.	LAMPS	MOUNTING	NOTES
D	8" HORIZONTAL FLUORESCENT DOWNLIGHT WITH WHITE SELF FLANGED TRIM, LOW IRRIDESCENT REFLECTOR AND ELECTRONIC DIMMING BALLAST	PORTFOLIO CB0421042-84G11U-WF	1-42W TRIPLE TUBE	RECESSED	
D1	6" LED DIMMABLE DOWNLIGHT WITH ROUND MATTE WHITE TRIM RING AND ASSOCIATED DIMMING CONTROLLER.	EVERBRITE LIGHTING XLSZ-D-35-120RHM	LED 3500K	RECESSED	PROVIDE "XLD" DIMMING CONTROLLER WALL SWITCH CAPABLE OF ON, OFF, 100 LEVELS OF DIMMING AND PRESET.
G	1x4 GASKETED FLUORESCENT WITH RADIO SUPPRESSORS, ASYMMETRIC LENS AND 2 BALLASTS	ALICO ST8140-2	3-32W T8	RECESSED GRID	
J	12" UNDERCABINET FLUORESCENT WITH SOLID FRONT AND ROCKER SWITCH	FAIR-SAFE MSS-08-120-1K12-EB51-RSW	1-8W T5	SURFACE	


**NOTES:**

- SEE SHEET E-001 FOR LEGEND AND GENERAL NOTES.
- REFER TO SPECIFICATION 265100 FOR BALLAST AND LAMP TYPES.

**KEYED NOTES:**

① EXISTING OR LIGHT.

② EXISTING FIXTURE SHOWN IN RELOCATED POSITION.

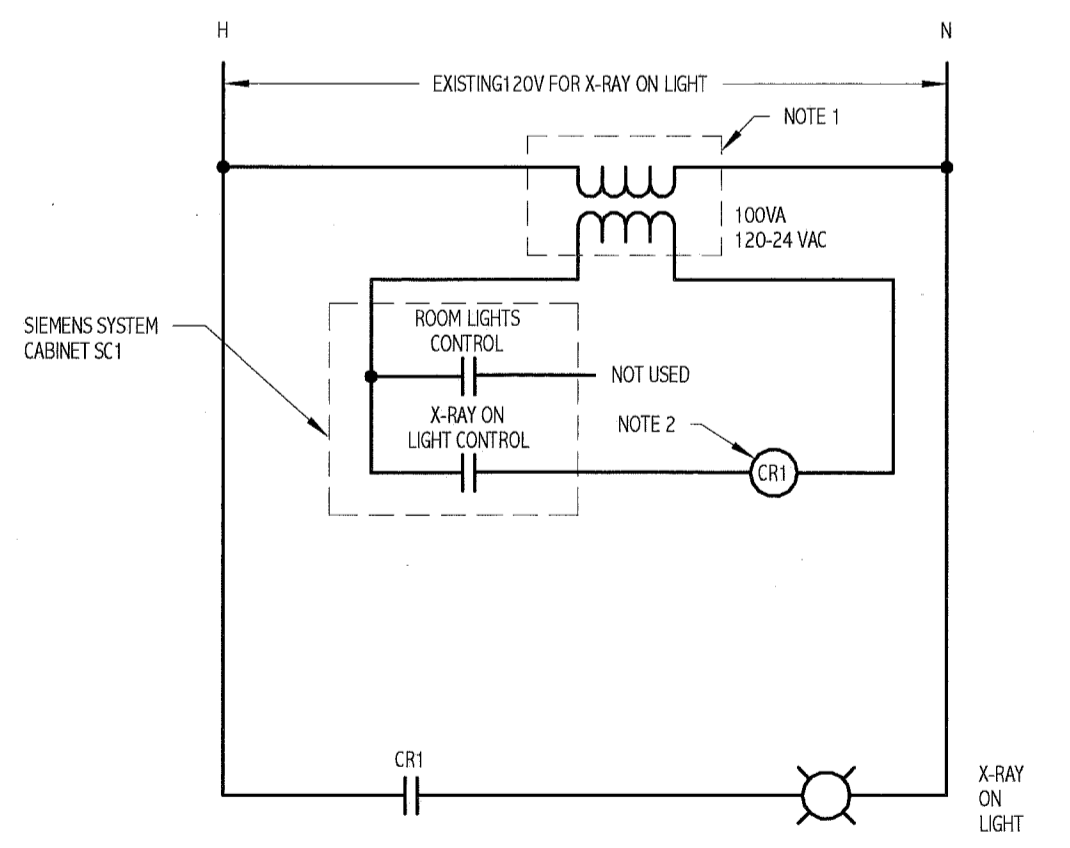




- PROVIDE A 100VA SQUARE D TYPE TF100-D23 CONTROL TRANSFORMER WITH PRIMARY AND SECONDARY FUSES IN A NEMA 1 ENCLOSURE. SQUARE D PART #H51.
- PROVIDE CONTROL RELAY. ALLEN-BRADLEY PART #700-N201-A24 IN NEMA 1 ENCLOSURE.

② ANGIO X-RAY ON LIGHT/ROOM LIGHTING CONTROL SCHEMATIC  
12" = 1'-0"

① BASEMENT LIGHTING PLAN  
1/4" = 1'-0"

1441 Free Street, P.O. Box 618  
Portland, Maine 04104  
Tel: (207) 772-3846  
Fax: (207) 772-1000  
www.smartinc.com

ARCHITECTURE  
ENGINEERING  
PLANNING  
INTERIOR DESIGN  
COMMISSIONING

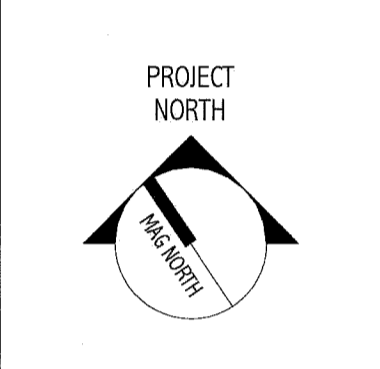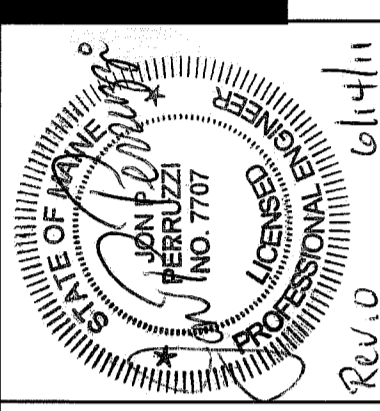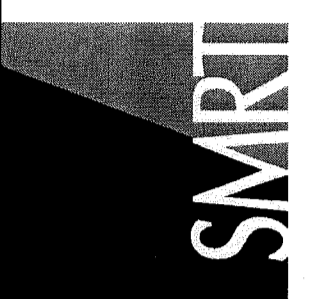

Bramhall Radiology  
ANGIO BI-PLANE RENOVATIONS  
PORTLAND, ME

ISSUED FOR CONSTRUCTION  
06.14.11

CURRENT ISSUE STATUS:

REV	DESCRIPTION	DATE
0	ISSUED FOR CONSTRUCTION	06.14.11

GRAPHIC SCALE:  
0' 1'

SCALE: As Indicated  
PROJECT MANAGER: DIV  
I.C./DRAWN BY: CDS  
A/E OF RECORD: IPP  
PROJECT NO.: 11011  
DATE: 06.14.11

SHEET TITLE:  
BASEMENT LIGHTING PLAN

SHEET NO.:  
EL101