


# MAINE MEDICAL CENTER

22 Bramhall Street  
Portland, ME 04102

## ARTIS ZEE BIPLANE ANGIO

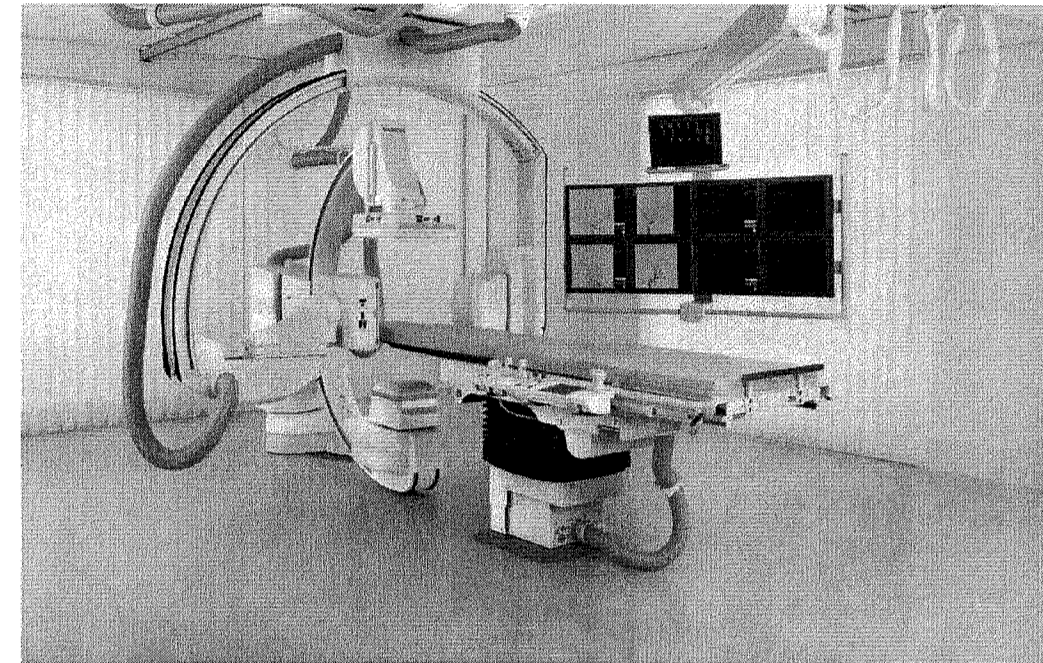

**Contents:**

Sheet No.	Description
A-101	EQUIPMENT LAYOUT-DETAILS, LEGEND, AND NOTES
A-102	REFLECTED CEILING, SAFETY/SERVICE CLEARANCE PLAN
S-101	STRUCTURAL FLOOR PLAN-DETAILS AND NOTES
S-102	STRUCTURAL CEILING PLAN-DETAILS AND NOTES
E-101	ELECTRICAL PLAN(S)-LEGEND AND NOTES
E-102	ELECTRICAL PLAN-LEGEND AND NOTES
E-501	ELECTRICAL DETAILS AND NOTES
M-101	MECHANICAL PLAN-DETAILS AND NOTES

**Project Contacts:**

**Siemens**  
Project Manager  
Rich Deister  
Phone: (207) 929-3556  
Voice Mail: (-)  
rich.deister@siemens.com


Planner  
Susi Douglas

Project #: 1002281


**SIEMENS**  
SIEMENS MEDICAL SOLUTIONS  
51 Valley Stream Parkway  
Malvern, PA 19355  
www.usa.siemens.com/medical

ARTIS ZEE BIPLANE ANGIO  
ANGIO ROOM B 445  
MAINE MEDICAL CENTER

Issue #: 1  
Date: 06/07/11  
**SIEMENS**

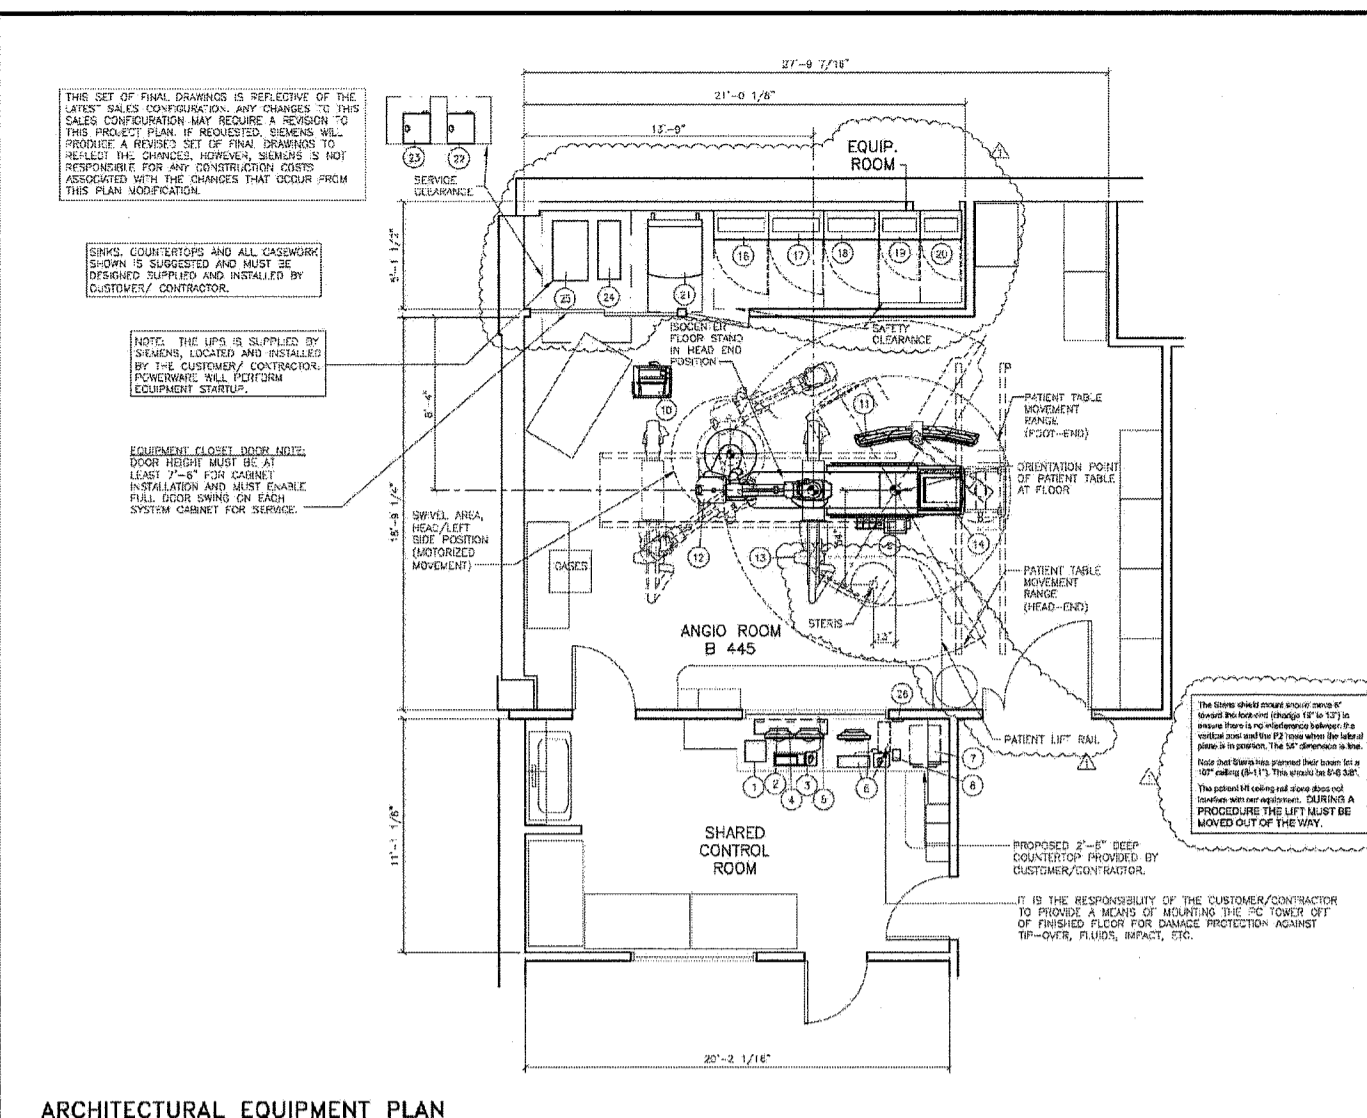

ARCHITECTURAL EQUIPMENT PLAN SCALE: 1/4" = 1'-0"

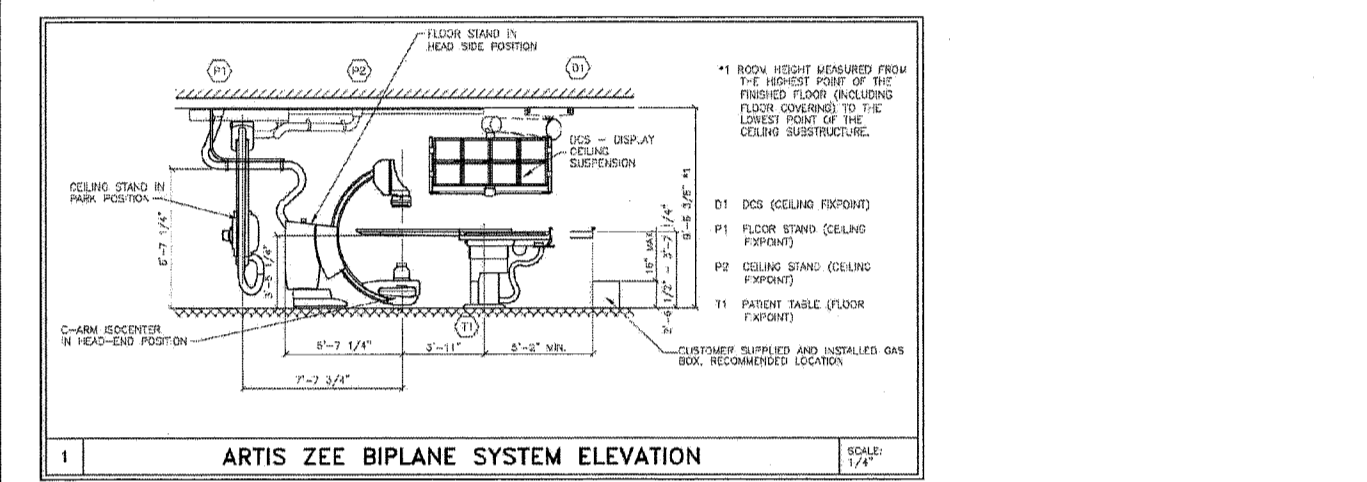

ARTIS ZEE BIPLANE SYSTEM ELEVATION

**ATTENTION:** THE OWNER IS ADVISED TO VERIFY ALL DIMENSIONS AND REQUIREMENTS OF THE ARTIS ZEE BIPLANE SYSTEM WITH THE MANUFACTURER'S INSTALLATION MANUAL AND TO VERIFY THE ROOM DIMENSIONS AND REQUIREMENTS WITH THE MANUFACTURER'S INSTALLATION MANUAL.

NO.	DESCRIPTION	QTY	UNIT	MANUFACTURER	REMARKS
01	ARTIS ZEE BIPLANE ANGIO	1	SYSTEM	SIEMENS	
02	CONTROL CONSOLE	1	CONSOLE	SIEMENS	
03	CONTROL CHAIR	1	CHAIR	SIEMENS	
04	CONTROL PANEL	1	PANEL	SIEMENS	
05	CONTROL TABLE	1	TABLE	SIEMENS	
06	CONTROL STAND	1	STAND	SIEMENS	
07	CONTROL CART	1	CART	SIEMENS	
08	CONTROL CABINET	1	CABINET	SIEMENS	
09	CONTROL MONITOR	1	MONITOR	SIEMENS	
10	CONTROL KEYPAD	1	KEYPAD	SIEMENS	
11	CONTROL TRACK	1	TRACK	SIEMENS	
12	CONTROL WHEEL	1	WHEEL	SIEMENS	
13	CONTROL JOYSTICK	1	JOYSTICK	SIEMENS	
14	CONTROL BUTTON	1	BUTTON	SIEMENS	
15	CONTROL SWITCH	1	SWITCH	SIEMENS	
16	CONTROL LEVER	1	LEVER	SIEMENS	
17	CONTROL KNOB	1	KNOB	SIEMENS	
18	CONTROL ROLLER	1	ROLLER	SIEMENS	
19	CONTROL SLIDER	1	SLIDER	SIEMENS	
20	CONTROL TRACKER	1	TRACKER	SIEMENS	
21	CONTROL WHEEL ASSEMBLY	1	ASSEMBLY	SIEMENS	
22	CONTROL JOYSTICK ASSEMBLY	1	ASSEMBLY	SIEMENS	
23	CONTROL BUTTON ASSEMBLY	1	ASSEMBLY	SIEMENS	
24	CONTROL SWITCH ASSEMBLY	1	ASSEMBLY	SIEMENS	
25	CONTROL LEVER ASSEMBLY	1	ASSEMBLY	SIEMENS	
26	CONTROL KNOB ASSEMBLY	1	ASSEMBLY	SIEMENS	
27	CONTROL ROLLER ASSEMBLY	1	ASSEMBLY	SIEMENS	
28	CONTROL SLIDER ASSEMBLY	1	ASSEMBLY	SIEMENS	
29	CONTROL TRACKER ASSEMBLY	1	ASSEMBLY	SIEMENS	
30	CONTROL WHEEL ASSEMBLY	1	ASSEMBLY	SIEMENS	
31	CONTROL JOYSTICK ASSEMBLY	1	ASSEMBLY	SIEMENS	
32	CONTROL BUTTON ASSEMBLY	1	ASSEMBLY	SIEMENS	
33	CONTROL SWITCH ASSEMBLY	1	ASSEMBLY	SIEMENS	
34	CONTROL LEVER ASSEMBLY	1	ASSEMBLY	SIEMENS	
35	CONTROL KNOB ASSEMBLY	1	ASSEMBLY	SIEMENS	
36	CONTROL ROLLER ASSEMBLY	1	ASSEMBLY	SIEMENS	
37	CONTROL SLIDER ASSEMBLY	1	ASSEMBLY	SIEMENS	
38	CONTROL TRACKER ASSEMBLY	1	ASSEMBLY	SIEMENS	
39	CONTROL WHEEL ASSEMBLY	1	ASSEMBLY	SIEMENS	
40	CONTROL JOYSTICK ASSEMBLY	1	ASSEMBLY	SIEMENS	
41	CONTROL BUTTON ASSEMBLY	1	ASSEMBLY	SIEMENS	
42	CONTROL SWITCH ASSEMBLY	1	ASSEMBLY	SIEMENS	
43	CONTROL LEVER ASSEMBLY	1	ASSEMBLY	SIEMENS	
44	CONTROL KNOB ASSEMBLY	1	ASSEMBLY	SIEMENS	
45	CONTROL ROLLER ASSEMBLY	1	ASSEMBLY	SIEMENS	
46	CONTROL SLIDER ASSEMBLY	1	ASSEMBLY	SIEMENS	
47	CONTROL TRACKER ASSEMBLY	1	ASSEMBLY	SIEMENS	
48	CONTROL WHEEL ASSEMBLY	1	ASSEMBLY	SIEMENS	
49	CONTROL JOYSTICK ASSEMBLY	1	ASSEMBLY	SIEMENS	
50	CONTROL BUTTON ASSEMBLY	1	ASSEMBLY	SIEMENS	

NO.	DESCRIPTION	QTY	UNIT	MANUFACTURER	REMARKS
01	ARTIS ZEE BIPLANE ANGIO	1	SYSTEM	SIEMENS	
02	CONTROL CONSOLE	1	CONSOLE	SIEMENS	
03	CONTROL CHAIR	1	CHAIR	SIEMENS	
04	CONTROL PANEL	1	PANEL	SIEMENS	
05	CONTROL TABLE	1	TABLE	SIEMENS	
06	CONTROL STAND	1	STAND	SIEMENS	
07	CONTROL CART	1	CART	SIEMENS	
08	CONTROL CABINET	1	CABINET	SIEMENS	
09	CONTROL MONITOR	1	MONITOR	SIEMENS	
10	CONTROL KEYPAD	1	KEYPAD	SIEMENS	
11	CONTROL TRACK	1	TRACK	SIEMENS	
12	CONTROL WHEEL	1	WHEEL	SIEMENS	
13	CONTROL JOYSTICK	1	JOYSTICK	SIEMENS	
14	CONTROL BUTTON	1	BUTTON	SIEMENS	
15	CONTROL SWITCH	1	SWITCH	SIEMENS	
16	CONTROL LEVER	1	LEVER	SIEMENS	
17	CONTROL KNOB	1	KNOB	SIEMENS	
18	CONTROL ROLLER	1	ROLLER	SIEMENS	
19	CONTROL SLIDER	1	SLIDER	SIEMENS	
20	CONTROL TRACKER	1	TRACKER	SIEMENS	
21	CONTROL WHEEL ASSEMBLY	1	ASSEMBLY	SIEMENS	
22	CONTROL JOYSTICK ASSEMBLY	1	ASSEMBLY	SIEMENS	
23	CONTROL BUTTON ASSEMBLY	1	ASSEMBLY	SIEMENS	
24	CONTROL SWITCH ASSEMBLY	1	ASSEMBLY	SIEMENS	
25	CONTROL LEVER ASSEMBLY	1	ASSEMBLY	SIEMENS	
26	CONTROL KNOB ASSEMBLY	1	ASSEMBLY	SIEMENS	
27	CONTROL ROLLER ASSEMBLY	1	ASSEMBLY	SIEMENS	
28	CONTROL SLIDER ASSEMBLY	1	ASSEMBLY	SIEMENS	
29	CONTROL TRACKER ASSEMBLY	1	ASSEMBLY	SIEMENS	
30	CONTROL WHEEL ASSEMBLY	1	ASSEMBLY	SIEMENS	
31	CONTROL JOYSTICK ASSEMBLY	1	ASSEMBLY	SIEMENS	
32	CONTROL BUTTON ASSEMBLY	1	ASSEMBLY	SIEMENS	
33	CONTROL SWITCH ASSEMBLY	1	ASSEMBLY	SIEMENS	
34	CONTROL LEVER ASSEMBLY	1	ASSEMBLY	SIEMENS	
35	CONTROL KNOB ASSEMBLY	1	ASSEMBLY	SIEMENS	
36	CONTROL ROLLER ASSEMBLY	1	ASSEMBLY	SIEMENS	
37	CONTROL SLIDER ASSEMBLY	1	ASSEMBLY	SIEMENS	
38	CONTROL TRACKER ASSEMBLY	1	ASSEMBLY	SIEMENS	
39	CONTROL WHEEL ASSEMBLY	1	ASSEMBLY	SIEMENS	
40	CONTROL JOYSTICK ASSEMBLY	1	ASSEMBLY	SIEMENS	
41	CONTROL BUTTON ASSEMBLY	1	ASSEMBLY	SIEMENS	
42	CONTROL SWITCH ASSEMBLY	1	ASSEMBLY	SIEMENS	
43	CONTROL LEVER ASSEMBLY	1	ASSEMBLY	SIEMENS	
44	CONTROL KNOB ASSEMBLY	1	ASSEMBLY	SIEMENS	
45	CONTROL ROLLER ASSEMBLY	1	ASSEMBLY	SIEMENS	
46	CONTROL SLIDER ASSEMBLY	1	ASSEMBLY	SIEMENS	
47	CONTROL TRACKER ASSEMBLY	1	ASSEMBLY	SIEMENS	
48	CONTROL WHEEL ASSEMBLY	1	ASSEMBLY	SIEMENS	
49	CONTROL JOYSTICK ASSEMBLY	1	ASSEMBLY	SIEMENS	
50	CONTROL BUTTON ASSEMBLY	1	ASSEMBLY	SIEMENS	

NO.	DESCRIPTION	QTY	UNIT	MANUFACTURER	REMARKS
01	ARTIS ZEE BIPLANE ANGIO	1	SYSTEM	SIEMENS	
02	CONTROL CONSOLE	1	CONSOLE	SIEMENS	
03	CONTROL CHAIR	1	CHAIR	SIEMENS	
04	CONTROL PANEL	1	PANEL	SIEMENS	
05	CONTROL TABLE	1	TABLE	SIEMENS	
06	CONTROL STAND	1	STAND	SIEMENS	
07	CONTROL CART	1	CART	SIEMENS	
08	CONTROL CABINET	1	CABINET	SIEMENS	
09	CONTROL MONITOR	1	MONITOR	SIEMENS	
10	CONTROL KEYPAD	1	KEYPAD	SIEMENS	
11	CONTROL TRACK	1	TRACK	SIEMENS	
12	CONTROL WHEEL	1	WHEEL	SIEMENS	
13	CONTROL JOYSTICK	1	JOYSTICK	SIEMENS	
14	CONTROL BUTTON	1	BUTTON	SIEMENS	
15	CONTROL SWITCH	1	SWITCH	SIEMENS	
16	CONTROL LEVER	1	LEVER	SIEMENS	
17	CONTROL KNOB	1	KNOB	SIEMENS	
18	CONTROL ROLLER	1	ROLLER	SIEMENS	
19	CONTROL SLIDER	1	SLIDER	SIEMENS	
20	CONTROL TRACKER	1	TRACKER	SIEMENS	
21	CONTROL WHEEL ASSEMBLY	1	ASSEMBLY	SIEMENS	
22	CONTROL JOYSTICK ASSEMBLY	1	ASSEMBLY	SIEMENS	
23	CONTROL BUTTON ASSEMBLY	1	ASSEMBLY	SIEMENS	
24	CONTROL SWITCH ASSEMBLY	1	ASSEMBLY	SIEMENS	
25	CONTROL LEVER ASSEMBLY	1	ASSEMBLY	SIEMENS	
26	CONTROL KNOB ASSEMBLY	1	ASSEMBLY	SIEMENS	
27	CONTROL ROLLER ASSEMBLY	1	ASSEMBLY	SIEMENS	
28	CONTROL SLIDER ASSEMBLY	1	ASSEMBLY	SIEMENS	
29	CONTROL TRACKER ASSEMBLY	1	ASSEMBLY	SIEMENS	
30	CONTROL WHEEL ASSEMBLY	1	ASSEMBLY	SIEMENS	
31	CONTROL JOYSTICK ASSEMBLY	1	ASSEMBLY	SIEMENS	
32	CONTROL BUTTON ASSEMBLY	1	ASSEMBLY	SIEMENS	
33	CONTROL SWITCH ASSEMBLY	1	ASSEMBLY	SIEMENS	
34	CONTROL LEVER ASSEMBLY	1	ASSEMBLY	SIEMENS	
35	CONTROL KNOB ASSEMBLY	1	ASSEMBLY	SIEMENS	
36	CONTROL ROLLER ASSEMBLY	1	ASSEMBLY	SIEMENS	
37	CONTROL SLIDER ASSEMBLY	1	ASSEMBLY	SIEMENS	
38	CONTROL TRACKER ASSEMBLY	1	ASSEMBLY	SIEMENS	
39	CONTROL WHEEL ASSEMBLY	1	ASSEMBLY	SIEMENS	
40	CONTROL JOYSTICK ASSEMBLY	1	ASSEMBLY	SIEMENS	
41	CONTROL BUTTON ASSEMBLY	1	ASSEMBLY	SIEMENS	
42	CONTROL SWITCH ASSEMBLY	1	ASSEMBLY	SIEMENS	
43	CONTROL LEVER ASSEMBLY	1	ASSEMBLY	SIEMENS	
44	CONTROL KNOB ASSEMBLY	1	ASSEMBLY	SIEMENS	
45	CONTROL ROLLER ASSEMBLY	1	ASSEMBLY	SIEMENS	
46	CONTROL SLIDER ASSEMBLY	1	ASSEMBLY	SIEMENS	
47	CONTROL TRACKER ASSEMBLY	1	ASSEMBLY	SIEMENS	
48	CONTROL WHEEL ASSEMBLY	1	ASSEMBLY	SIEMENS	
49	CONTROL JOYSTICK ASSEMBLY	1	ASSEMBLY	SIEMENS	
50	CONTROL BUTTON ASSEMBLY	1	ASSEMBLY	SIEMENS	

NO.	DESCRIPTION	QTY	UNIT	MANUFACTURER	REMARKS
01	ARTIS ZEE BIPLANE ANGIO	1	SYSTEM	SIEMENS	
02	CONTROL CONSOLE	1	CONSOLE	SIEMENS	
03	CONTROL CHAIR	1	CHAIR	SIEMENS	
04	CONTROL PANEL	1	PANEL	SIEMENS	
05	CONTROL TABLE	1	TABLE	SIEMENS	
06	CONTROL STAND	1	STAND	SIEMENS	
07	CONTROL CART	1	CART	SIEMENS	
08	CONTROL CABINET	1	CABINET	SIEMENS	
09	CONTROL MONITOR	1	MONITOR	SIEMENS	
10	CONTROL KEYPAD	1	KEYPAD	SIEMENS	
11	CONTROL TRACK	1	TRACK	SIEMENS	
12	CONTROL WHEEL	1	WHEEL	SIEMENS	
13	CONTROL JOYSTICK	1	JOYSTICK	SIEMENS	
14	CONTROL BUTTON	1	BUTTON	SIEMENS	
15	CONTROL SWITCH	1	SWITCH	SIEMENS	
16	CONTROL LEVER	1	LEVER	SIEMENS	
17	CONTROL KNOB	1	KNOB	SIEMENS	
18	CONTROL ROLLER	1	ROLLER	SIEMENS	
19	CONTROL SLIDER	1	SLIDER	SIEMENS	
20	CONTROL TRACKER	1	TRACKER	SIEMENS	
21	CONTROL WHEEL ASSEMBLY	1	ASSEMBLY	SIEMENS	
22	CONTROL JOYSTICK ASSEMBLY	1	ASSEMBLY	SIEMENS	
23	CONTROL BUTTON ASSEMBLY	1	ASSEMBLY	SIEMENS	
24	CONTROL SWITCH ASSEMBLY	1	ASSEMBLY	SIEMENS	
25	CONTROL LEVER ASSEMBLY	1	ASSEMBLY	SIEMENS	
26	CONTROL KNOB ASSEMBLY	1	ASSEMBLY	SIEMENS	
27	CONTROL ROLLER ASSEMBLY	1	ASSEMBLY	SIEMENS	
28	CONTROL SLIDER ASSEMBLY	1	ASSEMBLY	SIEMENS	
29	CONTROL TRACKER ASSEMBLY	1	ASSEMBLY	SIEMENS	
30	CONTROL WHEEL ASSEMBLY	1	ASSEMBLY	SIEMENS	
31	CONTROL JOYSTICK ASSEMBLY	1	ASSEMBLY	SIEMENS	
32	CONTROL BUTTON ASSEMBLY	1	ASSEMBLY	SIEMENS	
33	CONTROL SWITCH ASSEMBLY	1	ASSEMBLY	SIEMENS	
34	CONTROL LEVER ASSEMBLY	1	ASSEMBLY	SIEMENS	
35	CONTROL KNOB ASSEMBLY	1	ASSEMBLY	SIEMENS	
36	CONTROL ROLLER ASSEMBLY	1	ASSEMBLY	SIEMENS	
37	CONTROL SLIDER ASSEMBLY	1	ASSEMBLY	SIEMENS	
38	CONTROL TRACKER ASSEMBLY	1	ASSEMBLY	SIEMENS	
39	CONTROL WHEEL ASSEMBLY	1	ASSEMBLY	SIEMENS	
40	CONTROL JOYSTICK ASSEMBLY	1	ASSEMBLY	SIEMENS	
41	CONTROL BUTTON ASSEMBLY	1	ASSEMBLY	SIEMENS	