


# MAINE MEDICAL CENTER

22 Bramhall St  
Portland, ME 04102

## PBC SUITE - ARTIS ZEE MULTI-PURPOSE

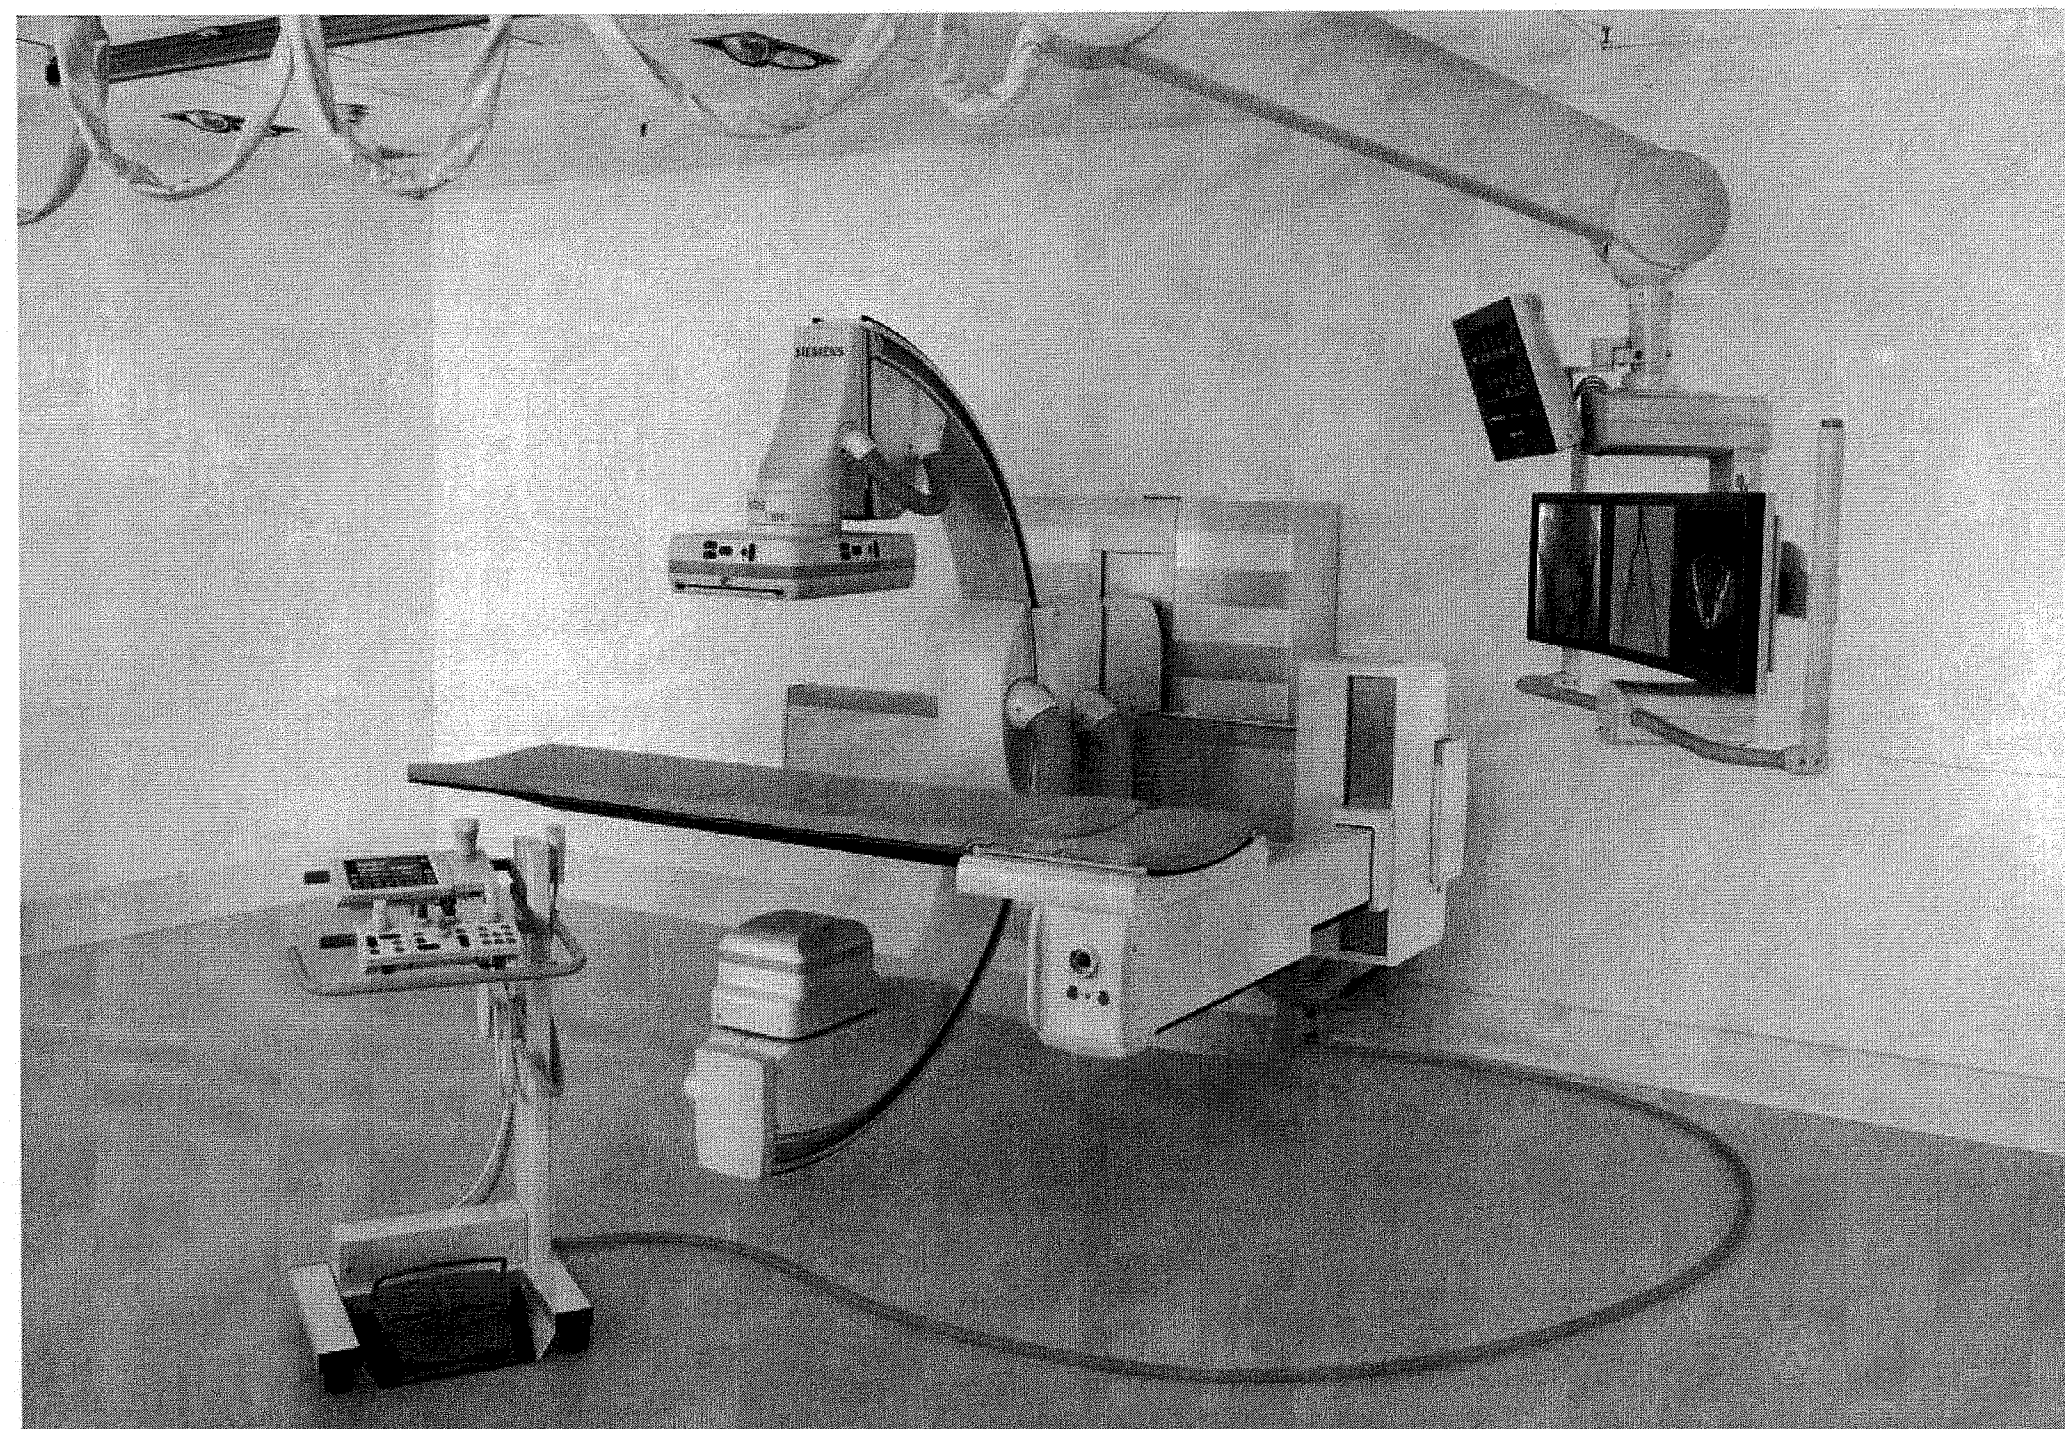

### Contents:

Sheet No.	Description
A-101	EQUIPMENT LAYOUT-DETAILS, LEGEND, AND NOTES
A-102	REFLECTED CEILING, SAFETY/SERVICE CLEARANCE PLAN
S-101	STRUCTURAL FLOOR PLAN-DETAILS AND NOTES
S-102	STRUCTURAL CEILING PLAN-DETAILS AND NOTES
E-101	ELECTRICAL PLAN(S)-LEGEND AND NOTES
E-102	ELECTRICAL PLAN-LEGEND AND NOTES
E-501	ELECTRICAL DETAILS AND NOTES
M-101	MECHANICAL PLAN-DETAILS AND NOTES

### Project Contacts:

**Siemens**  
Project Manager  
Rich Deister  
Phone: (207) 712-3205  
  
rich.deister@siemens.com

Planner  
Joan Paolucci

Project #: 1102468

**SIEMENS**  
**SIEMENS MEDICAL SOLUTIONS**  
51 Valley Stream Parkway  
Malvern, PA 19355  
[www.usa.siemens.com/medical](http://www.usa.siemens.com/medical)

MAINE MEDICAL CENTER



PBC SUITE - ARTIS ZEE MULTI-PURPOSE  
URPOSE

Issue #: 0  
Date: 01/04/12

**SIEMENS**

144 Fore Street, P.O. Box 618  
Portland, Maine 04104  
Tel: (207) 772-3846  
Fax: (207) 772-5100  
www.smrt.com

ARCHITECTURE  
ENGINEERING  
PLANNING  
INTERIOR DESIGN  
COMMISSIONING

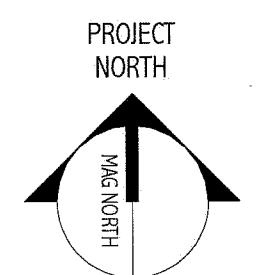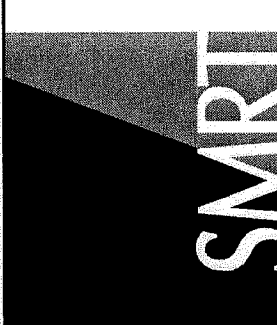

MAINE MEDICAL CENTER  
HOLDING, RADCU & PBC RENOVATION  
PORTLAND, ME

ISSUED FOR CONSTRUCTION  
02.24.12

CURRENT BASE STATUS:

REV	DESCRIPTION	DATE

GRAPHIC SCALE:  
0' 1'  
SCALE:  
PROJECT MANAGER: ND  
DRAWN BY:  
DATE OF RECORD: DIV  
PROJECT NO: 11063  
DATE: 2.24.12

SHEET TITLE:  
VENDOR EQUIPMENT  
DRAWINGS SHEET 1

SHEET No. Q-001

NOTE: THIS DRAWING WAS NOT PREPARED BY SMRT. IT IS PROVIDED FOR COORDINATION AND REFERENCE PURPOSES ONLY.