

**GENERAL NOTE:**

- SEE SHEET FP001 FOR LEGEND AND ABBREVIATIONS.

**DEMOLITION KEYED NOTES:**


- REMOVE PORTION OF PRE-ACTION SPRINKLER PIPING SERVICING LINAC ROOM. PIPING RELOCATED TO PROVIDE ADEQUATE SERVICE ACCESS FOR NEW AIR HANDLING UNIT.
- REMOVE EXISTING PARTIAL SPRINKLER SYSTEM IN THIS AREA BACK TO MAINS.

**KEYED NOTES:**

- RE-ROUTE LINAC ROOM PRE-ACTION SPRINKLER PIPING
- EXTEND EXISTING SPRINKLER SYSTEM INTO NUC. MED AREA AND PROVIDE NEW FCVA TO SERVE SMOKE COMPARTMENT. FIELD VERIFY CONNECTION POINT TO EXISTING SPRINKLER MAIN.
- PROVIDE SPRINKLER COVERAGE THROUGHOUT IN ACCORDANCE WITH NFPA 13.
- EXISTING ROOM IS NOT BEING RENOVATED AS PART OF THIS PROJECT. PROVIDE CAPPED OUTLET PROVISIONS FOR FUTURE INSTALL OF SPRINKLERS IN NEXT PHASE OF RENOVATION.
- REWORK EXISTING SPRINKLER PROTECTION AS REQUIRED FOR INSTALLATION OF NEW MECHANICAL DUCTWORK AND ARCHITECTURAL CEILING MODIFICATIONS.


**G1 FIRE PROTECTION DEMOLITION PLAN**

1/8"=1'-0"

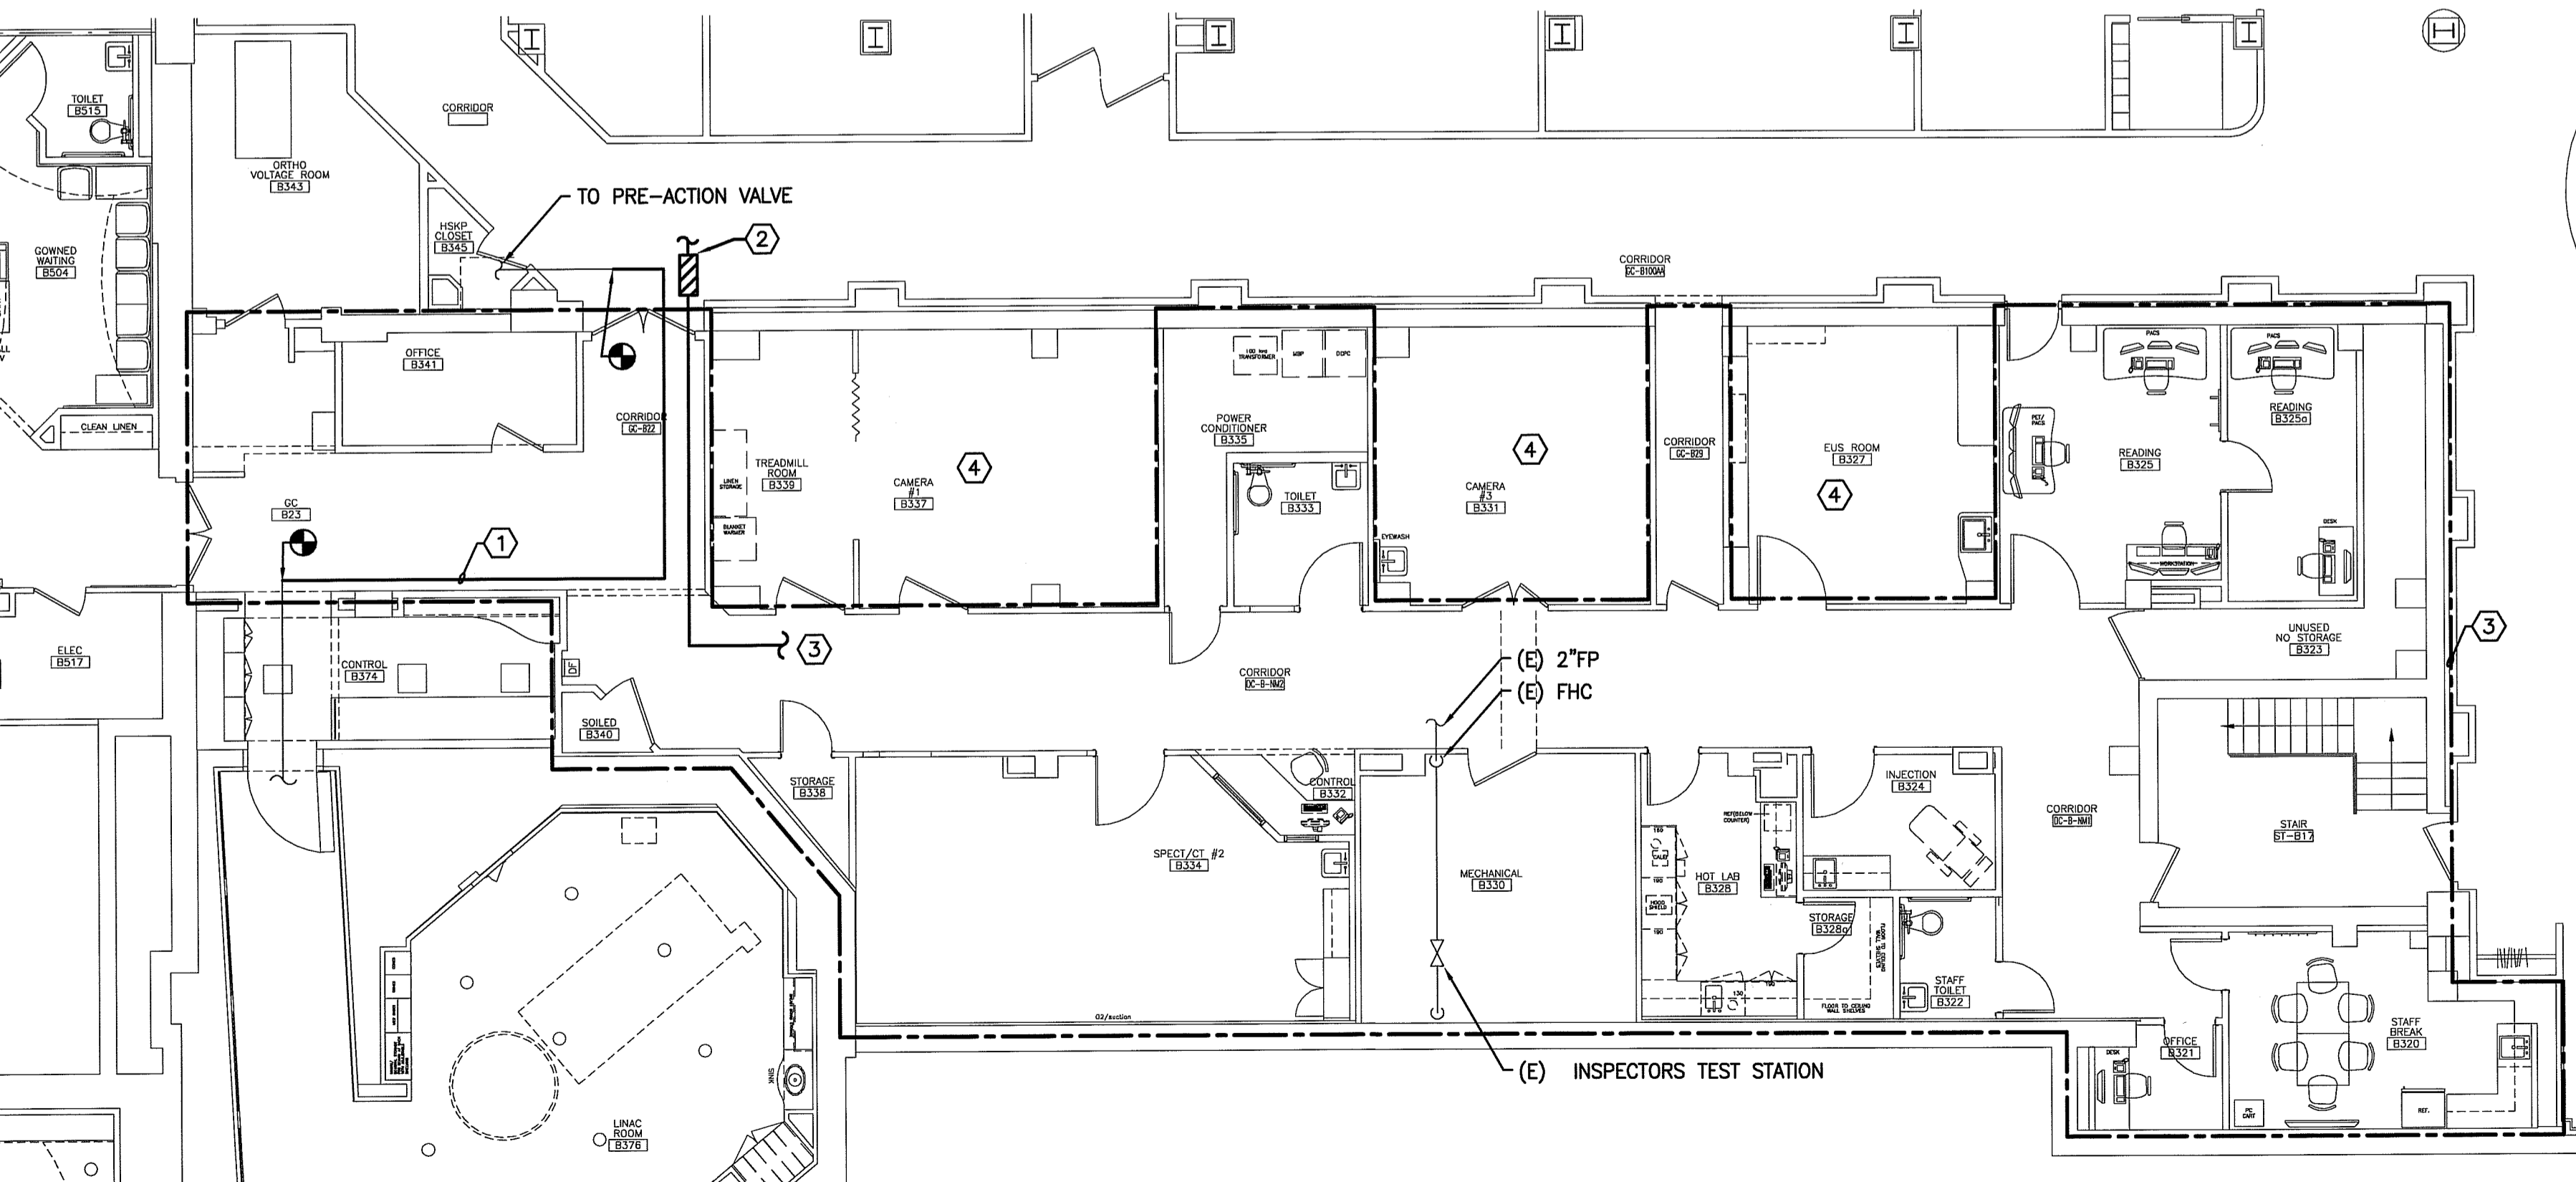

**A1 FIRE PROTECTION NEW WORK PLAN**

1/8"=1'-0"



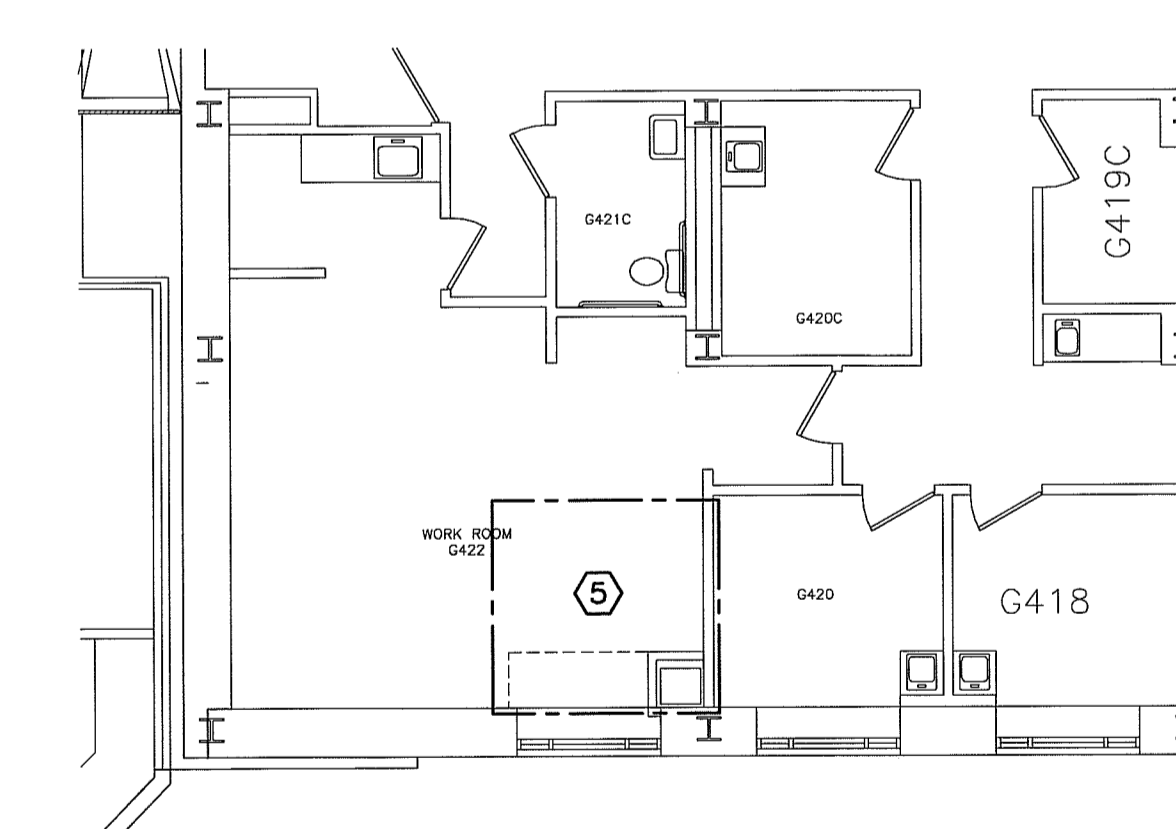


**A12 FIRE PROTECTION GROUND FLOOR PART PLAN**

1/8"=1'-0"

144 Fore Street/P.O. Box 618  
Portland, Maine 04104  
Tel: (207) 772-3846  
Fax: (207) 772-1070  
www.smrtdinc.com

ARCHITECTURE  
ENGINEERING  
PLANNING  
INTERIOR DESIGN  
COMMISSIONING

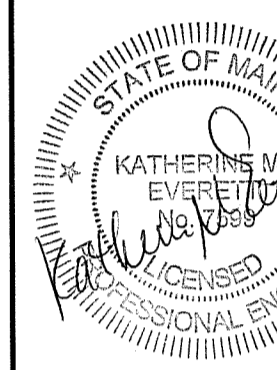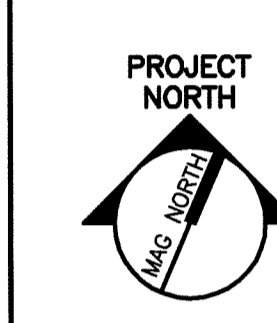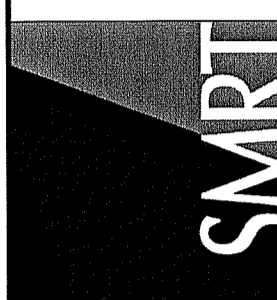

**MAINE MEDICAL CENTER  
NUCLEAR MEDICINE RENOVATIONS**  
PORTLAND, MAINE

**ISSUED FOR CONSTRUCTION 3-13-14**

REV	DESCRIPTION	DATE
0	ISSUED FOR CONSTRUCTION	3-13-14

GRAPHIC SCALE:  
0" = 1"

SCALE: 1/8"=1'-0"  
PROJECT MANAGER: DJV  
JC/DRAWN BY: MP  
A/E OF RECORD: KME  
CAD FILE: FP101-13128  
PROJECT NO: 13128  
DATE: 3-13-14

SHEET TITLE:  
**FIRE PROTECTION  
DEMOLITION AND  
NEW WORK PLANS**

SHEET No.  
**FP101**

© COPYRIGHT 2013 SMRT INC.