

MAINE MEDICAL CENTER RADIATION THERAPY GOWNED WAITING ROOM RENOVATION PORTLAND, MAINE

DRAWING LIST

GENERAL	COVER SHEET
GI001	COVER SHEET
ARCHITECTURAL	
A-001	PARTIAL NDF FLOOR PLAN
AD101	PARTIAL DEMOLITION PLAN
AD102	PARTIAL DEMOLITION PLAN
AE101	PARTIAL FLOOR PLAN
AE102	PARTIAL FLOOR PLAN
AE103	PARTIAL REFLECTED CEILING PLAN
AE104	PARTIAL REFLECTED CEILING PLAN
AE201	INTERIOR ELEVATIONS
AE202	INTERIOR ELEVATIONS
AE203	CASEWORK DETAIL
AE204	CASEWORK DETAIL
AE205	CASEWORK DETAIL
AE601	SCHEDULES
AF101	FLOOR FINISH PLAN
AF102	FLOOR FINISH PLAN
MECHANICAL AND PLUMBING	
M-001	LEGEND AND ABBREVIATIONS
M-002	SPECIFICATIONS
MD101	HVAC DEMOLITION PLAN
MD102	HVAC DEMOLITION PLAN
MH101	HVAC PARTIAL FLOOR PLAN
MH102	HVAC PARTIAL FLOOR PLAN
M-501	DETAILS
M-601	SCHEDULES
PD101	PLUMBING DEMOLITION PLAN
PD102	PLUMBING DEMOLITION PLAN
PL101	PLUMBING PLAN
PL102	PLUMBING PLAN
PL601	SCHEDULES
ELECTRICAL	
E-001	LEGEND AND GENERAL NOTES
ED101	PARTIAL DEMOLITION PLAN
ED102	PARTIAL DEMOLITION PLAN
EP100	OVERALL POWER PLAN
EP101	PARTIAL FLOOR PLAN POWER
EP102	PARTIAL FLOOR PLAN POWER
EL101	PARTIAL FLOOR PLAN LIGHTING
EL102	PARTIAL FLOOR PLAN LIGHTING
EY101	PARTIAL FLOOR PLAN SYSTEMS
EY102	PARTIAL FLOOR PLAN SYSTEMS
EL601	LIGHTING SCHEDULE


GENERAL NOTES:

- FIELD VERIFY ALL DIMENSIONS AND LAYOUT PRIOR TO PROCEEDING WITH WORK. NOTIFY ARCHITECT IN WRITING OF ANY DISCREPANCIES OR INCONSISTENCIES. FAILURE TO REPORT ANY DISCREPANCIES WITHIN THESE CONSTRUCTION DOCUMENTS TO THE ARCHITECT WILL NOT BE GROUNDS FOR ADDITIONAL COST OR CHANGE ORDERS.
- "PROVIDE" MEANS "FURNISH AND INSTALL".
- THE CONTRACTOR SHALL BE RESPONSIBLE FOR PROVIDING ALL MATERIALS (UNLESS NOTED OTHERWISE), AND WORKMANSHIP IN ACCORDANCE WITH FEDERAL, STATE, CITY AND LOCAL BUILDING CODES AND THEIR REQUIREMENTS.
- THE CONTRACTOR AND ALL TRADES SHALL NOTE REQUIREMENTS OF "GENERAL NOTES" ON ALL SHEETS.
- CONTRACTOR TO CONFIRM EXISTING WALL RATINGS.
- REFER TO ALL CONSTRUCTION DOCUMENTS FOR REQUIREMENTS WHICH MAY AFFECT THE WORK IN ANOTHER DISCIPLINE AND COORDINATE WORK.
- PROVIDE BLOCKING IN WALLS AS NECESSARY WHERE CASEWORK, SHELVES, HANDRAILS, AND MISC. EQUIPMENT ARE LOCATED.
- PATCH ALL HOLES, WALLS AND CRACKS IN ROOMS TO RECEIVE NEW PAINT.


PARTITION NOTES:

- PARTITION TYPE DRAWINGS ARE GRAPHIC REPRESENTATION ONLY, THEY ARE NOT TO SCALE TYPICAL.
- ALL BLANKET INSULATION IS TO BE FULL THICKNESS AND FULL HEIGHT UNLESS NOTED OTHERWISE.
- REFERENCE FLOOR PLANS AND ROOM FINISH SCHEDULES FOR ADDITIONAL FIRE RATING AND FINISH INFORMATION.
- REFERENCE DOOR AND WINDOW TAGS FOR FRAME TYPES AND DETAILS.
- REFERENCE PLANS FOR PARTITION TAGS.

KEY PLAN:

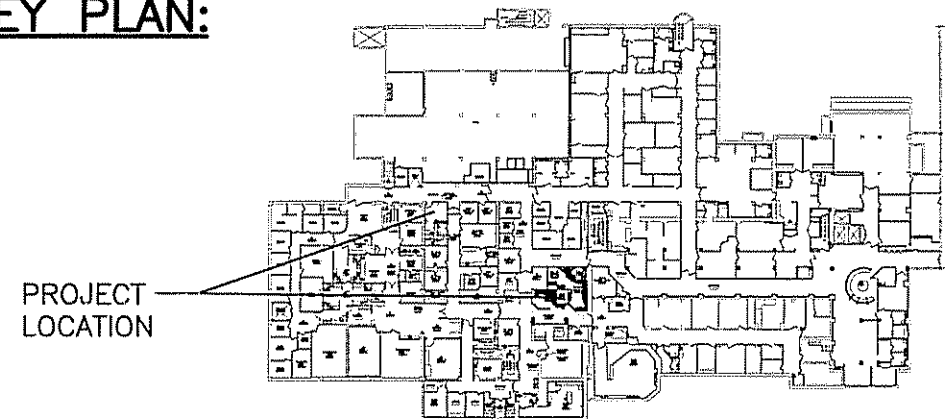

PARTITION LEGEND

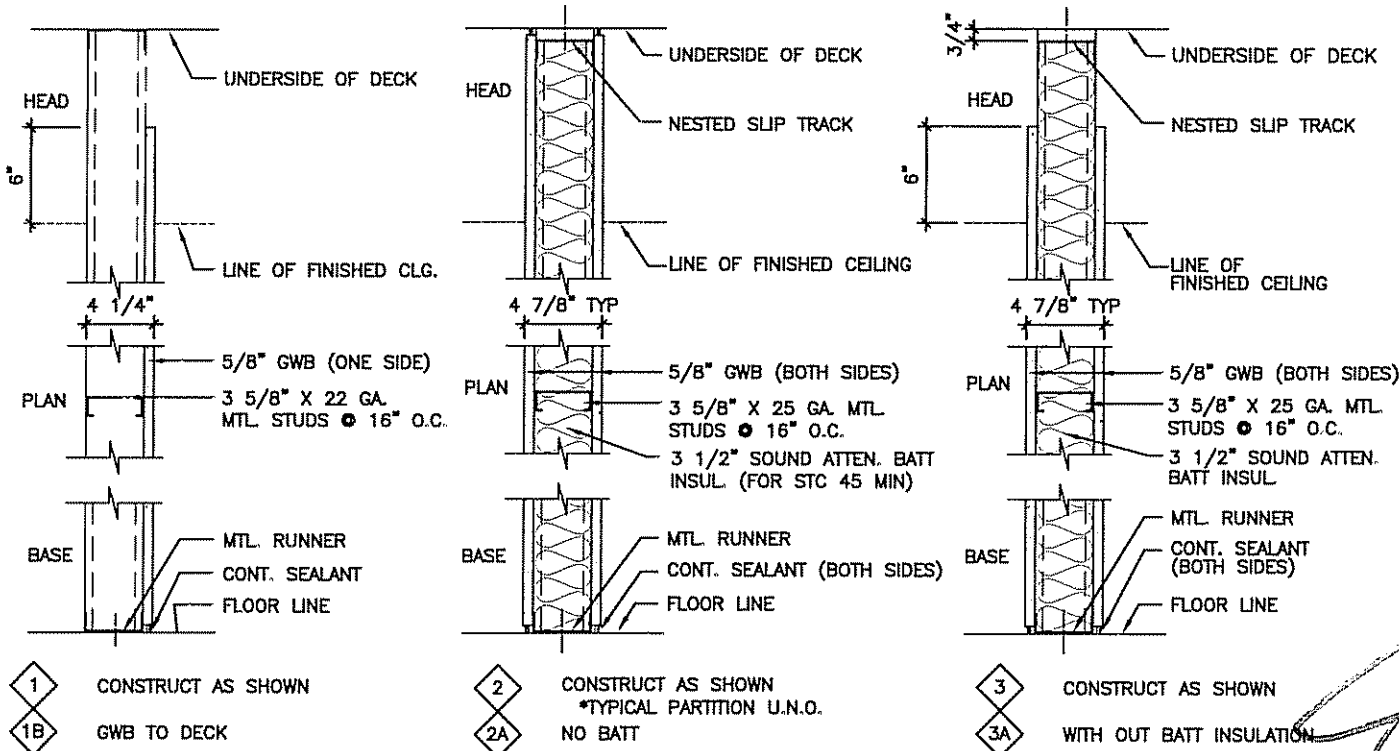

ISSUED FOR CONSTRUCTION	12-8-06	DATE
REV	DESCRIPTION	
0		

PROJECT: MAINE MEDICAL CENTER
RADIATION THERAPY RENOVATIONS
PORTLAND, MAINE

SHEET TITLE: COVER SHEET

PROJECT NORTH

ISSUED FOR CONSTRUCTION
12-8-06

SCALE: 1/4"=1'-0"

JC/DRAWN BY: MDR

A/E OF RECORD: CDP

SMRT CAD FILE: GI001-05133-02

PROJECT No: 06043

DATE: 12-8-06

SHEET No. GI001



© COPYRIGHT 2006 SMRT INC.

LICENSED ARCHITECT
CRAIG DAVID
PIPER
No. 2692
STATE OF MAINE


12.8.06



ARCHITECTURE ENGINEERING PLANNING
SMRT
144 Fore Street/P.O. Box 618 PORTLAND, MAINE 04104
tel. (207) 772-3846 / fax. (207) 772-1070

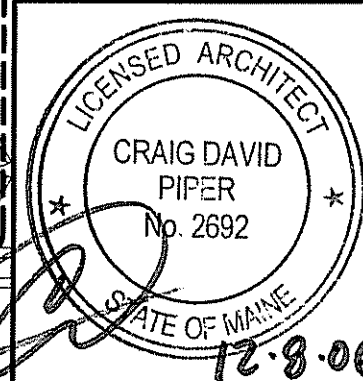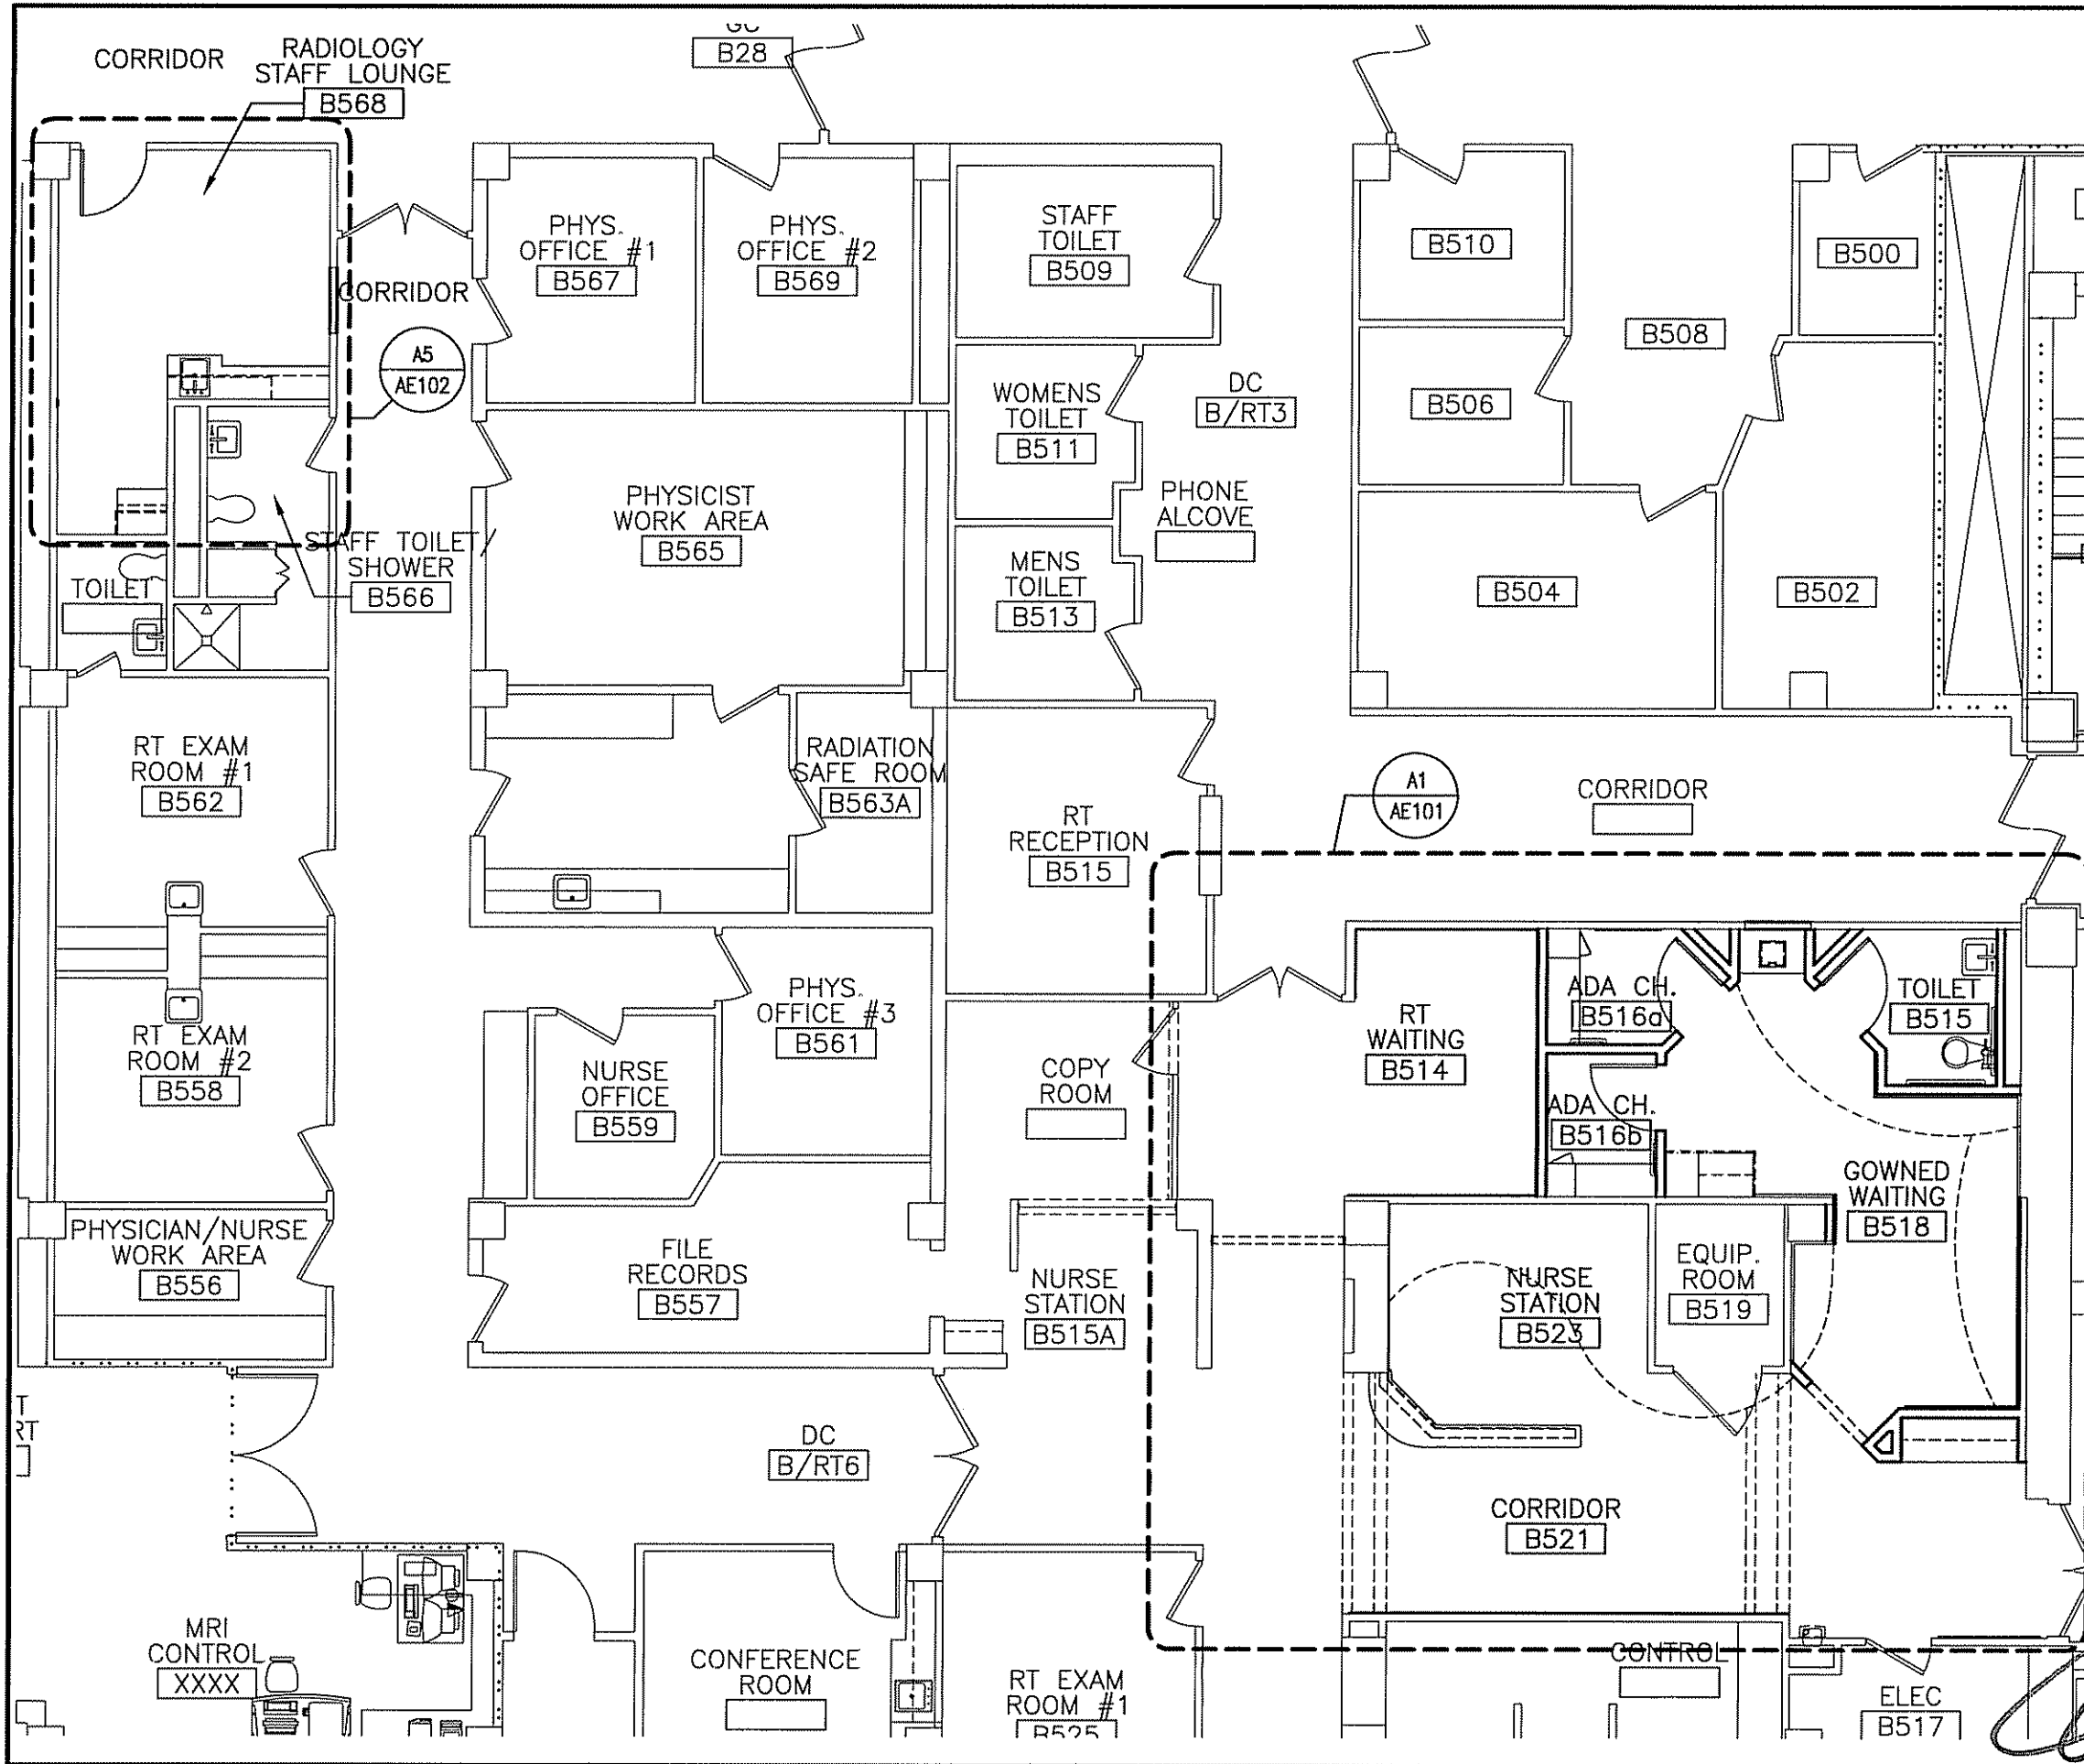

ISSUED FOR CONSTRUCTION 12-8-06		PROJECT NORTH 	PROJECT No: 06043 DATE: 12-8-06
PROJECT: MAINE MEDICAL CENTER RADIATION THERAPY RENOVATIONS PORTLAND, MAINE	SHEET TITLE: PARTIAL NDF FLOOR PLAN	MDR CDP A-001-06043 06043	12-8-06
SCALE: 1/8" = 1'-0" PROJECT MANAGER: CDP SHEET No. A-001	JC/DRAWN BY: A/E OF RECORD: SMRT CAD FILE: A-001-06043 PROJECT No: 06043 DATE: 12-8-06	PROJECT No: 06043 DATE: 12-8-06	12-8-06
CURRENT ISSUED STATUS: ISSUED FOR CONSTRUCTION 12-8-06	PROJECT: MAINE MEDICAL CENTER RADIATION THERAPY RENOVATIONS PORTLAND, MAINE	SHEET TITLE: PARTIAL NDF FLOOR PLAN	PROJECT No: 06043 DATE: 12-8-06
REV 0 ISSUED FOR CONSTRUCTION DATE 12-8-06	DESCRIPTION ARCHITECTURE ENGINEERING PLANNING SMRT 144 Fore Street/P.O. Box 618 PORTLAND, MAINE 04104 tel. (207) 772-3846 / fax. (207) 772-1070	SM RT	DATE 12-8-06

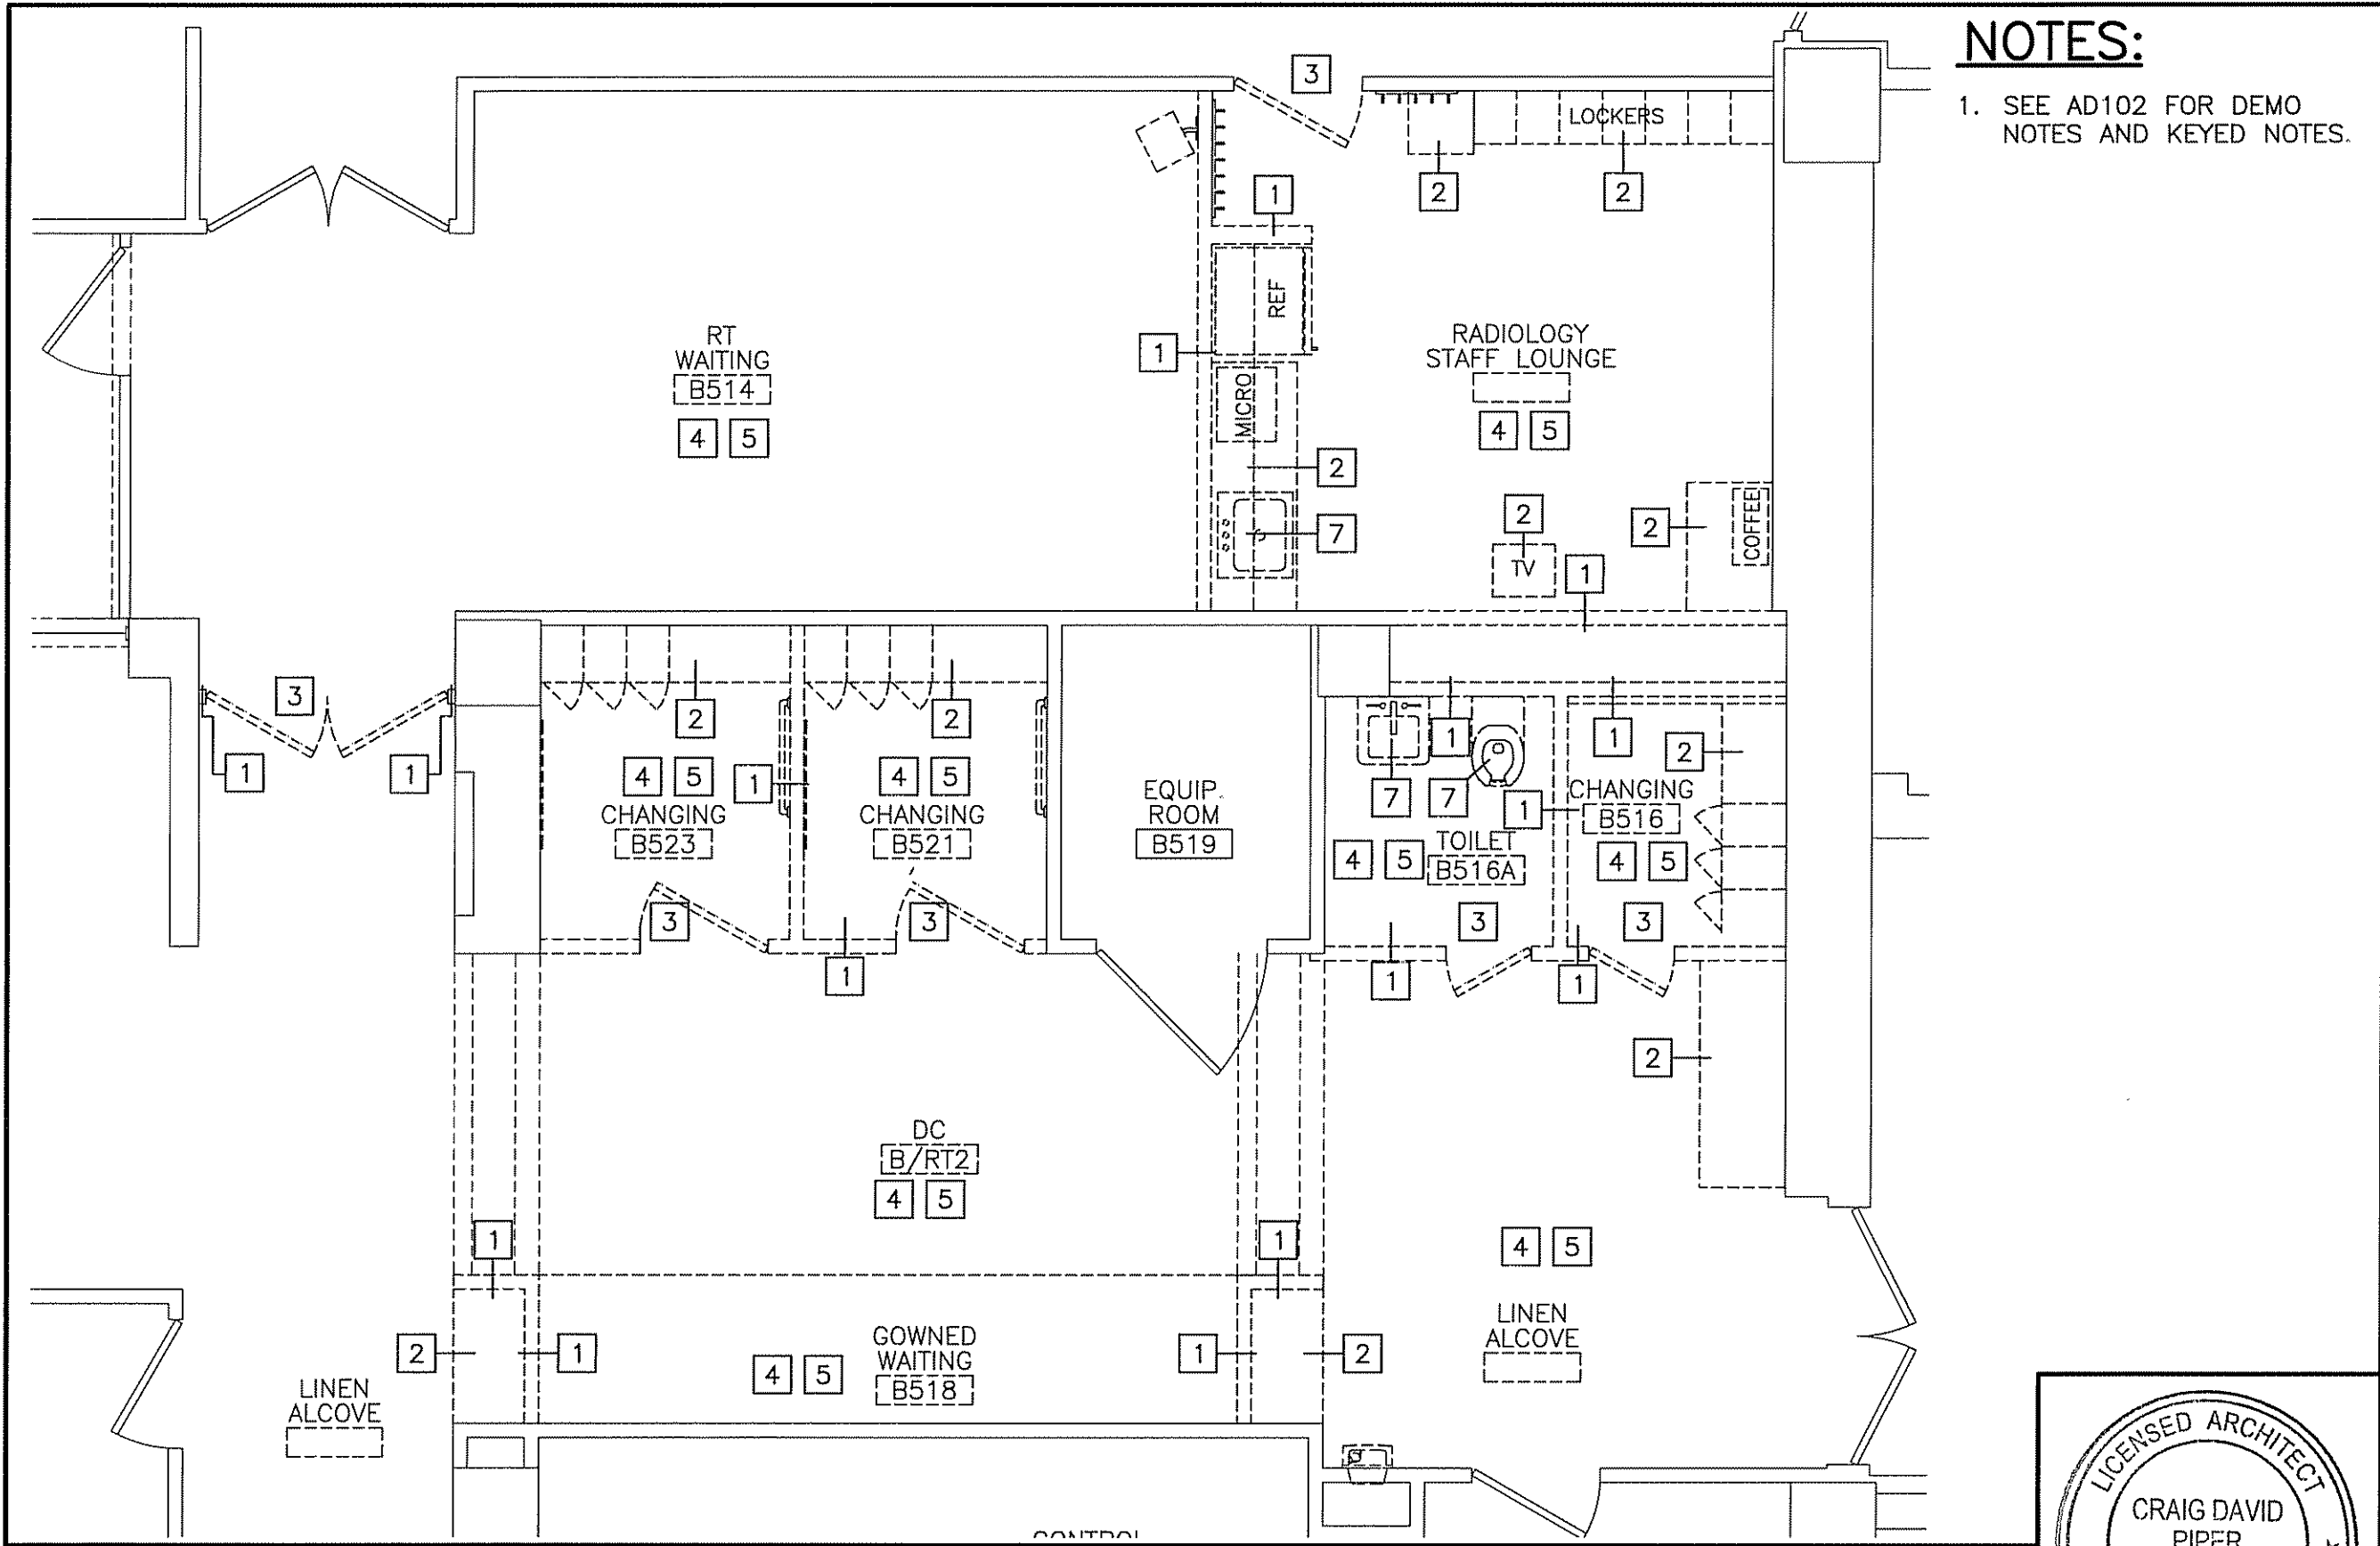


NOTES:
 1. SEE AD102 FOR DEMO NOTES AND KEYED NOTES.

ISSUED FOR CONSTRUCTION	12-8-06	DATE
REV	DESCRIPTION	
0		

ARCHITECTURE ENGINEERING PLANNING
 SMRT
 144 Fore Street/P.O. Box 618 PORTLAND, MAINE 04104
 tel. (207) 772-3846 / fax. (207) 772-1070

PROJECT: MAINE MEDICAL CENTER RADIATION THERAPY RENOVATIONS PORTLAND, MAINE

SHEET TITLE: PARTIAL DEMOLITION PLAN

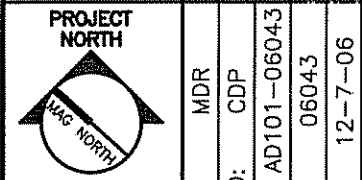

JC/DRAWN BY: MDR
 A/E OF RECORD: CDP
 SMRT CAD FILE: AD101-06043
 PROJECT No: 06043
 DATE: 12-7-06


CURRENT ISSUED STATUS: ISSUED FOR CONSTRUCTION 12-8-06

SCALE: 1/4"=1'-0"

PROJECT MANAGER: CDP

SHEET No. AD101

© COPYRIGHT 2008 SMRT INC.

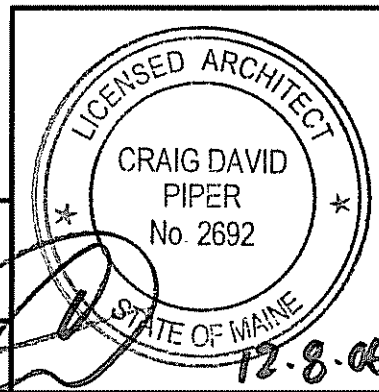

A1
 1/4"=1'-0"

PARTIAL DEMOLITION PLAN


*

DEMOLITION KEY NOTES:

- 1 REMOVE PARTITION COMPLETE.
- 2 REMOVE EXISTING CASEWORK COMPLETE.
- 3 REMOVE DOOR, FRAME AND HARDWARE COMPLETE.
- 4 REMOVE CEILING TILE AND GRID ASSEMBLY COMPLETE. COORDINATE EXTENTS OF REMOVAL WITH PARTITION LOCATIONS AND EXISTING FINISHES TO REMAIN.
- 5 REMOVE EXISTING FLOOR COMPLETE. PREPARE FOR INSTALLATION OF NEW.
- 6 REMOVE PORTION OF PARTITION FOR INSTALLATION OF DOOR. COORDINATE EXTENTS WITH FINISHES TO REMAIN. REFERENCE DOOR SCHEDULE.
- 7 REMOVE/RELOCATE EXISTING FIXTURE. REFERENCE MECHANICAL/ELECTRICAL.
- 8 EXISTING CEILING SYSTEM TO BE REMOVED & REPLACED TO ALLOW MECHANICAL WORK TO BE PERFORMED.
- 9 REMOVE EXISTING WALL TILE COMPLETE, AND PREPARE SURFACE FOR PTD.


GENERAL DEMOLITION NOTES:

- 1. COORDINATE EXTENT OF DEMOLITION WITH LOCATIONS OF PARTITIONS DESCRIBED ON PLANS AND WITH LOCATIONS OF FINISHES NOTED AS EXISTING TO REMAIN.
- 2. ANY WALL, PARTITION OR SURFACE DISTURBED BECAUSE OF NEW WORK OR DEMOLITION SHALL BE PATCHED AND FINISHED CONTINUOUSLY TO THE NEAREST CORNER UNLESS NOTED OTHERWISE, MATCH EXISTING ADJACENT CONSTRUCTION FINISHES, CONTINUITY AND FIRE RATINGS UNLESS NOTED OTHERWISE.
- 3. PROTECT ALL FINISHES, MATERIALS AND EQUIPMENT NOTED AS EXISTING TO REMAIN. CONTRACTOR SHALL BE RESPONSIBLE TO REPLACE ALL FINISHES, MATERIALS AND EQUIPMENT DAMAGED DURING CONSTRUCTION.
- 4. DIMENSIONS INDICATED ± ARE EXISTING CONDITION DIMENSIONS TO BE VERIFIED IN FIELD.

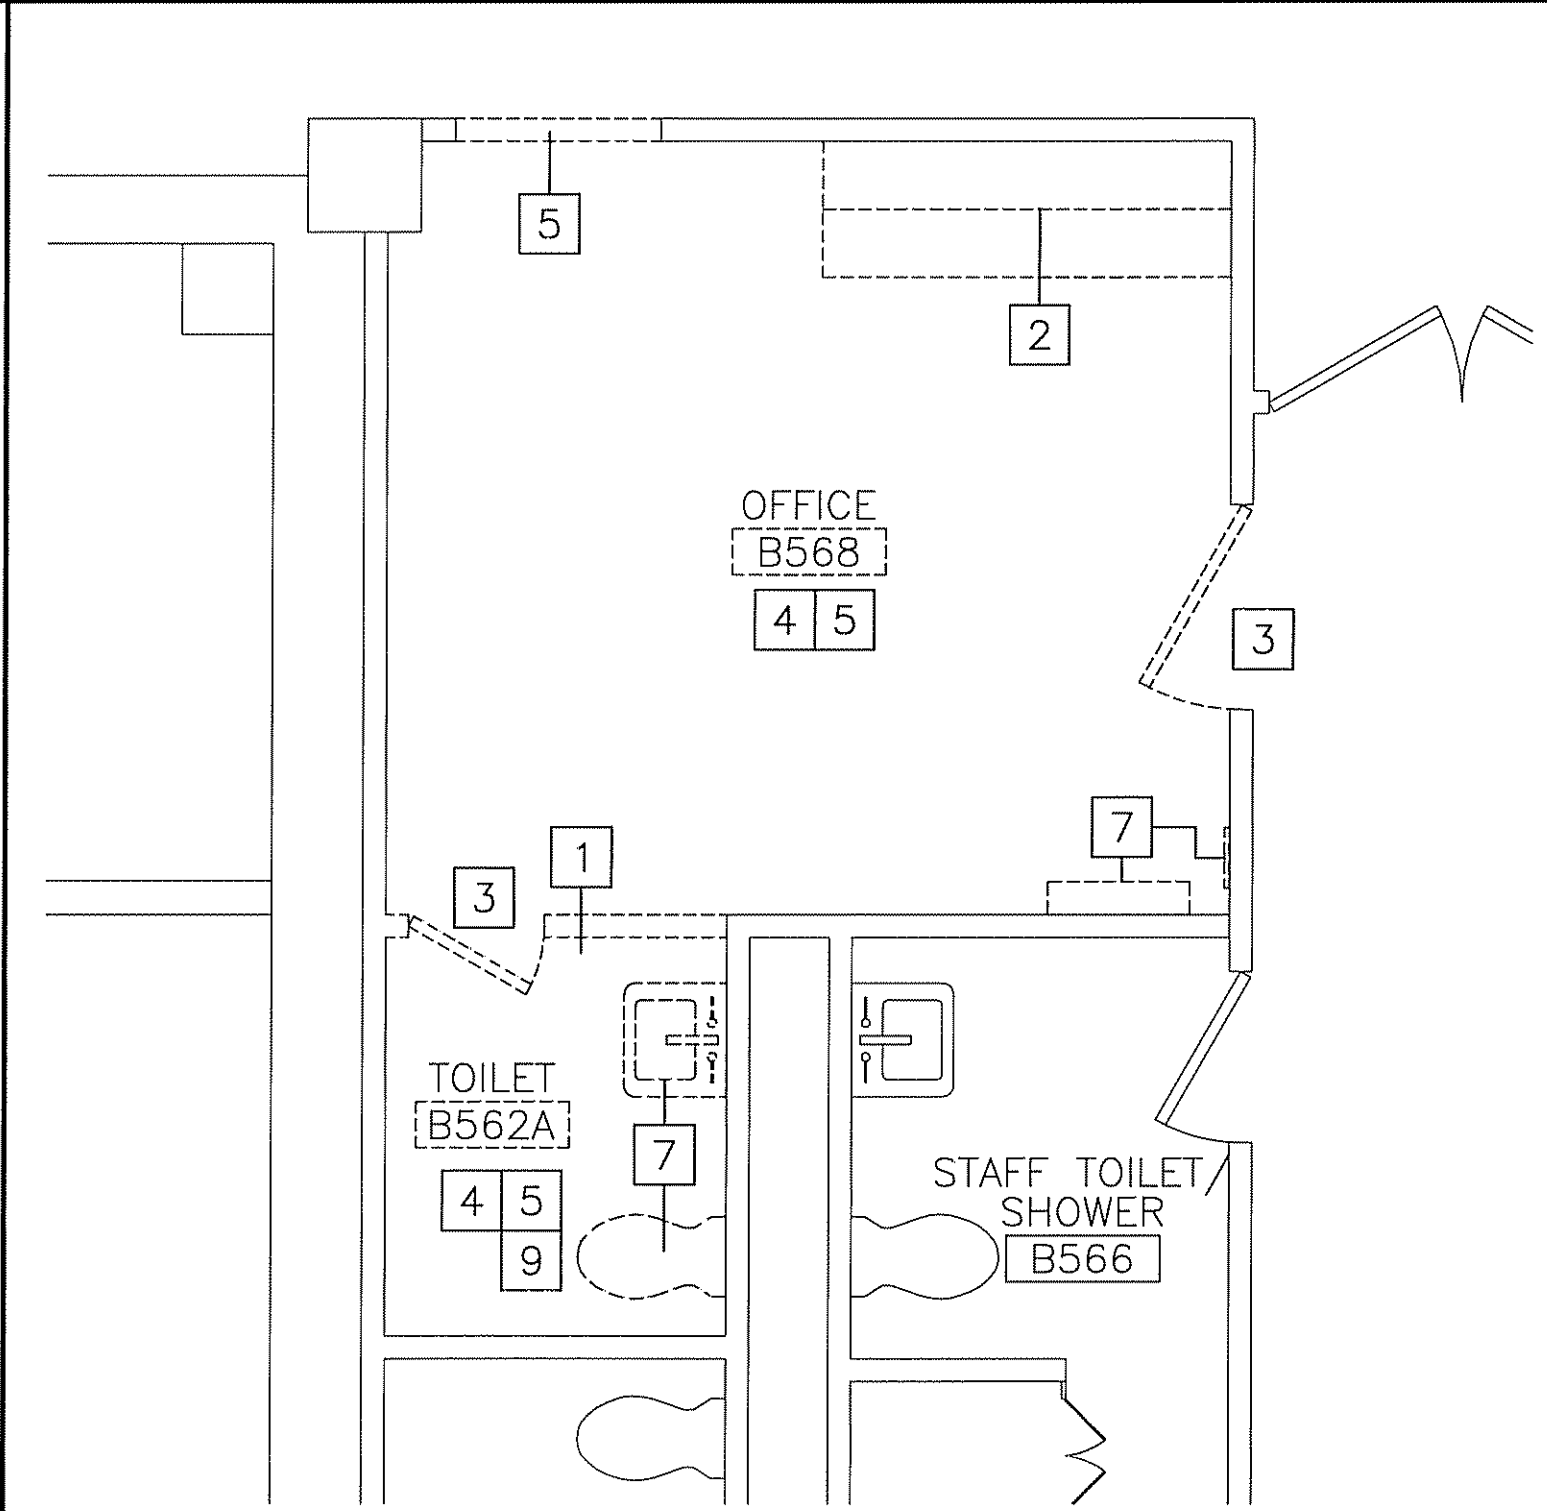


A5
1/4"=1'-0"

PARTIAL DEMOLITION PLAN
*

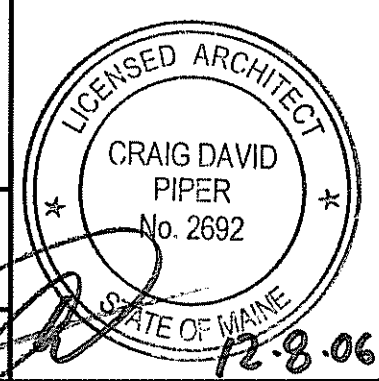

CURRENT ISSUED STATUS: ISSUED FOR CONSTRUCTION 12-8-06		SCALE: 1/4"=1'-0"	JC/DRAWN BY: MDR	MDR	DATE: 12-8-06
PROJECT MANAGER: CDP	A/E OF RECORD: CDP	PROJECT No. AD102	SMRT CAD FILE: AD102-06043	CDP	
PROJECT: MAINE MEDICAL CENTER RADIATION THERAPY RENOVATIONS PORTLAND, MAINE		SHEET TITLE: PARTIAL DEMOLITION PLAN		PROJECT No. 06043	
PROJECT: MAINE MEDICAL CENTER RADIATION THERAPY RENOVATIONS PORTLAND, MAINE		SHEET TITLE: PARTIAL DEMOLITION PLAN		DATE: 12-8-06	
ISSUED FOR CONSTRUCTION 12-8-06		PROJECT No. AD102		DATE: 12-8-06	
REV 0		DESCRIPTION		DATE 12-8-06	
<p>ARCHITECTURE ENGINEERING PLANNING SMRT 144 Fore Street/P.O. Box 618 PORTLAND, MAINE 04104 tel. (207) 772-3846 / fax. (207) 772-1070</p>					

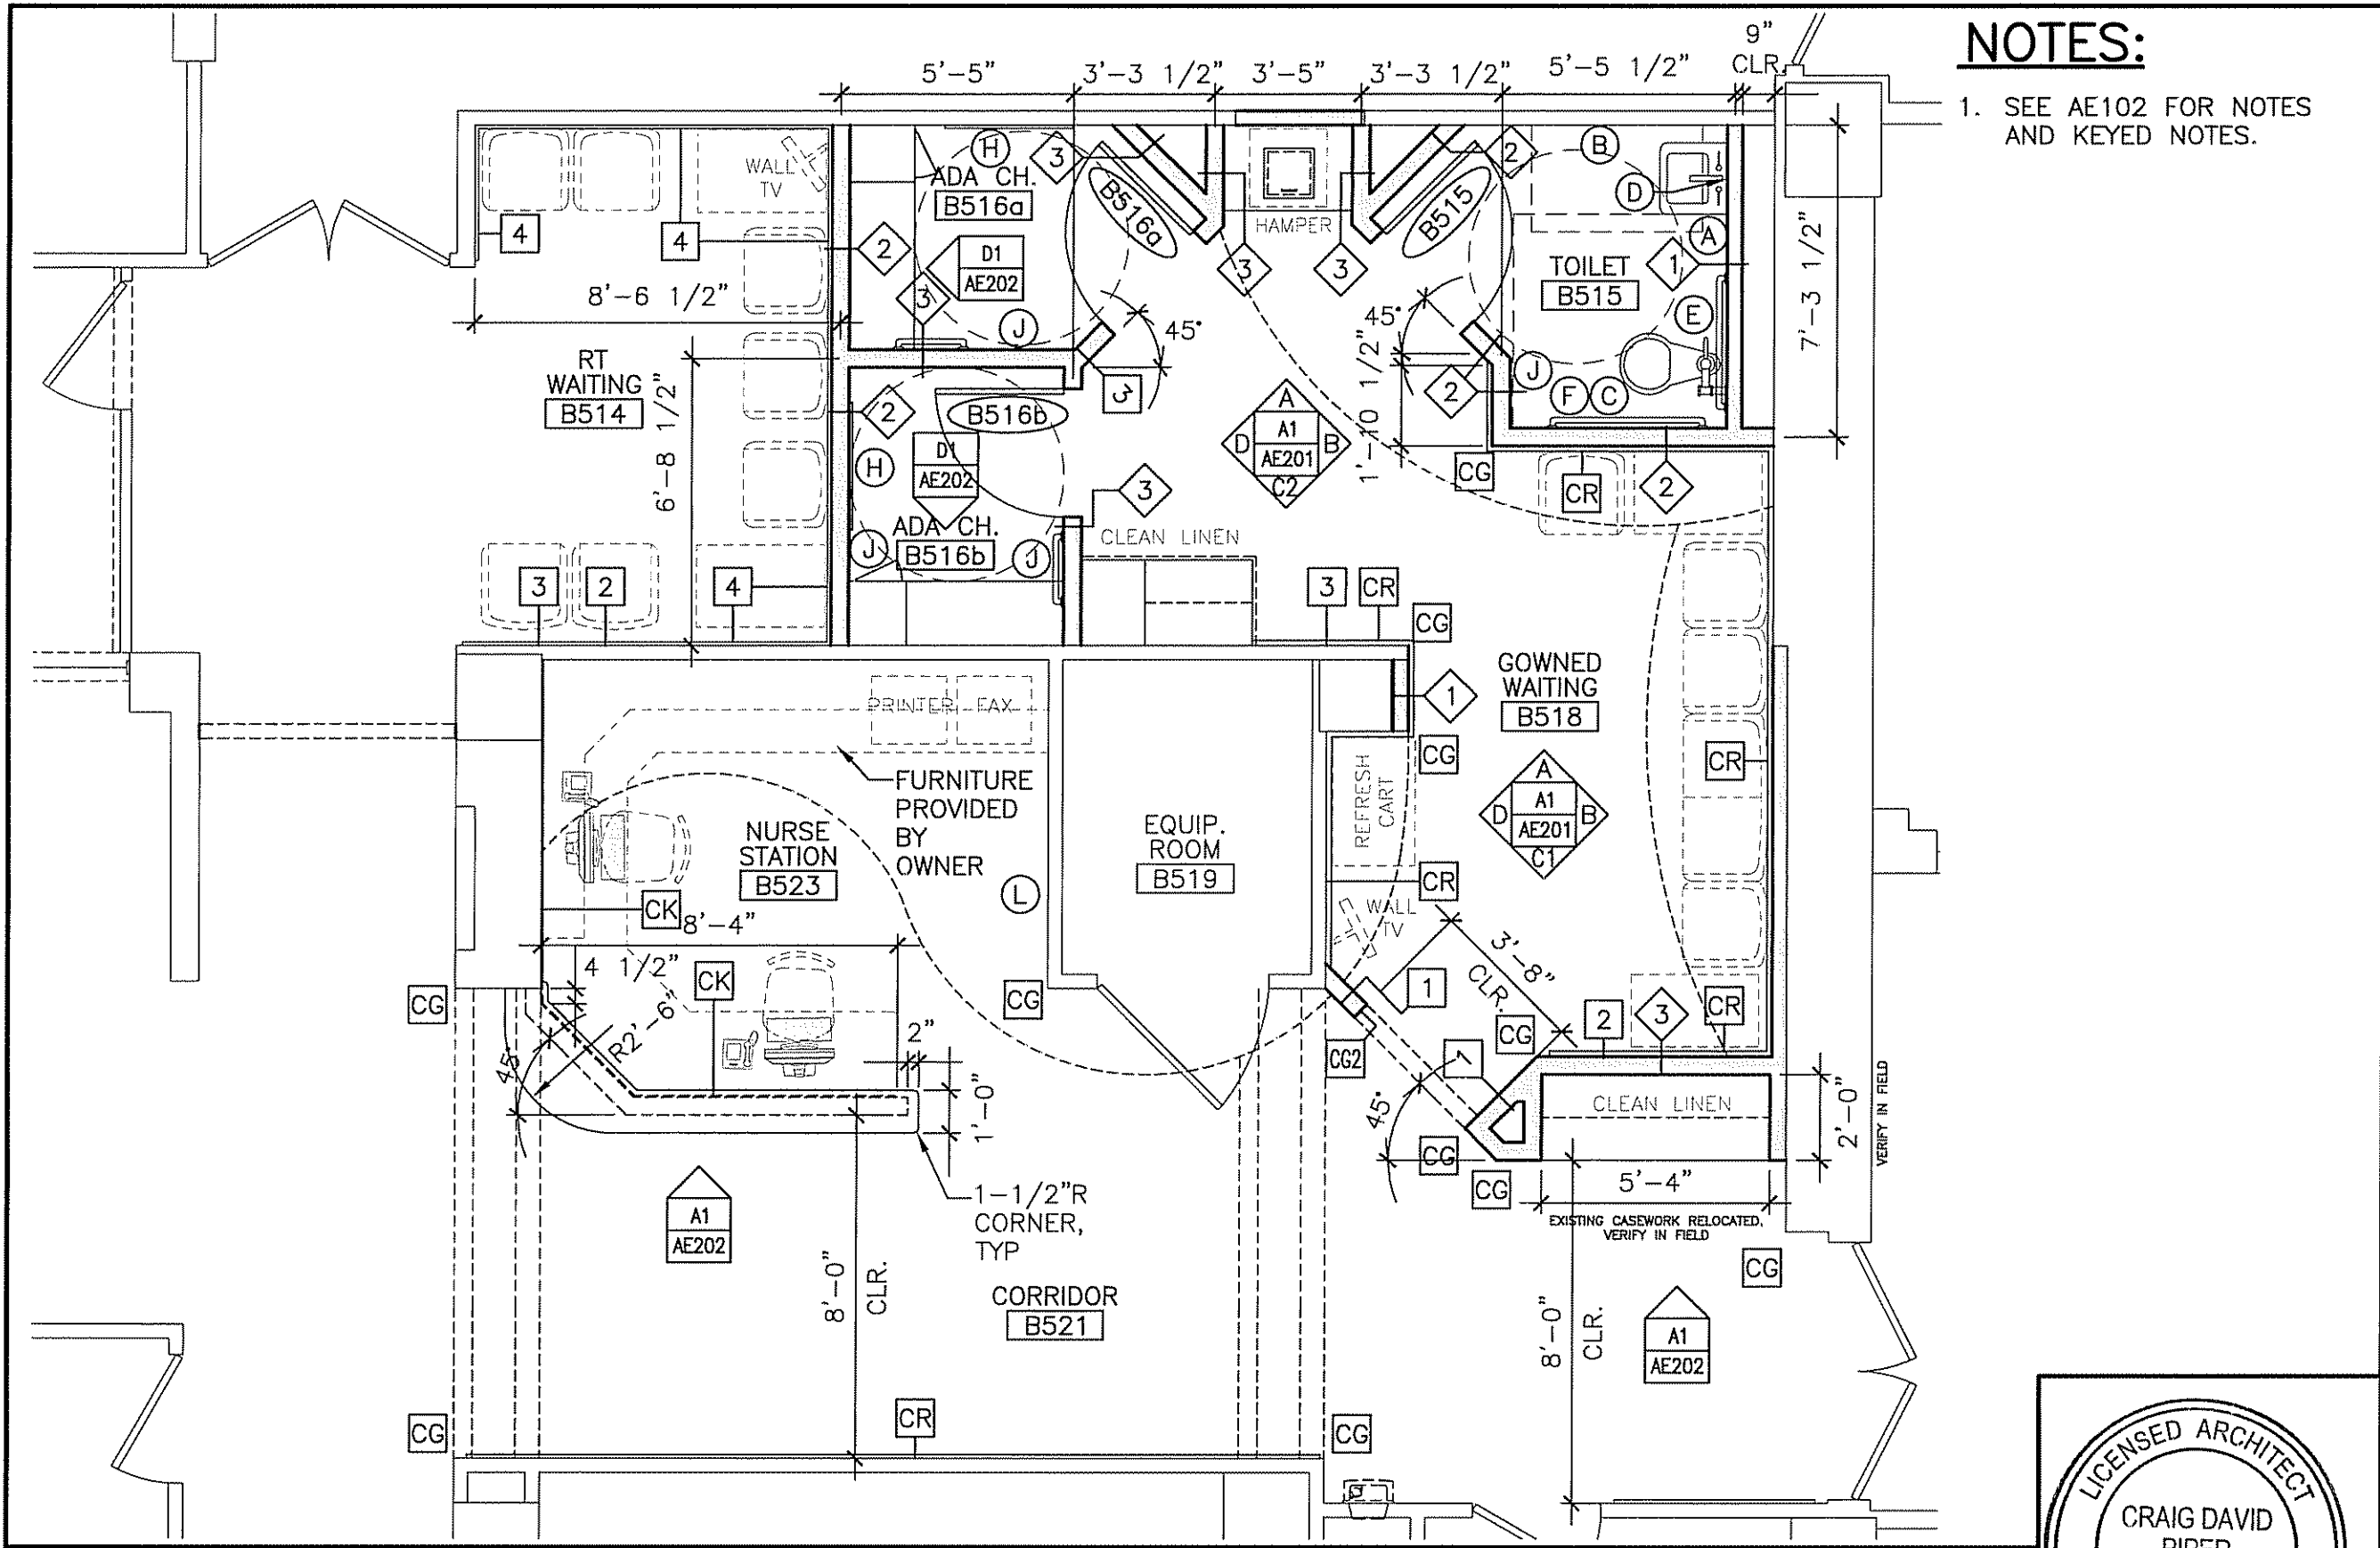


NOTES:
 1. SEE AE102 FOR NOTES AND KEYED NOTES.

0	ISSUED FOR CONSTRUCTION	12-8-06	DATE
REV	DESCRIPTION		

SM
RT
 ARCHITECTURE ENGINEERING PLANNING
 SMART
 144 Fore Street, P.O. Box 618 PORTLAND, MAINE 04104
 tel. (207) 772-3846 / fax. (207) 772-1070

PROJECT: MAINE MEDICAL CENTER RADIATION THERAPY RENOVATIONS
 PORTLAND, MAINE

SHEET TITLE: PARTIAL FLOOR PLAN

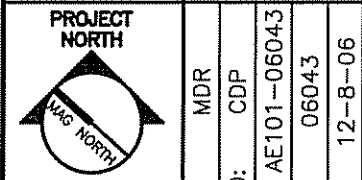

CURRENT ISSUED STATUS: **ISSUED FOR CONSTRUCTION 12-8-06**

SCALE: 1/4"=1'-0"

PROJECT MANAGER: CDP

SHEET No. AE101


JC/DRAWN BY: MDR

A/E OF RECORD: CDP

SMART CAD FILE: AE101-06043

PROJECT No: 06043

DATE: 12-8-06

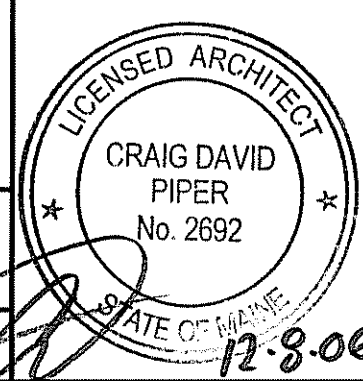


A1

1/4"=1'-0"

 




PARTIAL FLOOR PLAN

*





NOTES:

1. SEE GENERAL NOTES ON A-001.
2. FURNITURE DASHED IN BY OTHERS IS INDICATED FOR COORDINATION AND BLOCKING.
3. PARTITION TYPE  IS TYPICAL UNLESS NOTED OTHERWISE.

WALL LEGEND

-  PARTITION TYPE, SEE G1001
-  INDICATES NEW PARTITION/ WALL
-  CORNER GUARD, INSTALL 4" ABOVE FLOOR
-  WOOD CHAIR RAIL, SEE D5/AE204
-  CORK BOARD, BETWEEN DESK SURFACE AND WALL CABINET OR COUNTER AT PART. HEIGHT WALL. EQUAL TO MANTON, ROLLED, 1/4" THICK

  
KEYED NOTES:

-  WALL MOUNT TV(NIC), PROVIDE BLOCKING
-  MAGAZINE RACK
-  EDUCATIONAL MATERIAL RACK
-  EXISTING CHAIR RAIL TO REMAIN, CUT AND RE-INSTALL AS REQUIRED

ACCESSORY SCHEDULE

TAG	DESCRIPTION	
(A)	SOAP DISPENSER	C/C
(B)	PAPER TOWEL DISPENSER	C/C
(C)	TOILET PAPER DISPENSER	C/C
(D)	MIRROR 18" x 30"	C/C
(E)	36" GRAB BAR	C/C
(F)	42" GRAB BAR	C/C
(G)	ROBE/COAT HOOK	C/C
(H)	WALL MIRROR, EXISTING RELOCATE	O/C
(J)	(2) COAT HOOKS, SEE DETAIL	C/C
(K)	EXISTING RELOCATED GRAB BAR	O/C
(L)	EXISTING RELOCATED BULLETIN BOARDS	O/C

C/C - CONTRACTOR FURNISHED/CONTRACTOR INSTALLED
 O/C - OWNER FURNISHED/CONTRACTOR INSTALLED
 O/O - OWNER FURNISHED/OWNER INSTALLED
 (CONTRACTOR SHALL PROVIDE BLOCKING IN WALL)

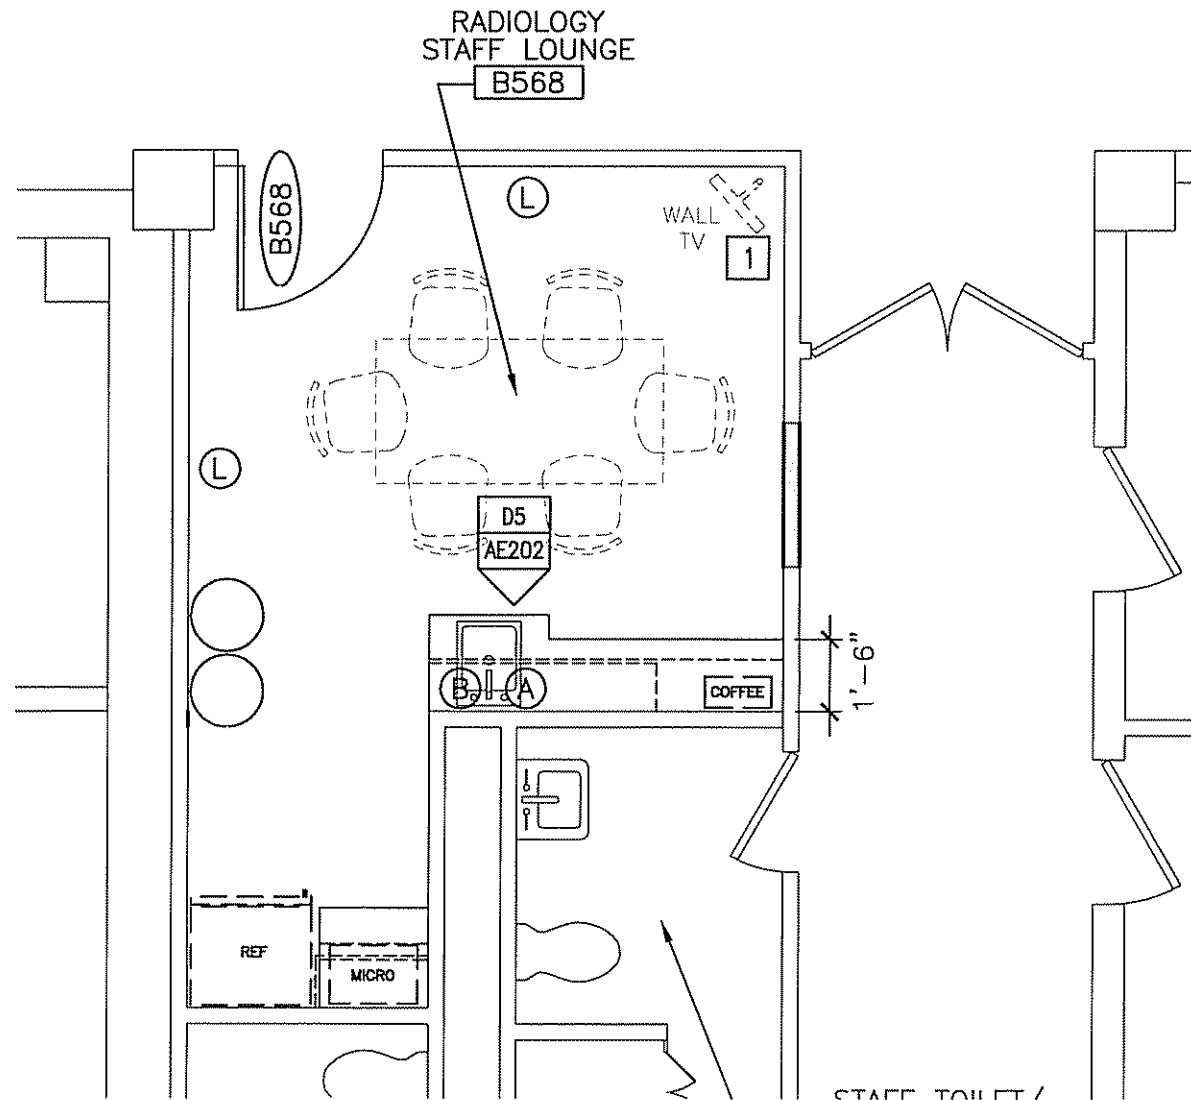



A5


PARTIAL FLOOR PLAN

1/4"=1'-0"

*

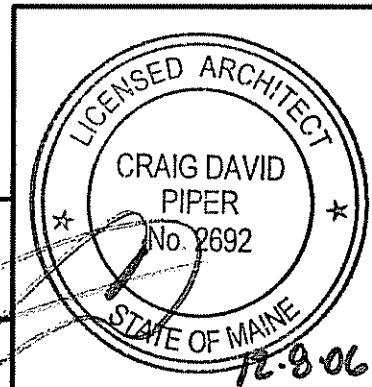

PROJECT: MAINE MEDICAL CENTER RADIATION THERAPY RENOVATIONS PORTLAND, MAINE		SHEET TITLE: PARTIAL FLOOR PLAN	
CURRENT ISSUED STATUS: ISSUED FOR CONSTRUCTION 12-8-06		SCALE: 1/4"=1'-0"	
PROJECT MANAGER: CDP	JC/DRAWN BY: MDR	A/E OF RECORD: CDP	MDR
SHEET No. AE102	SMRT CAD FILE: AE102-06043	PROJECT No: 06043	DATE: 12-8-06
 ARCHITECTURE ENGINEERING PLANNING SMRT 144 Fore Street/P.O. Box 618 PORTLAND, MAINE 04104 tel. (207) 772-3846 / fax. (207) 772-1070			

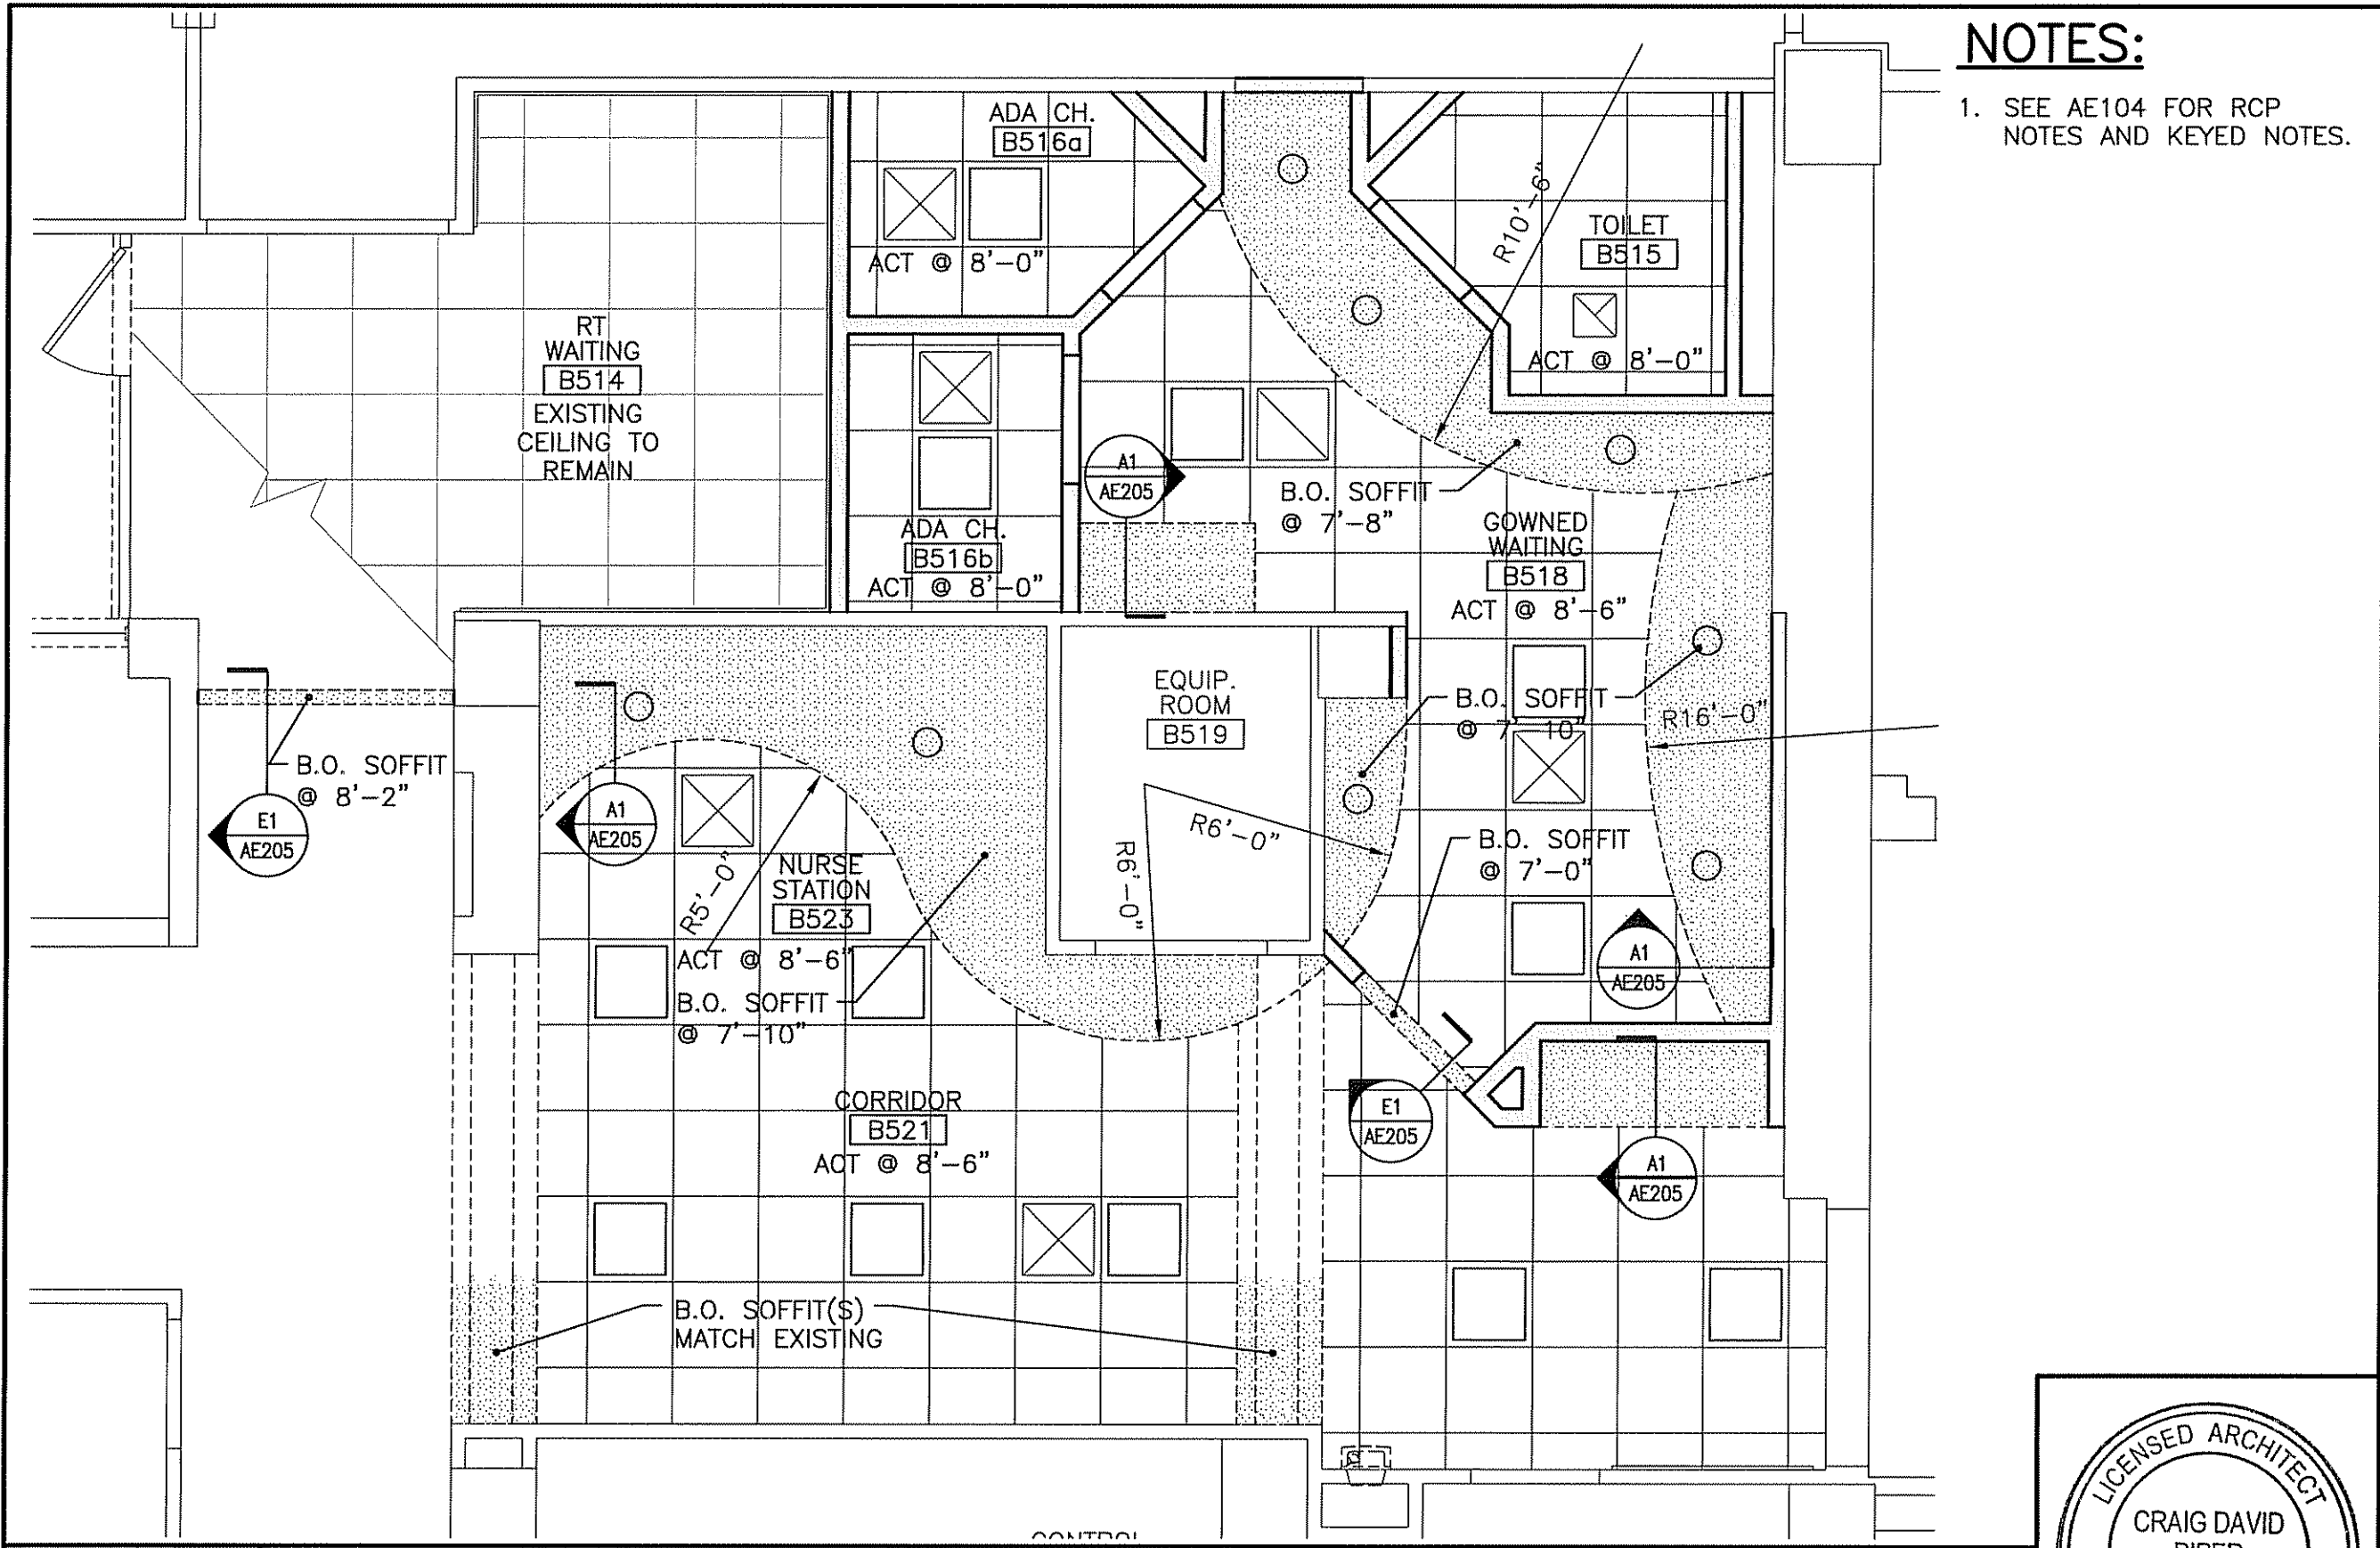

NOTES:
 1. SEE AE104 FOR RCP NOTES AND KEYED NOTES.

0	ISSUED FOR CONSTRUCTION	12-8-06	DATE
	REV	DESCRIPTION	

ARCHITECTURE ENGINEERING PLANNING
 SMRT
 144 Fore Street, P.O. Box 618 PORTLAND, MAINE 04104
 tel. (207) 772-3846 / fax. (207) 772-1070

PROJECT: MAINE MEDICAL CENTER RADIATION THERAPY RENOVATIONS
 PORTLAND, MAINE

SHEET TITLE: PARTIAL REFLECTED CEILING PLAN

PROJECT NORTH	MDR
JC/DRAWN BY:	CDP
A/E OF RECORD:	AE101-06043
SMRT CAD FILE:	06043
PROJECT No:	12-8-06
DATE:	


CURRENT ISSUED STATUS: **ISSUED FOR CONSTRUCTION 12-8-06**

SCALE: 1/4"=1'-0"

PROJECT MANAGER: CDP

SHEET No. **AE103**

© COPYRIGHT 2006 SMRT INC.

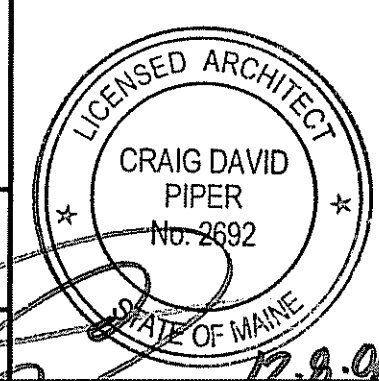

A1	PARTIAL REFLECTED CEILING PLAN
1/4"=1'-0"	*

REFLECTED CEILING NOTES

 
 








1. FIRE SPRINKLERS SHALL BE LOCATED IN ALIGNMENT WITH OTHER CEILING ITEMS, TYPICALLY.
2. FIRE SPRINKLERS SHALL BE CENTERED IN CEILING TILE.
3. FIRE SPRINKLERS SHALL BE PLACED TO COORDINATE WITH LIGHT FIXTURE POSITIONS INDICATED.
4. ALIGN CEILING ITEMS AS SHOWN, WITH COMMON CENTERLINES, TYPICALLY. CENTER ITEMS IN CEILINGS, OR IN AREAS UNLESS INDICATED OTHERWISE.
5. REFER TO ROOM FINISH SCHEDULE FOR CEILING HEIGHTS AND CEILING FINISHES TO BE PROVIDED.
6. EXCEPT WHERE INDICATED, CENTER CEILING GRIDS IN ROOMS. USE HALF TILES OR GREATER @ PERIMETERS AS POSSIBLE.
7. PROVIDE ACCESS PANELS AS REQUIRED IN GWB CEILINGS FOR ACCESS TO MECHANICAL VALVES/ CONTROLS. REFERENCE MECHANICAL.


KEYED NOTES:

1 *

 2

SYMBOL LEGEND

- | | | | |
|---|--|---|-----------------------------|
|  | 2x2 SUSPENDED CEILING PANEL AND GRID ASSEMBLY. |  | DOWN LIGHT. |
|  | 2x4 SUSPENDED CEILING PANEL AND GRID ASSEMBLY. |  | CEILING MOUNTED EXIT LIGHT. |
|  | GWB CEILING. |  | RETURN AIR GRILLE. |
|  | 2x4 LAY-IN LIGHT FIXTURE. |  | SUPPLY AIR GRILLE. |
|  | 1x4 PENDANT LIGHT FIXTURE. |  | EXHAUST AIR GRILLE. |

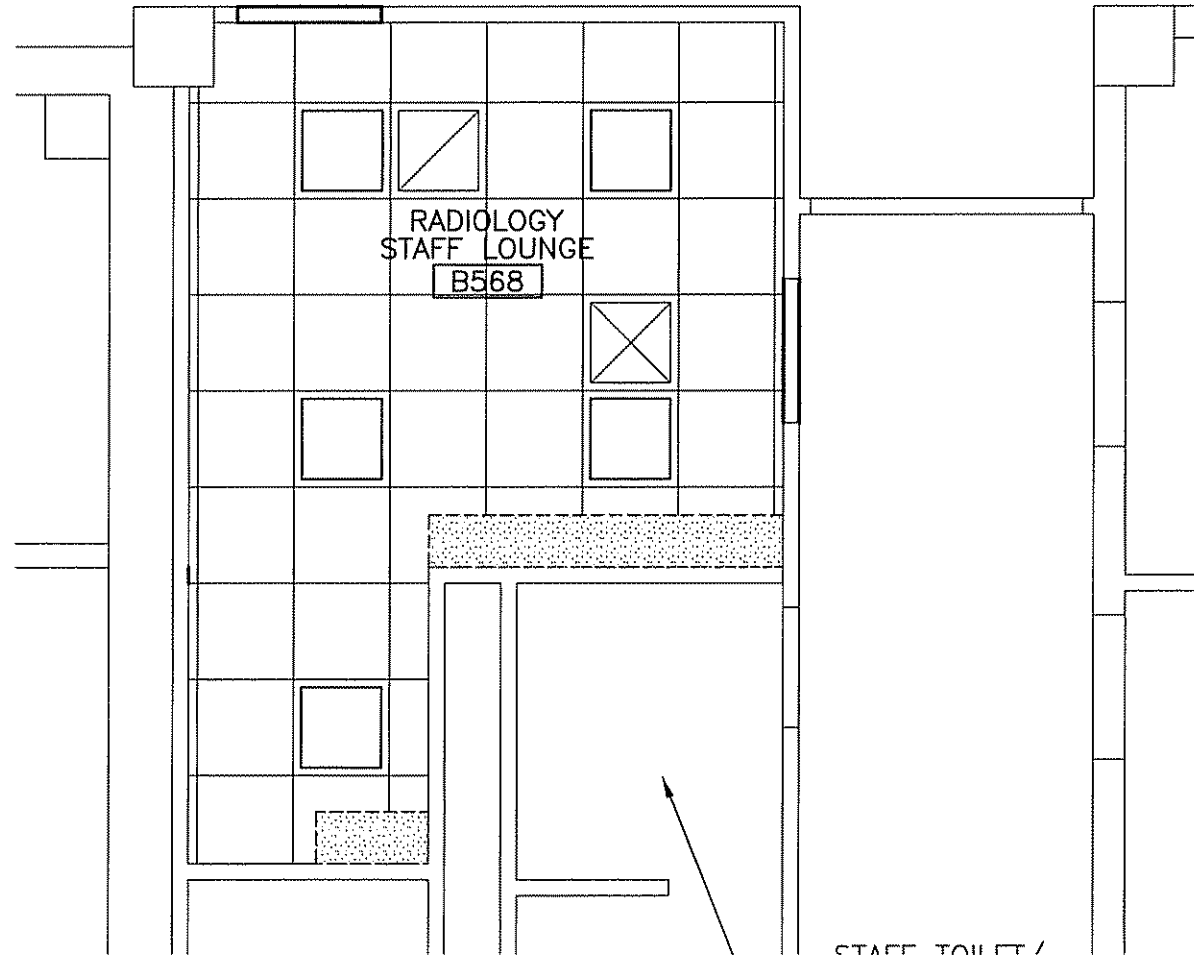


A5

PARTIAL FLOOR PLAN






1/4"=1'-0"

*

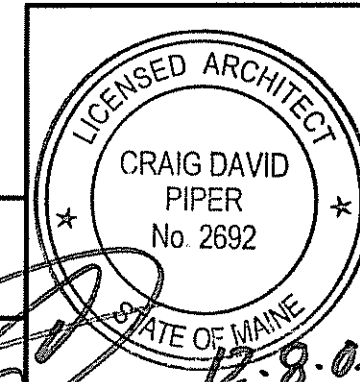

PROJECT: MAINE MEDICAL CENTER RADIATION THERAPY RENOVATIONS PORTLAND, MAINE		SHEET TITLE: PARTIAL RCP PLAN	
PROJECT NORTH		JC/DRAWN BY: MDR	DATE: 12-8-06
CURRENT ISSUED STATUS: ISSUED FOR CONSTRUCTION 12-8-06		A/E OF RECORD: CDP	SMRT CAD FILE: AE104-06043
SCALE: 1/4"=1'-0"		PROJECT No: 06043	DATE: 12-8-06
PROJECT MANAGER: CDP		SHEET No. AE104	
ISSUED FOR CONSTRUCTION 12-8-06		© COPYRIGHT 2006 SMRT INC.	
REV	DESCRIPTION	ARCHITECTURE ENGINEERING PLANNING SMRT 144 Fore Street/P.O. Box 618 PORTLAND, MAINE 04104 tel. (207) 772-3846 / fax. (207) 772-1070	
0	ISSUED FOR CONSTRUCTION	DATE: 12-8-06	




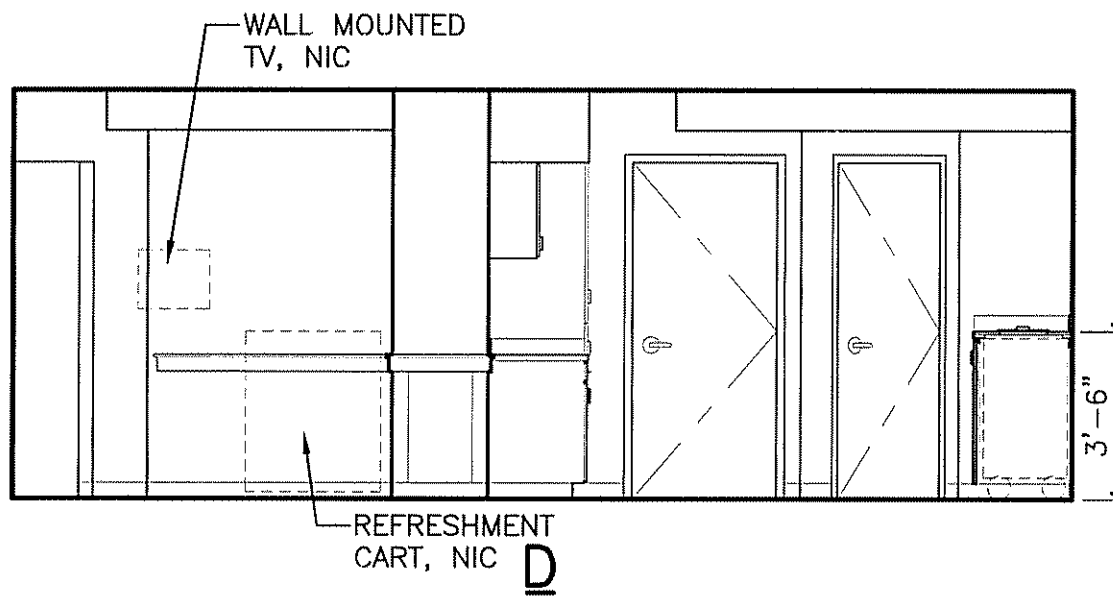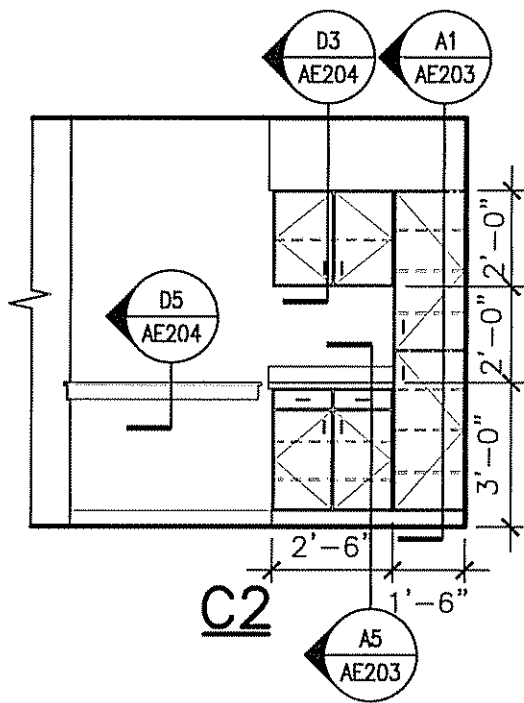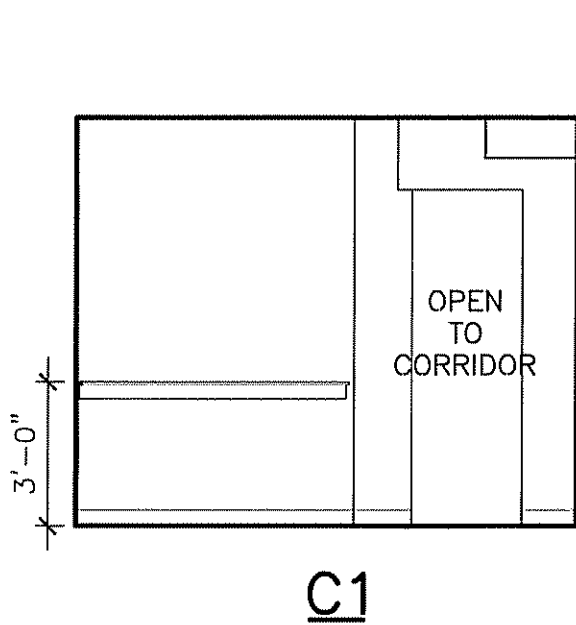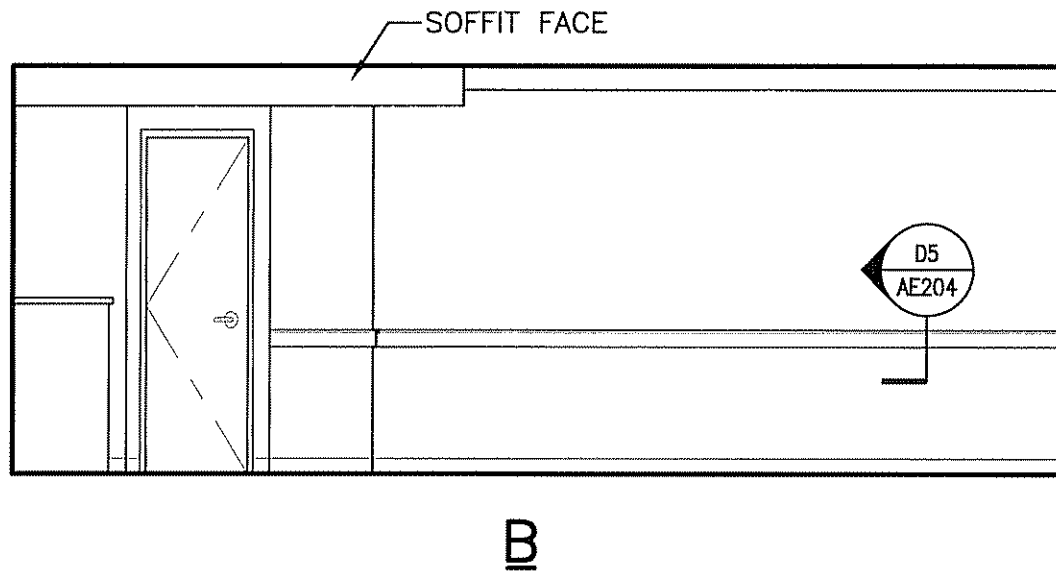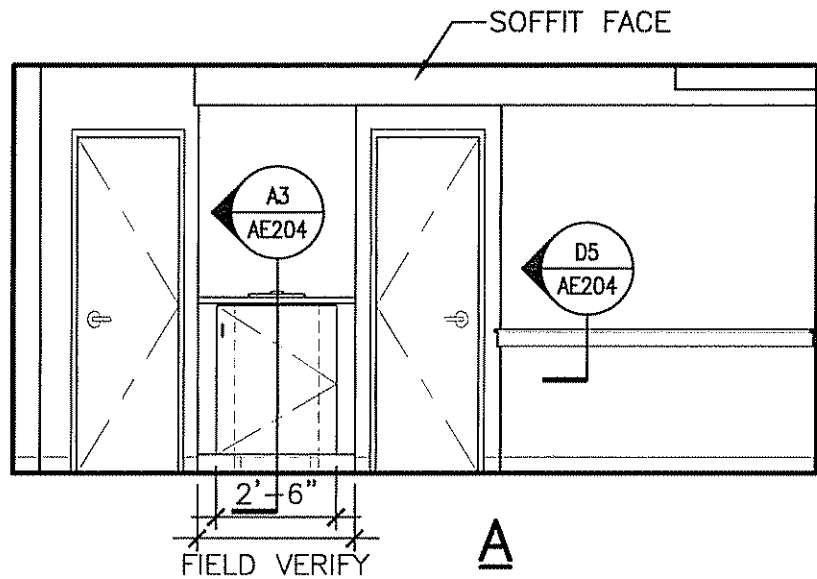


A1 GOWNED WAITING #B518



1/4"=1'-0"

*

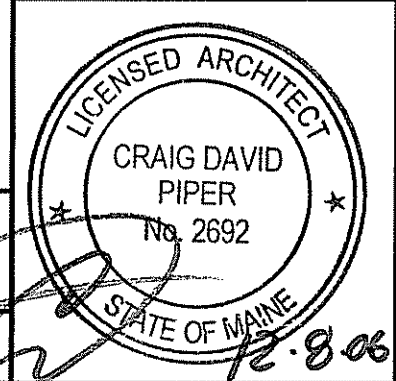


PROJECT: MAINE MEDICAL CENTER RADIATION THERAPY RENOVATIONS PORTLAND, MAINE		SHEET TITLE: INTERIOR ELEVATIONS	
ISSUED FOR CONSTRUCTION	12-8-06	DATE	
REV	DESCRIPTION		
0			
CURRENT ISSUED STATUS: ISSUED FOR CONSTRUCTION 12-8-06		SCALE: 1/4"=1'-0"	
PROJECT MANAGER: CDP		JC/DRAWN BY: MDR	
SHEET No. AE201		A/E OF RECORD: CDP	
SMRT CAD FILE: AE201--06043		PROJECT No.: 06043	
PROJECT No. AE201		DATE: 12-8-06	
© copyright 2006 SMRT inc.			
ARCHITECTURE ENGINEERING PLANNING SMRT		144 Fore Street/P.O. Box 618 PORTLAND, MAINE 04104 tel. (207) 772-3846 / fax. (207) 772-1070	

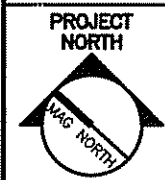

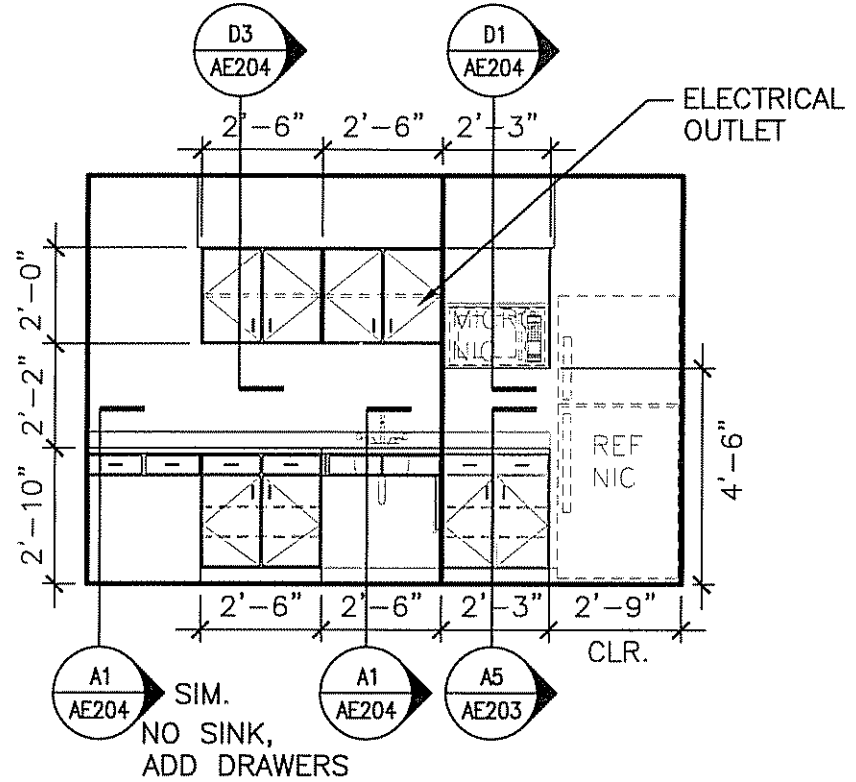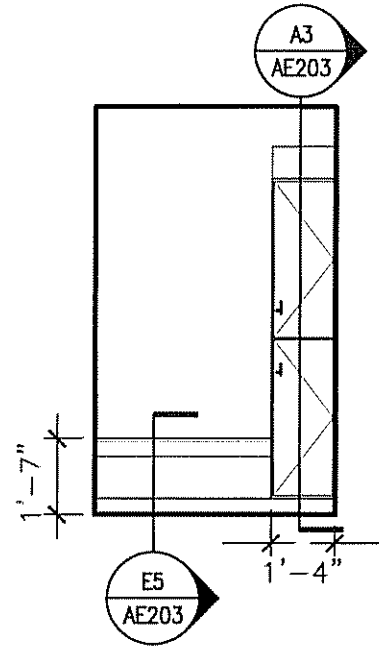

D1 ADA CHANGE #B516b
1/4"=1'-0" *

D5 RADIOLOGY STAFF LOUNGE #568
1/4"=1'-0" *

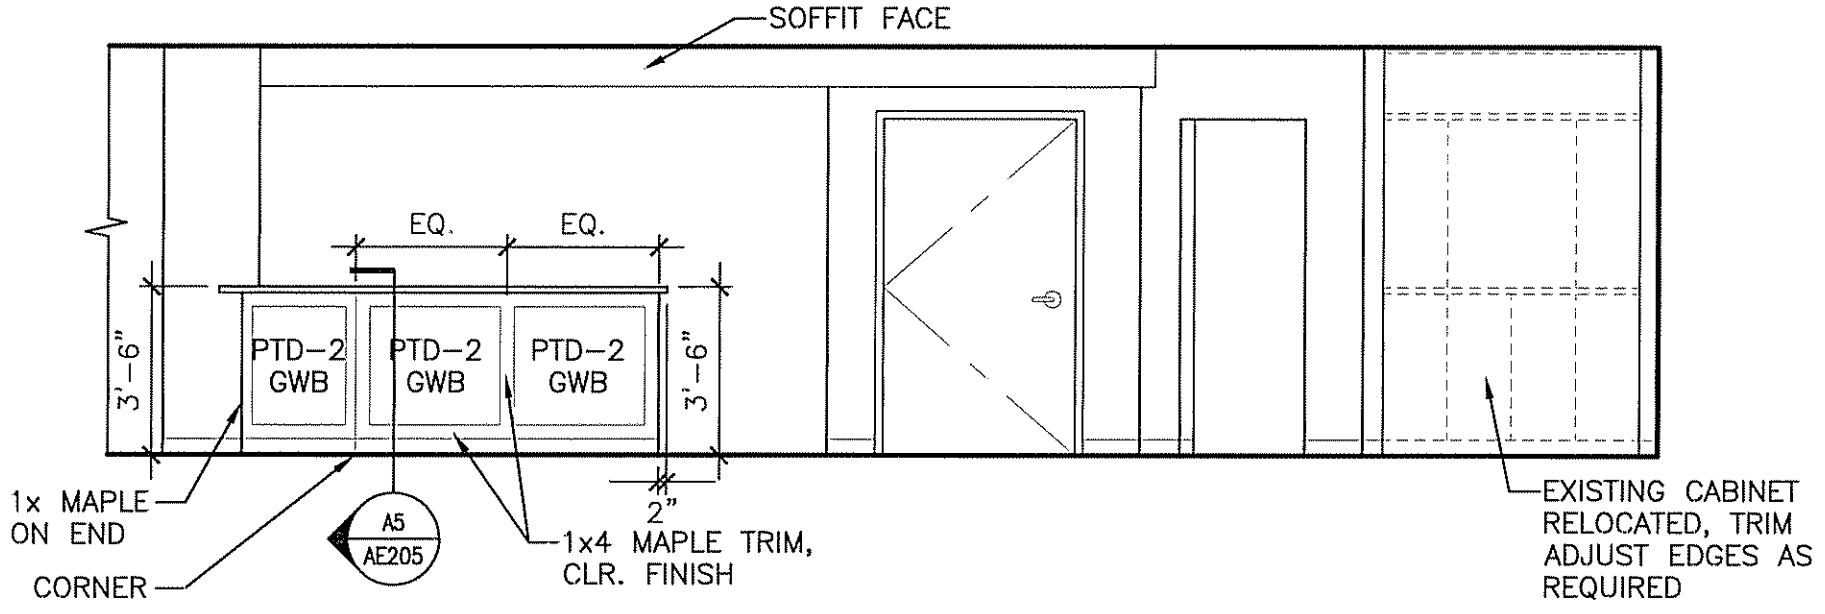

A1 NURSE STATION #B523
1/4"=1'-0" *

ISSUED FOR CONSTRUCTION	12-8-06	DATE
REV	DESCRIPTION	
0		



ARCHITECTURE ENGINEERING PLANNING
SMRT
144 Fore Street/P.O. Box 618 PORTLAND, MAINE 04104
tel. (207) 772-3846 / fax. (207) 772-1070


PROJECT: MAINE MEDICAL CENTER
RADIATION THERAPY RENOVATIONS
PORTLAND, MAINE





SHEET TITLE:
INTERIOR ELEVATIONS



CURRENT ISSUED STATUS:
ISSUED FOR CONSTRUCTION
12-8-06

SCALE:	1/4"=1'-0"	JC/DRAWN BY:	MDR
PROJECT MANAGER:	CDP	A/E OF RECORD:	CDP
SHEET No.	AE202	SMRT CAD FILE:	AE202-06043
		PROJECT No.:	06043
		DATE:	12-8-06

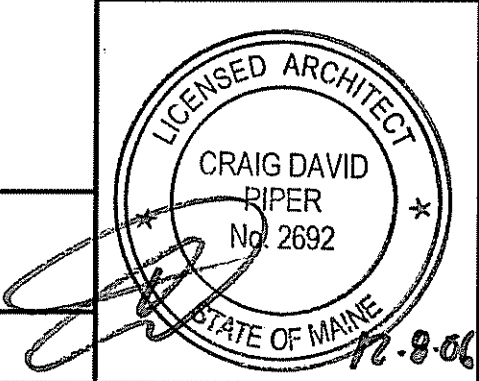


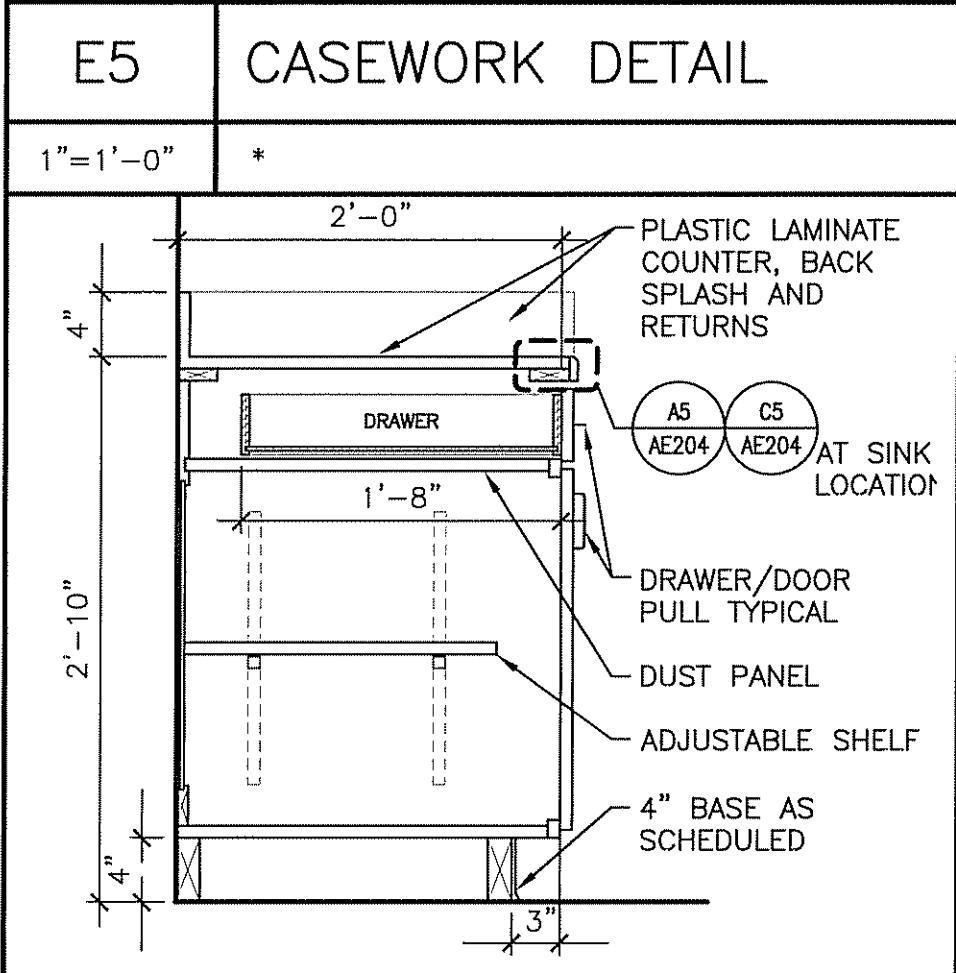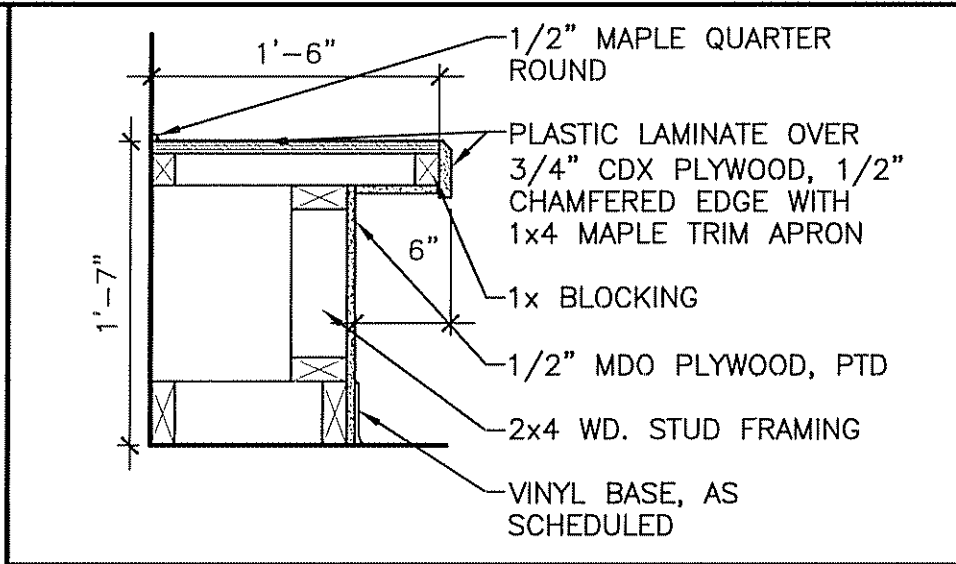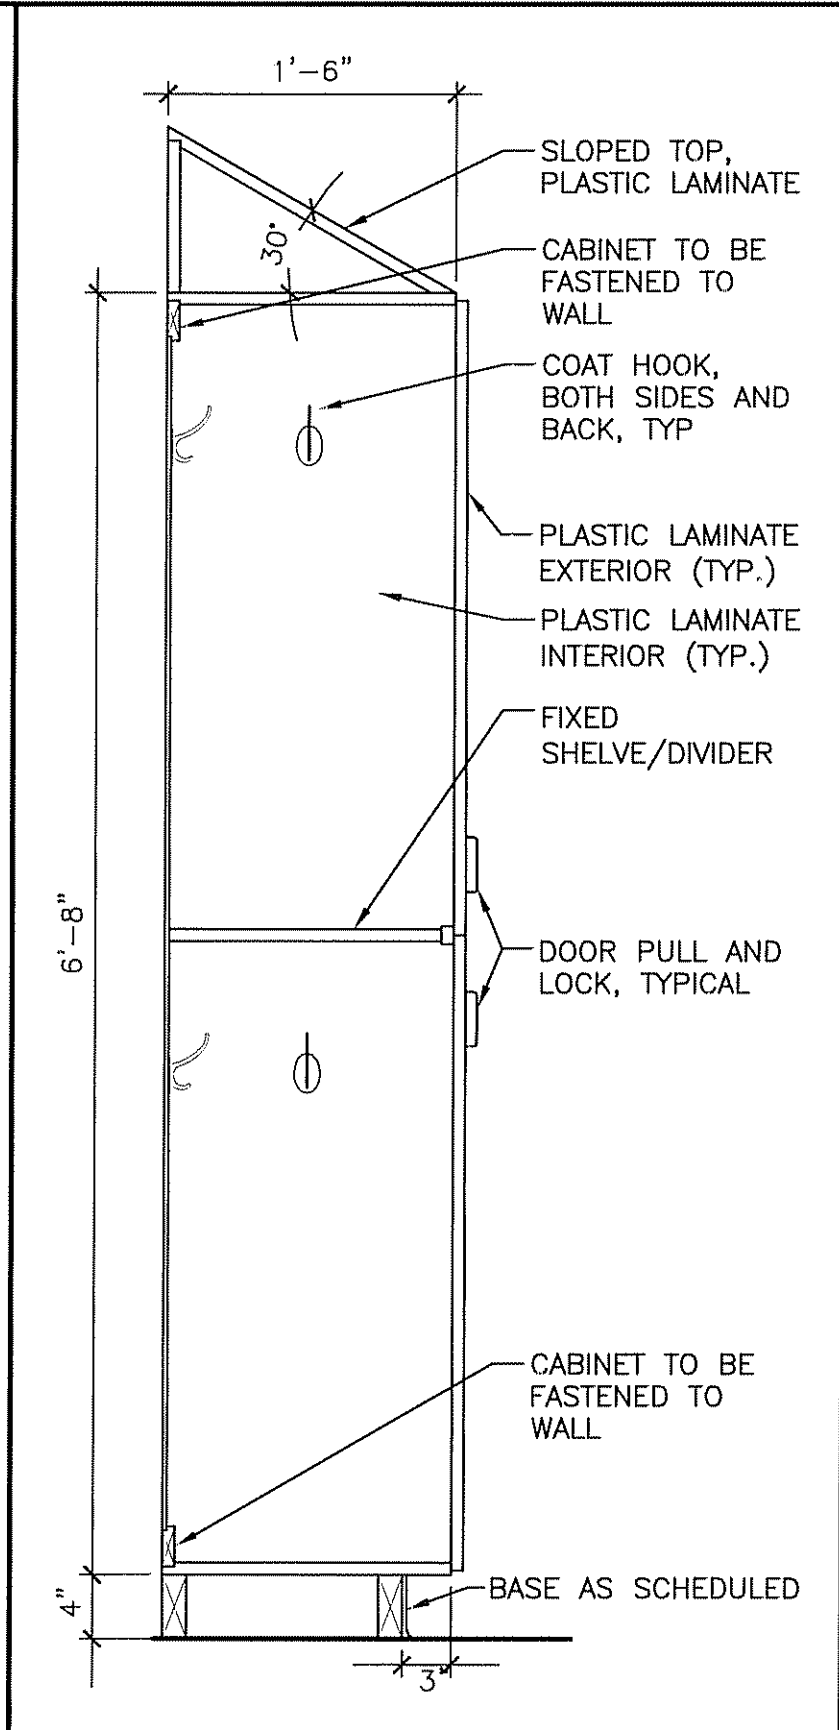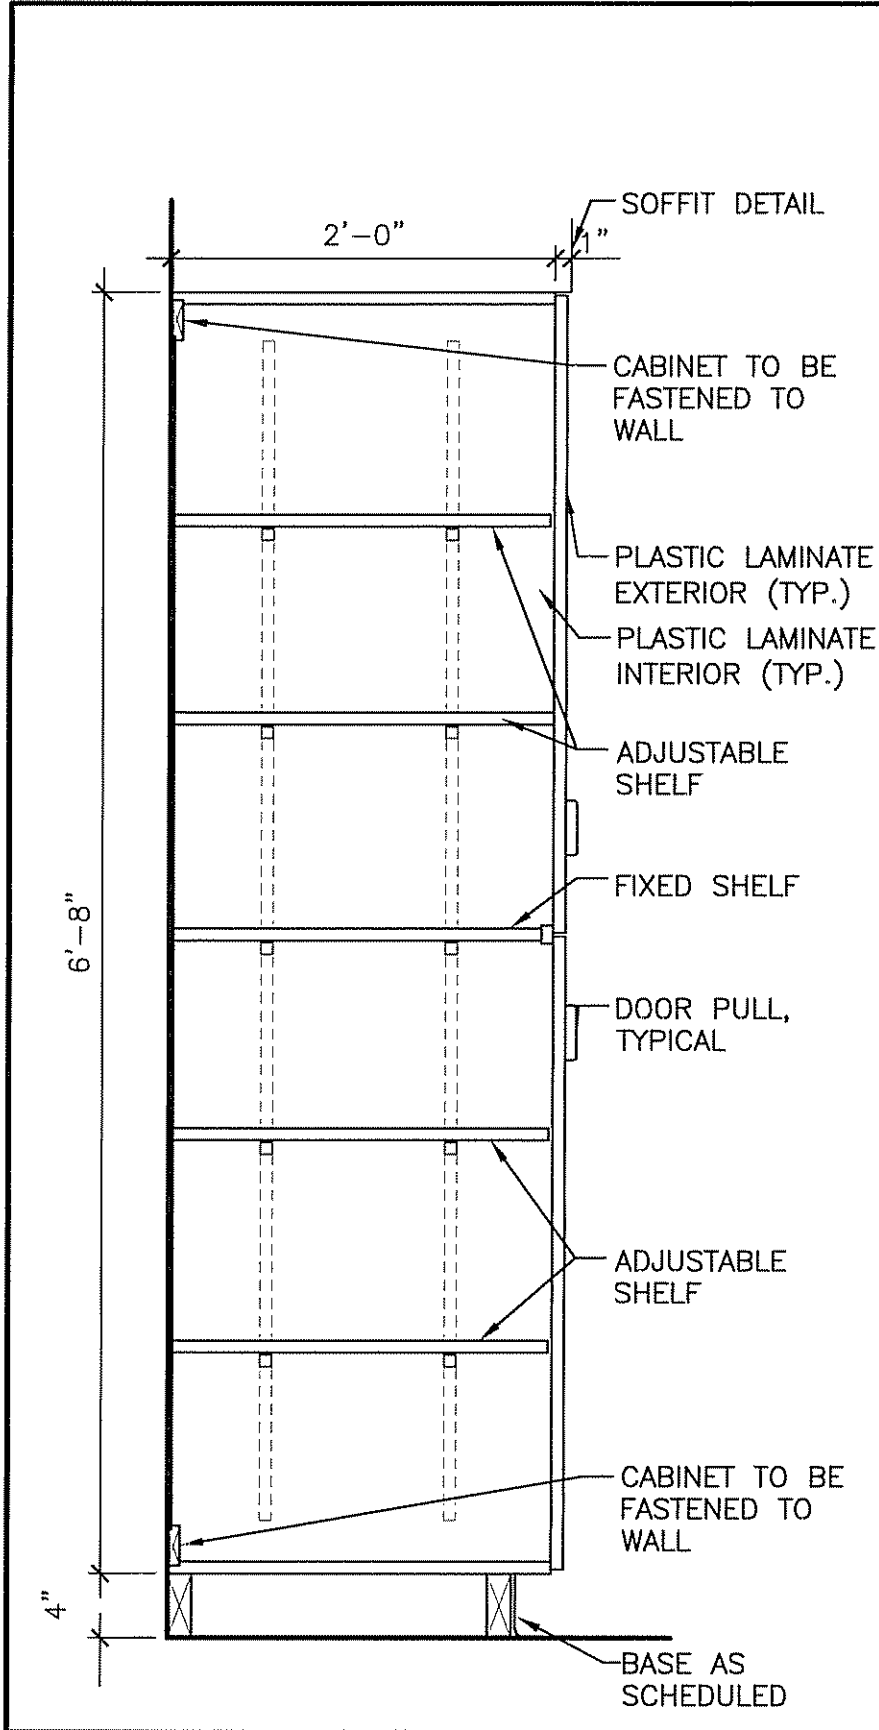

A1	CASEWORK DETAIL
1"=1'-0"	*

A3	CASEWORK DETAIL
1"=1'-0"	*




A5	CASEWORK DETAIL
1"=1'-0"	*

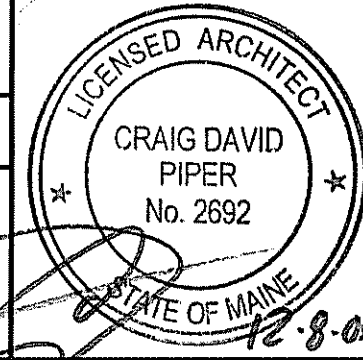

PROJECT: MAINE MEDICAL CENTER RADIATION THERAPY RENOVATIONS PORTLAND, MAINE		SHEET TITLE: CASEWORK DETAILS	
PROJECT NO: 06043		DATE: 12-8-06	
PROJECT MANAGER: CDP		SHEET No. AE203	
A/E OF RECORD: CDP		PROJECT No: 06043	
JC/DRAWN BY: MDR		DATE: 12-8-06	
SCALE: 1/4"=1'-0"		CURRENT ISSUED STATUS: ISSUED FOR CONSTRUCTION 12-8-06	
SMRT CAD FILE: AE203-06043		PROJECT No: 06043	
PROJECT No: 06043		DATE: 12-8-06	
PROJECT No: AE203		PROJECT No: 06043	
PROJECT No: AE203		PROJECT No: 06043	

0	ISSUED FOR CONSTRUCTION	12-8-06	DATE
0	REV	DESCRIPTION	

ARCHITECTURE ENGINEERING PLANNING
 SMRT
 144 Fore Street, P.O. Box 618 PORTLAND, MAINE 04104
 tel. (207) 772-3846 / fax. (207) 772-1070

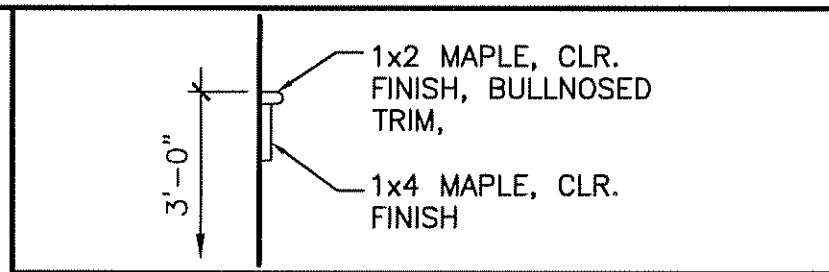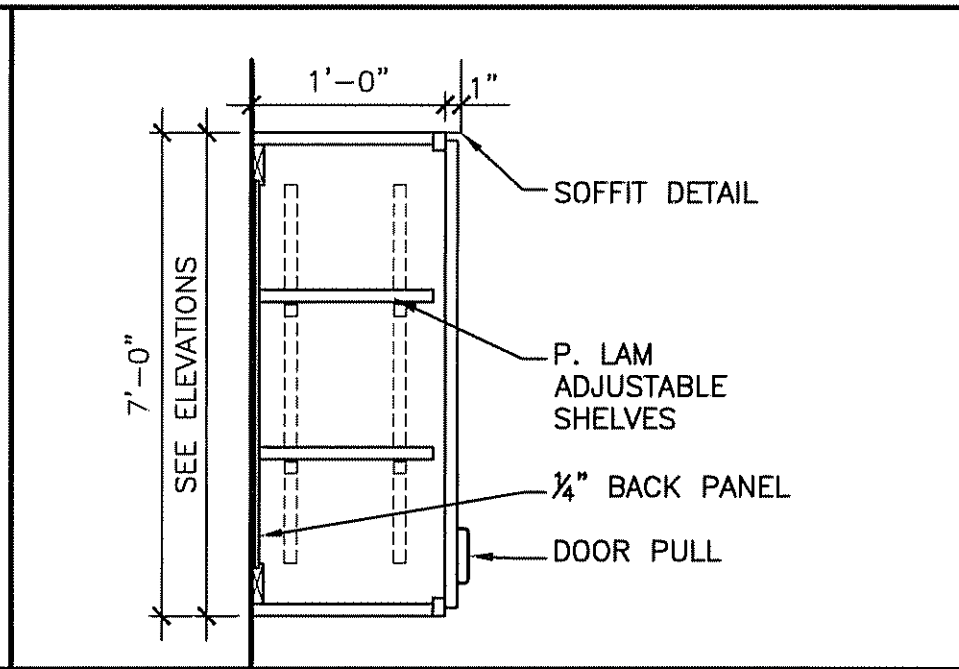
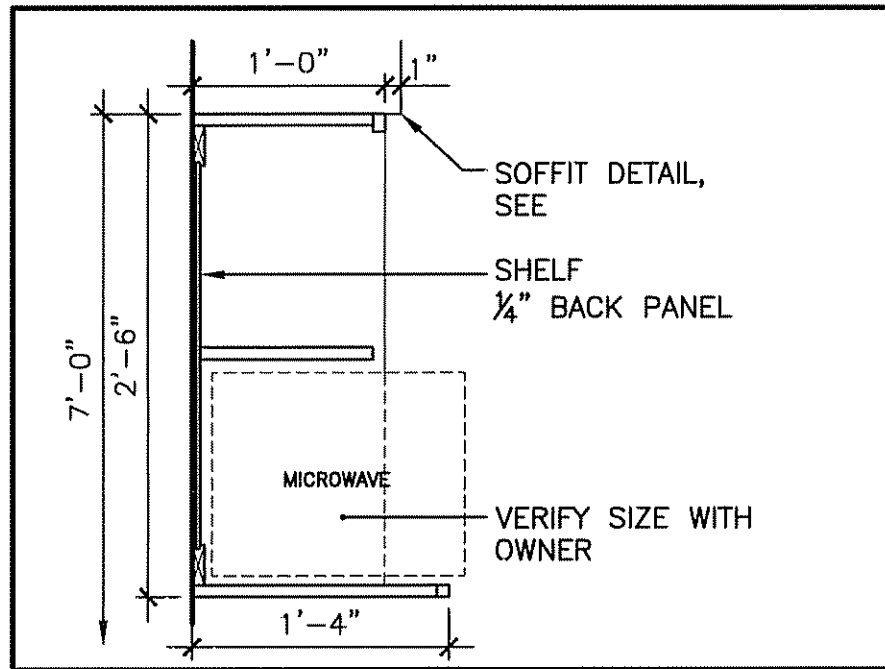


D1 CASEWORK DETAIL

D3 CASEWORK DETAIL

1"=1'-0" *

1"=1'-0" *

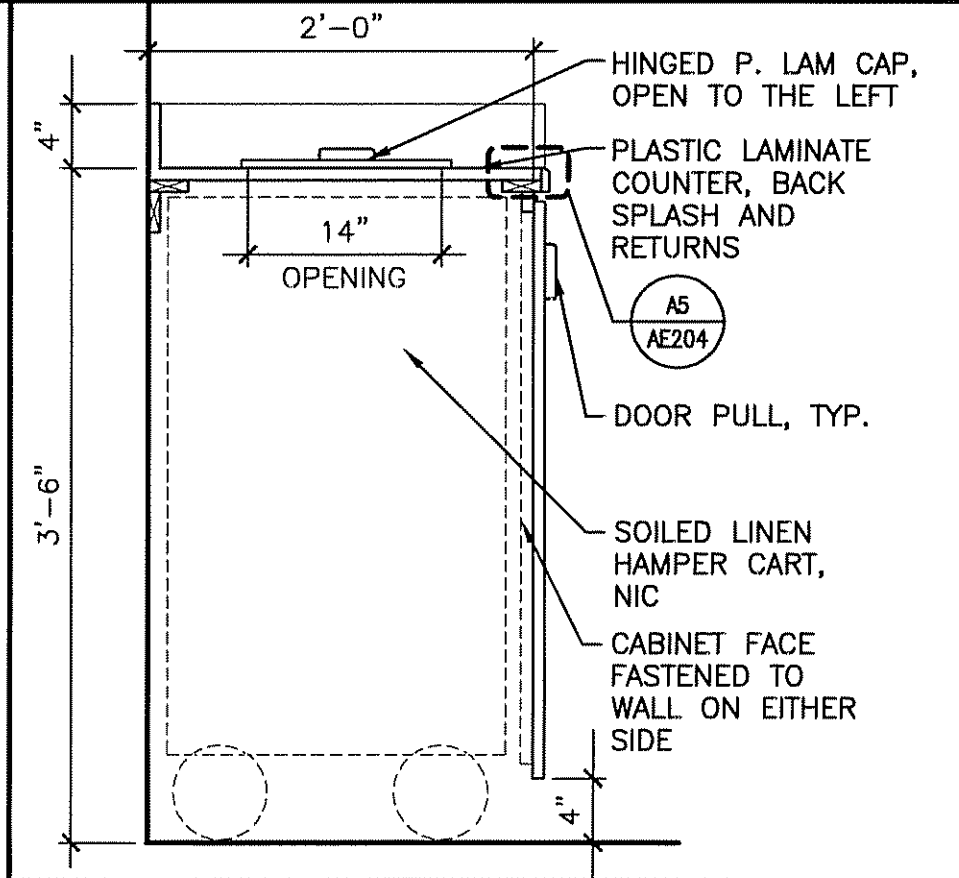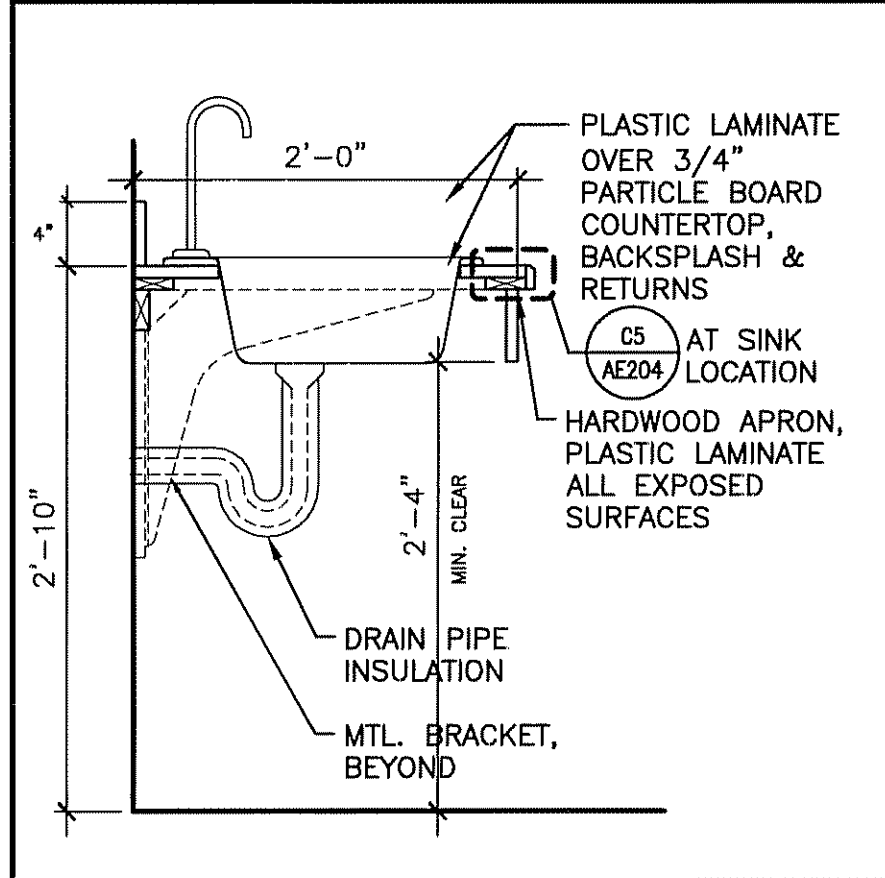

A1 CASEWORK DETAIL


A3 CASEWORK DETAIL

1"=1'-0" *

1"=1'-0" *


D5 CASEWORK DETAIL

1"=1'-0" *

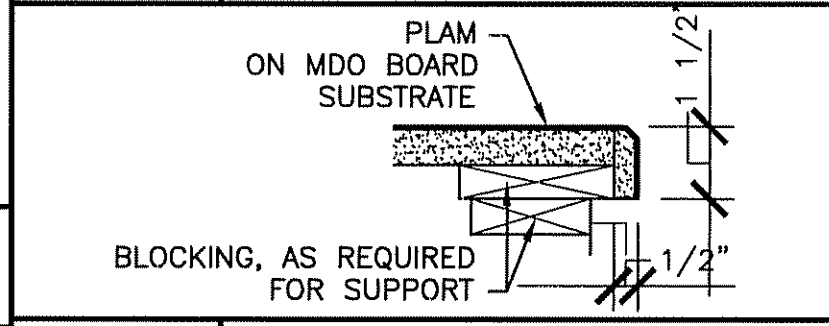

C5 CASEWORK DETAIL

1"=1'-0" *

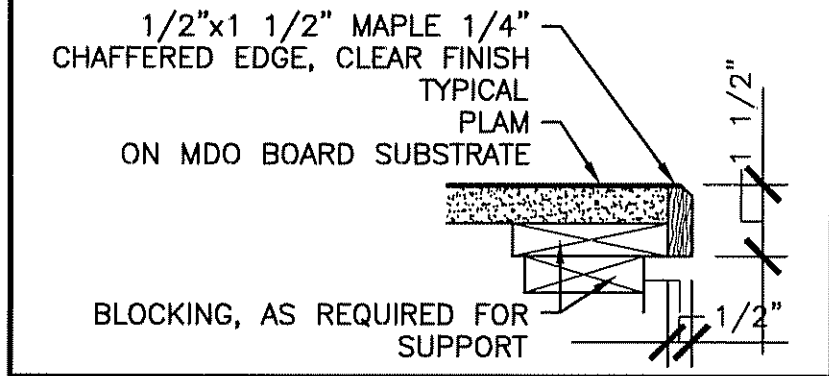

A5 CASEWORK DETAIL

1"=1'-0" *


0	ISSUED FOR CONSTRUCTION	12-8-06	DATE
REV	DESCRIPTION		

ARCHITECTURE ENGINEERING PLANNING
SMART
144 Fore Street/P.O. Box 618 PORTLAND, MAINE 04104
tel. (207) 772-3846 / fax. (207) 772-1070


PROJECT: MAINE MEDICAL CENTER RADIATION THERAPY RENOVATIONS PORTLAND, MAINE

SHEET TITLE: CASEWORK DETAILS

SCALE:	1/4"=1'-0"
PROJECT MANAGER:	CDP
SHEET No.	AE204
JC/DRAWN BY:	MDR
A/E OF RECORD:	CDP
SMRT CAD FILE:	AE204--06043
PROJECT No.:	06043
DATE:	12-8-06

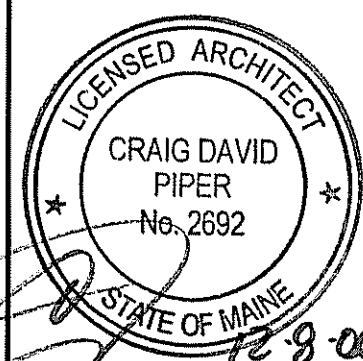


CURRENT ISSUED STATUS:
ISSUED FOR CONSTRUCTION
12-8-06

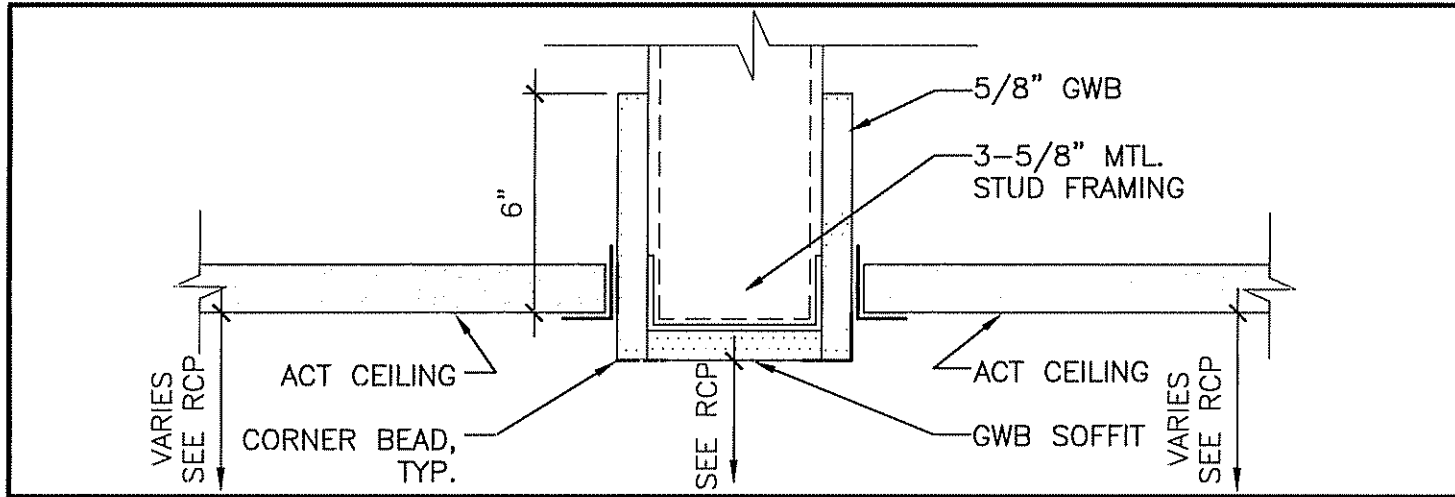


E1 SOFFIT DETAIL

3"=1'-0" *

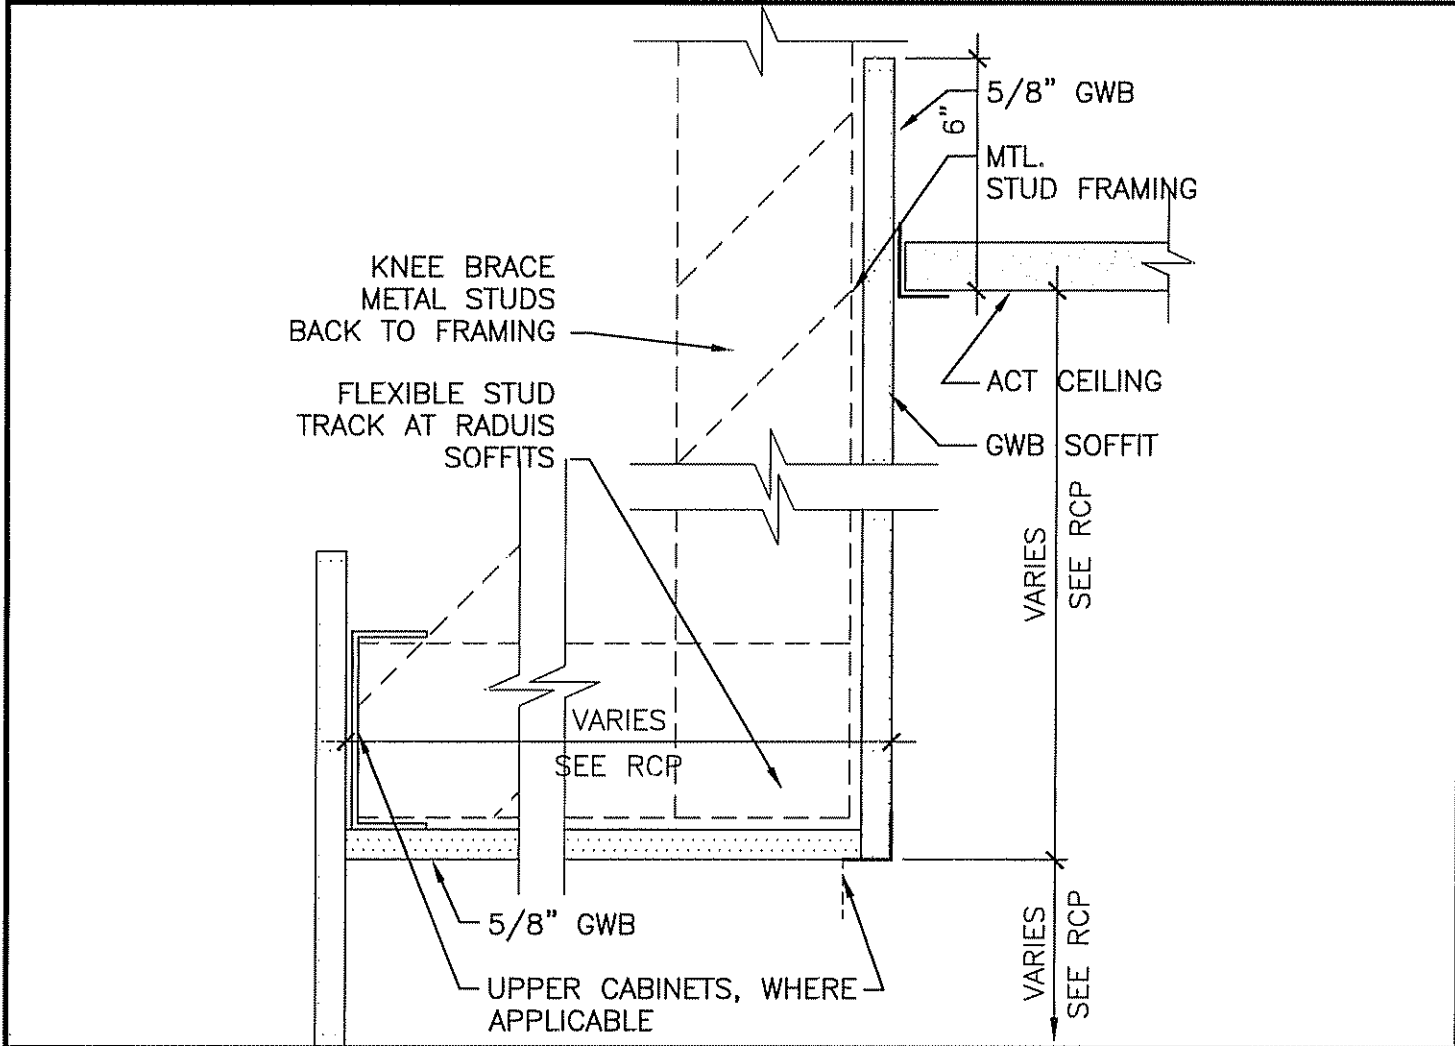


A1 SOFFIT DETAIL

3"=1'-0" *

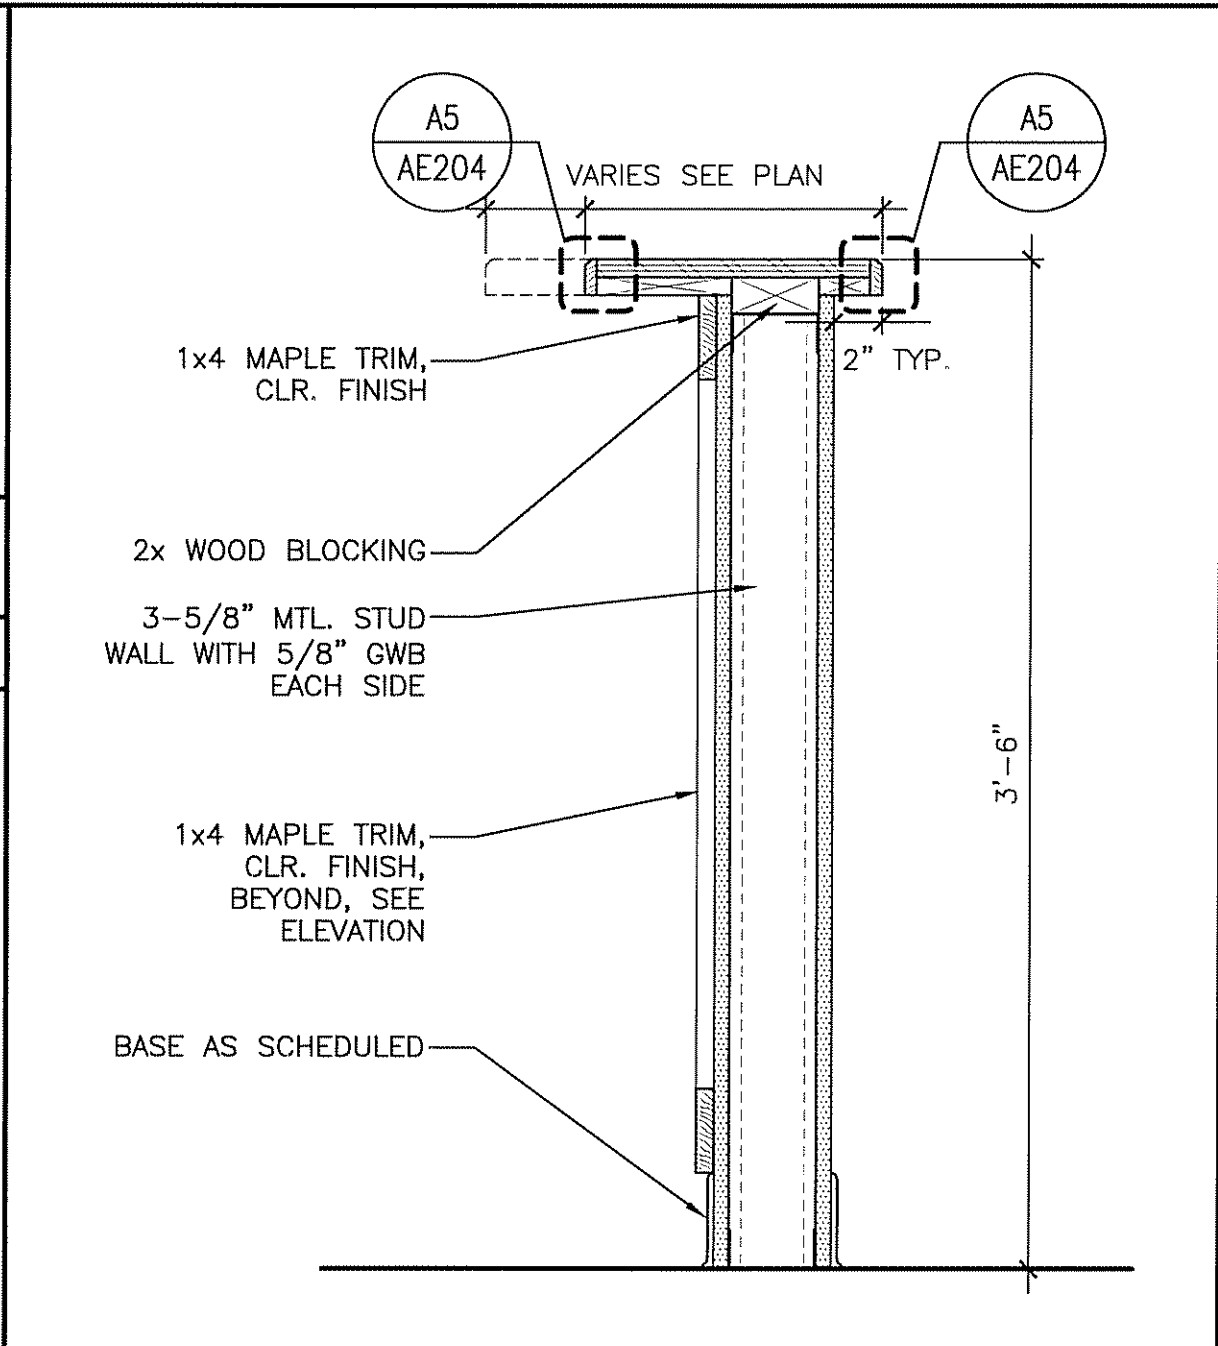

A5 CASEWORK DETAIL

1-1/2"=1'-0" *

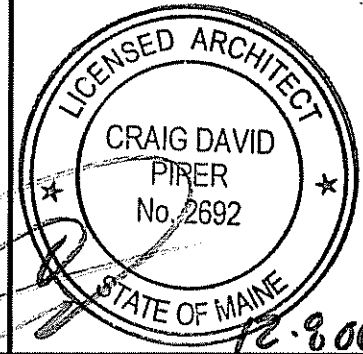

PROJECT: MAINE MEDICAL CENTER RADIATION THERAPY RENOVATIONS PORTLAND, MAINE		SHEET TITLE: CASEWORK DETAILS	
SCALE: 1/4"=1'-0"	JC/DRAWN BY: MDR	PROJECT No.: 06043	DATE: 12-8-06
PROJECT MANAGER: CDP	A/E OF RECORD: CDP	SMRT CAD FILE: AE205-06043	
SHEET No. AE205		PROJECT No.: 06043	DATE: 12-8-06
CURRENT ISSUED STATUS: ISSUED FOR CONSTRUCTION 12-8-06		PROJECT No.: 06043	
ISSUED FOR CONSTRUCTION 12-8-06		DATE: 12-8-06	
REV 0		DESCRIPTION	
DATE		12-8-06	
<small>144 Fore Street/P.O. Box 618 PORTLAND, MAINE 04104 tel. (207) 772-3846 / fax. (207) 772-1070</small>			

ROOM FINISH SCHEDULE

ROOM NUMBER	ROOM NAME	FLOOR	BASE	WALLS	CEILING		REMARKS
					MATERIAL	HEIGHT	
B514	RT WAITING	CPT-1	RB	PTD-1	ACT		
B515	TOILET	PFT-1	CT-1	CT/PTD-1	ACT		①
B516a	ADA CHANGE	CPT-1	RB	PTD-1	ACT		
B516b	ADA CHANGE	CPT-1	RB	PTD-1	ACT		
B518	GOWNED WAITING	CPT-1	RB	PTD-1	ACT		② PTD-1 ABOVE CHAIR RAIL, PTD-2 BELOW
B521	CORRIDOR	VCT	RB	PTD-1	ACT		SEE AF101 FOR DETAILS
B523	NURSE STATION	VCT	RB	PTD-1	ACT		② SEE AF101 FOR DETAILS
B568	RADIOLOGY STAFF LOUNGE	VCT	RB	PTD-1/PTD-2	ACT		PTD-2 AT WEST WALL. SEE AF102 FOR DETAILS

FINISH NOTES:

1. ALL DOOR FRAMES TO BE PTD-1.
2. FOR CASEWORK USE PLAM-1 ON ALL HORIZONTAL SURFACES (& BACKSPLASH) AND PLAM-2 ON ALL VERTICAL SURFACES, TYP. U.N.O.

DOOR SCHEDULE

DOOR NUMBER	DOOR			FRAME	REMARKS
	SIZE	MATERIAL	ELEVATION	MATERIAL	
B515	3'-0"x7'-0"x1-3/4"	WD	F	HM	
B516a	3'-0"x7'-0"x1-3/4"	WD	F	HM	2
B516b	3'-0"x7'-0"x1-3/4"	WD	F	HM	2
B568	3'-0"x7'-0"x1-3/4"	WD	F	HM	1

DOOR SCHEDULE NOTES

- 1 EXISTING RELOCATED WITH SIMILIAR HARDWARE
- 2 REUSE IF IN GOOD CONDITION

FINISH ABBREVIATIONS:

ACT	ACOUSTICAL CEILING TILE
CT	CERAMIC WALL TILE
PLAM	PLASTIC LAMINATE
PTD	PAINTED
PWC	PROTECTIVE WALL COVERING
RB	RUBBER BASE
VCT	VINYL COMPOSITION TILE
WD	WOOD

FINISH KEY NOTES:

- ① CT WAINSCOT, PERIMETER OF ROOM. TILE TO TERMINATE 2" ABOVE TOP OF SINK. PTD-2 AT NORTH WALL, ABOVE TILE.
- ② PTD-2 AT FACE AND UNDERSIDE OF CURVED SOFFITS.

FINISH LEGEND

CARPET

CPT-1 TANDUS, CROSSLEY #0313 FIRST IMPRESSIONS, COLOR: #08604 GREAT TAN

CERAMIC TILE

CT-1 AMERICAN OLEAN, SNOW MIST #95
6"X6" AND ALL TRIM PIECES.

PAINT

PTD-1 ICI ANTIQUE WHITE #739
PTD-2 ICI FLAGSTONE #1137

PORCELAIN FLOOR TILE

PFT-1 AMERICAN OLEAN, INDIAN SLATE ARD BIANCA, 12"X12"
PRODUCT # 6IINSBIA12

PLASTIC LAMINATE

PLAM-1 PIONITE, KALE FIBER AV861, SUEDE
PLAM-2 PIONITE, HARDROCK MAPLE, WM791 SUEDE

PROTECTIVE WALL COVERING


PWC-1 C/S ACROVYN #933 MISSION WHITE

RUBBER BASE

RB JOHNSONITE #40 BLACK


VCT

VCT-1 ARMSTRONG, POLAR WHITE # 51941
VCT-2 ARMSTRONG, BUTTERCREAM YELLOW #51800
VCT-3 ARMSTRONG, WILLOW GREEN #51938

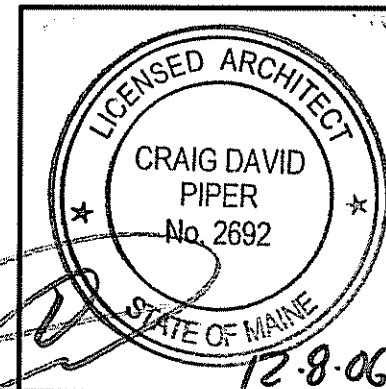

PROJECT:

MAINE MEDICAL CENTER
RADIATION THERAPY RENOVATIONS
PORTLAND, MAINE

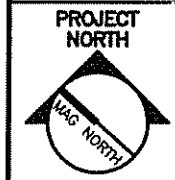

CURRENT ISSUED STATUS:
**ISSUED FOR CONSTRUCTION
12-8-06**

SHEET TITLE:


SCHEDULES

SCALE: 1/4"=1'-0"
PROJECT MANAGER: CDP
SHEET No. **AE601**
JC/DRAWN BY: MDR
A/E OF RECORD: CDP
SMRT CAD FILE: AE601-06043
PROJECT No: 06043
DATE: 12-8-06

REV 0
ISSUED FOR CONSTRUCTION 12-8-06
DATE

ARCHITECTURE ENGINEERING PLANNING
SMRT
144 Fore Street/P.O. Box 618 PORTLAND, MAINE 04104
tel. (207) 772-3846 / fax. (207) 772-1070



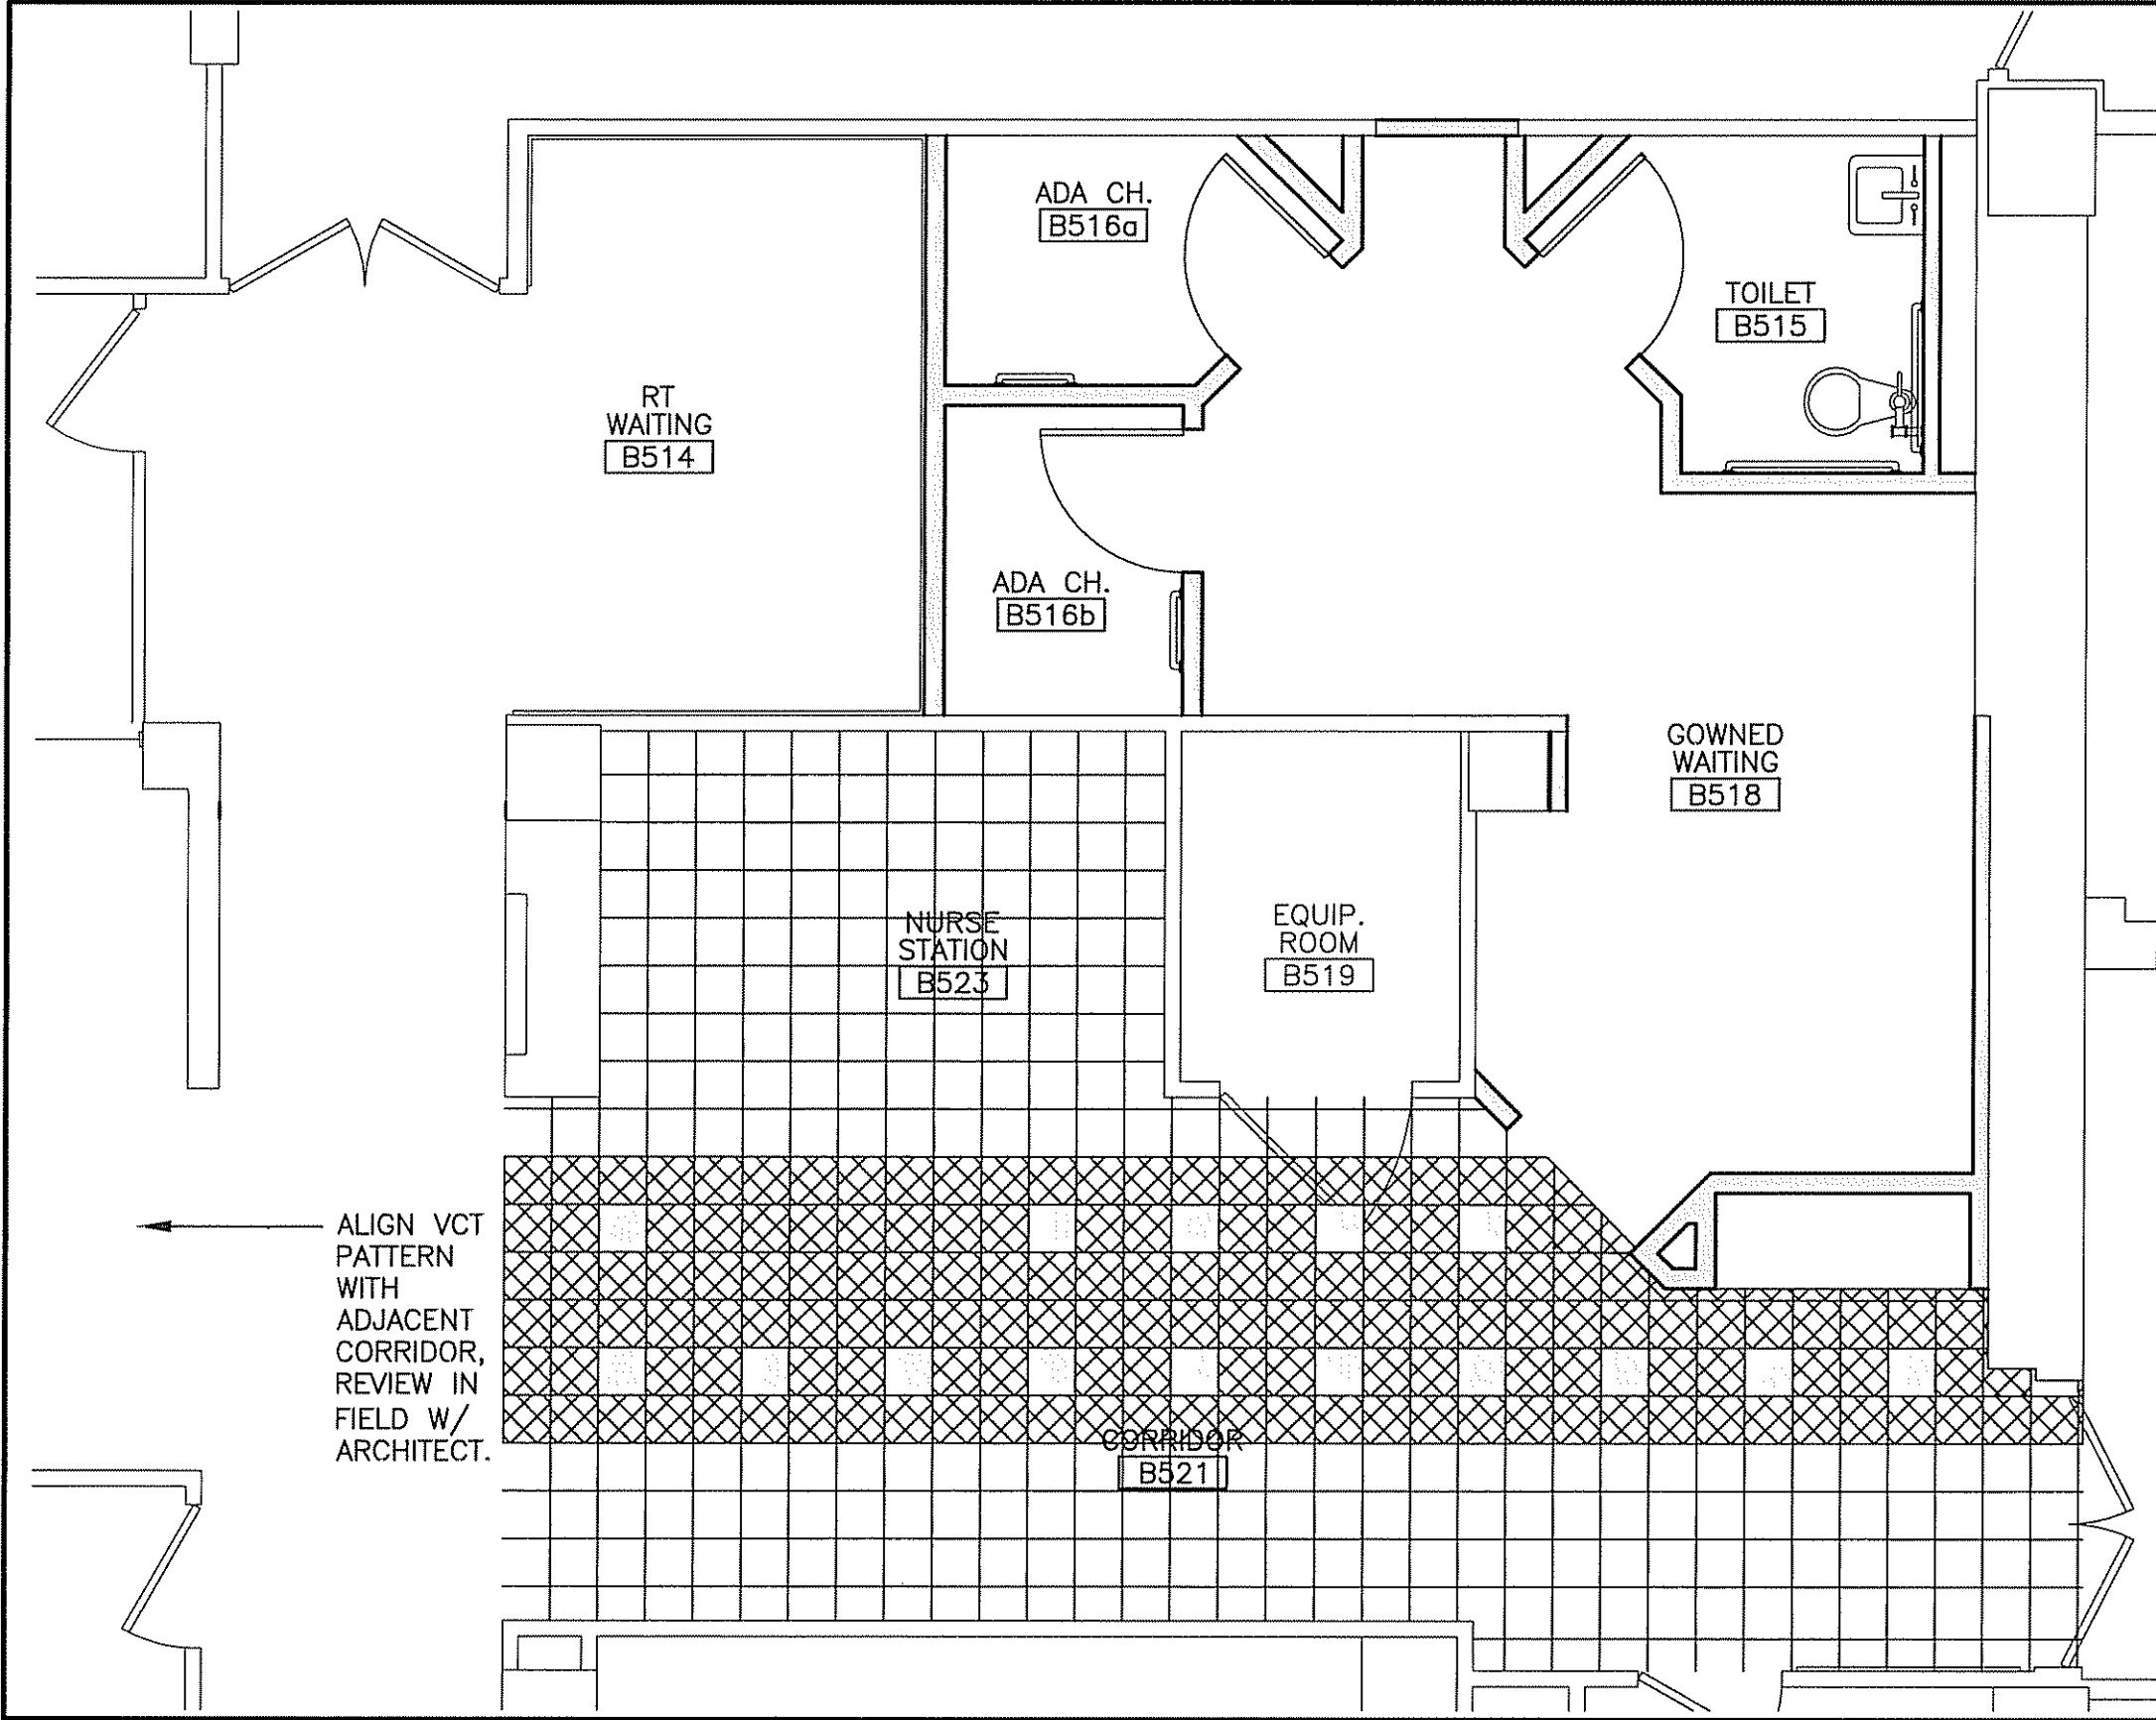

NOTES:

1. SEE AE601 FOR MATERIALS LEGEND.


FLOOR LEGEND:

- VCT-1
- VCT-2
- VCT-3


REV	DESCRIPTION	DATE
0	ISSUED FOR CONSTRUCTION	12-8-06

PROJECT: **MAINE MEDICAL CENTER RADIATION THERAPY RENOVATIONS**
 PORTLAND, MAINE

SHEET TITLE: **PARTIAL FLOOR FINISH PLAN**

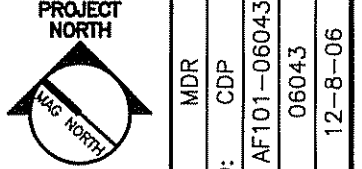

SCALE: 1/4"=1'-0"	JC/DRAWN BY: MDR
PROJECT MANAGER: CDP	A/E OF RECORD: CDP
SHEET No. AF101	SMRT CAD FILE: AF101-06043
	PROJECT No: 06043
	DATE: 12-8-06

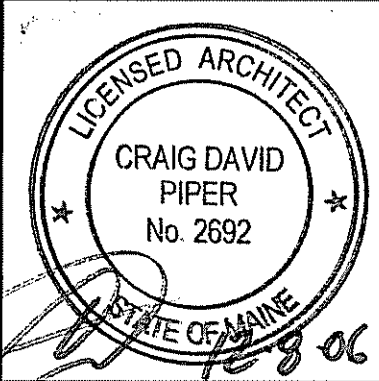

A1

1/4"=1'-0"

PARTIAL FLOOR FINISH PLAN

ISSUED FOR CONSTRUCTION
12-8-06


CURRENT ISSUED STATUS:




ARCHITECTURE ENGINEERING PLANNING
 SMRT
 144 Fore Street/P.O. Box 618 PORTLAND, MAINE 04104
 tel. (207) 772-3846 / fax. (207) 772-1070

NOTES:

1. REFER TO AE601 FOR FINISH LEGEND.
2. REFER TO AF101 FOR FLOOR MATERIAL LEGEND.

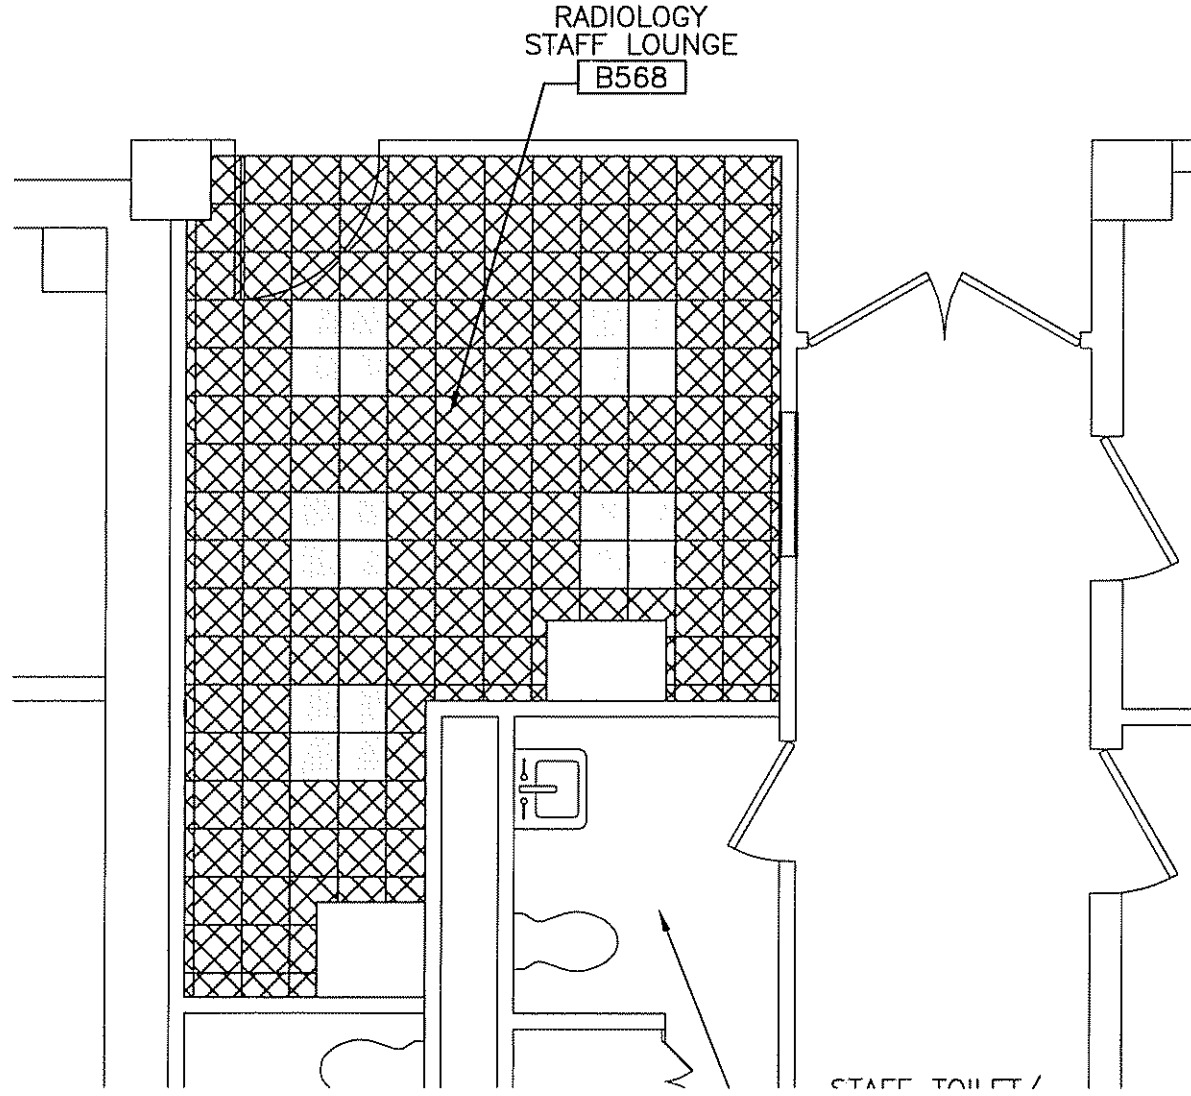

A5	PART. FLR. FIN. PLAN
1/4"=1'-0"	*

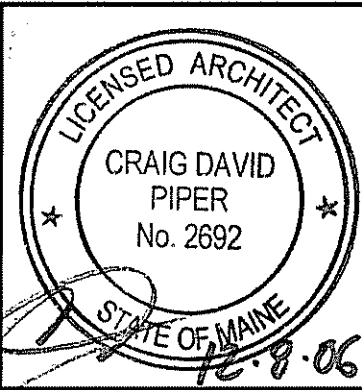

<p>CURRENT ISSUED STATUS: ISSUED FOR CONSTRUCTION 12-8-06</p>	<p>JC/DRAWN BY: MDR A/E OF RECORD: CDP SMRT CAD FILE: AF102-06043 PROJECT No: 06043 DATE: 12-8-06</p>	<p>PROJECT NORTH</p>	<p>PROJECT: MAINE MEDICAL CENTER RADIATION THERAPY RENOVATIONS PORTLAND, MAINE</p> <p>SHEET TITLE: PARTIAL FLOOR FINISH PLAN</p>	<table border="1"> <tr> <th>REV</th> <th>DESCRIPTION</th> <th>DATE</th> </tr> <tr> <td>0</td> <td>ISSUED FOR CONSTRUCTION</td> <td>12-8-06</td> </tr> </table> <p>ARCHITECTURE ENGINEERING PLANNING SMRT 144 Fore Street/P.O. Box 618 PORTLAND, MAINE 04104 Tel. (207) 772-3846 / fax. (207) 772-1070</p> <p>SMRT</p>	REV	DESCRIPTION	DATE	0	ISSUED FOR CONSTRUCTION	12-8-06
REV	DESCRIPTION	DATE								
0	ISSUED FOR CONSTRUCTION	12-8-06								