


A2 LEVEL 2 FLOOR PLAN - SECTOR A
1/4" = 1'-0"

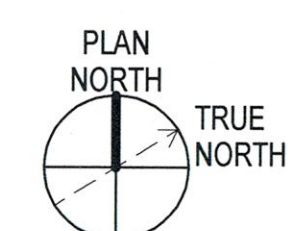

MEP ENGINEERS
AKF ENGINEERS

41 Farnsworth Street, 3rd Floor
Boston, MA 02210
617.337.3111
617.337.4211

STRUCTURAL ENGINEER
SIMPSON GUMPERTZ & HEGNER

41 Seyon Street, Building 1, Suite 1300
Waltham, MA 02453
781.907.8800
781.907.8809


MEDICAL EQUIPMENT PLANNERS
RTKL ASSOCIATES INC.

1717 PACIFIC AVENUE
DALLAS, TX 75201
214.468.7500
214.468.7501

COST ESTIMATOR
DG JONES & PARTNERS

3 Baldwin Green Common, Suite 202
Woburn, MA 01891
781.932.3131
781.932.3199

CONSTRUCTION DOCUMENTS

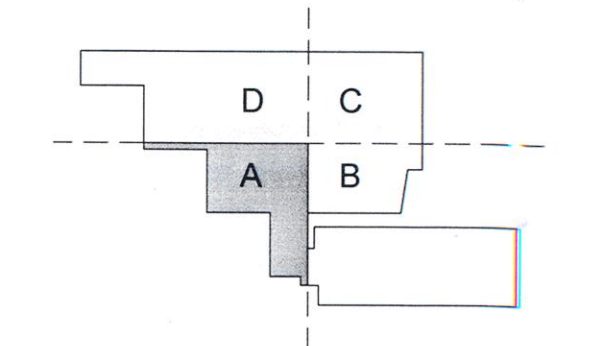

Revisions

| NO | ISSUE | DATE |
|----|-------------------|------------|
| 1 | Issued for Permit | 02/07/2014 |
| 1 | Addendum #3 | 01/17/2014 |

Sheet Information
 Date: SEPTEMBER 10, 2013
 Job #: C140135461 (MMC)/ 152168.000
 Drawn: AB
 Checked: DG
 Approved: Approver
 Title

LEVEL 02 ENLARGED PLAN - SECTOR A