

REFLECTED CEILING PLAN LEGEND

- L1 LINEAR SURFACE MOUNTED TO SMALL PROFILE
 - L2 LINEAR RECESSED TO DOWNLIGHT, 4" APERTURE, DIMMING BALLAST
 - L3 LINEAR RECESSED TO DOWNLIGHT, 4" APERTURE
 - L4 LINEAR SURFACE MOUNTED TO SMALL PROFILE
 - L5 LINEAR SURFACE MOUNTED TO 4" APERTURE
 - L6 LINEAR SURFACE MOUNTED TO SMALL PROFILE
 - L7 LINEAR CEILING GRID
 - L8 LINEAR SURFACE MOUNTED TO COVE, ASYMMETRIC OPTICS
 - L9 LINEAR MULLION MOUNTED TO COVE, 2" X 2" HOUSING
 - L10 LINEAR SURFACE MOUNTED LED STRIP
 - L11 LINEAR WALL MOUNTED TO 6" X 2" PROFILE
 - L12 LINEAR WALL MOUNTED TO 6" X 2" PROFILE
 - L13 LINEAR SURFACE MOUNTED TO UNDER-CABINET TASK LIGHT
 - L14 LINEAR SURFACE MOUNTED WARM LED, 1.5" X 2"
-
- P2 PENDANT, 4" DIA, CABLE SUSPENDED
 - R1 RECESSED CEILING LED OPEN DOWNLIGHT
 - R2 RECESSED CEILING LED OPEN DOWNLIGHT
 - R3 RECESSED CEILING LED OPEN DOWNLIGHT
 - R4 RECESSED CEILING LED OPEN DOWNLIGHT, DIMMABLE
 - R5 RECESSED CEILING LED OPEN DOWNLIGHT, 4" SQUARE
 - R6 RECESSED CEILING LED OPEN DOWNLIGHT, DIMMABLE, 4" SQUARE
 - R7 RECESSED CEILING X 1 X 1 FLUORESCENT
 - R8 RECESSED CEILING X 1 X 1 FLUORESCENT T-8
 - R9 SEMI RECESSED CEILING FLUORESCENT T-4, 1.5" X 4"
 - R10 RECESSED CEILING FLUORESCENT T8, ASYMMETRIC, ANTI-MICROBIAL
 - R11 RECESSED CEILING FLUORESCENT T8, ANTI-MICROBIAL
 - R12 RECESSED CEILING FLUORESCENT 2 X 2, ANTI-MICROBIAL
 - R13 RECESSED CEILING FLUORESCENT 2 X 2
 - R14A RECESSED CEILING FLUORESCENT T8, 40", ASYMMETRIC
 - R14B RECESSED CEILING FLUORESCENT T8, 24" ASYMMETRIC
 - R15 RECESSED CEILING LED, 7" SQUARE
 - R16 RECESSED CEILING LED, 7" ROUND
 - R17 RECESSED CEILING LED, 2.5" ROUND
-
- S1 STEM MOUNTED LINEAR T8 2" DIA
 - S2 FLOOR MOUNTED
-
- W2 WALL SURFACE MOUNTED LINEAR FLUORESCENT UPLIGHT
 - W3 WALL SURFACE MOUNTED, FROSTED LENS DOWNLIGHT
 - W4 WALL SURFACE MOUNTED, FROSTED LENS UP & DOWNLIGHT
 - W5 CEILING SURFACE MOUNTED, FROSTED LENS
 - W6 LINEAR SURFACE MOUNTED, DUAL SIDEWRIGHT LENS
-
- ACT-1 2x2 SUSPENDED ACOUSTICAL CEILING
 - ACT-2 2x4 SUSPENDED ACOUSTICAL CEILING, WASHABLE, CLIP-DOWN
 - ACT-3 2x4 SUSPENDED ACOUSTICAL CEILING
 - ACT-4 2x4 SUSPENDED ACOUSTICAL CEILING, WASHABLE, CLIP-DOWN
-
- GWB CEILING
 - EXPANSION JOINT
 - ACCESS PANEL
 - ANESTHESIOLOGY PANEL
 - SERVICE PANEL
 - RADIANT PANEL
 - 2x2 SUPPLY
 - 6x6 SUPPLY
 - 2x2 RETURN
 - 2x4 RETURN
 - 6x6 RETURN
-
- FIRE ALARM SPEAKER
 - SMOKE DETECTOR
 - SPRINKLER
 - EXIT SIGN
 - NURSE CALLCODE BLUE - CEILING
 - NURSE CALLCODE BLUE - WALL
 - SECURITY CAMERA (NC)
 - FIRE SHUTTER
 - BOOM
 - OCCUPANCY SENSOR
 - PUBLIC ADDRESS SPEAKER
 - NURSE CALL LAMP
 - PHOTO CELL
 - WIRELESS OUTLET
 - OBSCURE PRIVACY CURTAIN TRACK
 - IV TRACK
 - MEMO SHADE

RCP GENERAL NOTES

1. SEE ELEVATIONS FOR LOCATION OF LED LIGHTING AT RECEPTION AND COMMUNICATION STATION DESKS.
2. SEE TYPICAL MOUNTING HEIGHT FOR MOUNTING HEIGHT OF WALL SCONES.
3. COORDINATE TEES AND HANGER LOCATIONS WITH LINEAR DIFFUSIBLE GRILLE SIZES.
4. SPRINKLER HEAD AND COVER TO BE CUSTOM COLORED BY MANUFACTURER TO MATCH ADJ. CEILING FINISH. COLOR TO BE DETERMINED BY ARCHITECT.
5. UNLESS OTHERWISE NOTED, CENTER ALL SUSPENDED CEILING GRILLES WITH ROOM.
6. CENTER ALL LIGHT FIXTURES, SPRINKLER HEADS, ETC. IN CEILING TILE UNLESS OTHERWISE NOTED.
7. SEE ENGINEERING DRAWINGS FOR ADDITIONAL INFORMATION, I.E. LIGHT FIXTURES, DIFFUSERS AND OTHER CEILING MOUNTED DEVICES.
8. COORDINATE CEILING MOUNTED EQUIPMENT FINAL LAYOUT WITH OWNER AND VENDOR INSTALLATION DRAWINGS.
9. PROVIDE UNDER-CABINET LIGHT AT ALL LOCATIONS WITH UPPER CABINETS.
10. PROVIDE LED FLUORESCENT STRIP LIGHTING AS REQUIRED WITHIN LEVEL 4 PENTHOUSE - REFER TO ELECTRICAL.

PERKINS + WILL
 225 Franklin St., Suite 1100
 Boston, MA 02110
 1.617.470.0000
 1.617.478.0321
 www.perkinswill.com

Maine Medical Center
 MainHealth

Bean 2 Roof Addition
 22 Bramhall Street, Portland, Maine 04102

MEP ENGINEER
AKF ENGINEERS

41 Farnsworth Street, 3rd Floor
 Boston, MA 02210
 1.617.737.3111
 1.617.907.9000
 1.617.907.9009

STRUCTURAL ENGINEER
SIMPSON GUMPERT & HEGER

41 Seyon Street, Building 1, Suite 500
 Watbury, MA 02453
 1.781.907.9000
 1.781.907.9009


MEDICAL EQUIPMENT PLANNERS
RTKL ASSOCIATES INC.

1712 PACIFIC AVENUE
 DALLAS, TX 75201
 1.214.468.7600
 1.214.468.7601

COST ESTIMATOR
DG JONES & PARTNERS

3 Baldwin Green Common, Suite 202
 Watbury, MA 01607
 1.781.932.3131
 1.781.932.3199

CONSTRUCTION DOCUMENTS

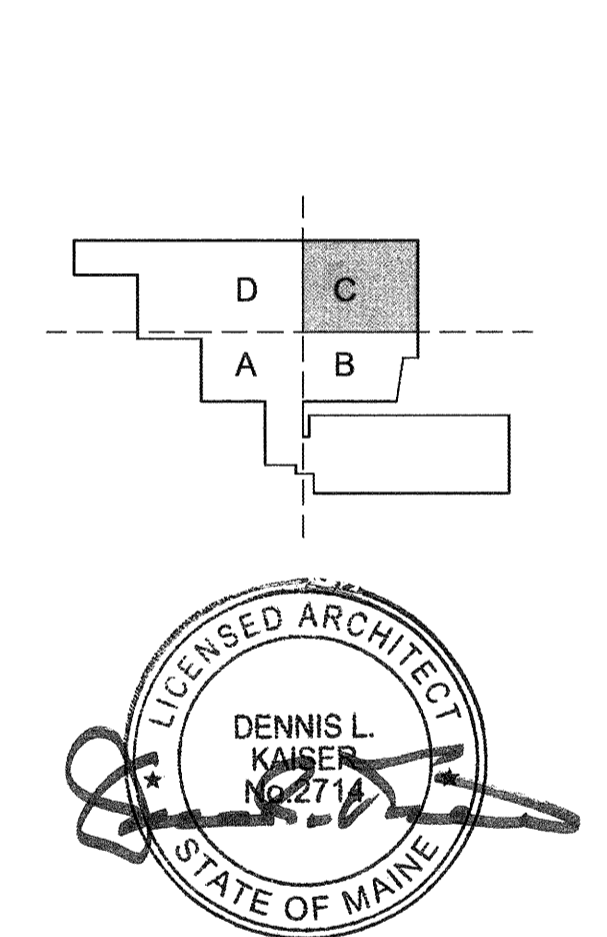

Revisions

NO.	ISSUE	DATE
1	Issued for Permit	02/07/2014
2	Addendum #3	01/17/2014
3	NO.	DATE

Sheet Information
 Date: SEPTEMBER 10, 2013
 Job #: C140135481 (MMC) 152168.000
 Drawn: TH
 Checked: DG
 Approved: Approver
 Title

LEVEL 02 ENLARGED RCP - SECTOR C

Sheet
A05-02C

A1 LEVEL 02 ENLARGED RCP - SECTOR C
 1/4" = 1'-0"

