
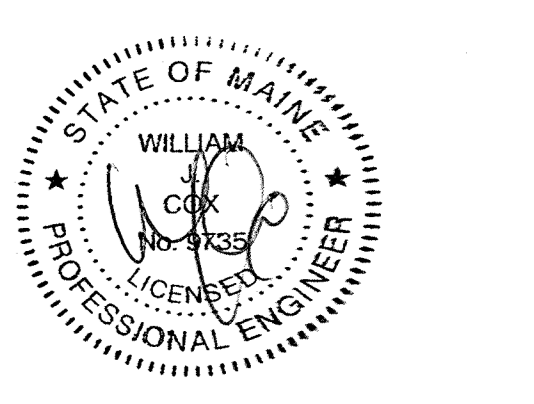


**CONSTRUCTION
DOCUMENTS**

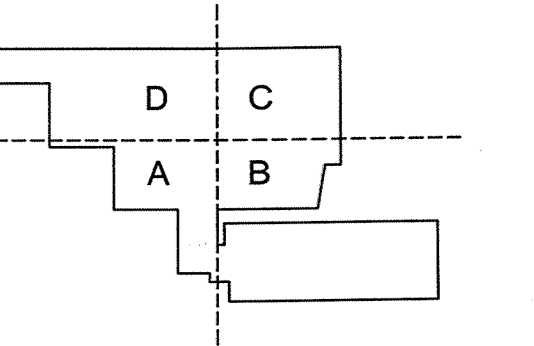


Revisions

2	Issued for Permit	2-07-14
1	Addendum #3	1-17-14
NO	ISSUE	DATE
Sheet Information		
Date	JUNE 14, 2013	
Job #	C140135461(MMC)/152168.000	
Drawn		
Checked		
Approved		


**EXISTING ELECTRICAL
SUB-BASEMENT
POWER PLAN -
ELECTRIC ROOMS**

Sheet


E03-00

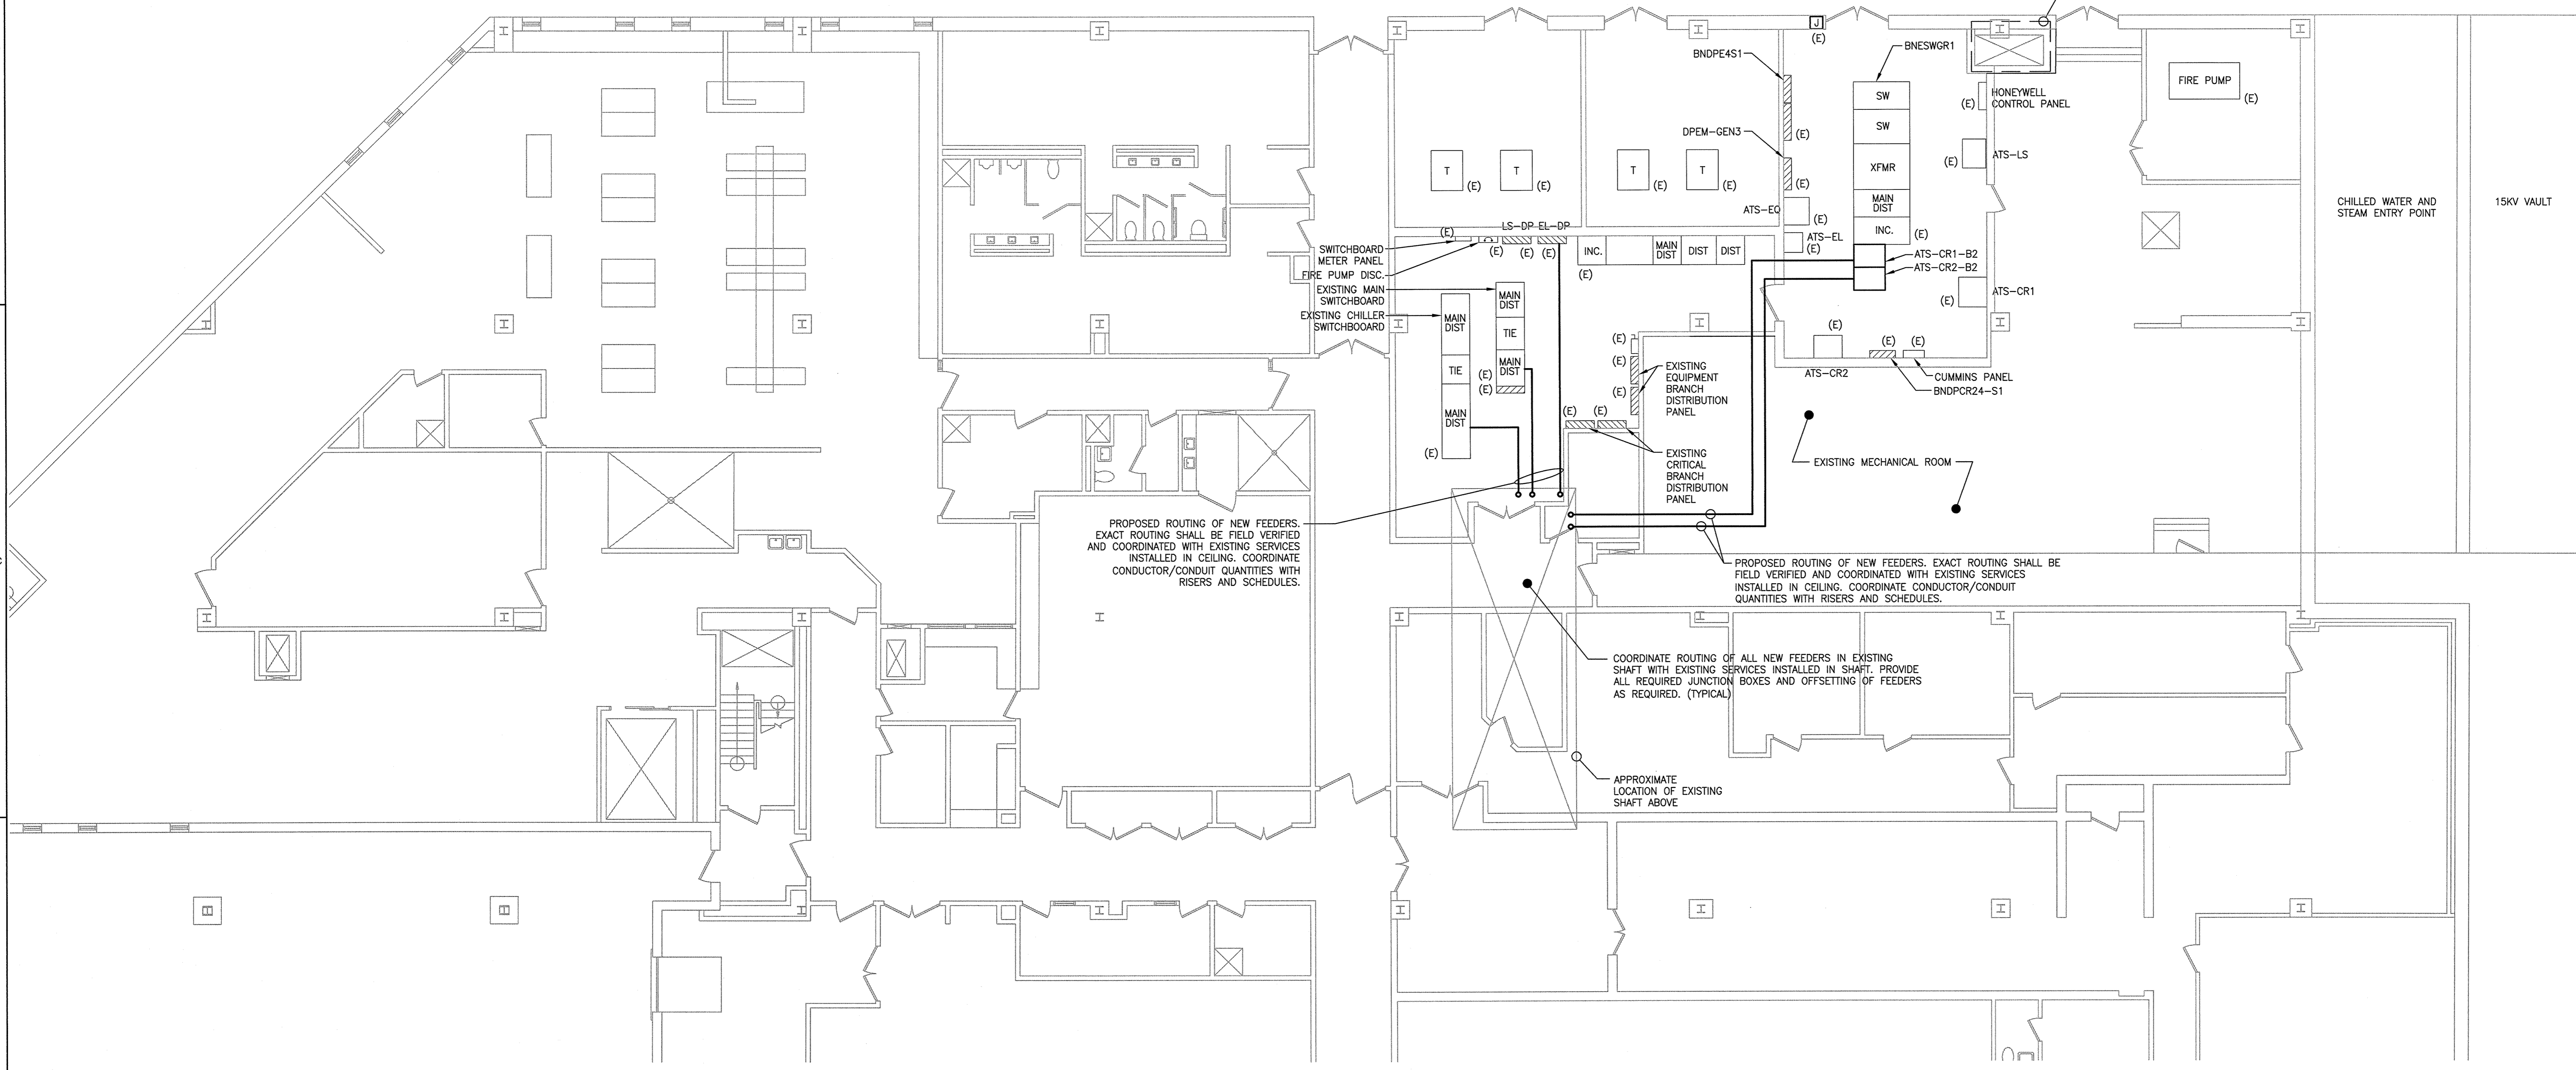

1 ELECTRICAL SUB-BASEMENT POWER PLAN - ELECTRIC ROOMS
SCALE: 1/8" = 1'-0"

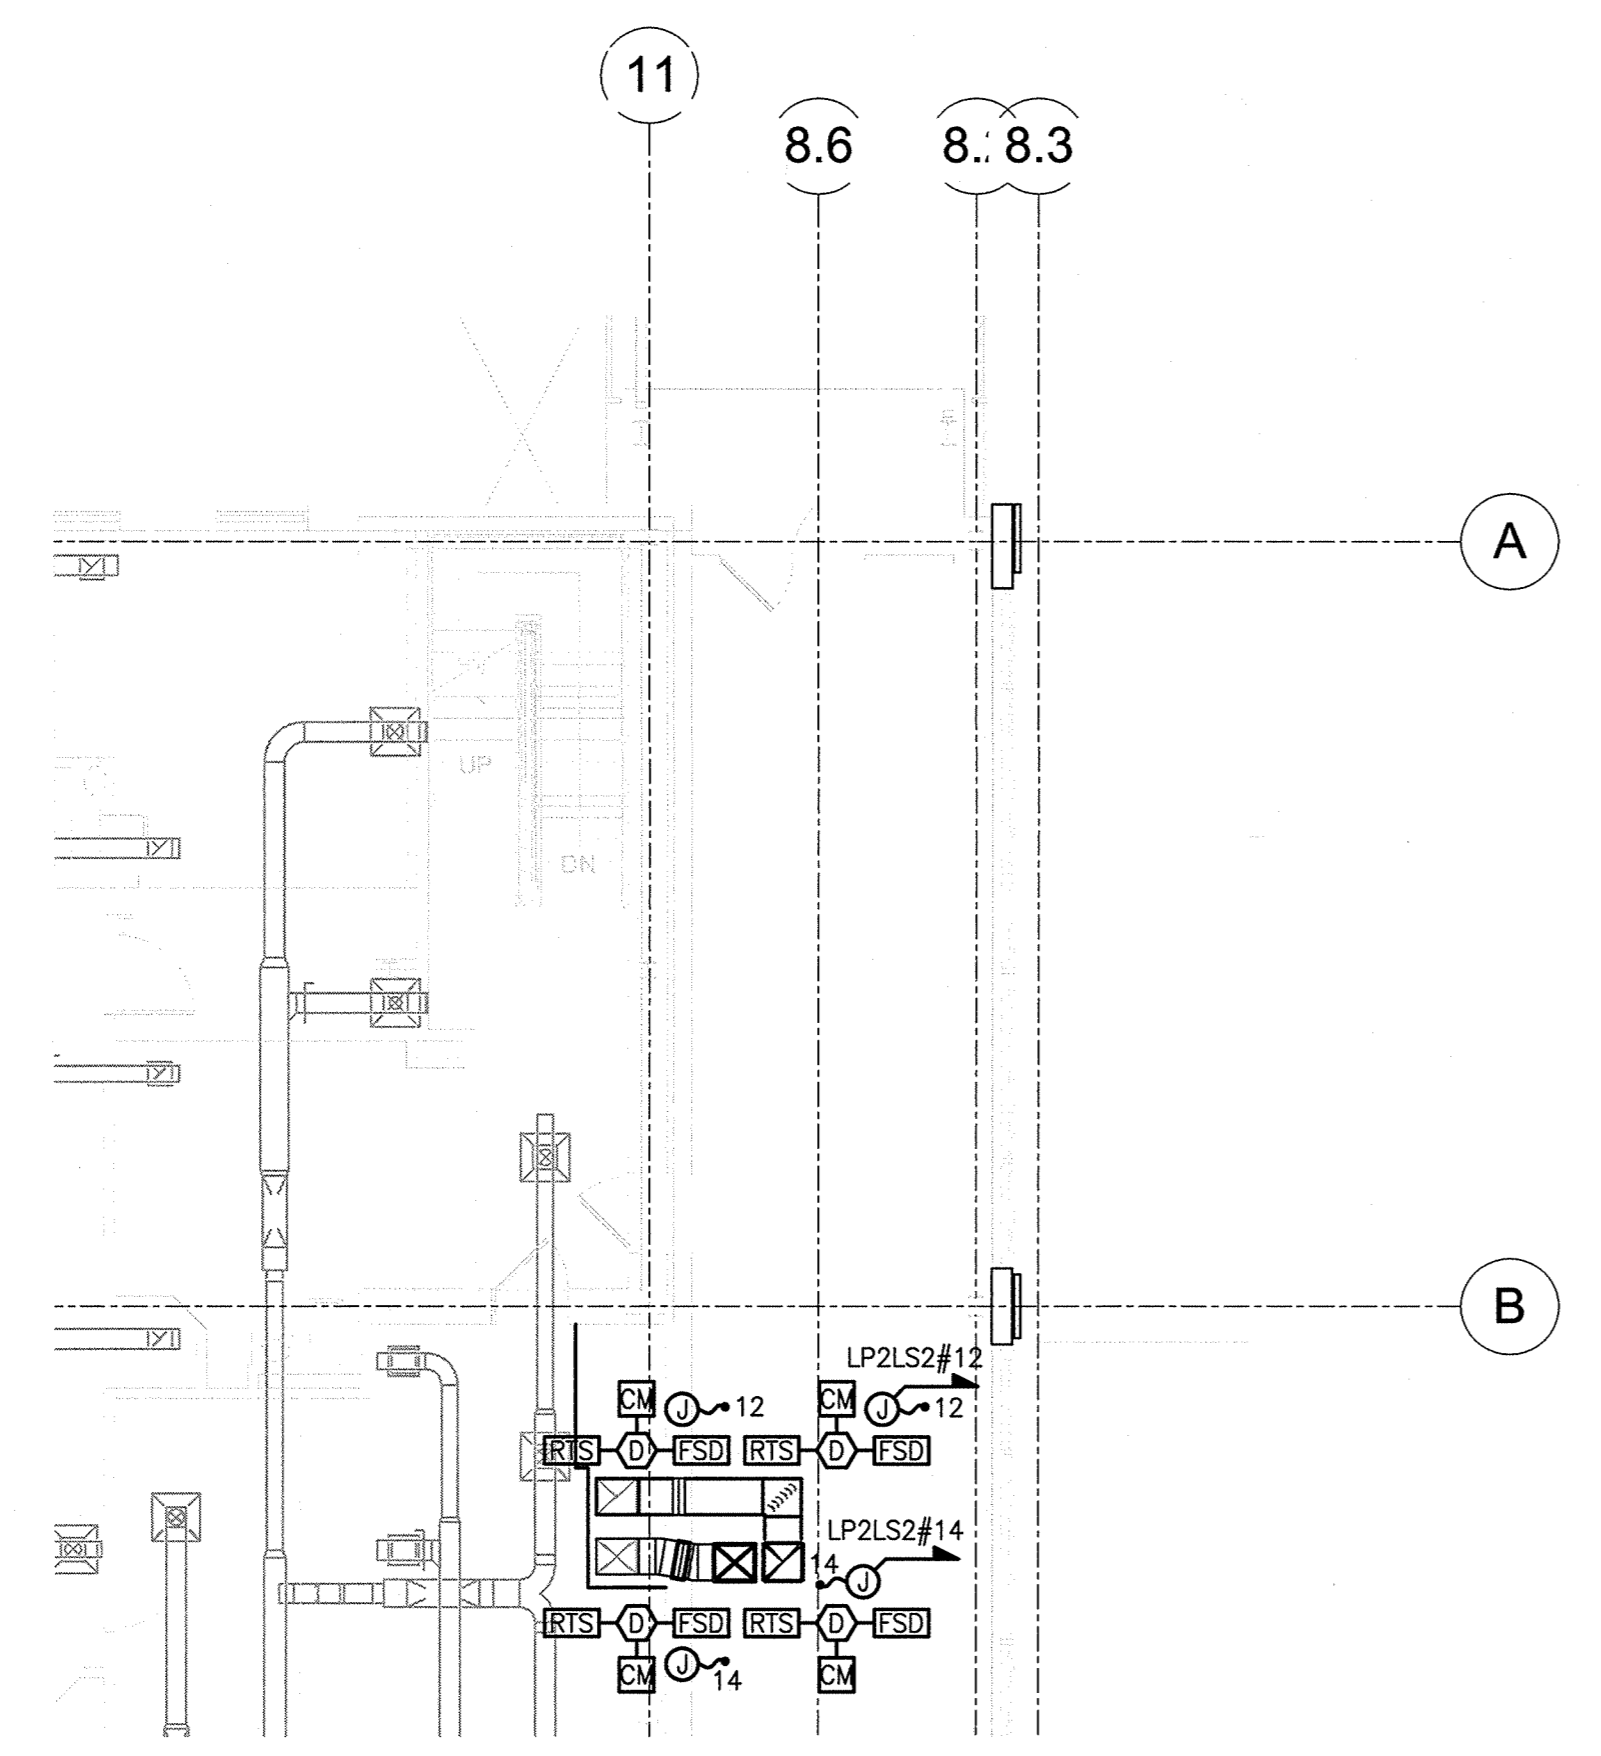

2 FIRE ALARM PART PLAN
SCALE: 1/8" = 1'-0"

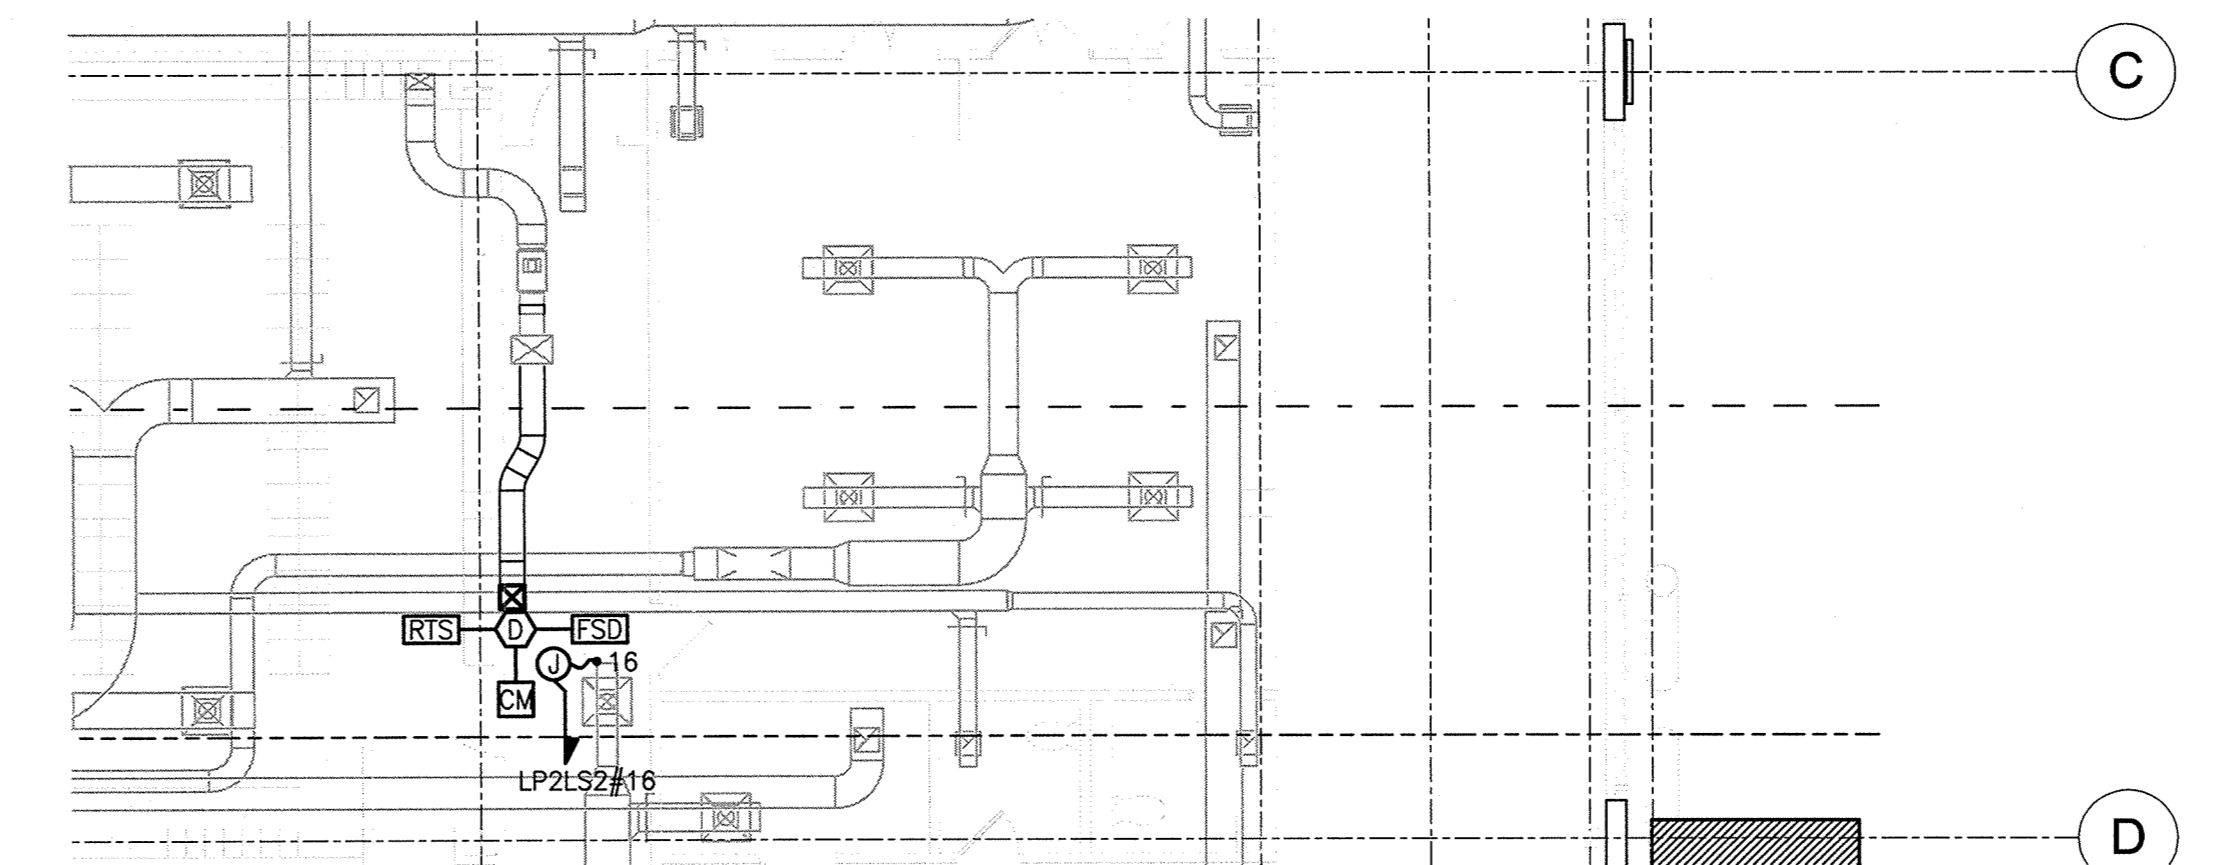

3 FIRE ALARM PART PLAN
SCALE: 1/8" = 1'-0"

