
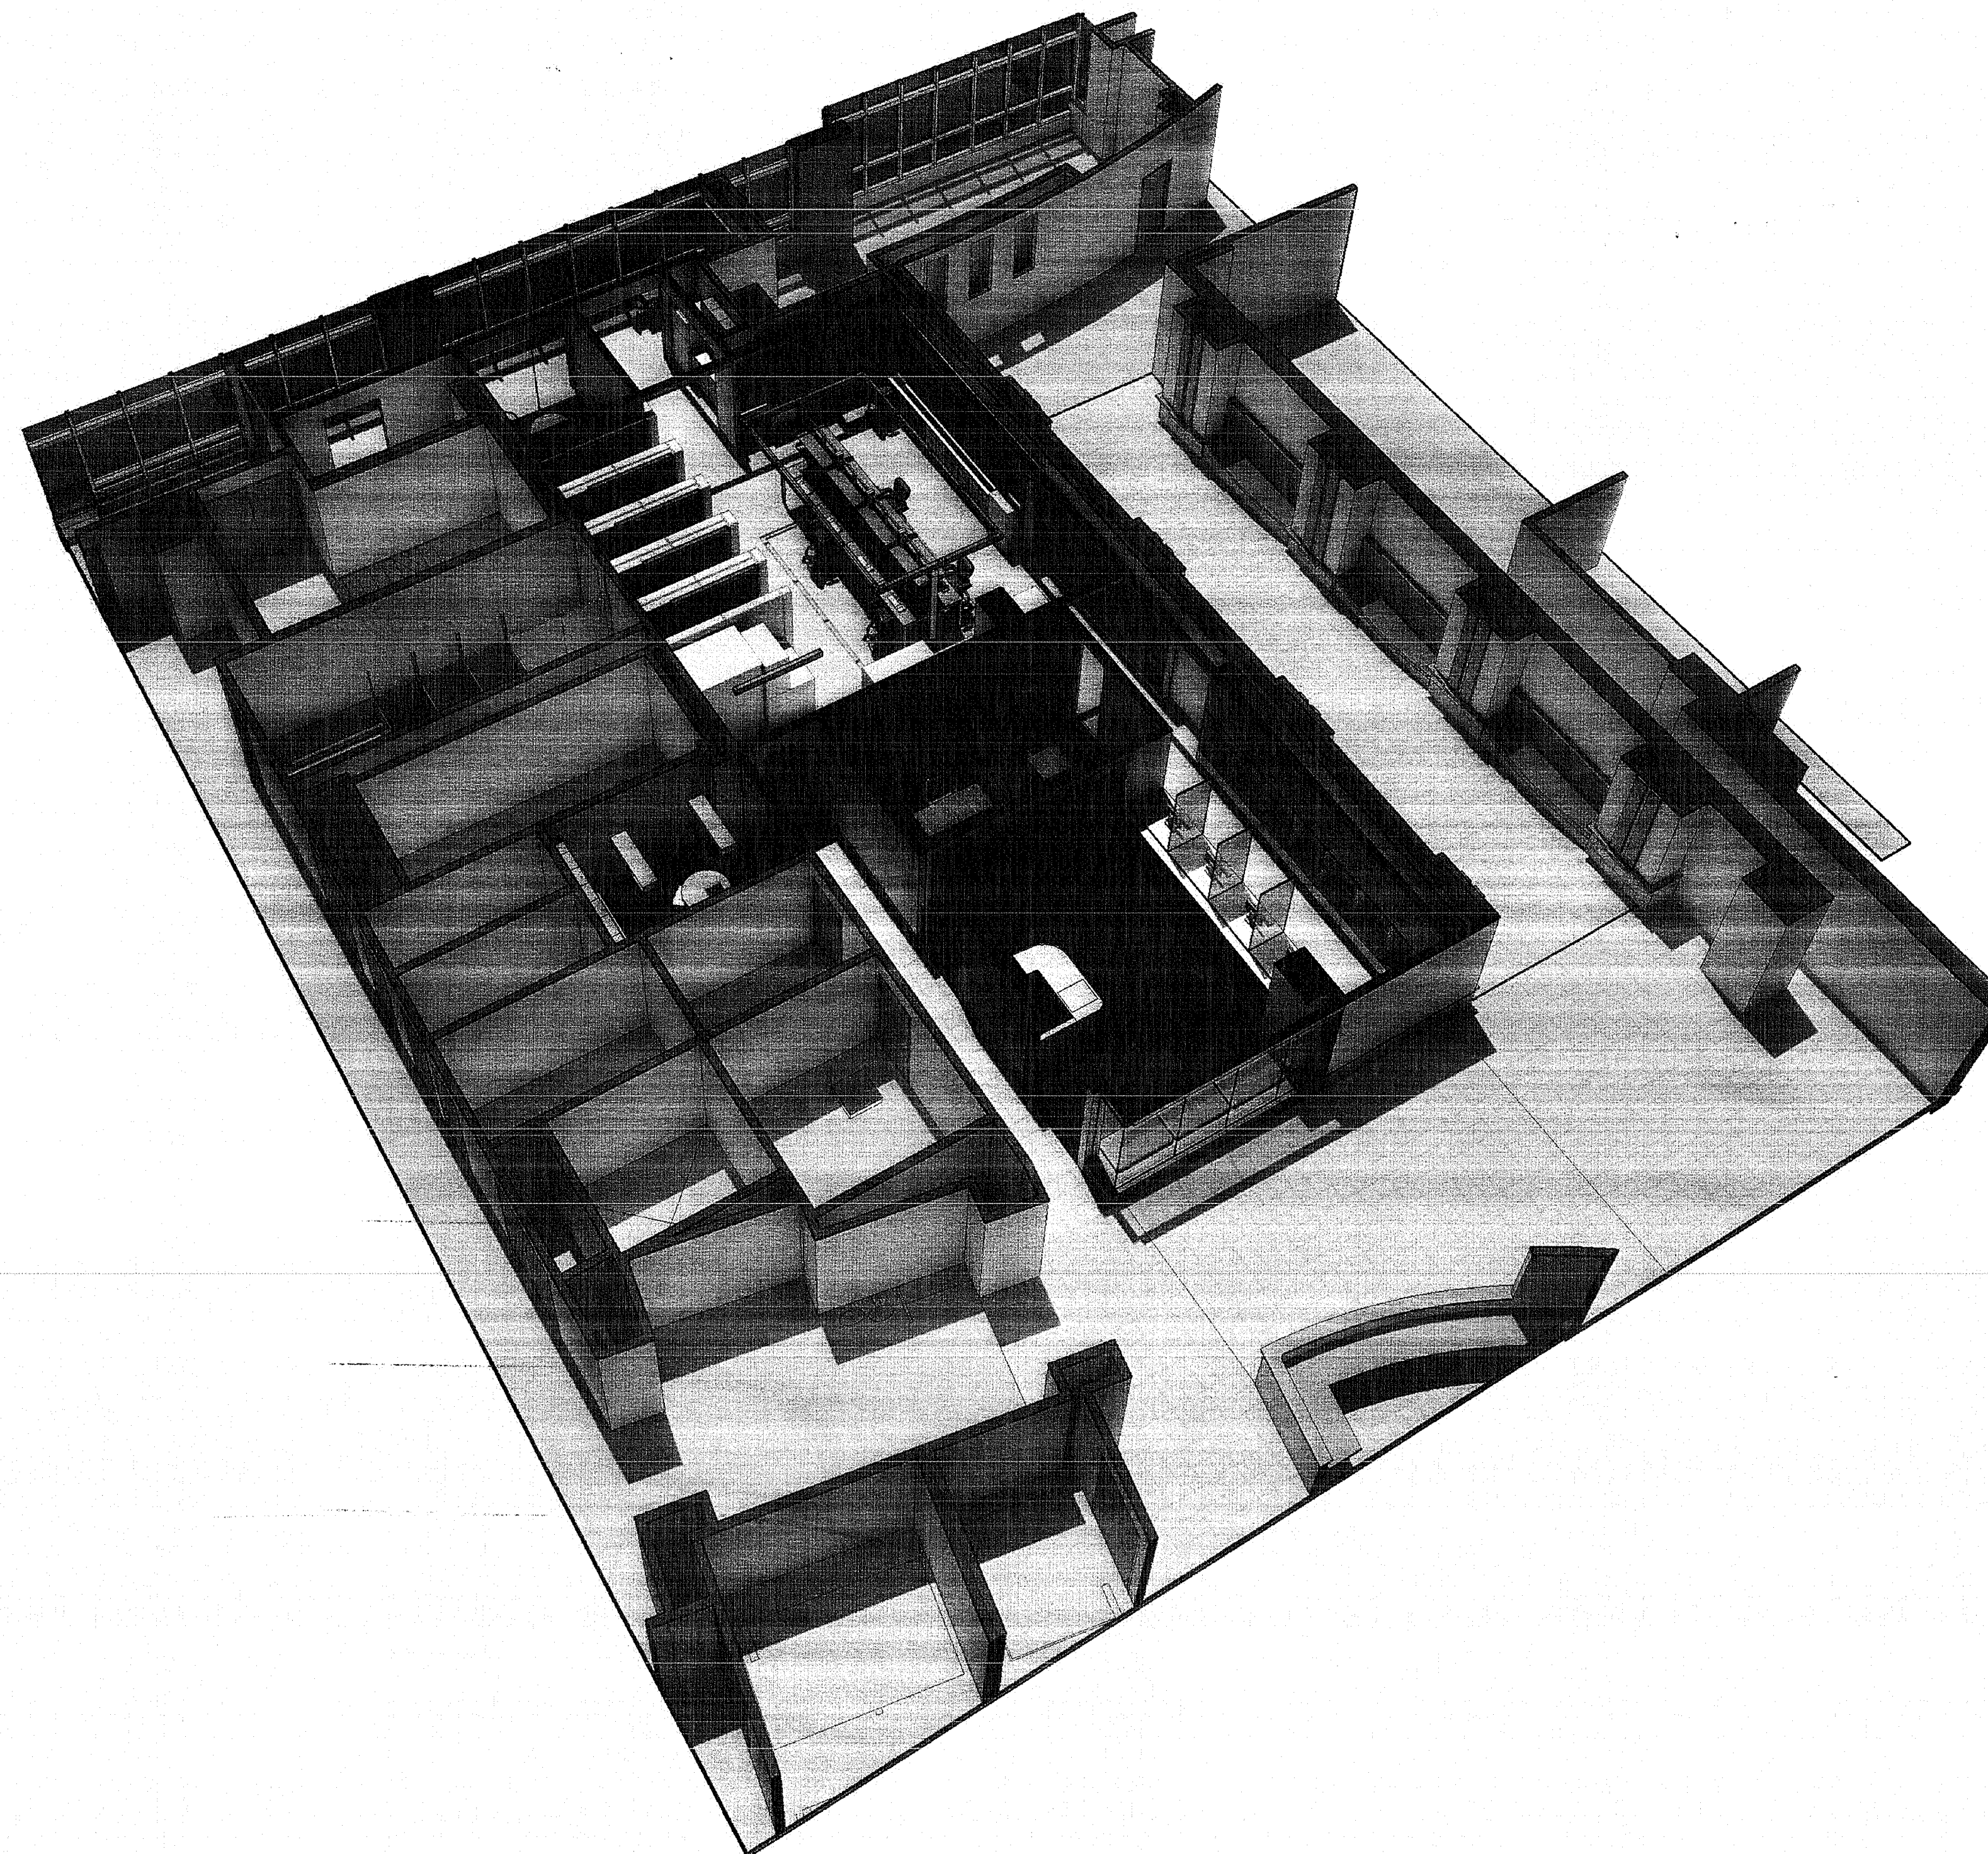
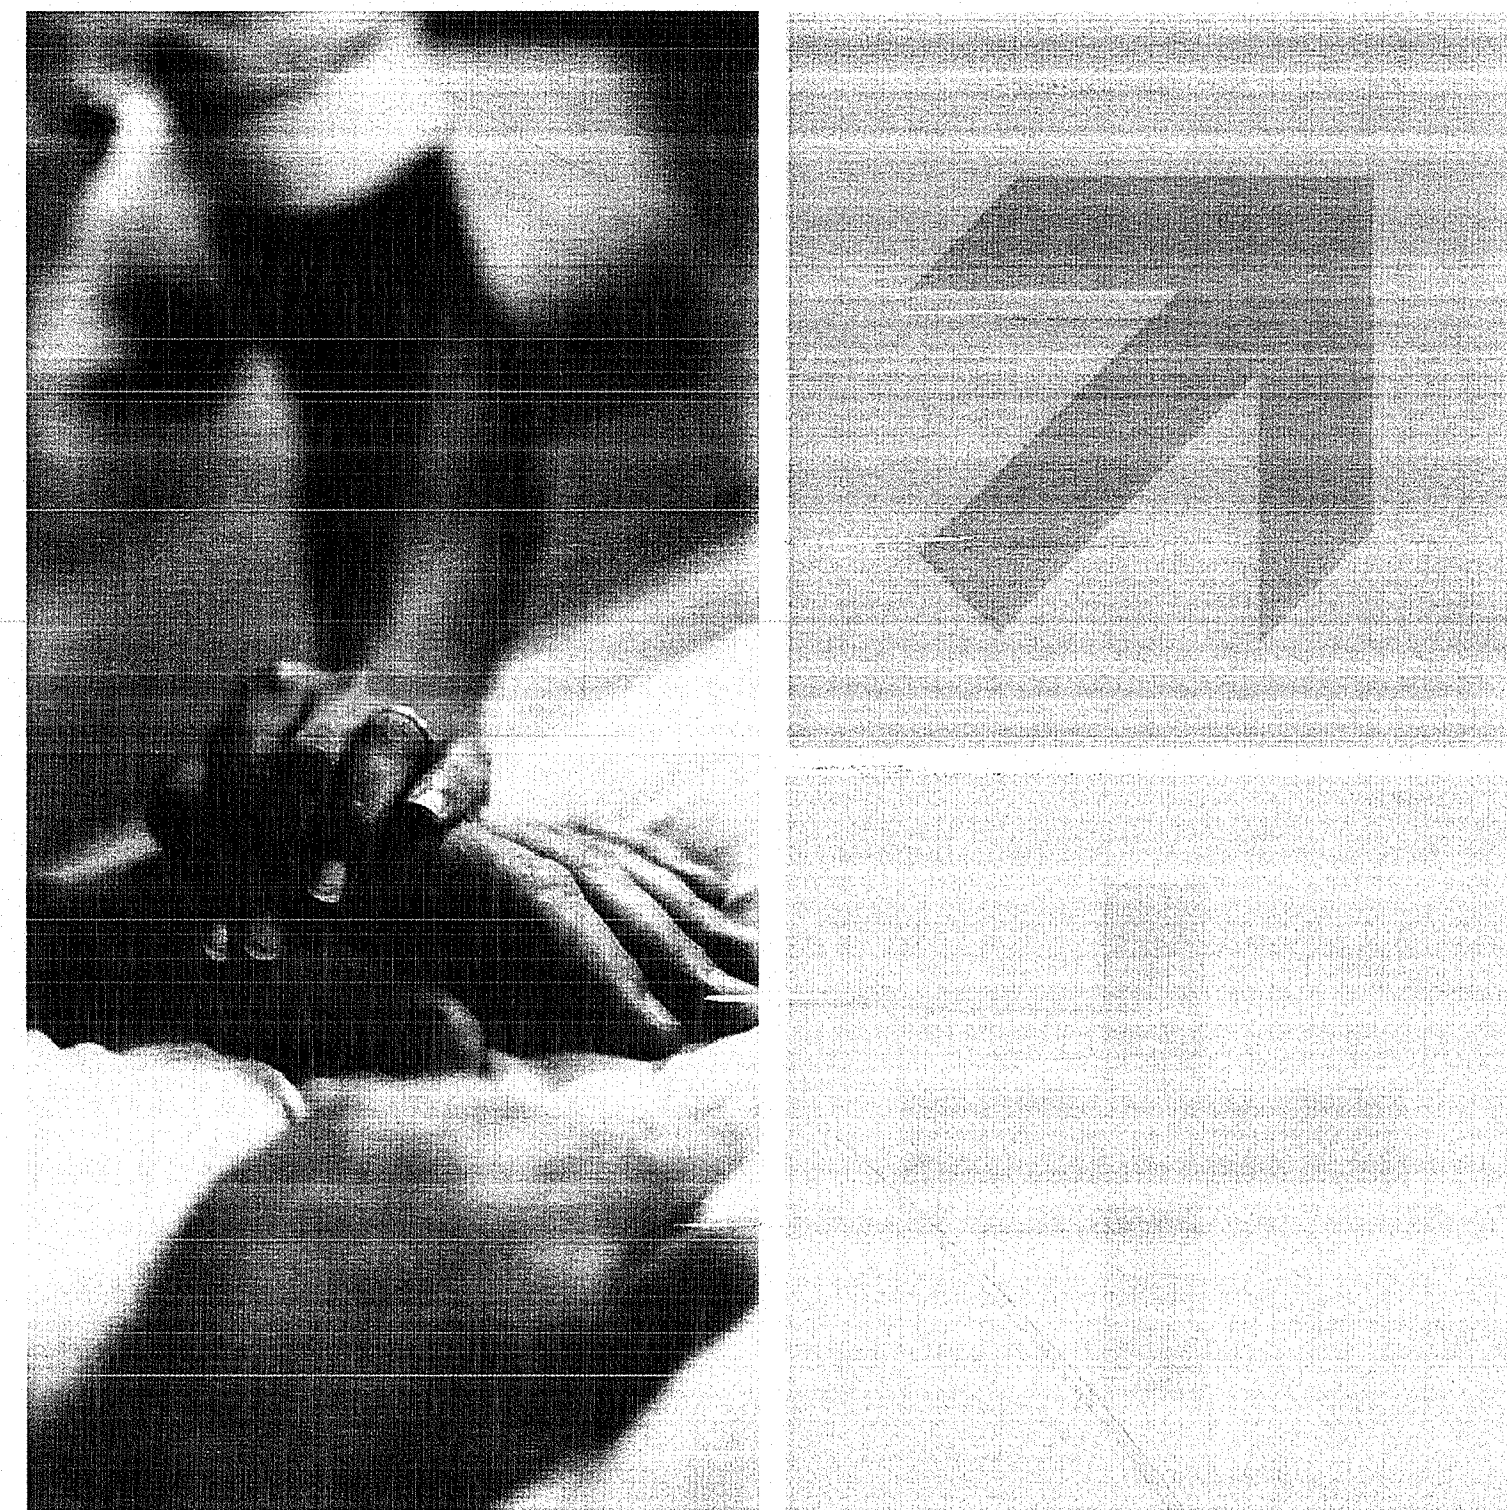
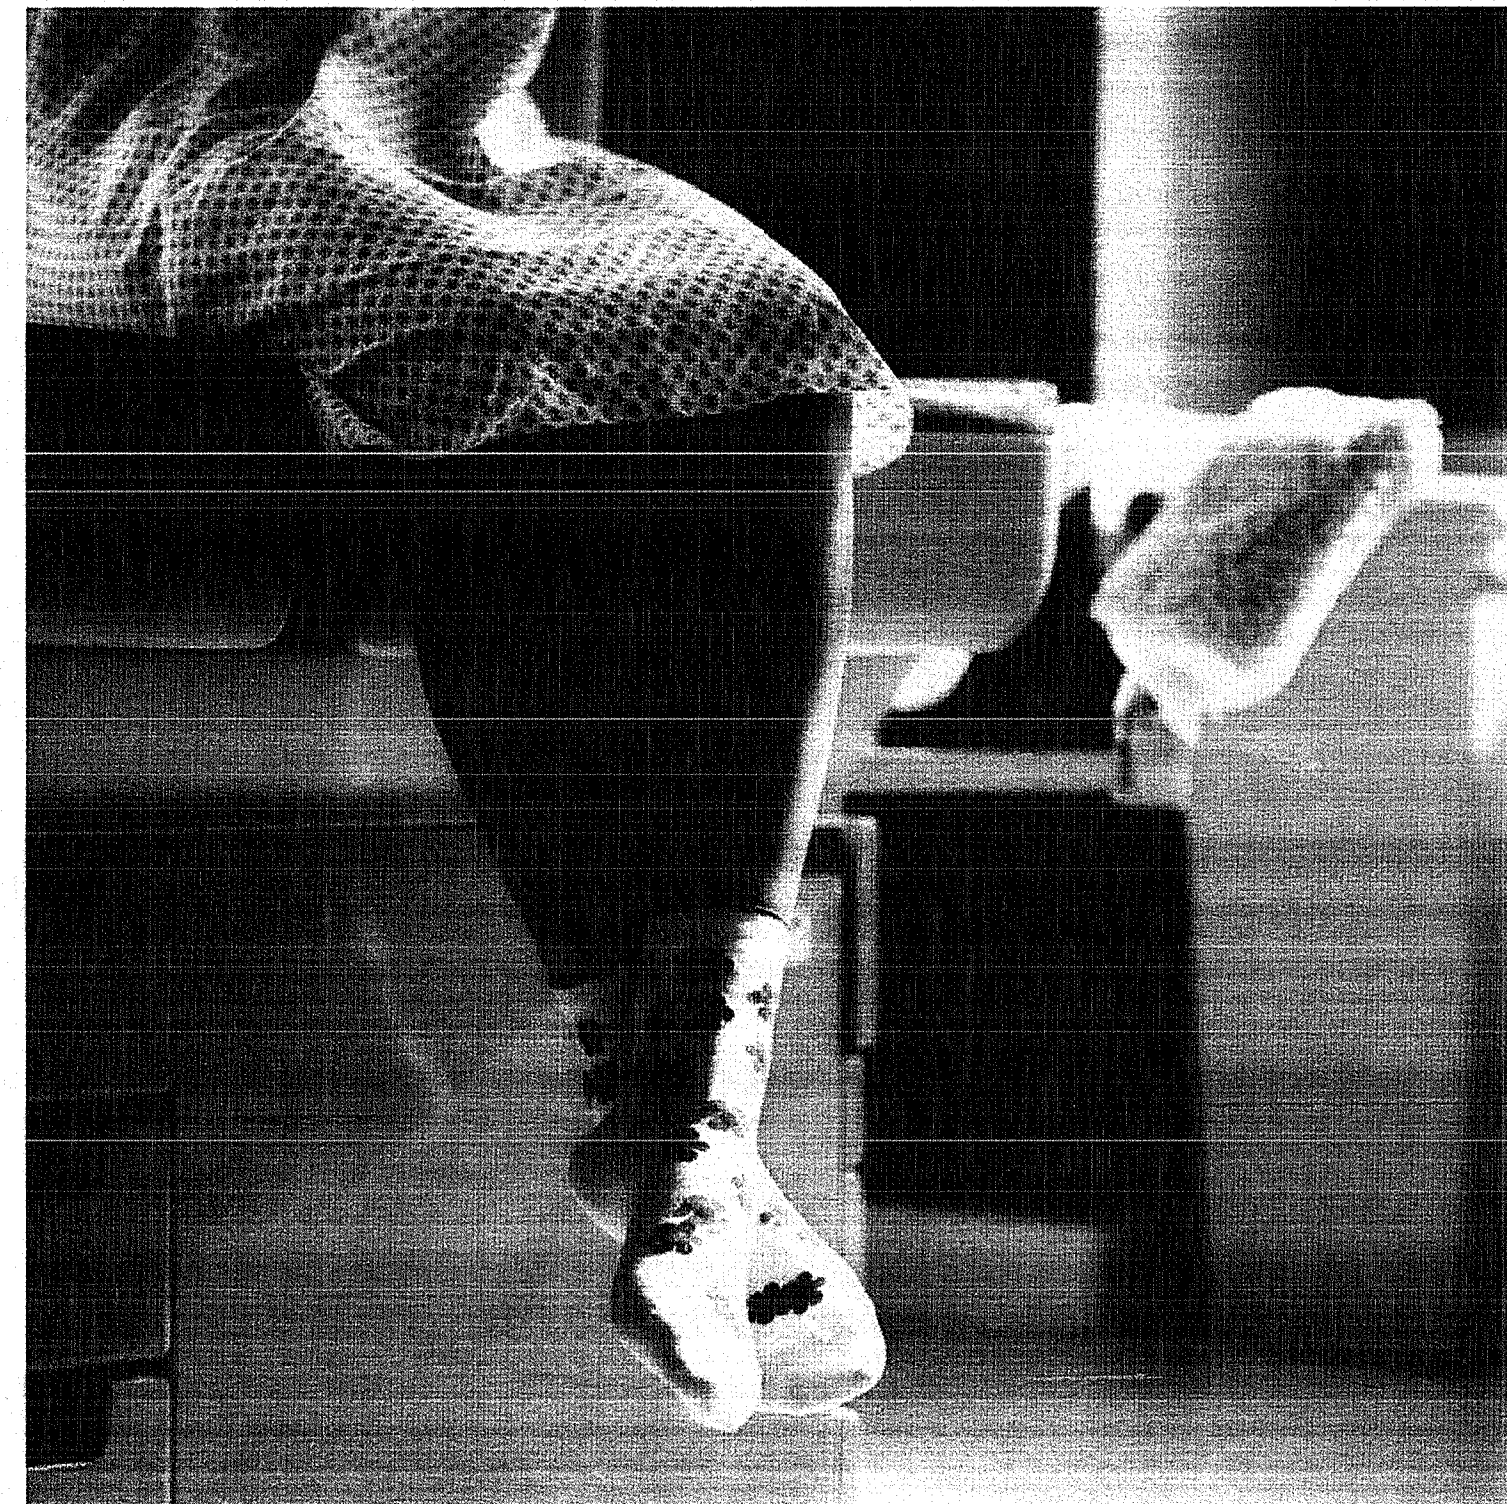


ISSUED FOR PERMIT

AUGUST 11, 2014

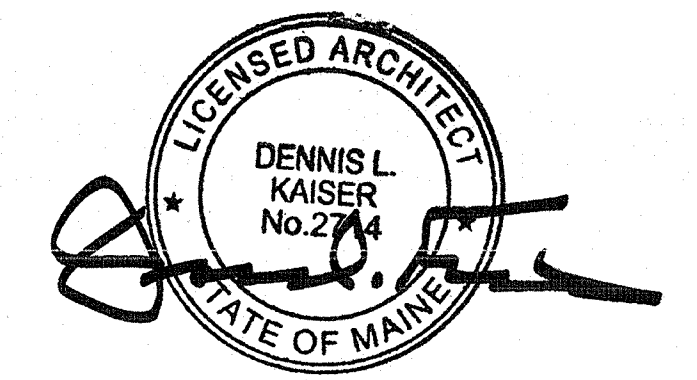

INDEX OF DRAWINGS			
SHEET NUMBER	SHEET NAME	ISSUED FOR BID 07.11.2014	ISSUED FOR PERMIT 08.11.2014
G00-00	COVER SHEET		
A00-01	ARCHITECTURAL ABBREVIATIONS, SYMBOLS & NOTES		
A00-12	TYPICAL MOUNTING HEIGHTS		
A00-15	LEVEL 01 CODE COMPLIANCE PLAN		
A00-40	INTERIOR PARTITION TYPE CHARTS		
A00-41	PARTITION HEAD AND MISC. GWB DETAILS		
A00-42	PARTITION HEAD AND MISC. GWB DETAILS		
A00-50	DOOR SCHEDULE, TYPES & FINISH SCHEDULE		
A00-51	DOOR DETAILS		
A01-01	LEVEL 01 OVERALL PLAN		
A02-00	BASEMENT DEMOLITION PLAN		
A02-01	LEVEL 01 DEMOLITION PLAN		
A04-01	LEVEL 01 FLOOR PLAN		
A05-01	LEVEL 01 REFLECTED CEILING PLAN		
A05-01	LEVEL 01 FINISH PLAN		
A07-01	LEVEL 01 POWER AND SIGNAL PLAN		
A08-01	LEVEL 01 EQUIPMENT AND FURNITURE PLAN		
A10-01	INTERIOR ELEVATIONS		
A10-02	INTERIOR ELEVATIONS		
A10-40	INTERIOR DETAILS		
A10-41	INTERIOR DETAILS		
A10-50	MILLWORK DETAILS		
A10-51	MILLWORK DETAILS - POINT OF SALE		
A10-52	MILLWORK DETAILS - BENCH & WOOD WALL		
A10-53	MILLWORK DETAILS - TRANSACTION COUNTER		
M000	MECHANICAL COVER SHEET		
M100	MECHANICAL DEMOLITION PLAN		
M200	MECHANICAL DUCTWORK PLAN		
M300	MECHANICAL PIPING PLAN		
M400	MECHANICAL SCHEDULES AND DETAILS		
M500	MECHANICAL SPECIFICATIONS SHEET 1 OF 2		
M501	MECHANICAL SPECIFICATIONS SHEET 2 OF 2		
F000	FIRE PROTECTION COVER SHEET		
F100	FIRE PROTECTION DEMOLITION SPRINKLER PLAN		
F200	FIRE PROTECTION SPRINKLER PLAN		
F300	FIRE PROTECTION DETAILS		
F400	FIRE PROTECTION SPECIFICATIONS		
P000	PLUMBING COVER SHEET		
P100	PLUMBING DEMOLITION BASEMENT PLAN		
P101	PLUMBING DEMOLITION FLOOR PLAN		
P200	PLUMBING BASEMENT PLAN		
P201	PLUMBING FLOOR PLAN		
P300	PLUMBING SCHEDULES AND DETAILS		
P400	PLUMBING SPECIFICATIONS		
E000	ELECTRICAL COVER SHEET		
E100	ELECTRICAL DEMOLITION LIGHTING PLAN		
E101	ELECTRICAL DEMOLITION POWER PLAN		
E200	ELECTRICAL LIGHTING PLAN		
E300	ELECTRICAL POWER PLAN		
E400	ELECTRICAL FIRE ALARM PLAN		
E400	ELECTRICAL SCHEDULES AND RISER DIAGRAMS		
E400	ELECTRICAL SPECIFICATIONS SHEET 1 OF 2		
E401	ELECTRICAL SPECIFICATIONS SHEET 2 OF 2		