


MAINE MEDICAL CENTER

22 Bramhall Street
Portland, ME 04102

SYMBIA INTEVO 2

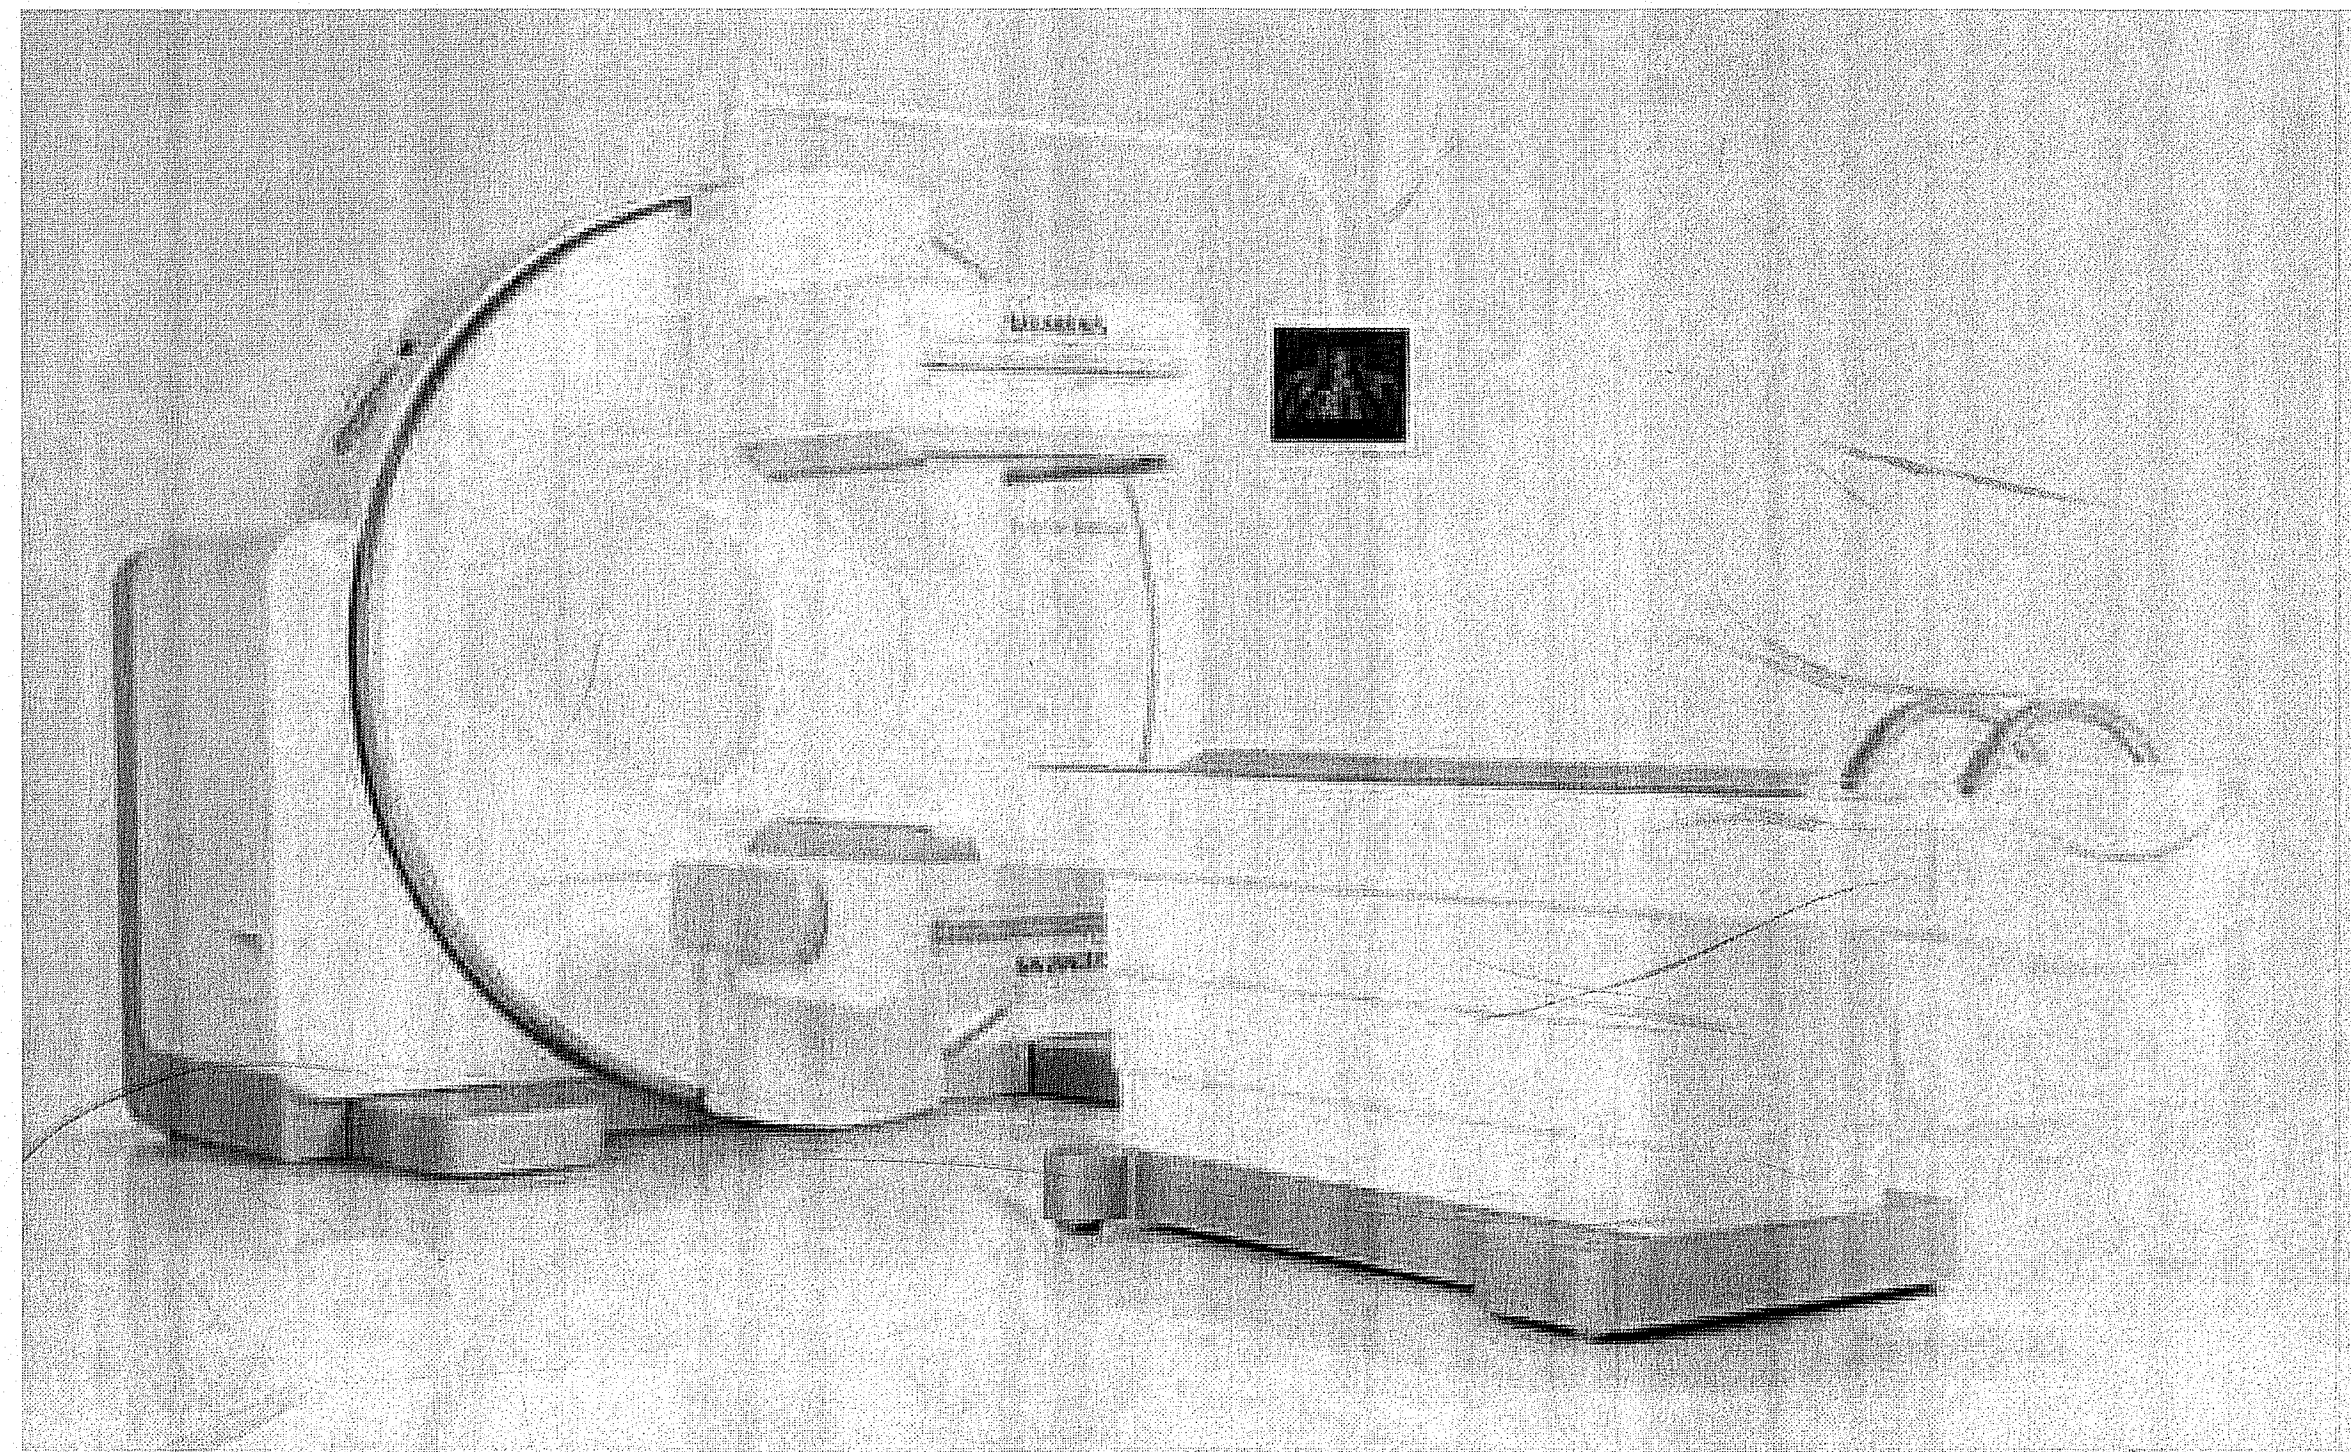

Contents:

Sheet No.	Description
A-101	EQUIPMENT PLAN-LEGEND, DETAILS AND NOTES
A-102	SAFETY SERVICE CLEARANCE PLAN, DETAILS AND NOTES
S-101	STRUCTURAL PLAN-DETAILS AND NOTES
S-501	DETAILS AND NOTES
E-101	ELECTRICAL PLAN(S)-LEGEND AND NOTES
E-102	ELECTRICAL PLAN-LEGEND AND NOTES

Project Contacts:

Siemens
Project Manager
Rich Deister
Phone: (207) 712-3205
rich.deister@siemens.com

Maine Medical Center
Customer Contact
Marshall Bartlett
Phone: (207) 662-2988

Planner
Robert Hill

Project #: 1402948

SIEMENS
SIEMENS MEDICAL SOLUTIONS
51 Valley Stream Parkway
Malvern, PA 19355
www.usa.siemens.com/medical