





**NOTE:**

1. SEE SHEET M-001 FOR LEGEND AND ABBREVIATIONS.

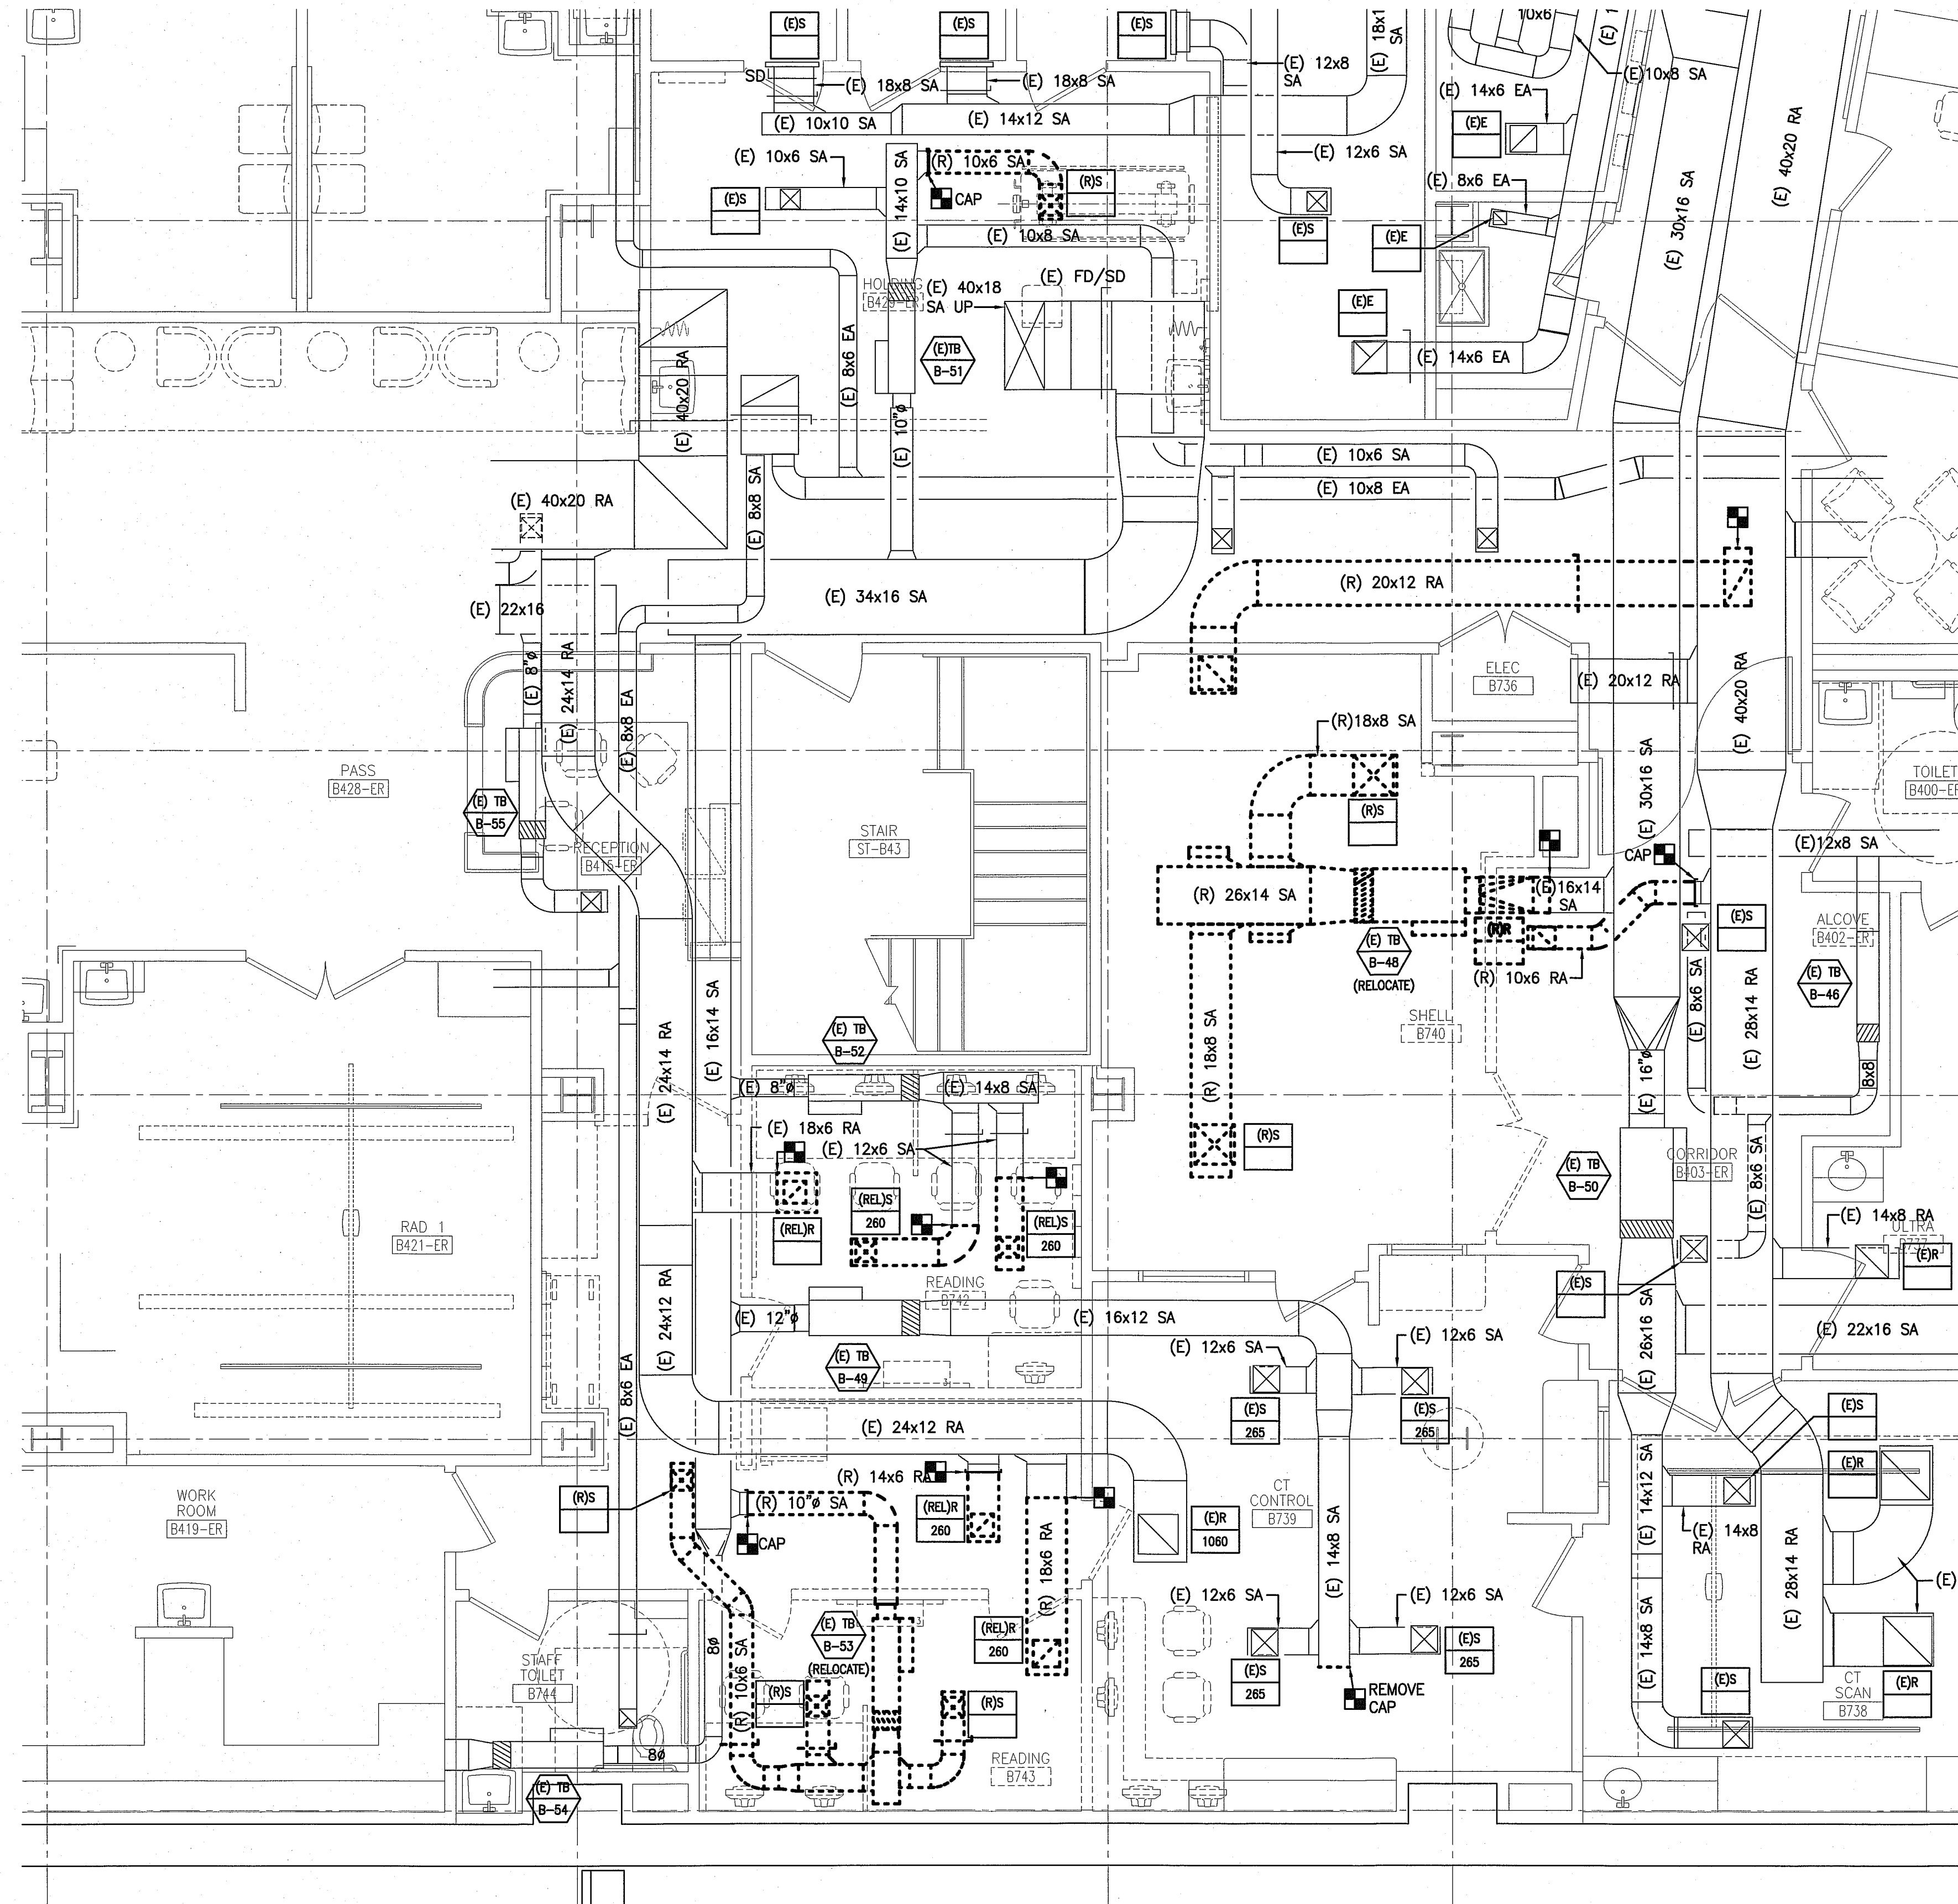

144 Fore Street/P.O. Box 618  
Portland, Maine 04104  
tel. (207) 772-3846  
fax. (207) 772-1070  
www.smartinc.com

ARCHITECTURE  
ENGINEERING  
PLANNING  
INTERIOR DESIGN  
COMMISSIONING

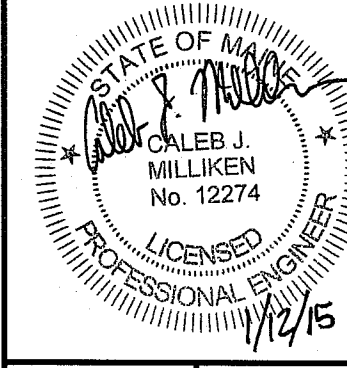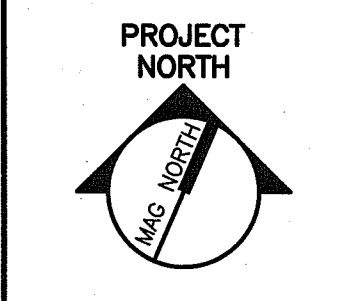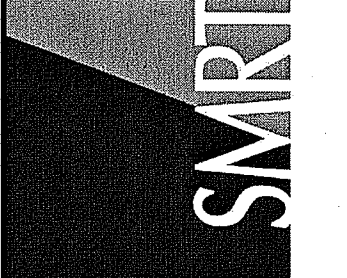

**MAINE MEDICAL CENTER  
ED CT FIT-UP AND READING RENOVATIONS**  
PORTLAND, MAINE

**ISSUED FOR PERMITTING  
1-12-15**

CURRENT ISSUE STATUS:

REV.	DESCRIPTION	DATE

GRAPHIC SCALE:  
0" 1"

SCALE: 1/4"=1'-0"  
PROJECT MANAGER: DJV  
JC/DRAWN BY: MDR/BGC  
A/E OF RECORD: CJM  
CAD FILE: MD101-14153  
PROJECT NO: 14150  
DATE:

SHEET TITLE:  
**HVAC DUCTWORK  
DEMOLITION PLAN**

**A6 FLOOR PLAN**

1/4"=1'-0"

SHEET No.  
**MD101**  
© copyright 2013 SMART INC.