





NOTE:

1. SEE SHEET M-001 FOR LEGEND AND ABBREVIATIONS.

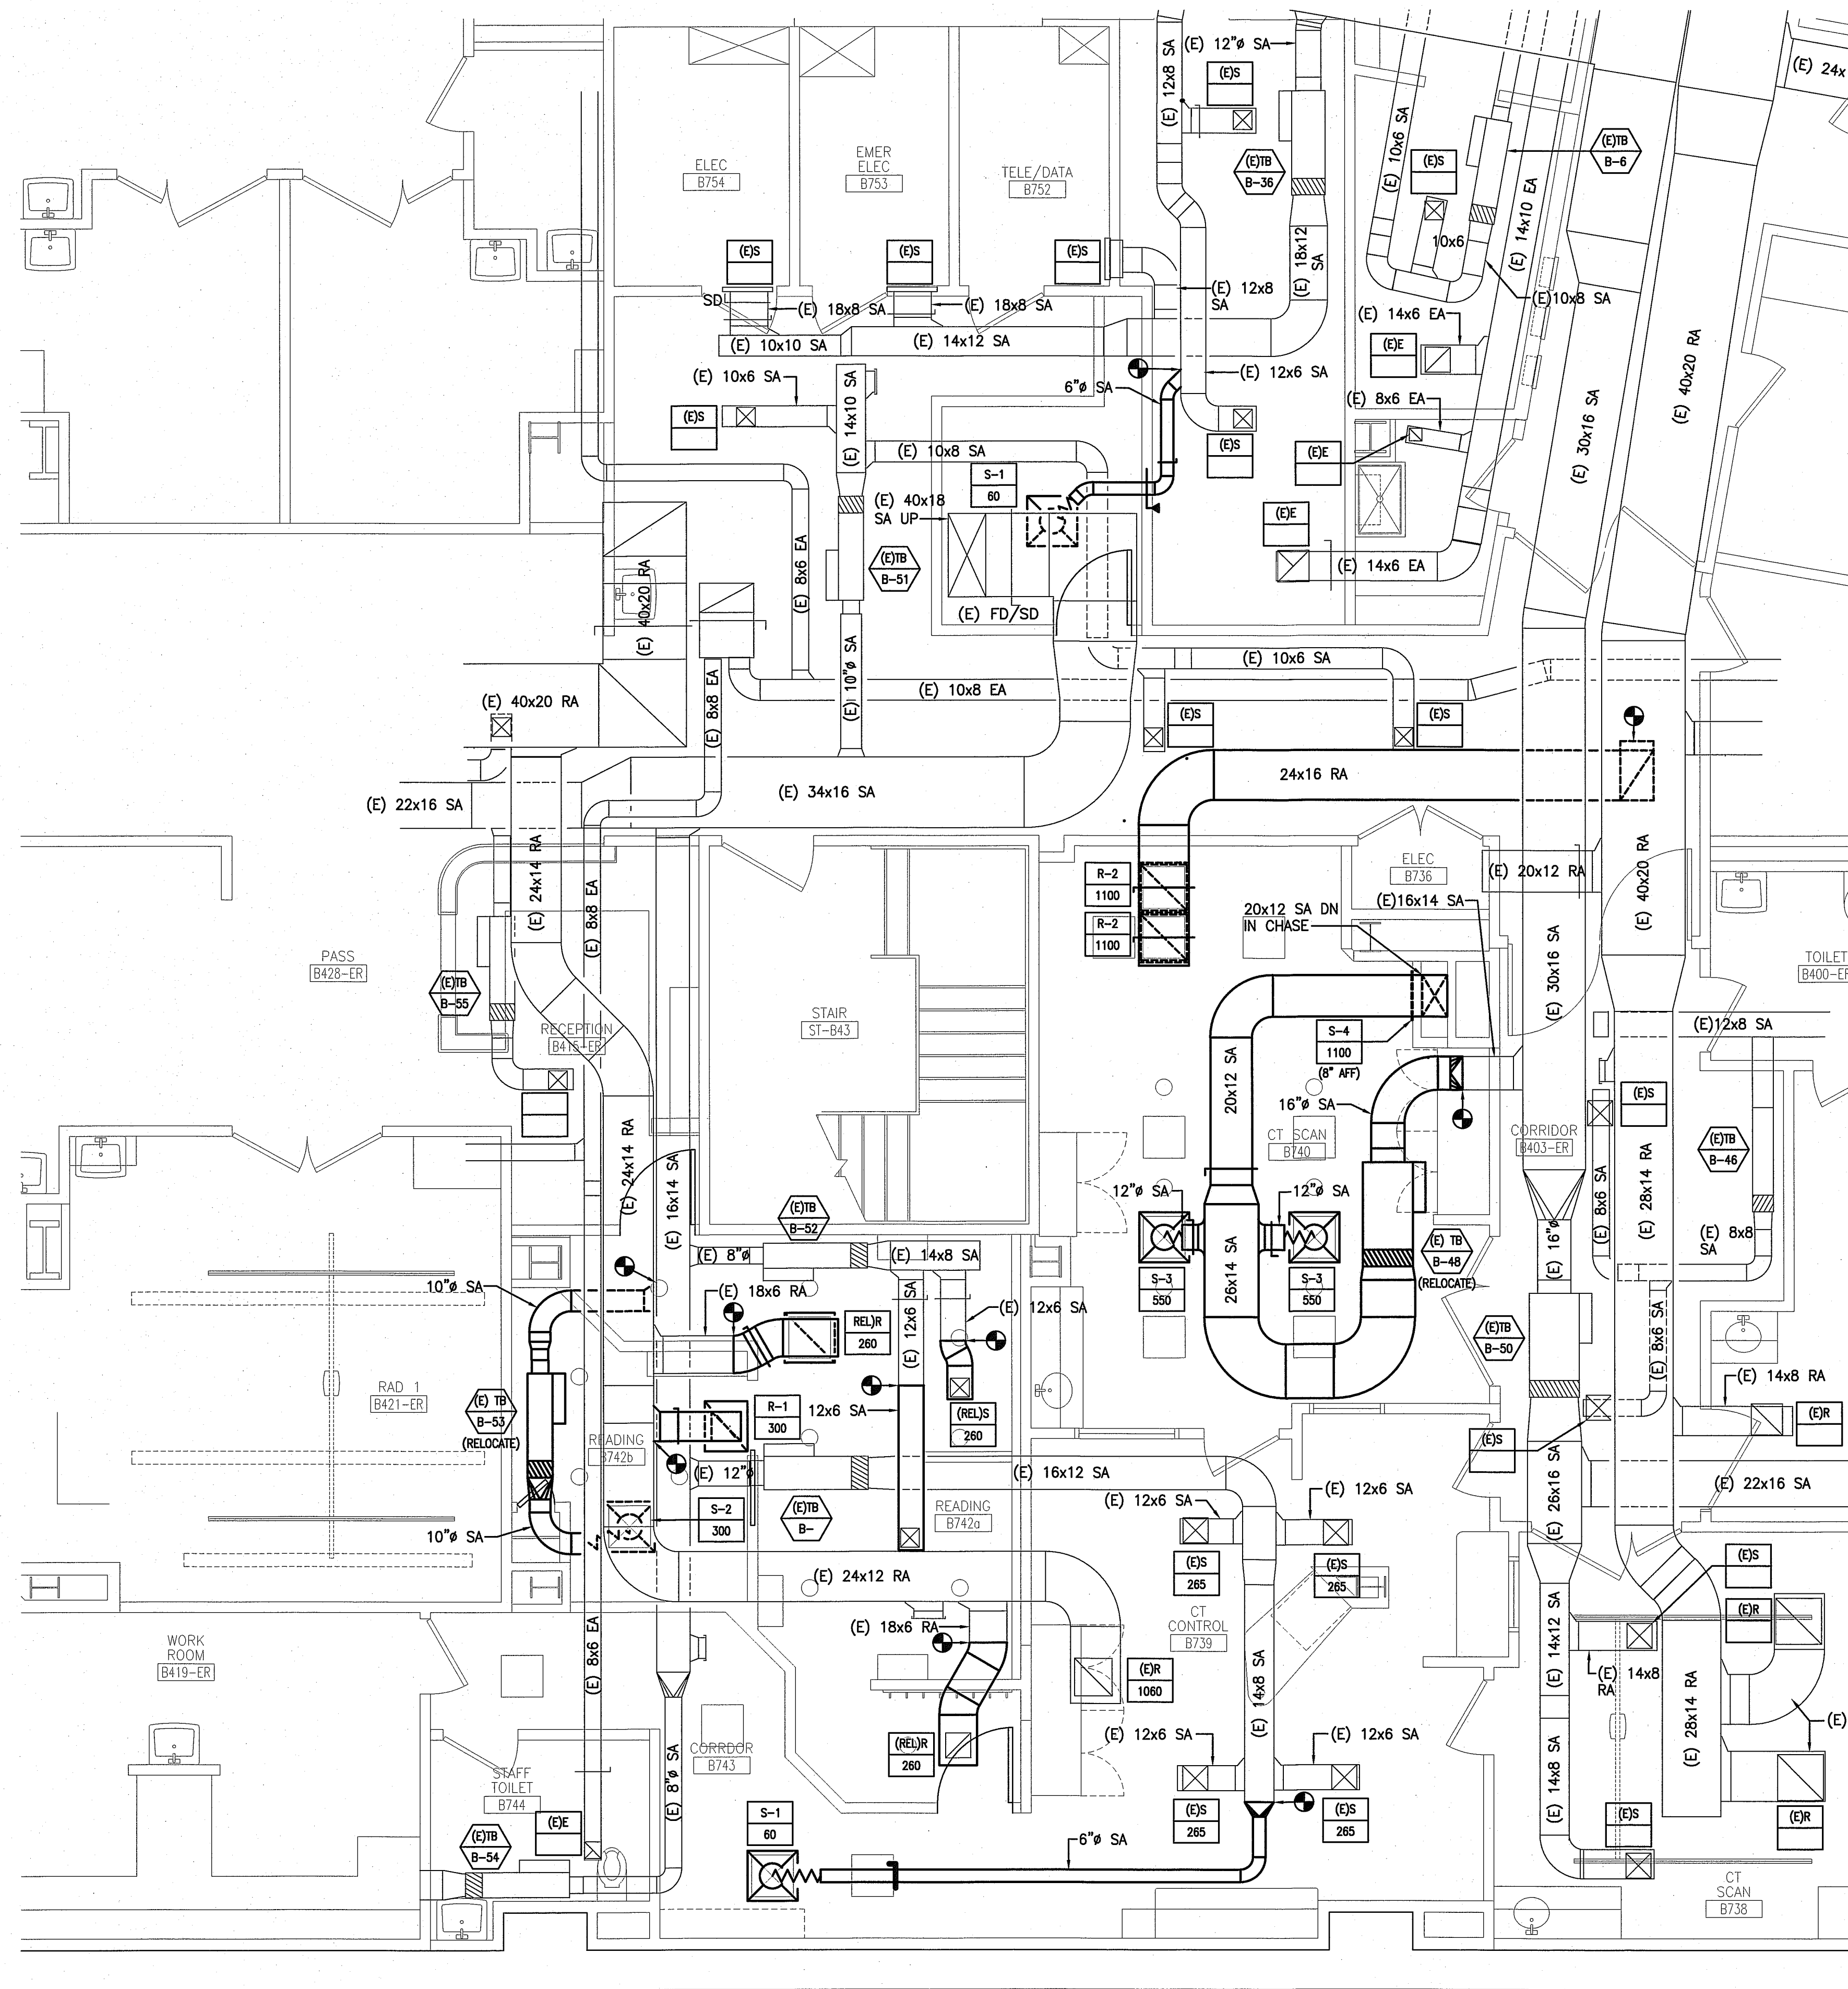

144 Fore Street/P.O. Box 618
Portland, Maine 04104
tel. (207) 772-3846
fax. (207) 772-1070
www.smrinc.com

ARCHITECTURE
ENGINEERING
PLANNING
INTERIOR DESIGN
COMMISSIONING

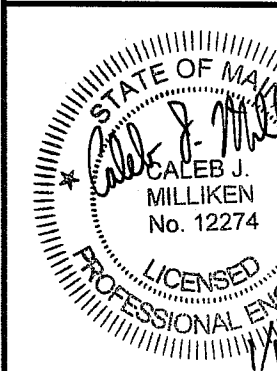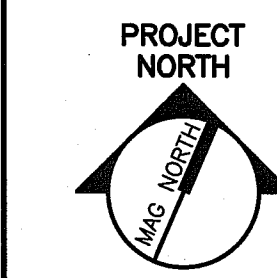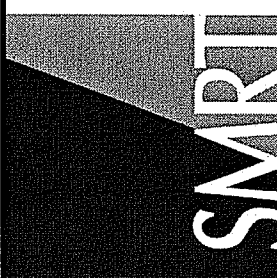

**MAINE MEDICAL CENTER
ED CT FIT-UP AND READING RENOVATIONS**
PORTLAND, MAINE

REV	DESCRIPTION	DATE

GRAPHIC SCALE:
0" 1"
SCALE: 1/4"=1'-0"
PROJECT MANAGER: DJV
JC/DRAWN BY: MDR/BGC
A/E OF RECORD: CJM
CAD FILE: MH101-14150
PROJECT NO: 14150
DATE:

SHEET TITLE:
**HVAC DUCTWORK
PLAN**

SHEET No.
MH101
© copyright 2013 SMR INC.

A6 FLOOR PLAN

1/4"=1'-0"