

NOTE:




1. SEE SHEET PLO01 FOR LEGEND AND ABBREVIATIONS.

KEYED NOTES:

- ① REMOVE EXISTING SINK. CAP EXISTING DRAIN CONNECTION IN WALL. EXISTING DRAIN AND VENT PIPING TO REMAIN FOR FUTURE RECONNECTION.
- ② INSTALL NEW 2" WASTE UNDER SLAB. SEE DETAIL XX/PL501

144 Fore Street/P.O. Box 618
Portland, Maine 04104
tel. (207) 772-3846
fax. (207) 772-1070
www.smmrinc.com

ARCHITECTURE
ENGINEERING
PLANNING
INTERIOR DESIGN
COMMISSIONING

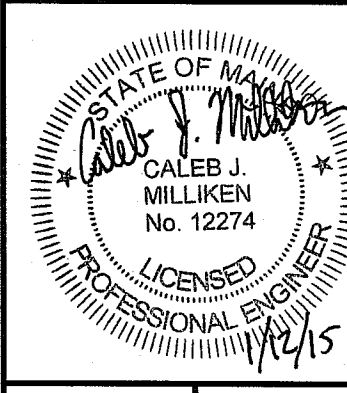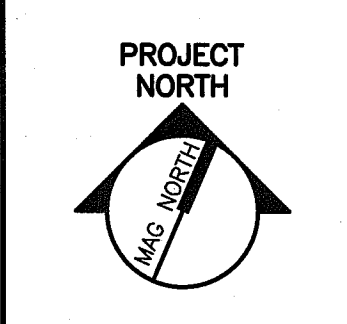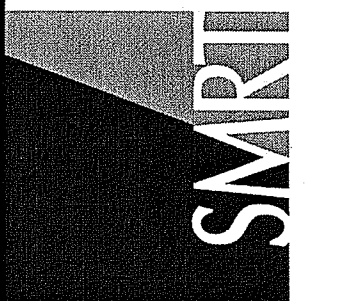

MAINE MEDICAL CENTER
ED CT FIT-UP AND READING RENOVATIONS
PORTLAND, MAINE
ISSUED FOR PERMITTING
1-12-15


REV	DESCRIPTION	DATE

GRAPHIC SCALE:
0" 1"

SCALE: 1/4"=1'-0"
PROJECT MANAGER: DJV
JC/DRAWN BY: MDR/BGG
A/E OF RECORD: CJM
CAD FILE: PL101-14150
PROJECT NO: 14150
DATE: 1/12/15


SHEET TITLE:
PLUMBING DWV
PIPING PLANS

SHEET No.
PL101
© COPYRIGHT 2013 SMR INC.

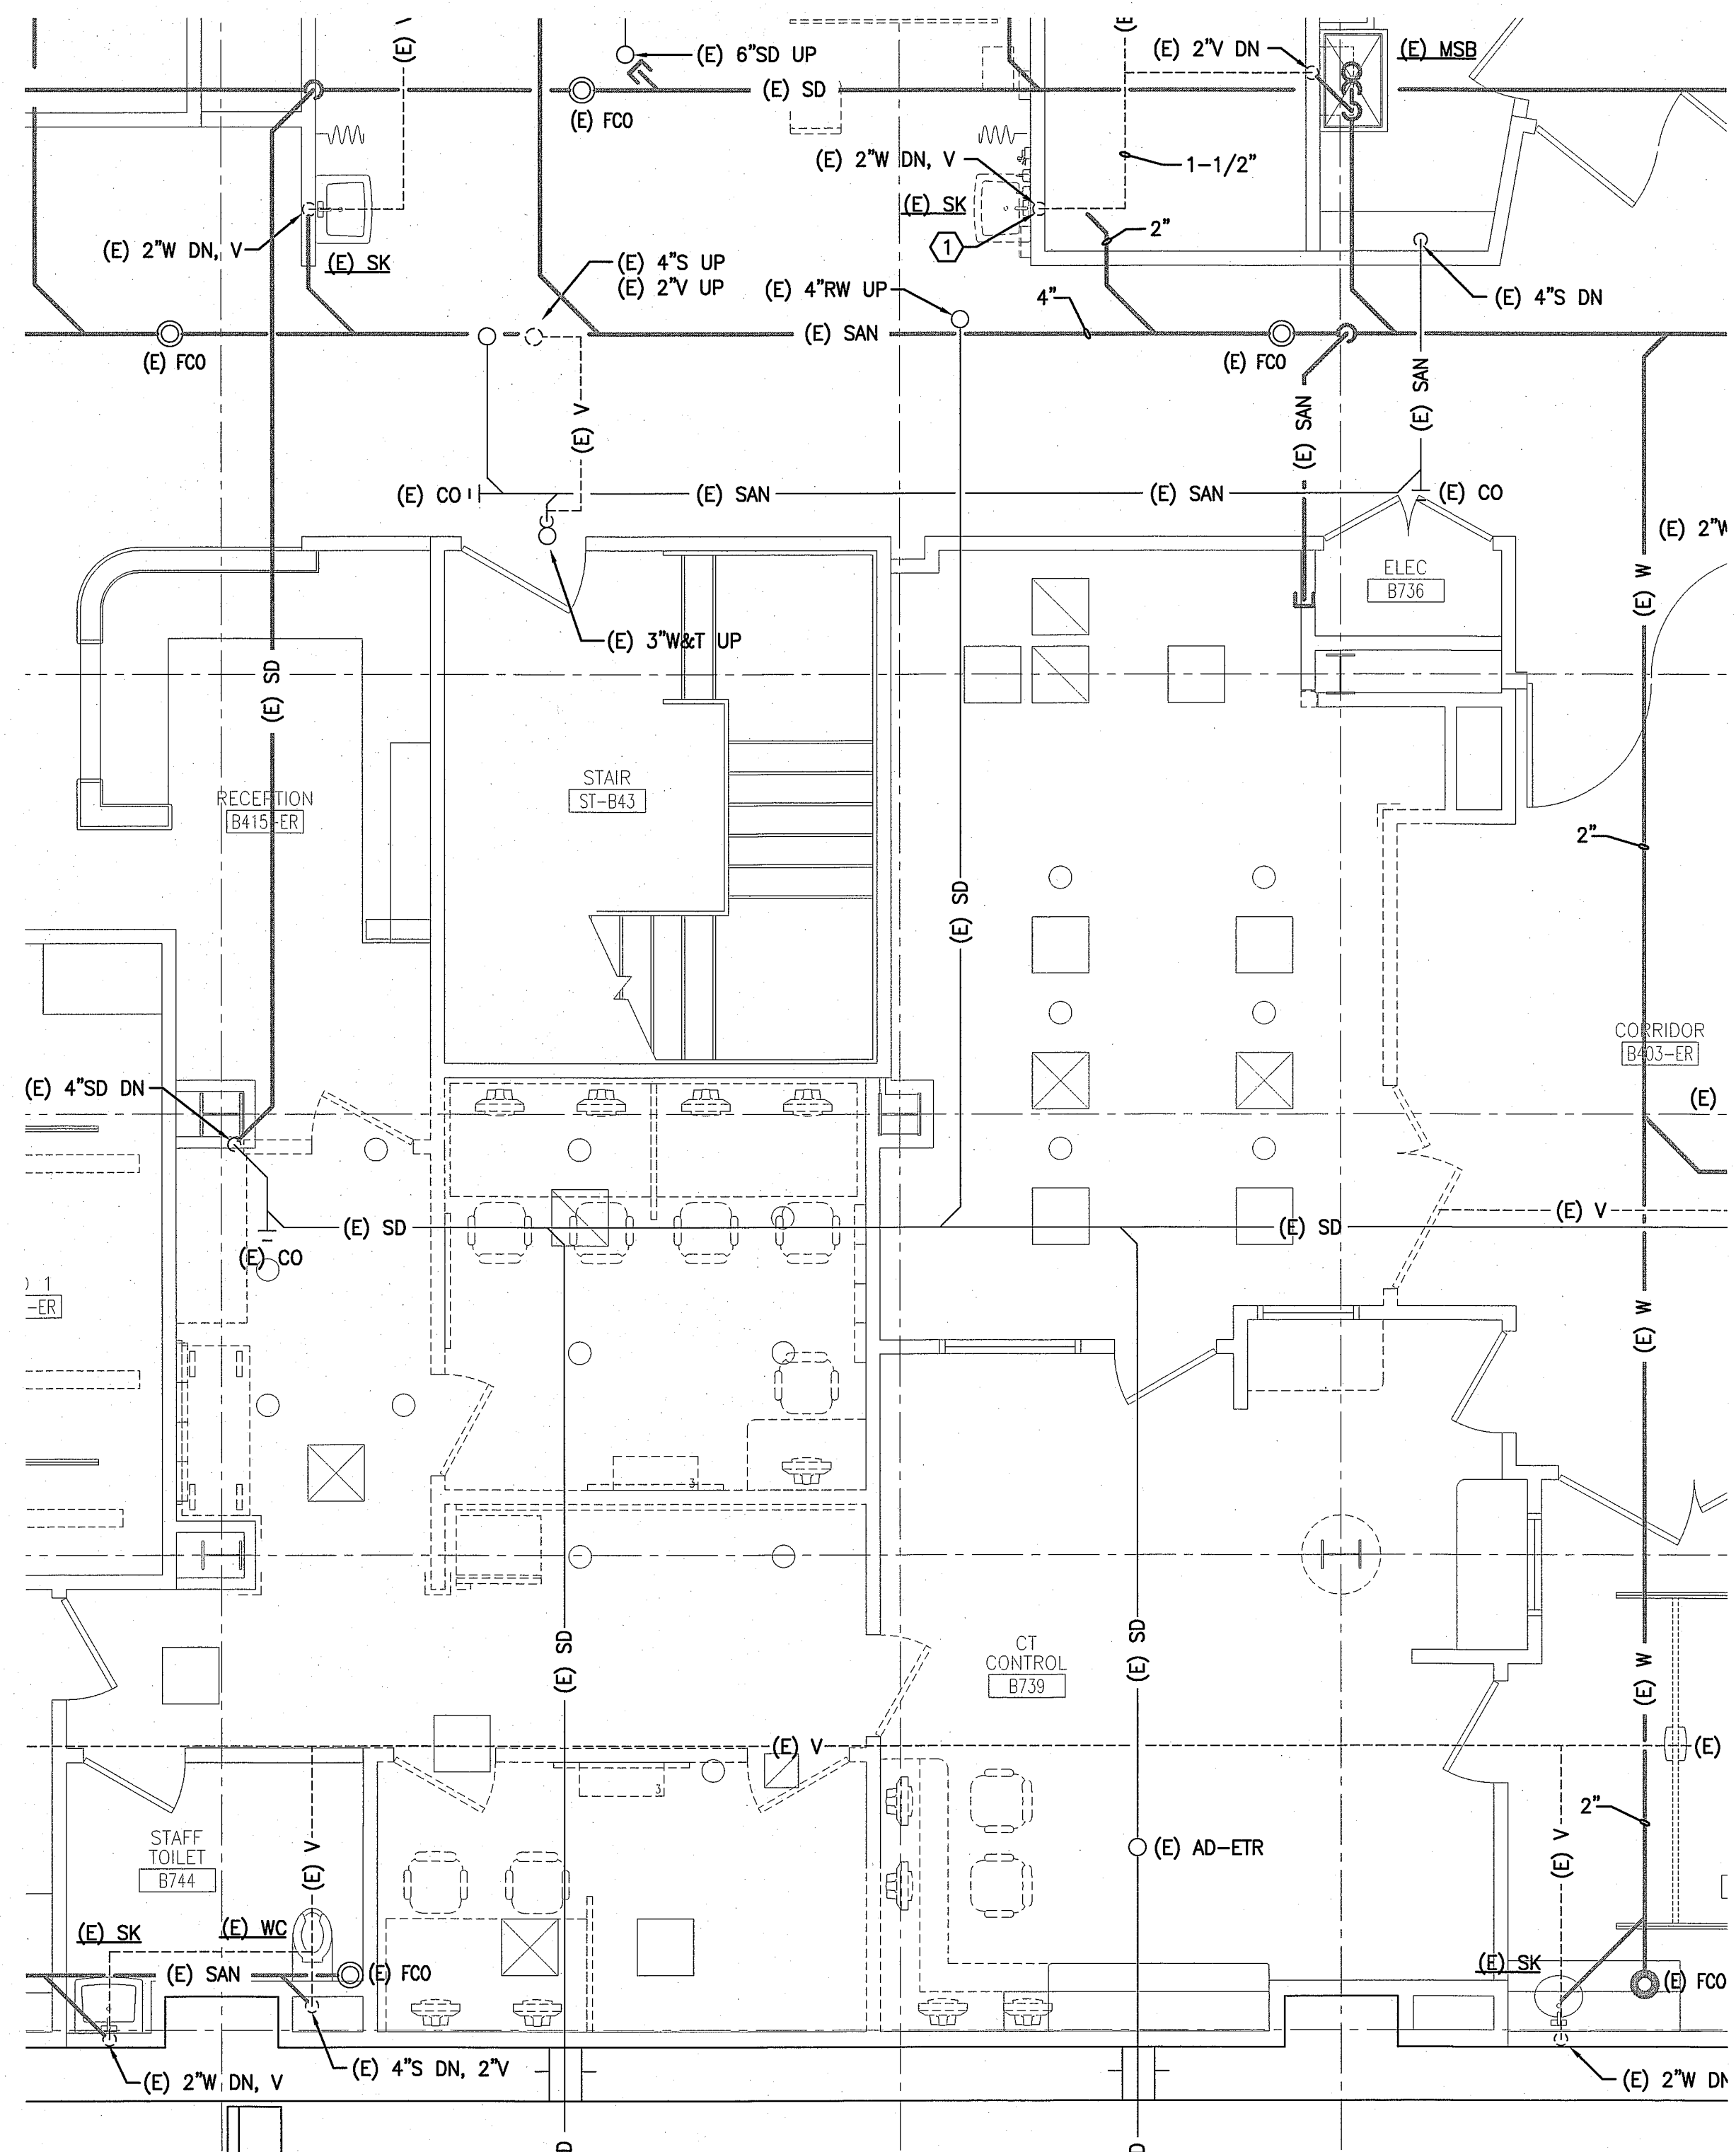

A1 DWV PIPING DEMOLITION PLAN

1/4"=1'-0"

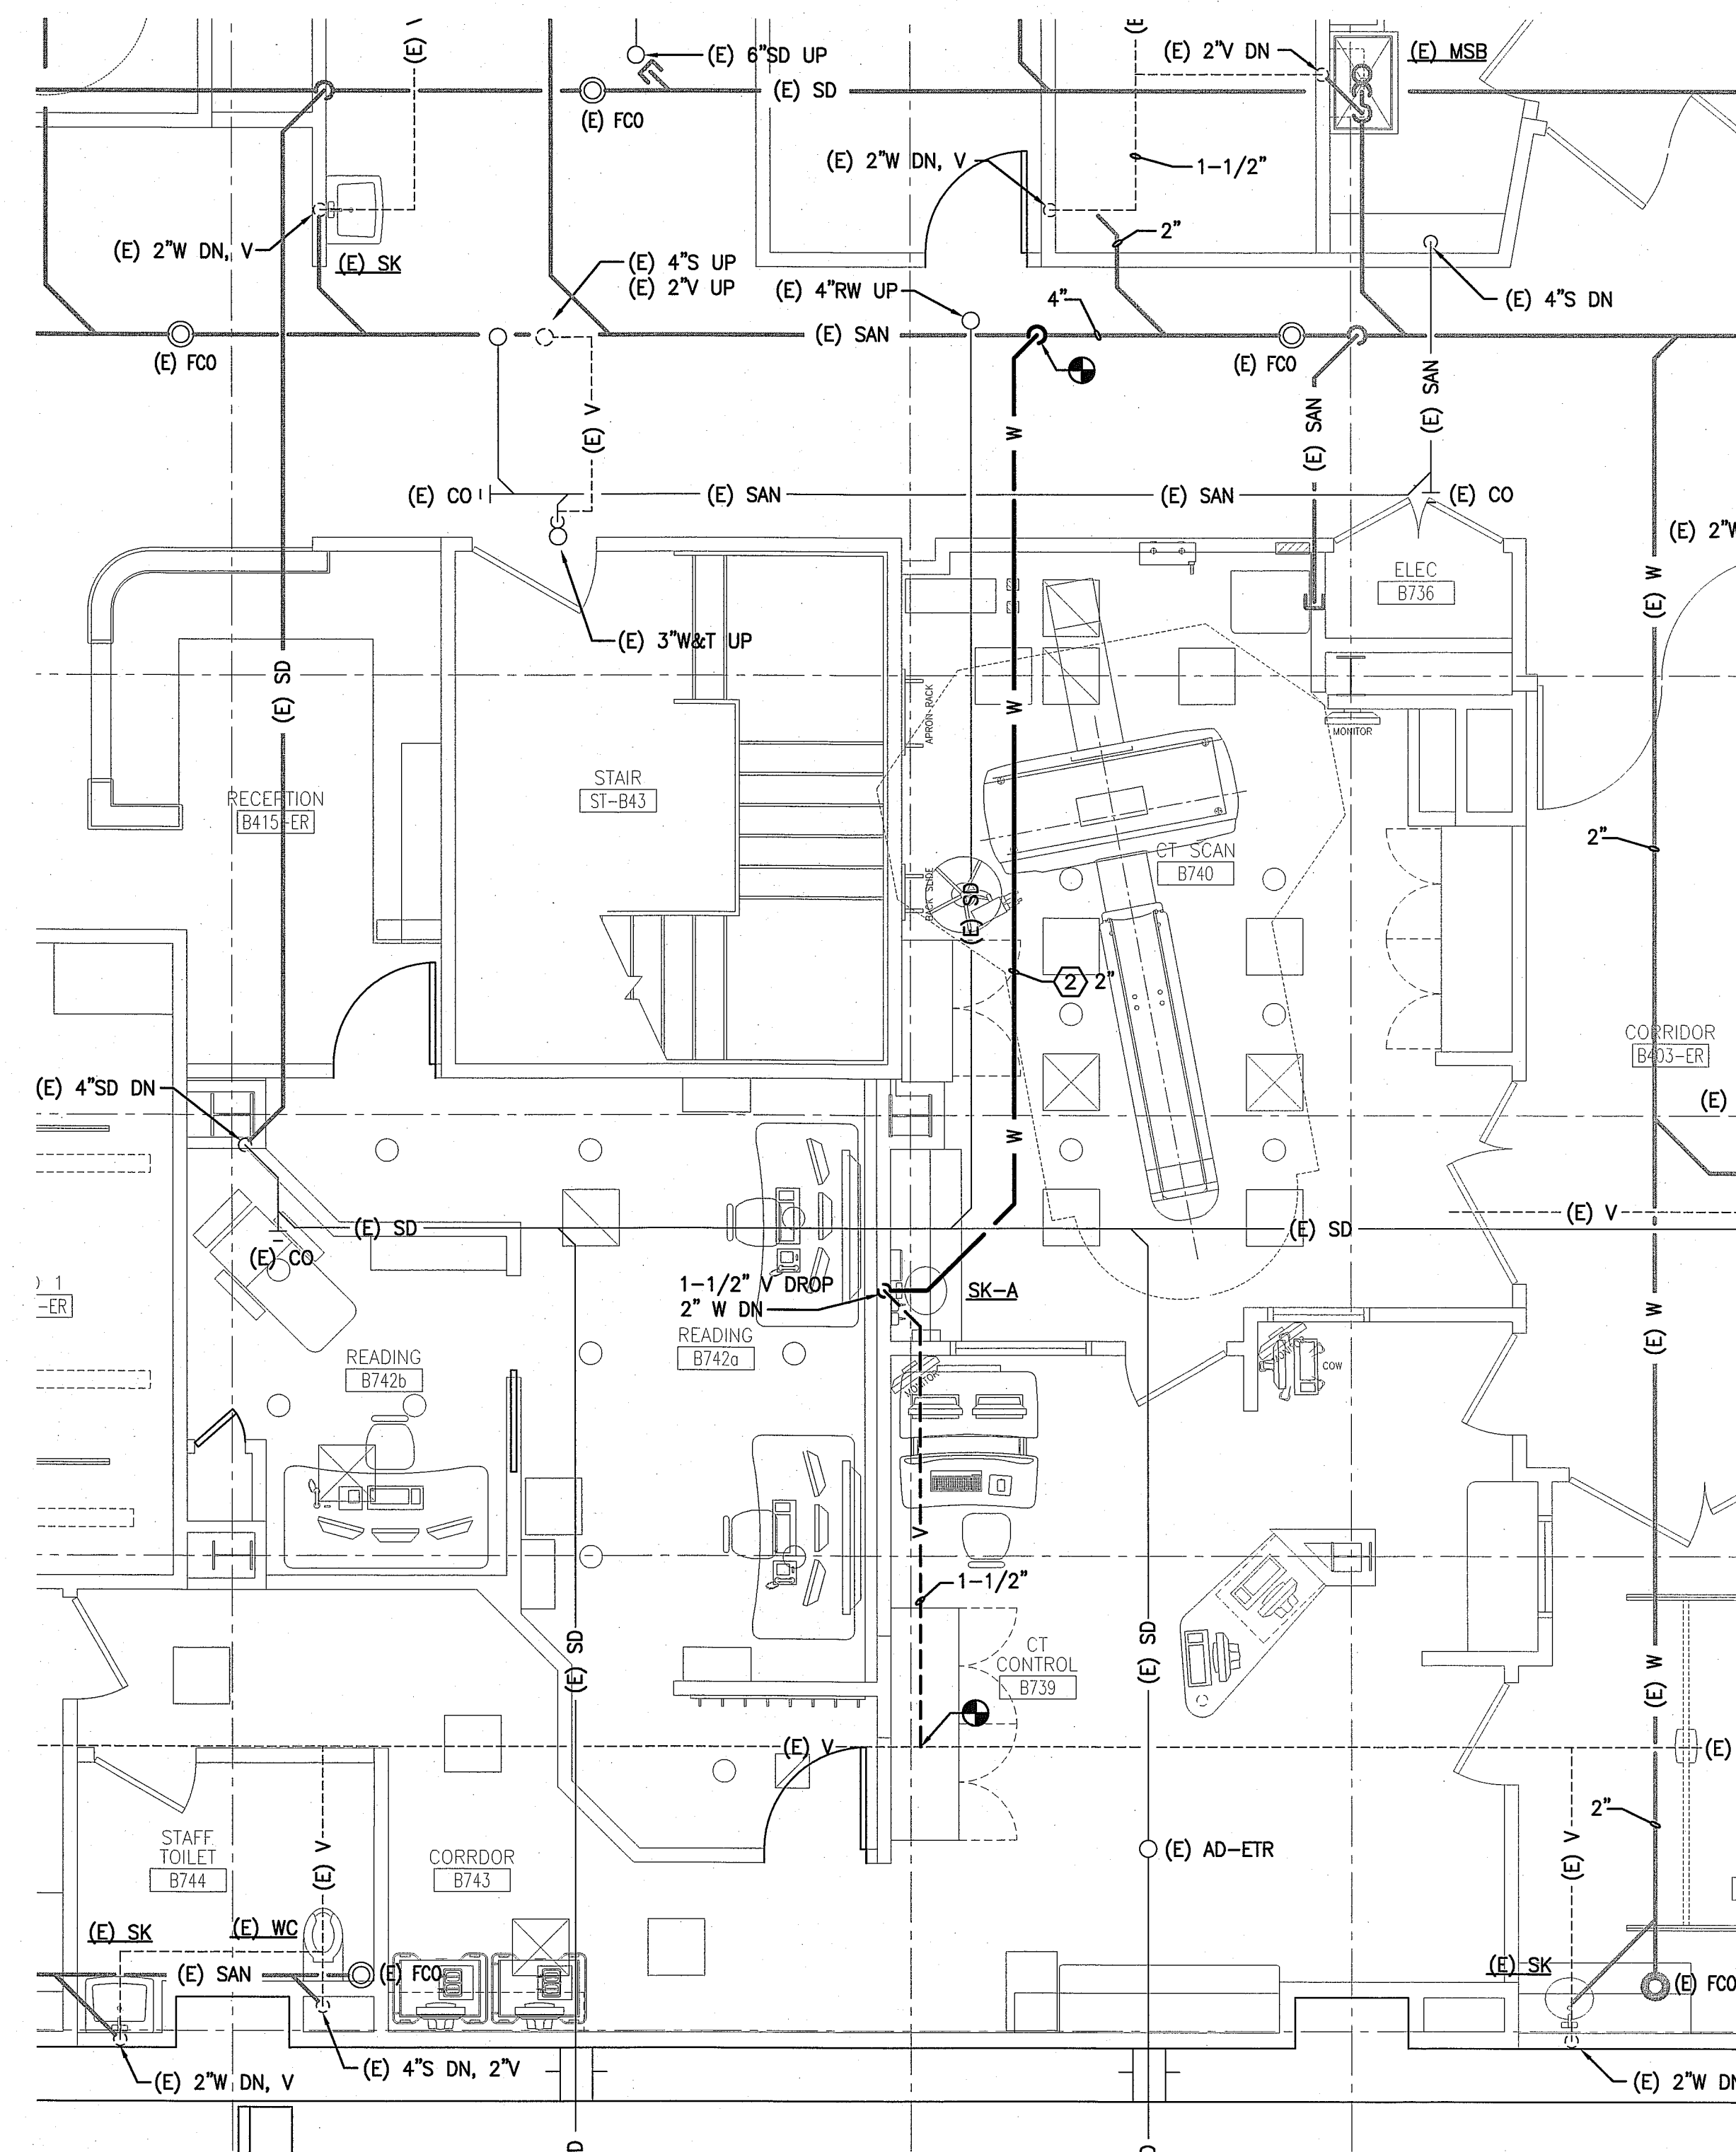

A8 DWV PIPING PLAN

1/4"=1'-0"