


NOTE:

1. SEE SHEET P-001 FOR LEGEND AND ABBREVIATIONS.




KEYED NOTES:

① REMOVE EXISTING MV, MA AND OX WALL OUTLETS AND CAP RELATED PIPING IN WALL. DROPS TO REMAIN FOR FUTURE RECONNECTION.

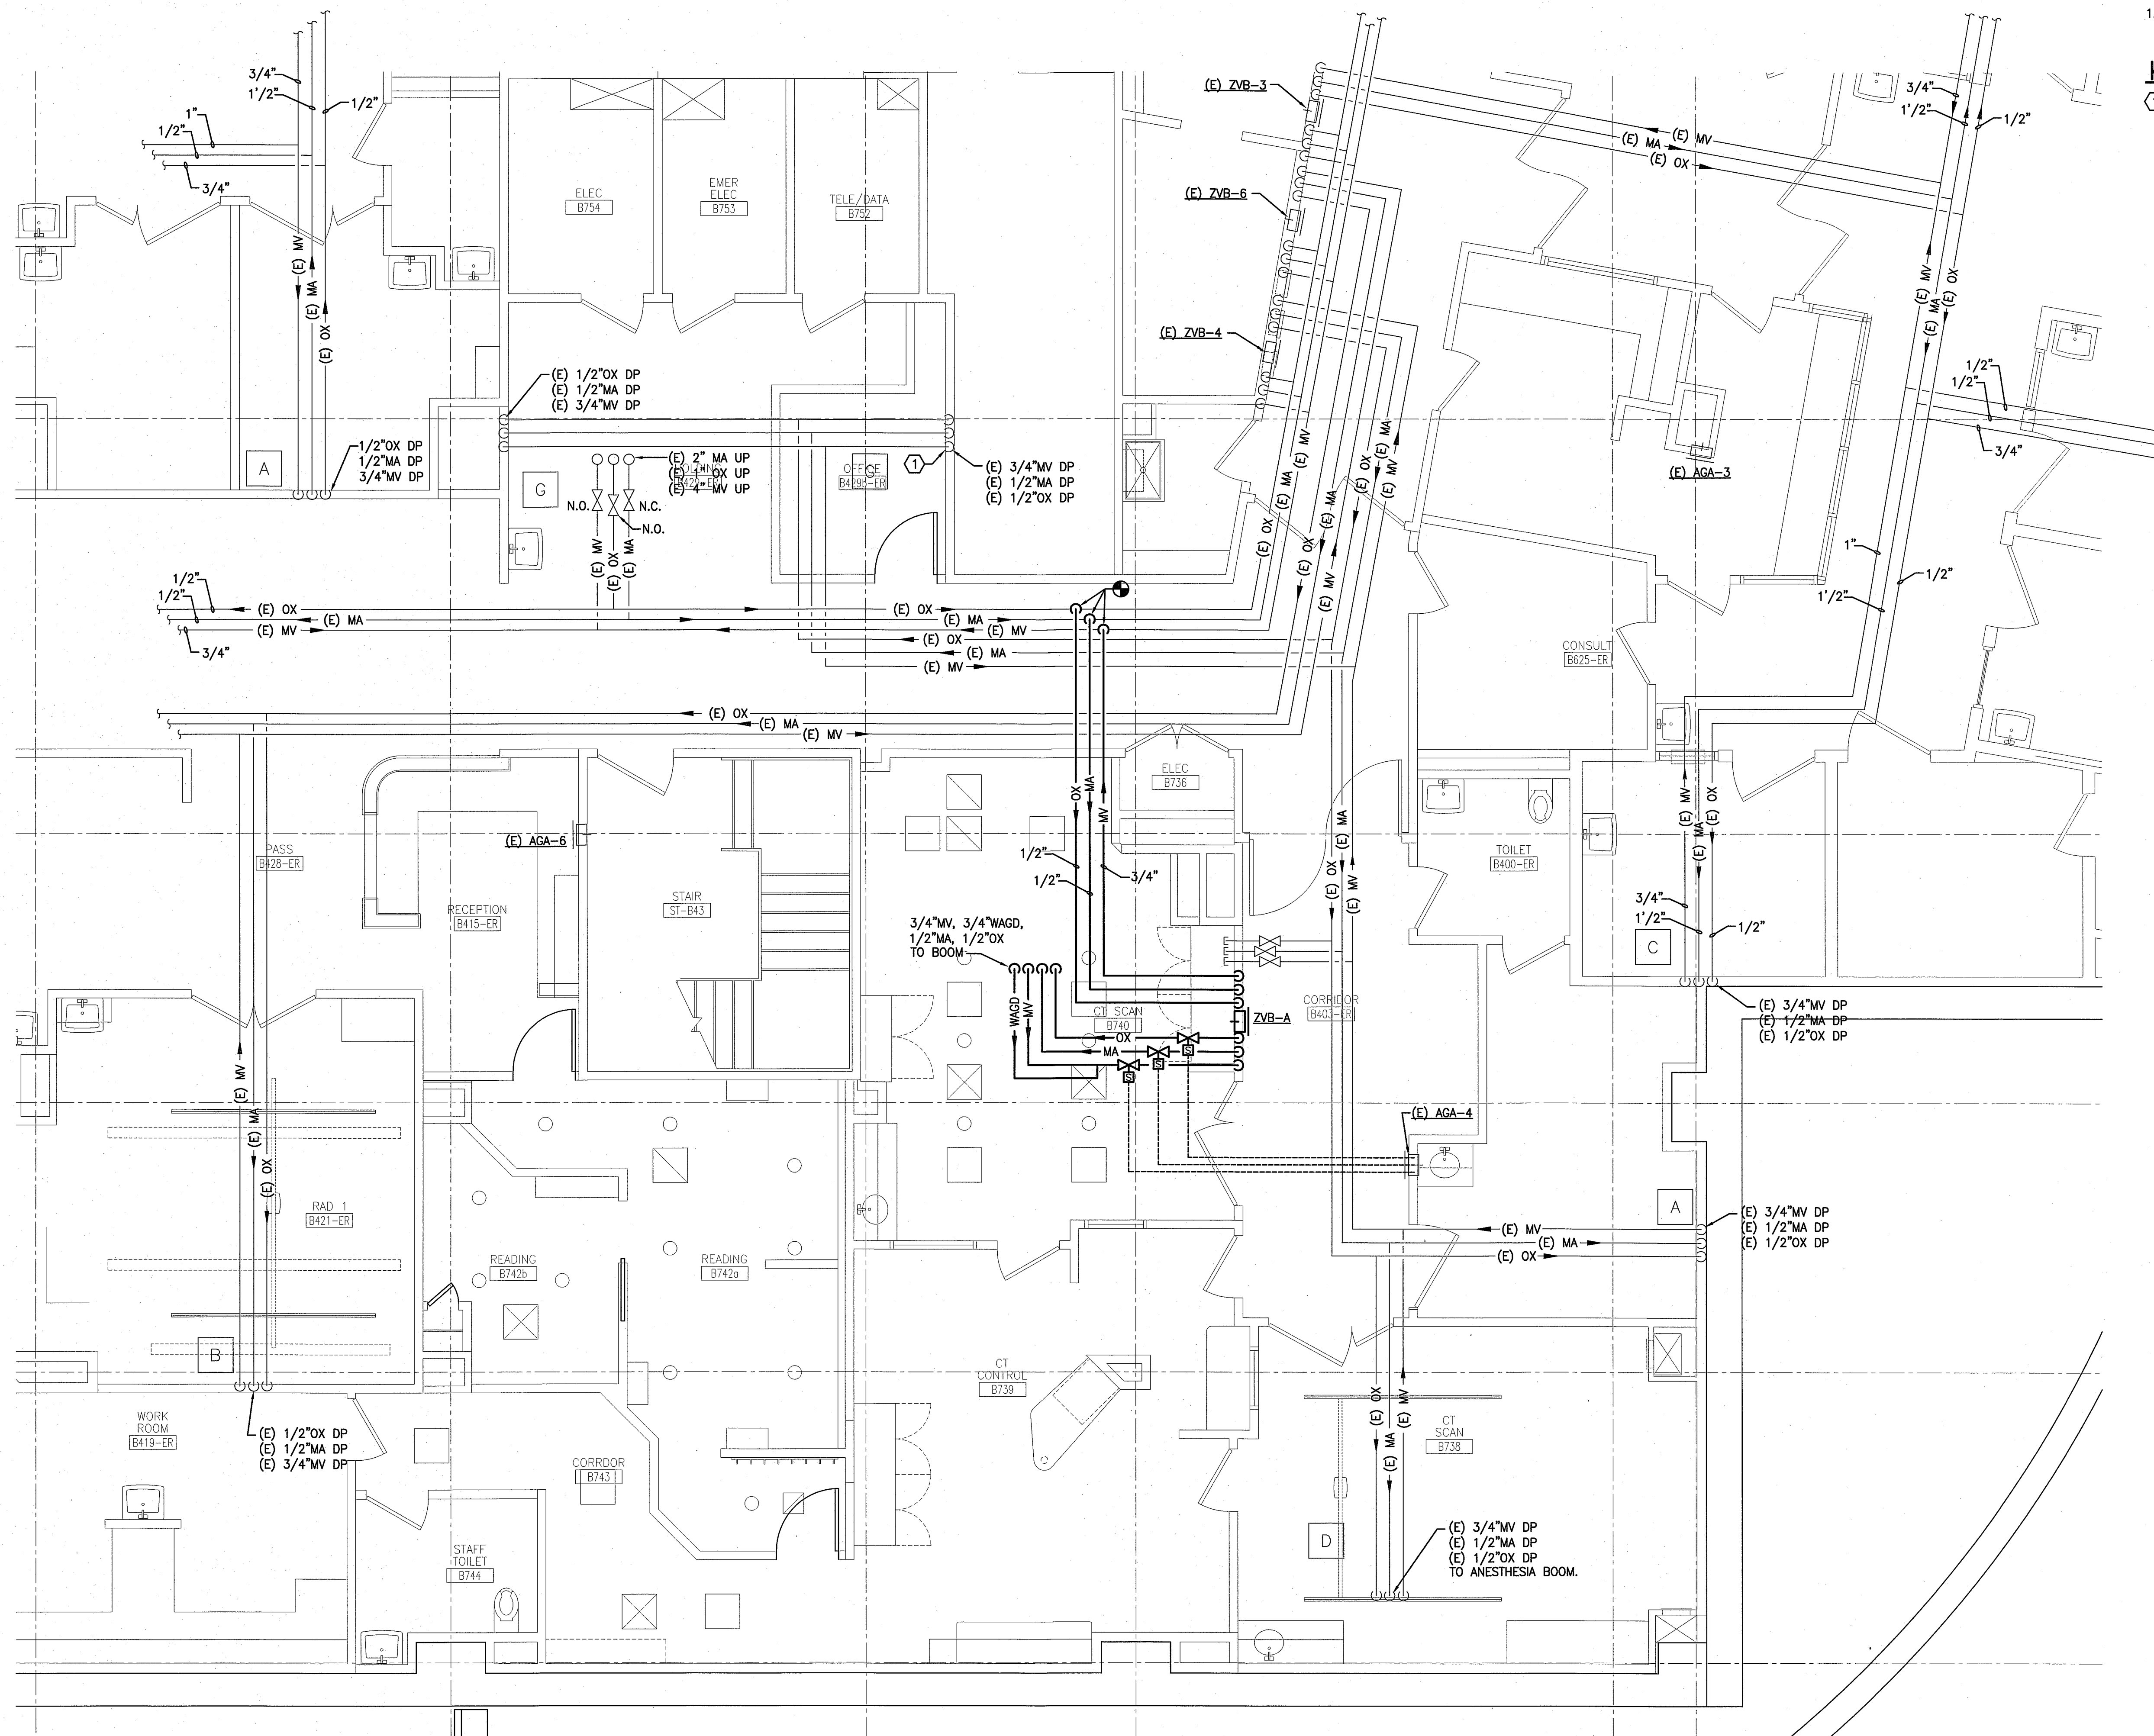

144 Fore Street/P.O. Box 618
Portland, Maine 04104
Tel: (207) 772-3646
Fax: (207) 772-1070
www.smri.com

ARCHITECTURE
ENGINEERING
PLANNING
INTERIOR DESIGN
COMMISSIONING

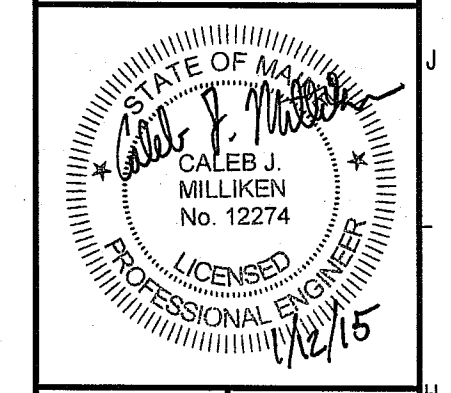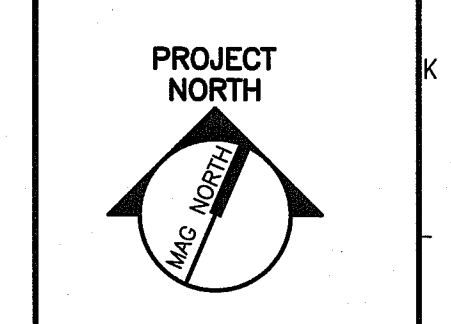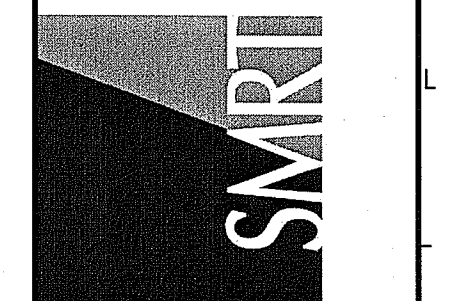

**MAINE MEDICAL CENTER
ED CT FIT-UP AND READING RENOVATIONS**
PORTLAND, MAINE
**ISSUED FOR PERMITTING
1-12-15**
CURRENT ISSUE STATUS:

REV	DESCRIPTION	DATE

GRAPHIC SCALE:
0" 1"
SCALE: AS NOTED
PROJECT MANAGER: DJM
JC/DRAWN BY: MBD
A/E OF RECORD: CJM
CAD FILE: PL112-14150
PROJECT NO: 14150
DATE:

SHEET TITLE:
**MEDICAL GAS
PIPING PLAN**

SHEET No.
PL112
© COPYRIGHT 2013 SMRI, INC.

A1 FLOOR PLAN

1/4"=1'-0"