



- NURSE CALL PATIENT STATION
- CODE BLUE
- BED ALARM
- OXYGEN
- VACUUM
- AIR
- NORMAL POWER DUPLEX
- EMERGENCY POWER DUPLEX
- BED OUTLET SIMPLEX
- WALL PROTECTION OVERLAY


1 TYPICAL HEADWALL
 1/2" = 1'-0"

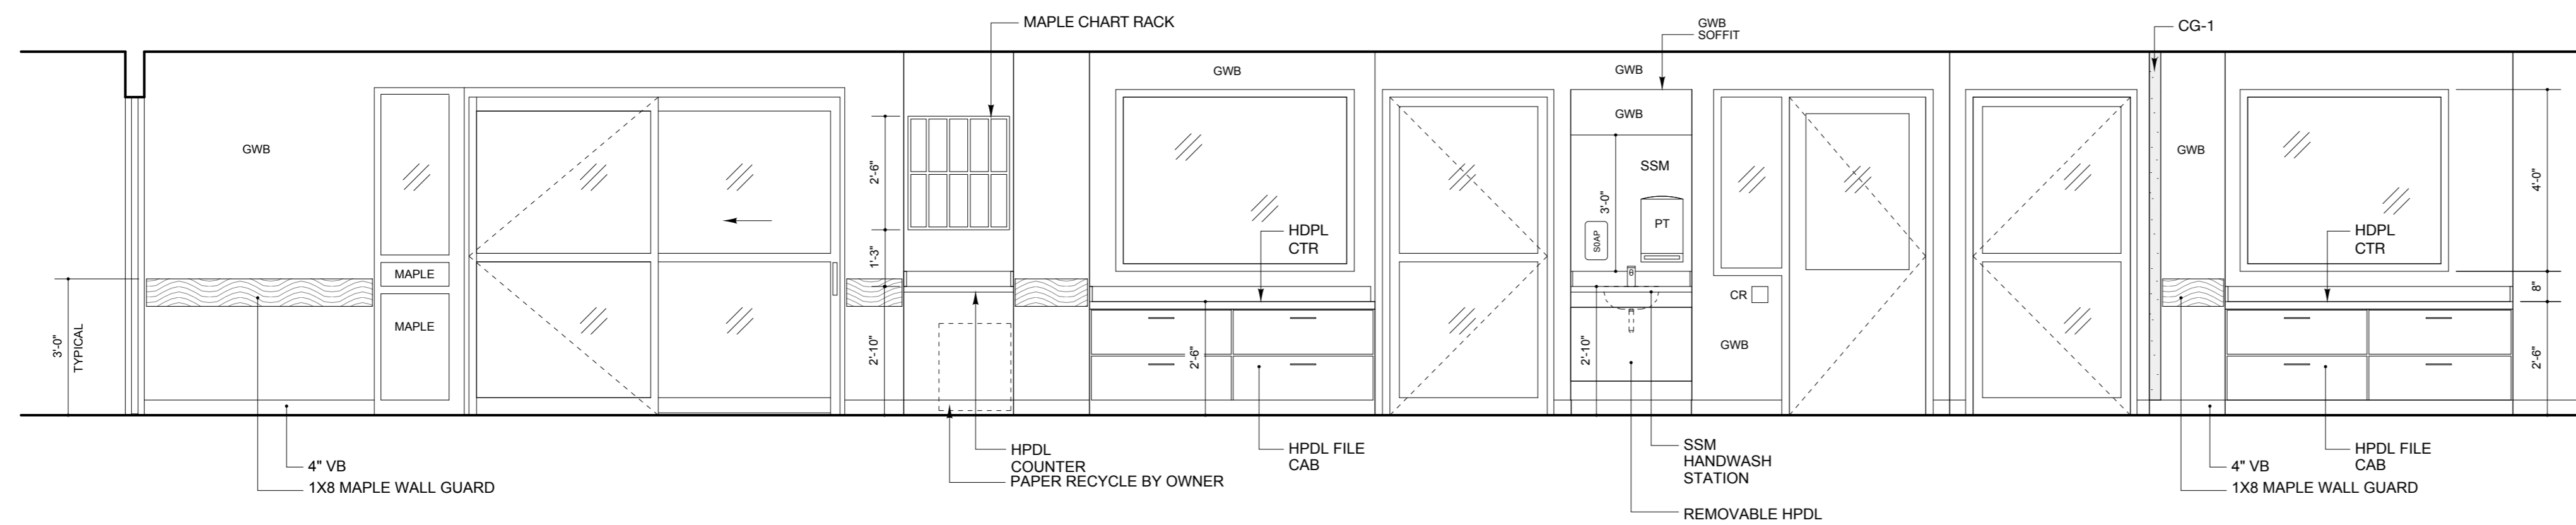


2 IMC - 6147 NORTH ELEVATION
 SCALE: 3/8" = 1'-0"

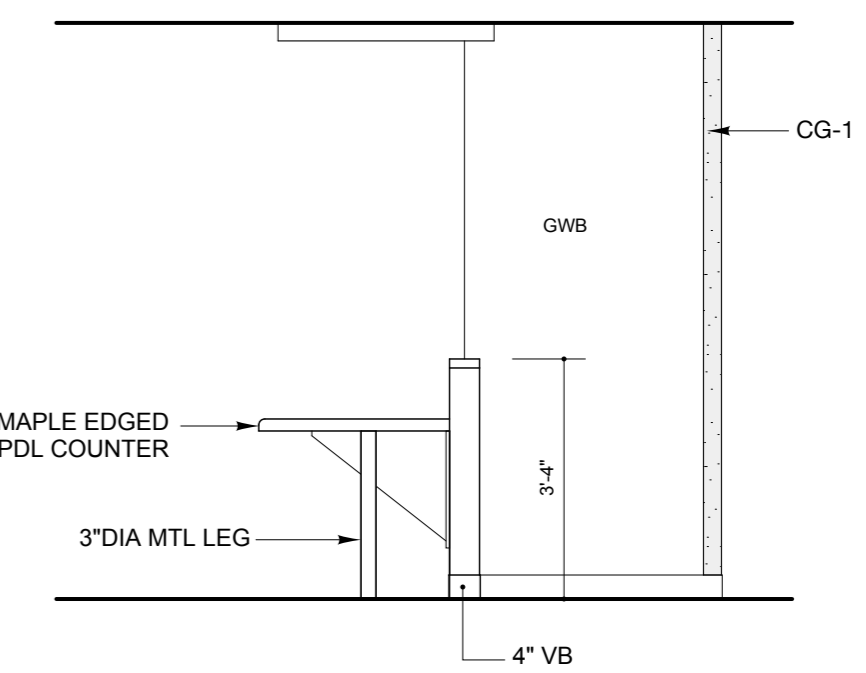


3 IMC - 6147 NURSING STATION
 SCALE: 3/8" = 1'-0" EAST ELEVATION

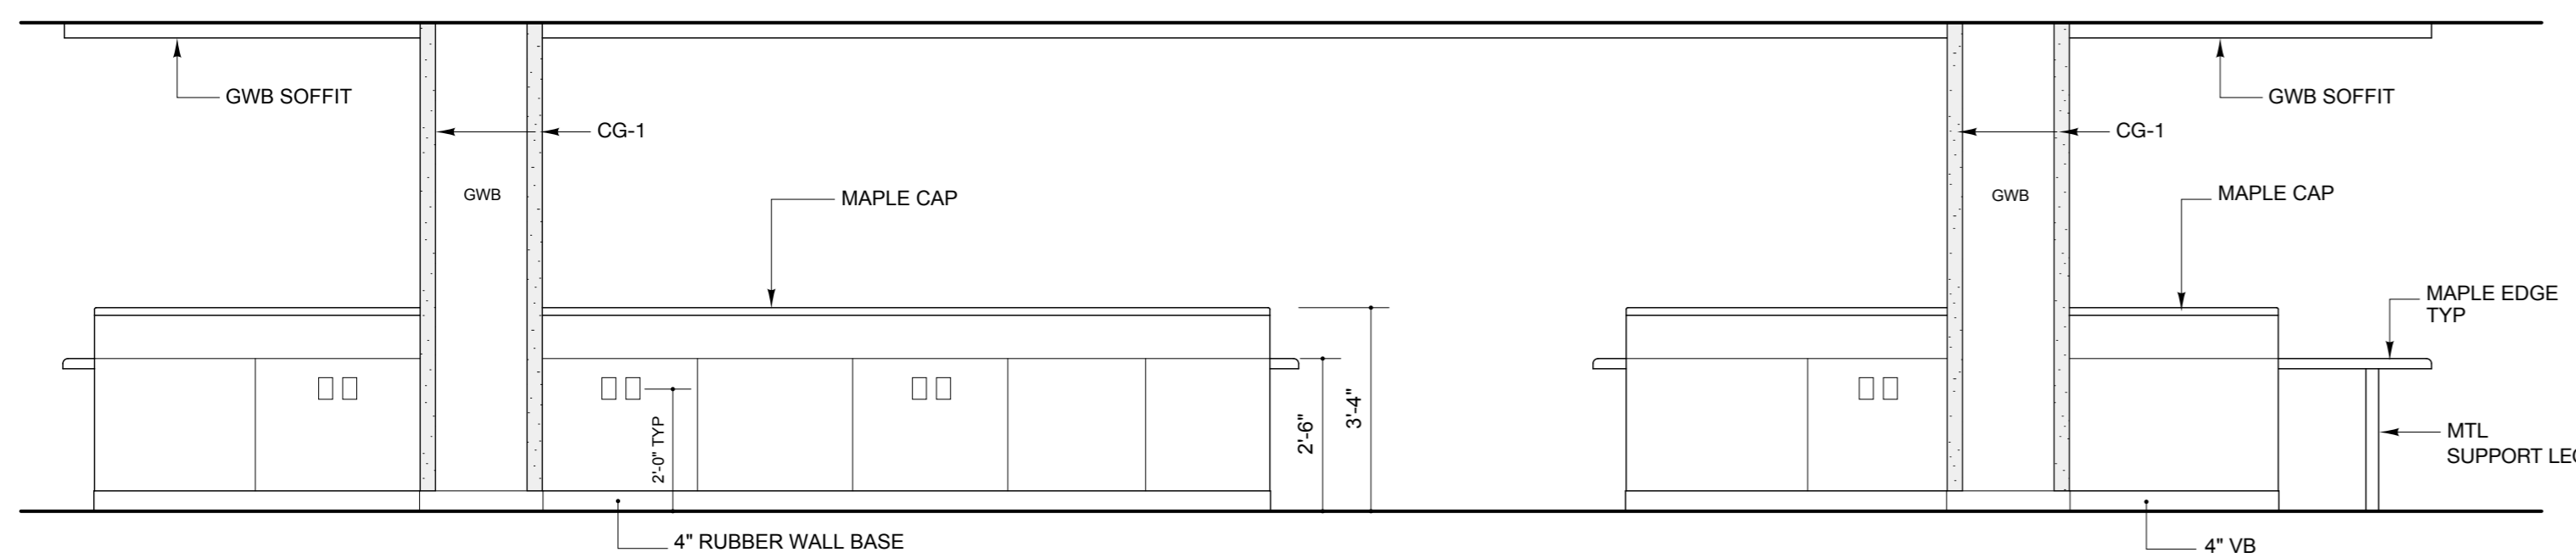


4 IMC - 6147 NURSING STATION
 SCALE: 3/8" = 1'-0" SOUTH ELEVATION

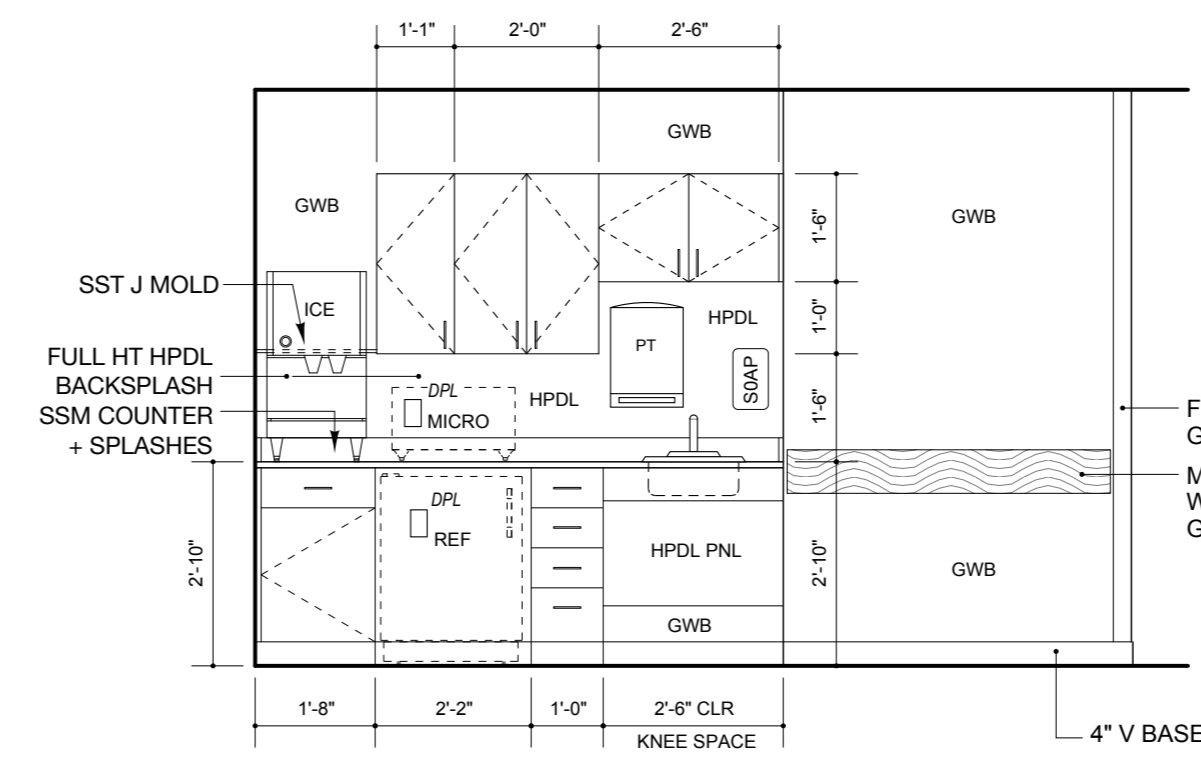


5 KITCHENETTE
 ROOM 6147

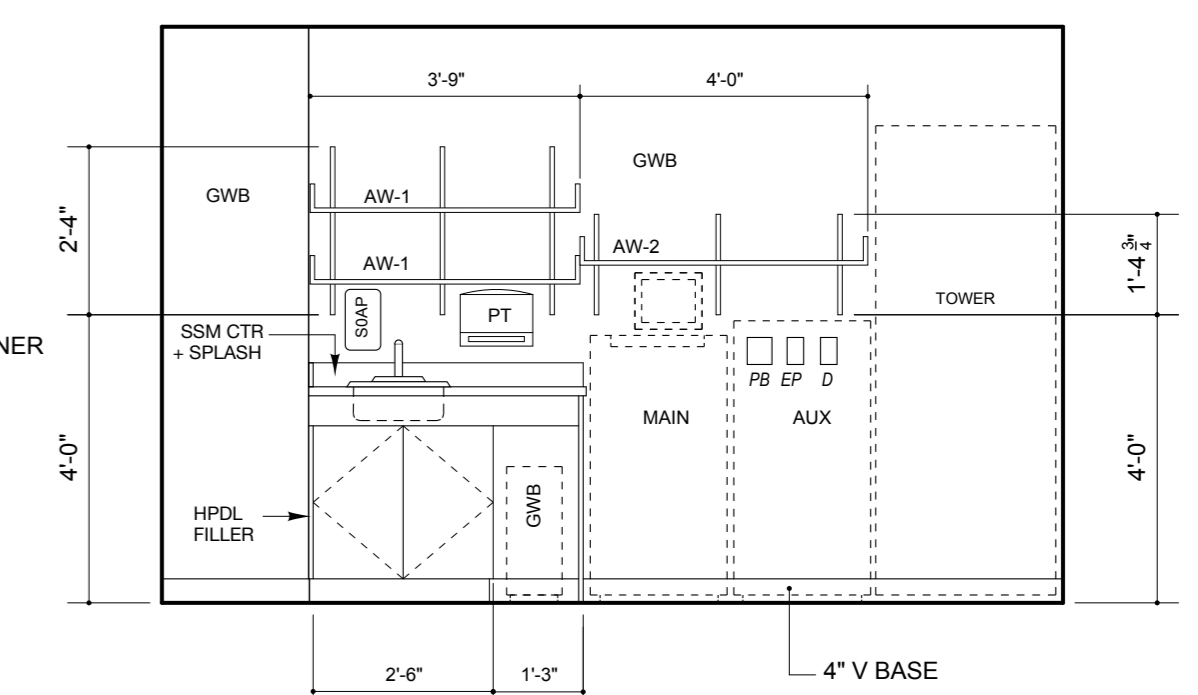


6 MED ROOM
 ROOM 6145 WEST

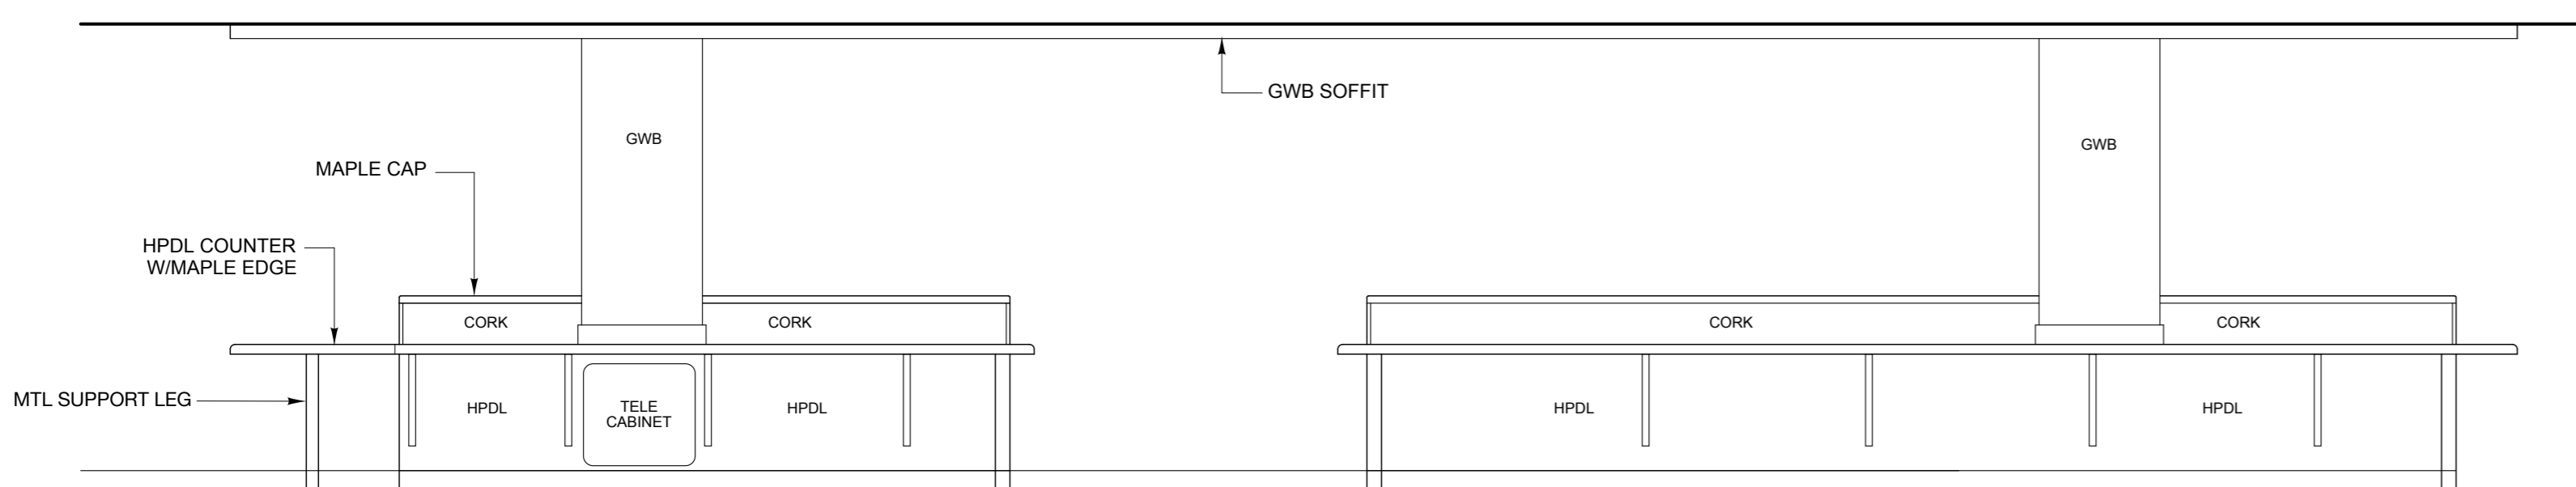

7 IMC - 6147 NURSING STATION
 SCALE: 3/8" = 1'-0" NORTH ELEVATION

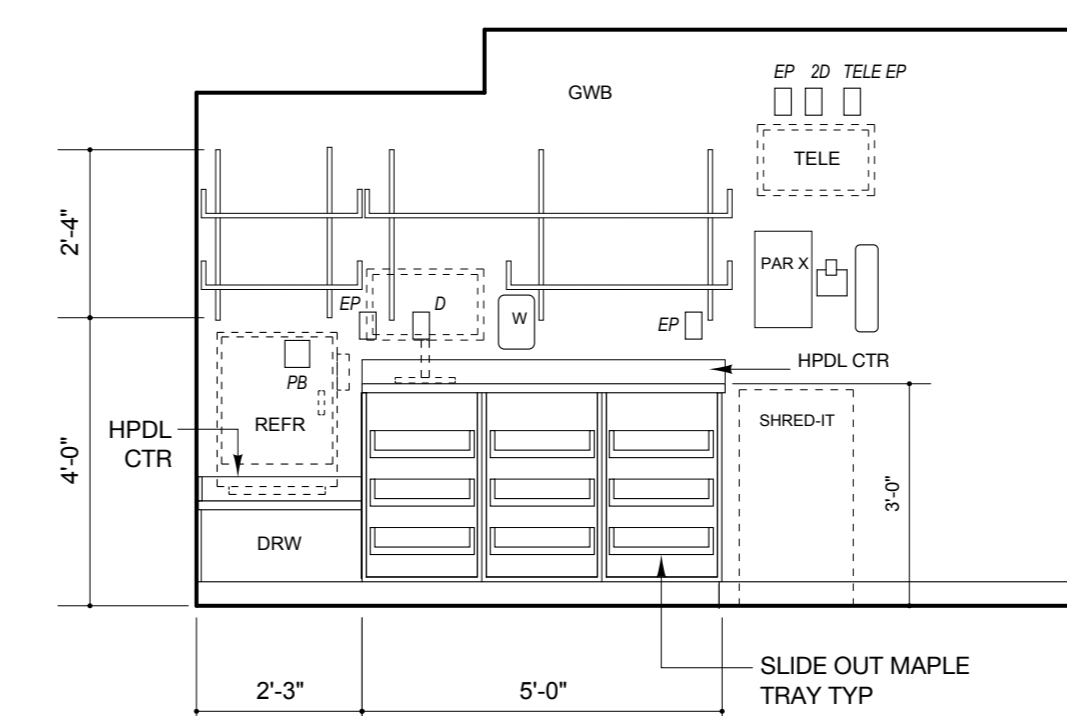

8 MED ROOM
 ROOM 6145 EAST

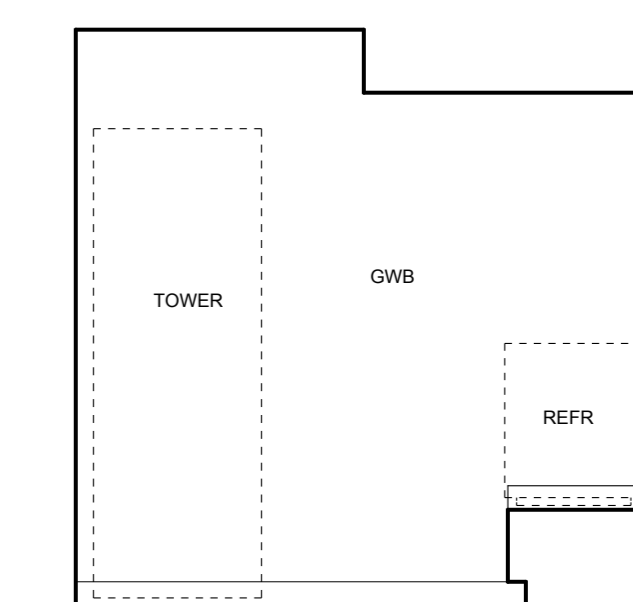

9 MED ROOM
 ROOM 6145 NORTH