



Winton Scott Architects  
 5 Milk Street  
 Portland, Maine 04101  
 207 774 4811  
 www.wintonsscott.com

Architecture / Planning  
 Preservation Architecture  
 Interior Architecture

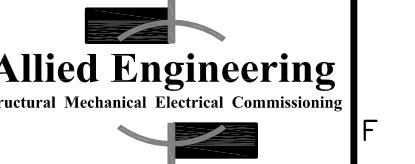

168 Veranda Street  
 Portland, Maine 04103  
 1-207-221-2266  
 F-207-221-2266  
 Web: www.allied-eng.com

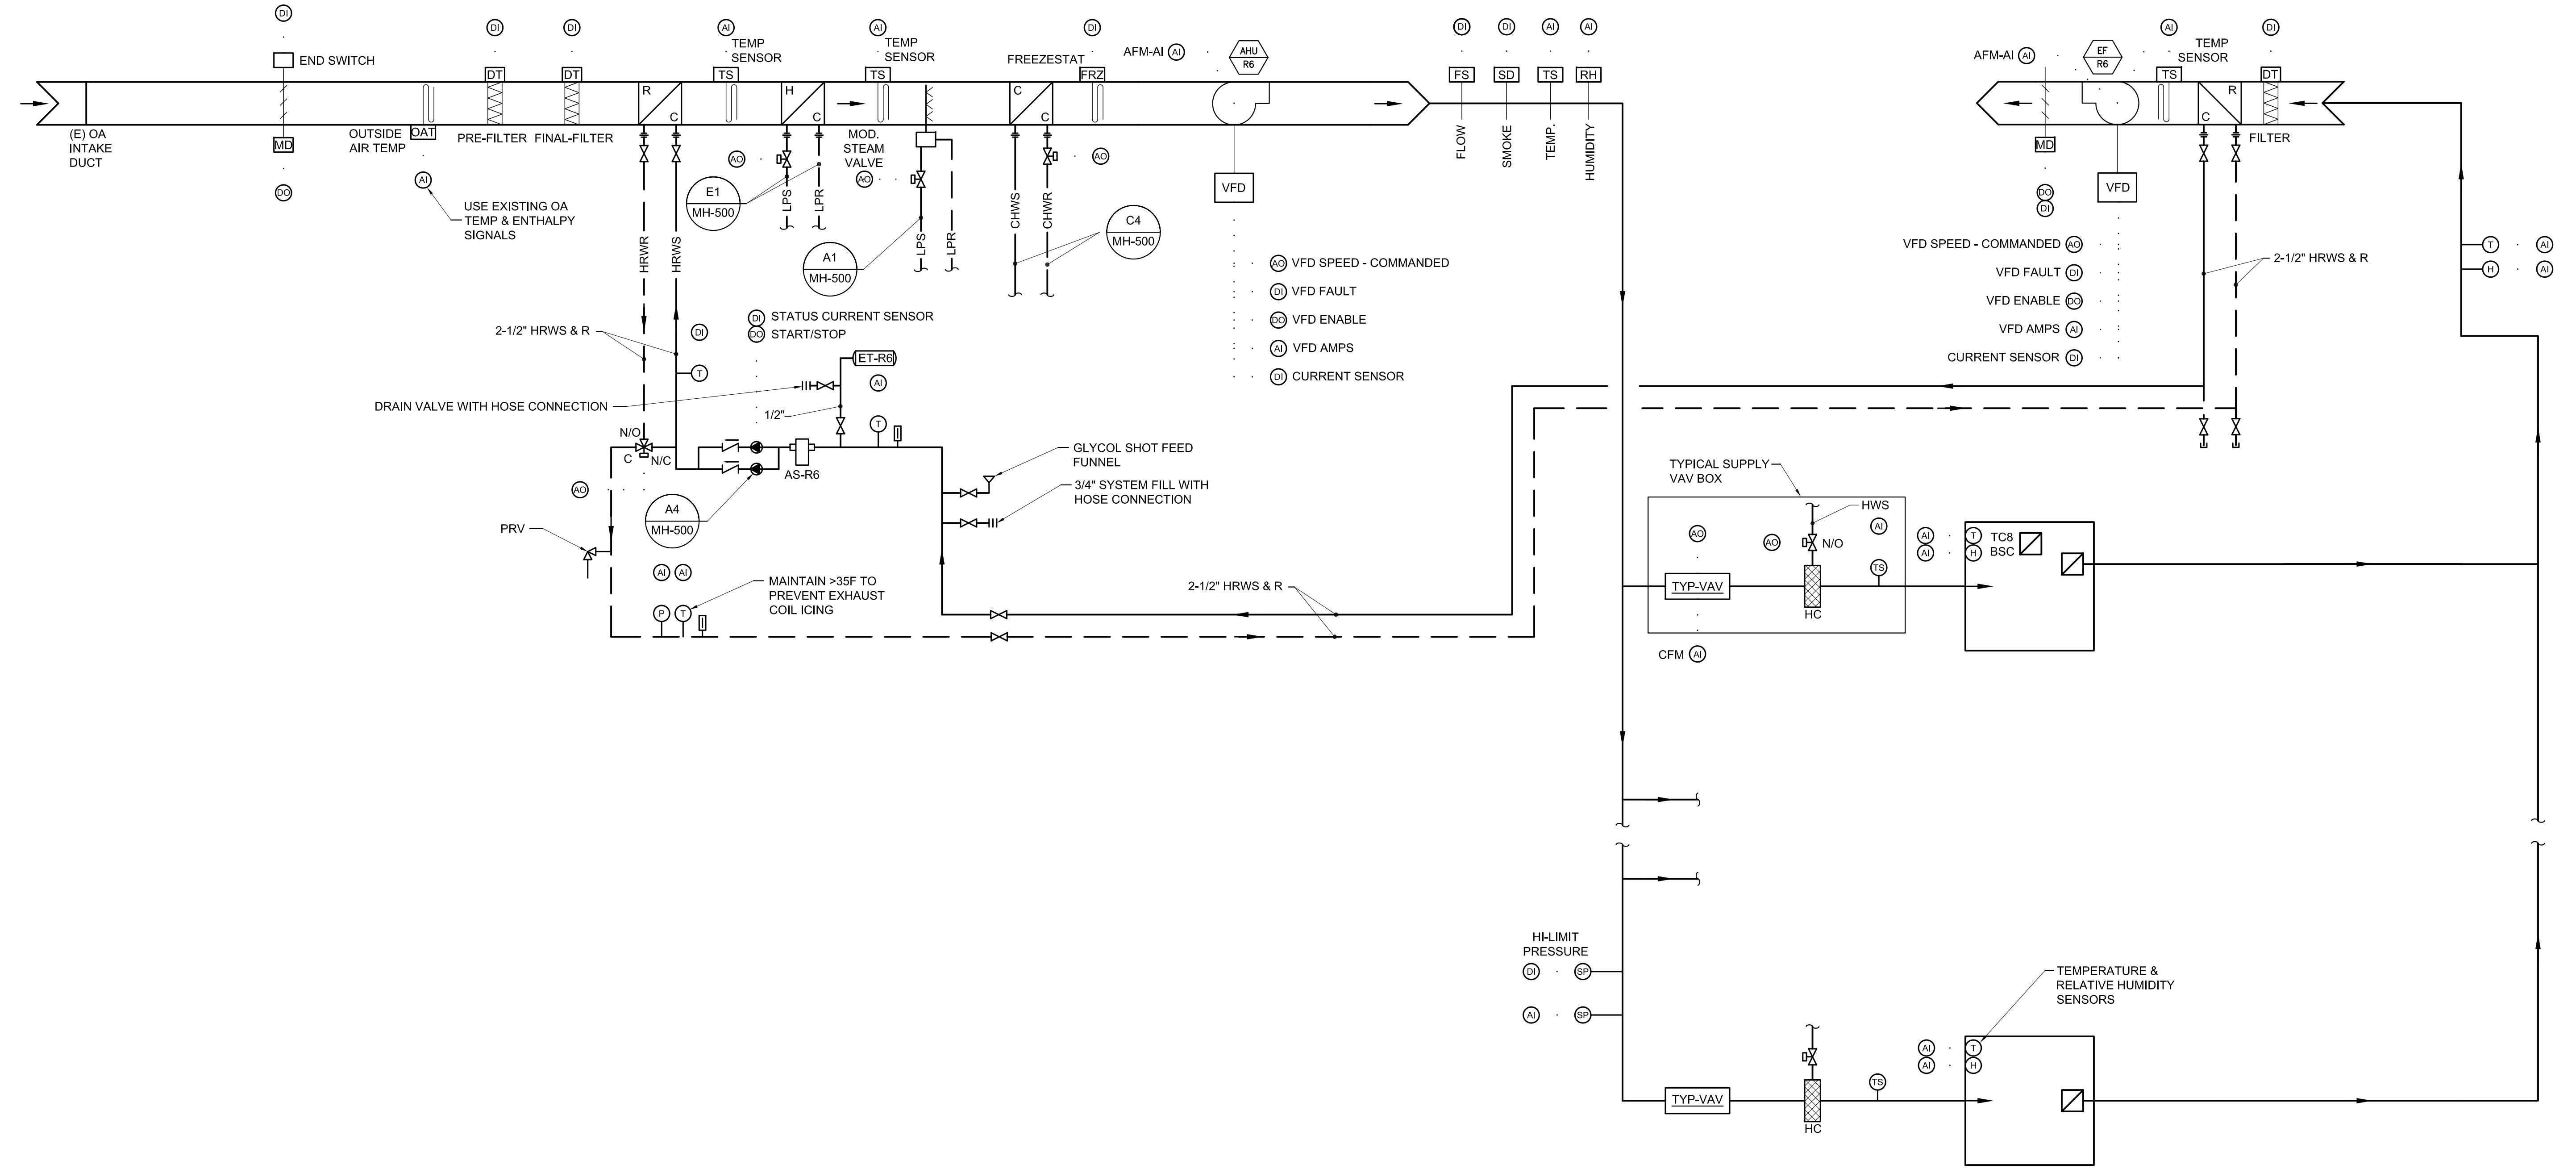

REVISIONS	NUMBER	DATE	BY	DESCRIPTION

Date:	
Drawn By:	SCL
Checked By:	IAM
Project Mgr:	
Project No:	
Cad File:	14014_M.DWG
Graphic:	0
Scale:	1"

<b>BAS CONTROL DIAGRAM</b>	
R6 Intermediate Care Unit Richards Wing Sixth Floor PORTLAND MAINE	

**MH-501**

PERMIT SET ~ 03 APRIL 2015 - NOT FOR CONSTRUCTION

N:\Projects\2014\14014 - MMC R6 2014 Intermediate Care Unit\100 Drawing Files\14014\_M.dwg Apr 03, 2015 - 2:15pm

A1	BAS CONTROL DIAGRAM
NONE	