



DC-PA301

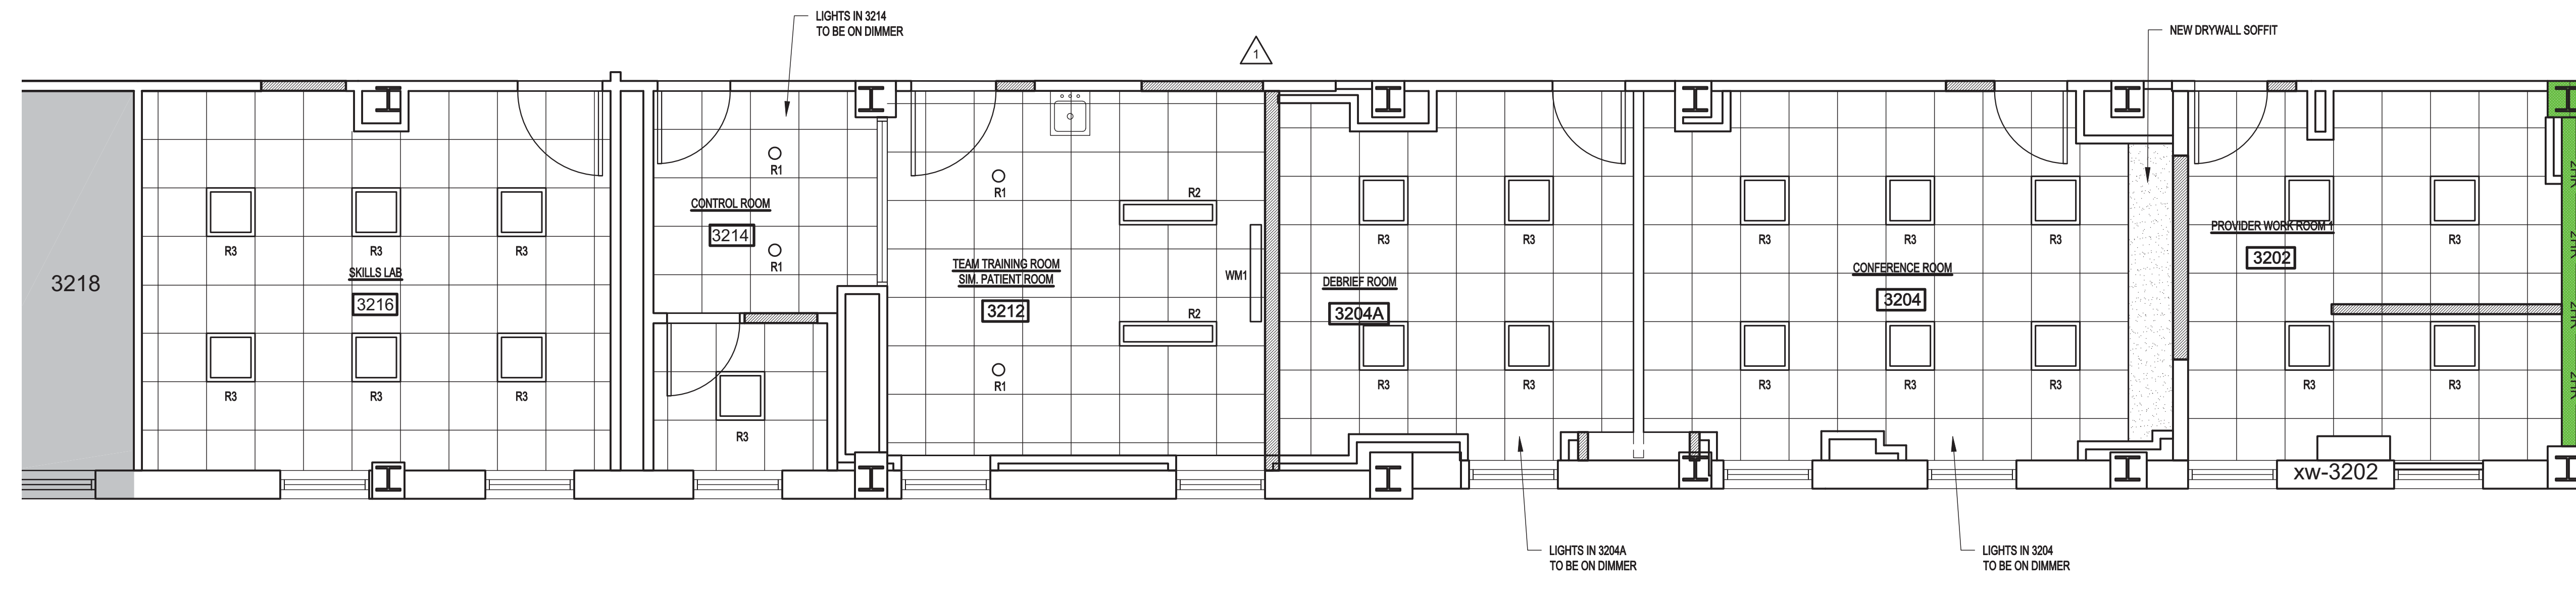


- NEW WALL
- DEMOLISHED WALL
- EXISTING WALL

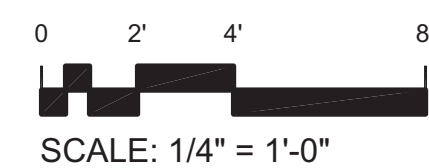

LIGHT FIXTURE SCHEDULE

TAG	TYPE	NOTES
R1	6" ROUND RECESSED LED DOWNLIGHT	
R2	1X4 LED TROFFER	
R3	2X2 LED TROFFER	
WM1	WALL MOUNT UP/DOWN LED PATIENT BED	

Consultants

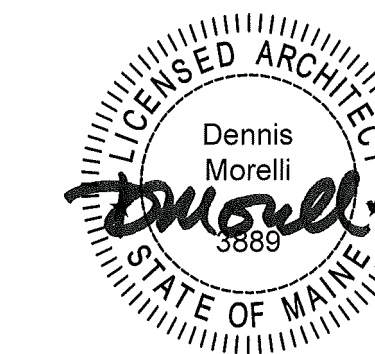

Bramhall Team Training Facility

Campus
 Bramhall
 Building
 Pavilion A
 Floor
 Third

Revisions

No	Revision	Date

Issue ISSUED FOR PERMIT
 Date 4 APRIL 2015
 Project # -
 Drawn By DM
 Checked By DFD
 Title

REFLECTED CEILING PLAN

Sheet

A102