


**REFLECTED CEILING PLAN LEGEND**

- L1 LINEAR RECESSED
- L2 LINEAR WALL GRAZER
- L3 LINEAR WALL WASHER
- L4 LINEAR COVE
- UC UNDERCOUNTER 24" L
- P3A DECORATIVE PENDANT (PURPLE)
- P3B DECORATIVE PENDANT (BLUE)
- P3C DECORATIVE PENDANT (YELLOW)
- P3D DECORATIVE PENDANT (RED)
- P3E DECORATIVE PENDANT (WHITE)
- R1 SQUARE DOWNLIGHT
- R10 SQUARE DOWNLIGHT
- R2 1X4 INDIRECT
- R3 SQUARE WALL WASHER
- R4D LINEAR ASYMMETRICAL BED LIGHT
- W1 FAMILY READING LIGHT
- W2 NIGHT LIGHT
- ACT 2x2 SUSPENDED ACOUSTICAL CEILING
- GMB CEILING
- 2x2 SUPPLY
- SUPPLY
- 2x2 RETURN
- RETURN
- RADIANT PANEL
- FIRE ALARM SPEAKER
- SMOKE DETECTOR
- SPRINKLER
- EXIT SIGN
- CUBICLE PRIVACY CURTAIN TRACK
- IV TRACK
- WINDOW SHADE - DUAL ROLL

**RCP GENERAL NOTES**

1. REFER TO ELEVATIONS FOR MOUNTING HEIGHT FOR MOUNTING HEIGHT OF WALL SCONES.
2. COORDINATE TEES AND HANGER LOCATIONS WITH LINEAR DIFFUSER GRILLE BOOTHS.
3. SPRINKLER HEAD AND COVER TO BE COLORED BY MANUFACTURER TO MATCH ADJ. CEILING FINISH - COLOR TO BE DETERMINED BY ARCHITECT.
4. DIFFUSER GRILLE TO BE COLORED TO MATCH ADJACENT CEILING FINISH. COLOR TO BE DETERMINED BY ARCHITECT.
5. UNLESS OTHERWISE NOTED, CENTER ALL SUSPENDED CEILING GRIDS WITHIN ROOM.
6. CENTER ALL LIGHT FIXTURES, SPRINKLER HEADS, ETC. IN CEILING TILE UNLESS OTHERWISE NOTED.
7. SEE ENGINEERING DRAWINGS FOR ADDITIONAL INFORMATION RE LIGHT FIXTURES, DIFFUSERS AND OTHER CEILING MOUNTED DEVICES.
8. COORDINATE CEILING MOUNTED EQUIPMENT FINAL LAYOUT WITH OWNER AND VENDOR INSTALLATION DRAWINGS.
9. PROVIDE UNDER-CABINET LIGHT AT ALL LOCATIONS WITH UPPER CABINETS.

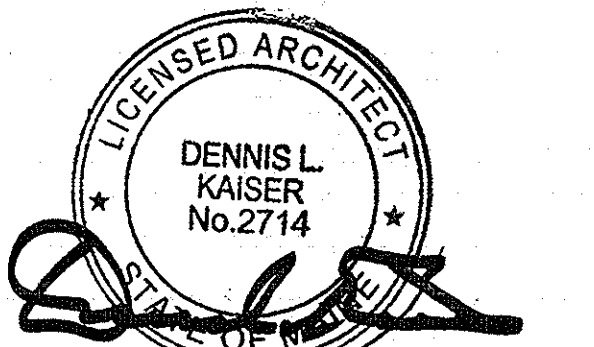


Revisions

ISSUED FOR PERMIT	06/08/15
1 ADDENDUM NO. 1	05/22/15
NO	ISSUE DATE
<b>Sheet Information</b>	
Date	MAY 1, 2015
Job Number	152168.009
Drawn	Author
Checked	sc
Approved	Approver
<b>Title</b>	

**LEVEL 06 - PICU -  
REFLECTED  
CEILING PLAN**

Sheet  
**A05-06**

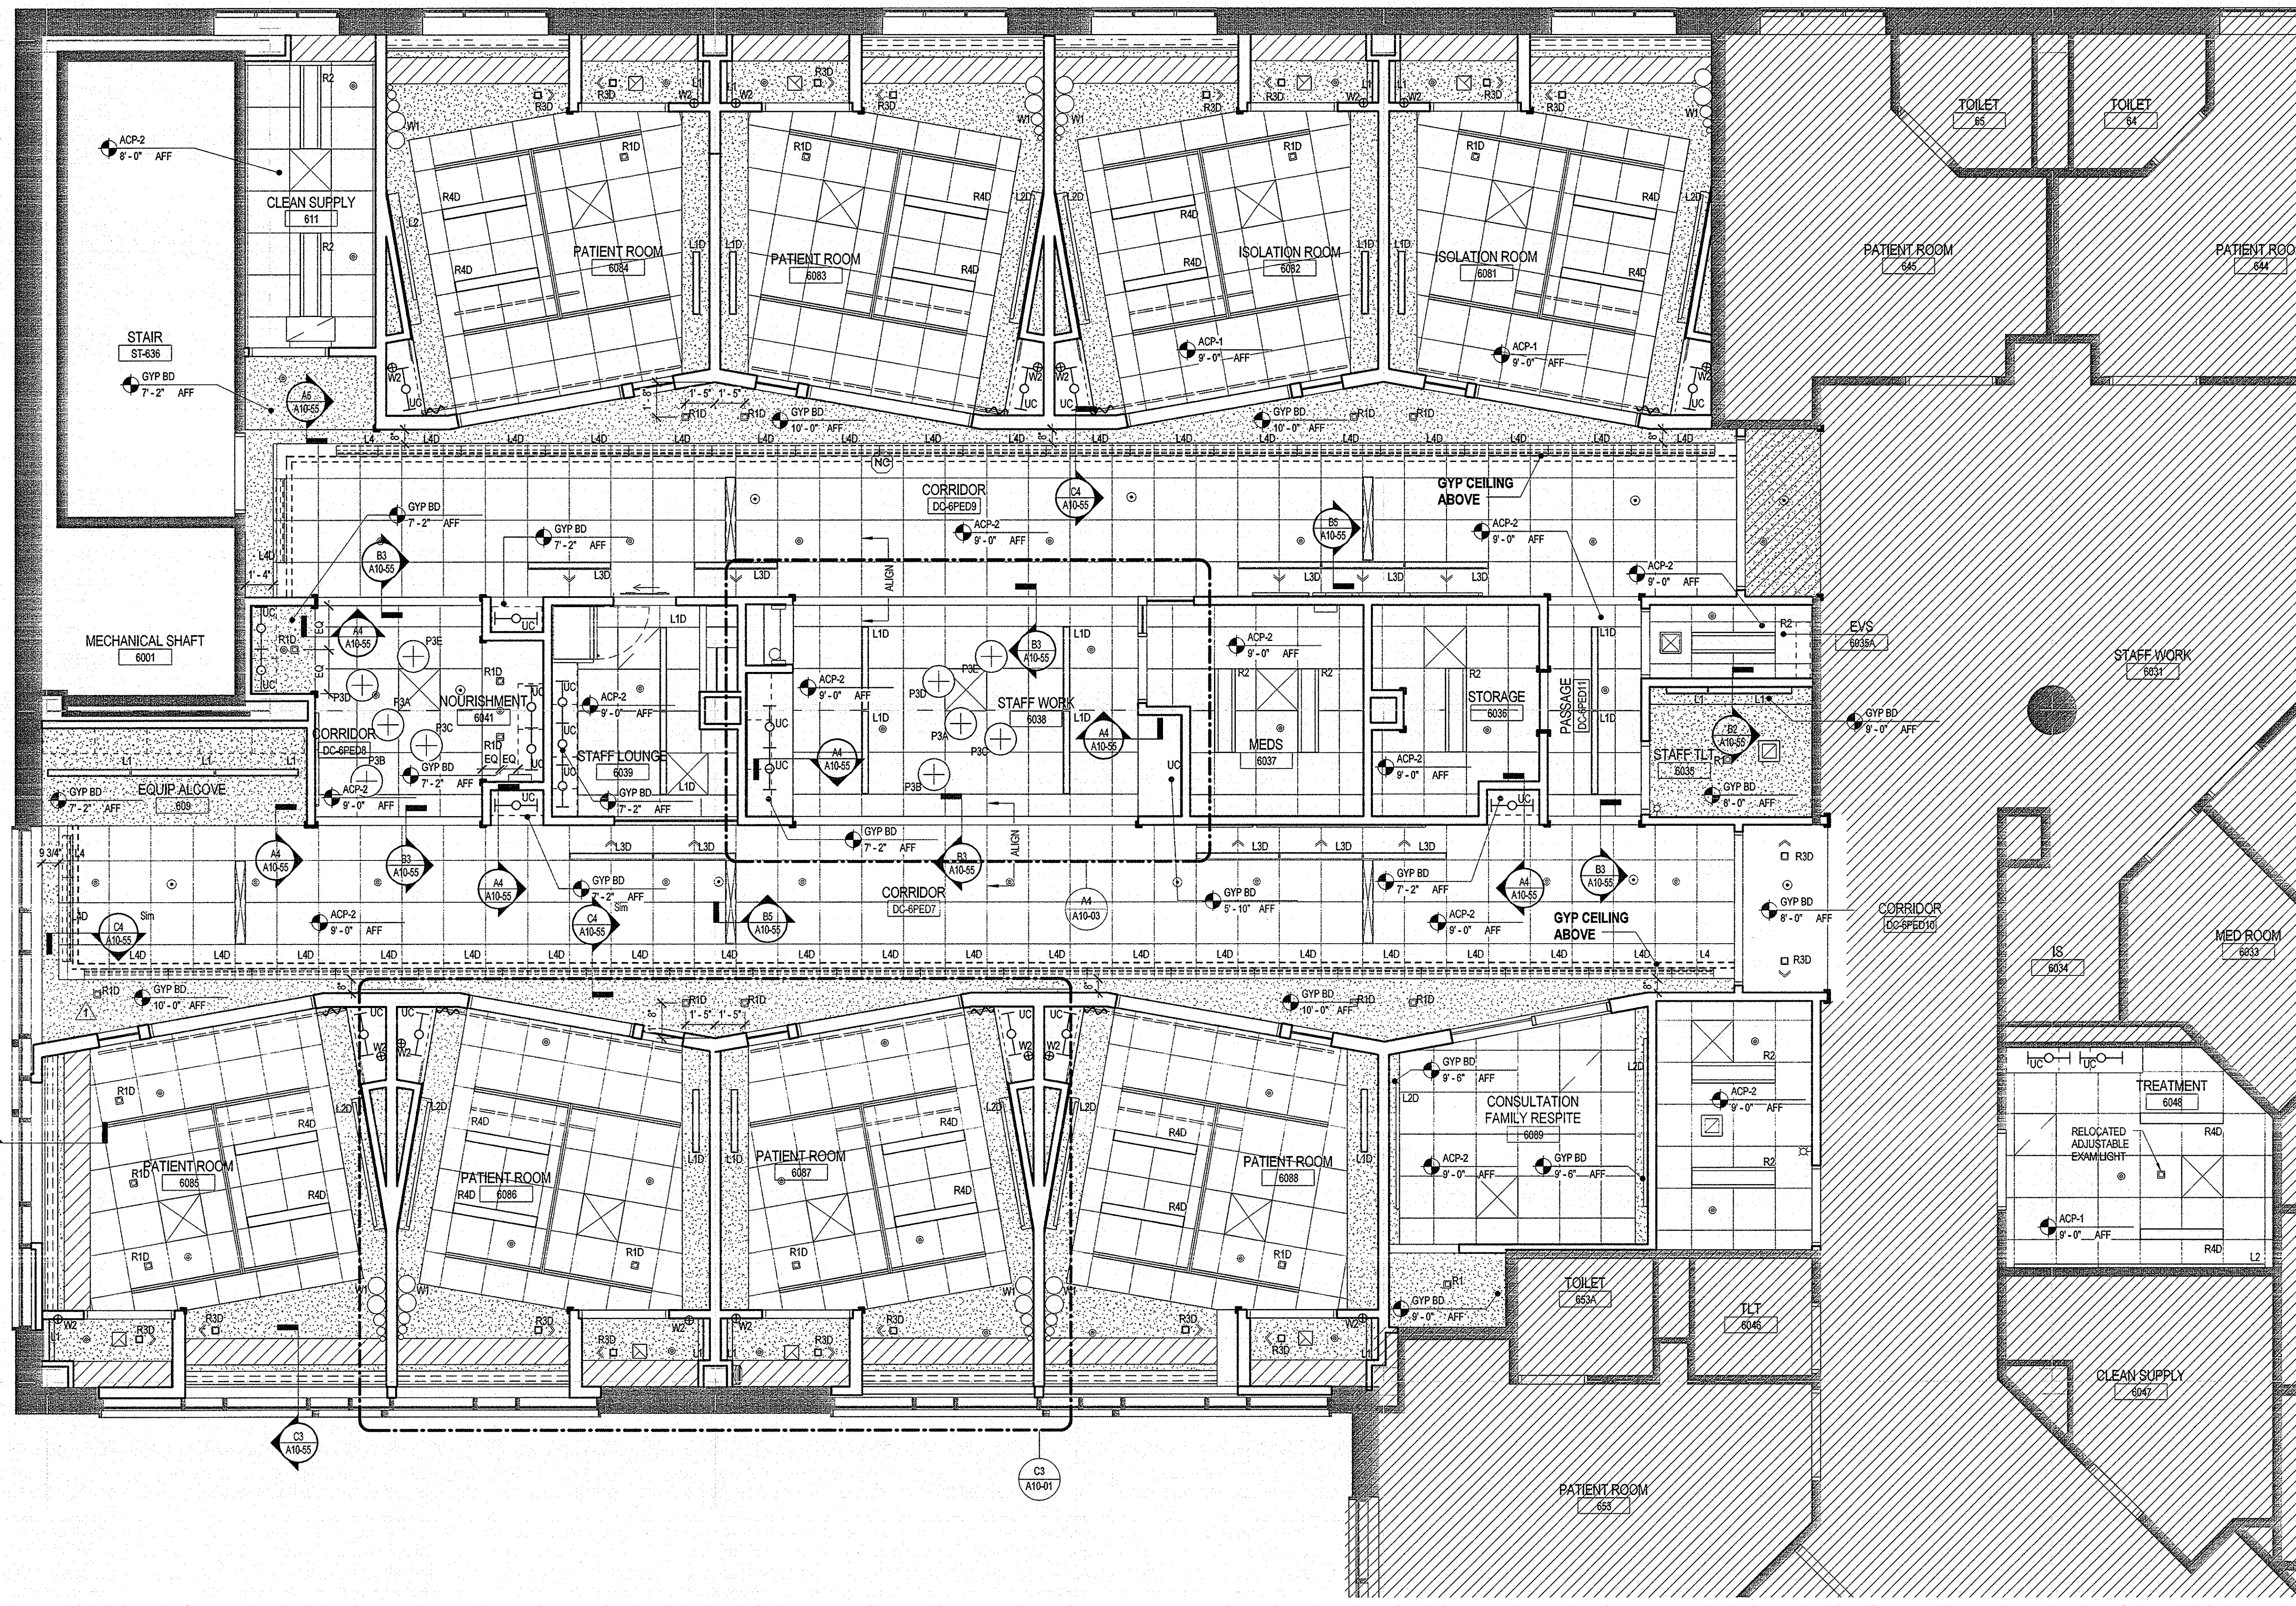

**1 LEVEL 06 PICU - REFLECTED CEILING PLAN**  
1/4" = 1'-0"