

Revisions

NO	ISSUE	DATE
1	ISSUED FOR PERMIT	06-08-15
2	ADDENDUM NO. 2	06-03-15
1	ADDENDUM NO. 1	05-22-15

Sheet Information

Date	MAY 1, 2015
Job Number	B140185-000
Drawn	GN
Checked	RAC
Approved	RAC
Title	


ELECTRICAL  
RISER DIAGRAMS  
AND SCHEDULES

Sheet

E00-10

FIXT. TYPE	DESCRIPTION	LAMPS			BALLAST		VOLTAGE	MANUFACTURER	CATALOG NUMBER	REMARKS
		NO.	WATTS	TYPE	NO.	INTEGRAL				
L1	CEILING RECESSED LENSED LINEAR SLOT FIXTURE	-	7.1FT	LED	1	Y	UNV	Pinnacle	ESL-38-XX-CONTINUOUS RUNS-VERIFY-UNV-4C-W	SEE NOTES 1-4
L1D	CEILING RECESSED LENSED LINEAR SLOT FIXTURE	-	7.1FT	LED	1	Y	UNV	Pinnacle	ESL-38-XX-CONTINUOUS RUNS-UNV-4C-W	
L2D	CEILING RECESSED LINEAR WALL WASHER	-	10FT	LED	1	Y	UNV	PRUDENTIAL BIONIC SERIES	BD-PRD-BEG3-LEDS-SCR-LENGTH-TMW-AWW-41G-LP-SCLNVC0M10	
L3D	CEILING RECESSED LINEAR WALL WASHER	-	10FT	LED	1	Y	UNV	Pinnacle	EV3WW-38HD-LENGTH-UNV-10-W	
L4D	SURFACE MOUNTED COVE FIXTURE	-	3FT	LED	1	Y	UNV	LD LIGHTING	08-380VHC02R-1-LENGTHD	PROVIDE DEDICATED LED SECTION AND DRIVER FOR ALL EMERGENCY LIGHTING SECTIONS (REFER TO FLOOR PLAN FOR EXACT QUANTITIES)
P3 SERIES	CEILING PENDANT DISK FIXTURE	-	30	LED	1	Y	UNV	REGAL LUMBERG	1456A-CUSTOM BAL	
R1	CEILING RECESSED SQUARE DOWNLIGHT	-	17.8	LED	1	Y	277	LUCIFER	28E-FD-1-WH-80X-13A-3C-1-N-VERIFY/DHMC-VERIFY-80X-13A-UJND-VERIFY-SGL-2	
R1D	CEILING RECESSED SQUARE DOWNLIGHT	-	17.8	LED	1	Y	277	LUCIFER	28E-FD-1-WH-80X-13A-3C-1-N-VERIFY/DHMC-VERIFY-80X-13A-UJAN-VERIFY-SGL-2	
R2	CEILING RECESSED 1'x1' FIXTURE	-	47	LED	1	Y	UNV	WILLIAMS	S03-S14-EDP0748385-F-056MYLAR-EDD07-UNV	
R3	CEILING RECESSED LENSED WALL WASHER	-	23	LED	1	Y	UNV	LUCIFER	D142P-NC-V-VERIFY-8013-3C-3DHMC-VERIFY-VERIFY-8013-UNV/ADJA-APP-Z-SQ-3	
R3D	CEILING RECESSED LENSED WALL WASHER	-	23	LED	1	Y	UNV	LUCIFER	D142P-NC-V-VERIFY-8013-3C-3DHMC-VERIFY-VERIFY-8013-UNV/ADJA-APP-Z-SQ-3	
R4D	CEILING RECESSED LINEAR ASYMMETRICAL EXAM ROOM FIXTURE	-	43.2	LED	1	Y	UNV	WILLIAMS	MD2G-44-EDP290835-A1CHA118-S6MYLAR-EDD2PH-UNV	
UC	UNDERCABINET TASK LIGHT	-	T8D	LED	1	Y	UNV	HEALTHCARE LIGHTING	HUC6-MVOLT4-EDGE-DIM-ACCESSORIES AS REQ'D-AM	
W1	SURFACE MOUNTED DECORATIVE WALL SCENE	-	7.35	LED	1	Y	120	VERIA	S840-COULED	
W2	RECESSED NIGHT LIGHT	-	1.5	LED	1	Y	UNV	COLE	1420W-AL-AMB	
EX1	SURFACE MOUNTED SINGLE FACE EXIT SIGN	-	2	LED	1	Y	UNV	EVENLITE	S0V-AC-R-1C-WH-XXX-PP-SD	COORDINATE ARROW DIRECTIONS WITH FLOOR PLANS
EX2	SURFACE MOUNTED DOUBLE FACE EXIT SIGN	-	2	LED	1	Y	UNV	EVENLITE	S0V-AC-R-2M-WH-PP-XXX-PP-SD	COORDINATE ARROW DIRECTIONS WITH FLOOR PLANS


LIGHTING FIXTURE SCHEDULE NOTES:  
1. COORDINATE ALL FIXTURE FINISH COLORS WITH ARCHITECT PRIOR TO BID.  
2. COORDINATE COLOR AND TEMPERATURE OF ALL LAMPS WITH ARCHITECT.  
3. COORDINATE FIXTURE LENGTHS WITH ARCHITECTURAL FLOOR PLANS.  
4. COORDINATE FIXTURE TRIM WITH CEILING TYPE WHERE FIXTURE IS BEING INSTALLED.

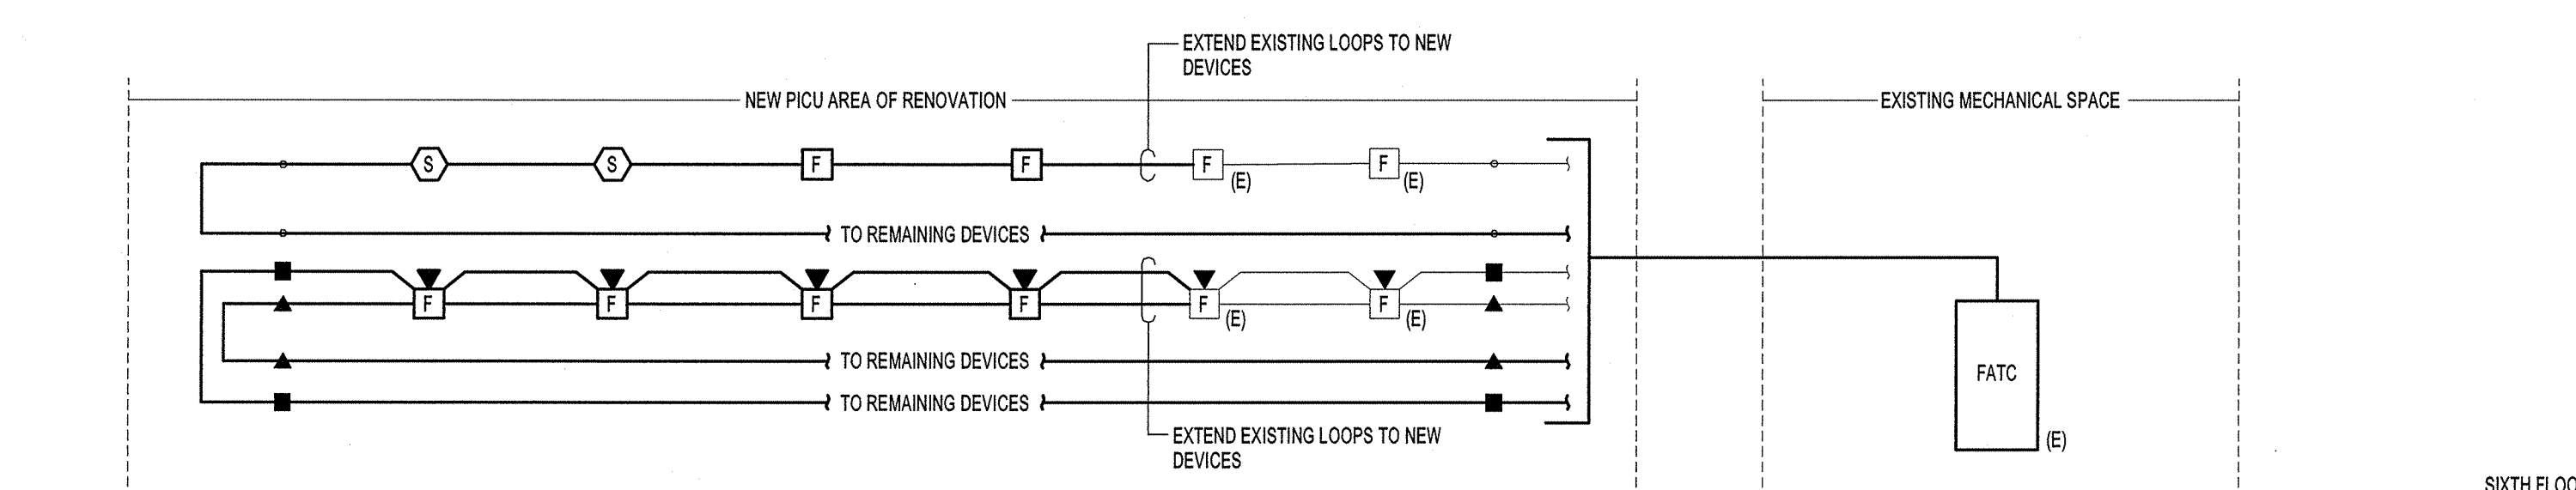

1 PARTIAL FIRE ALARM RISER DIAGRAM  
SCALE: N.T.S.

FIRE ALARM WIRING LEGEND:

- CLASS 'A' ADDRESSABLE SIGNAL CIRCUIT
- CLASS 'A' AUDIO EVAC. CIRCUITS
- CLASS 'A' STROBEMANDIPAL LIGHT
- INDICATES CONTINUATION OF WIRING TYPE

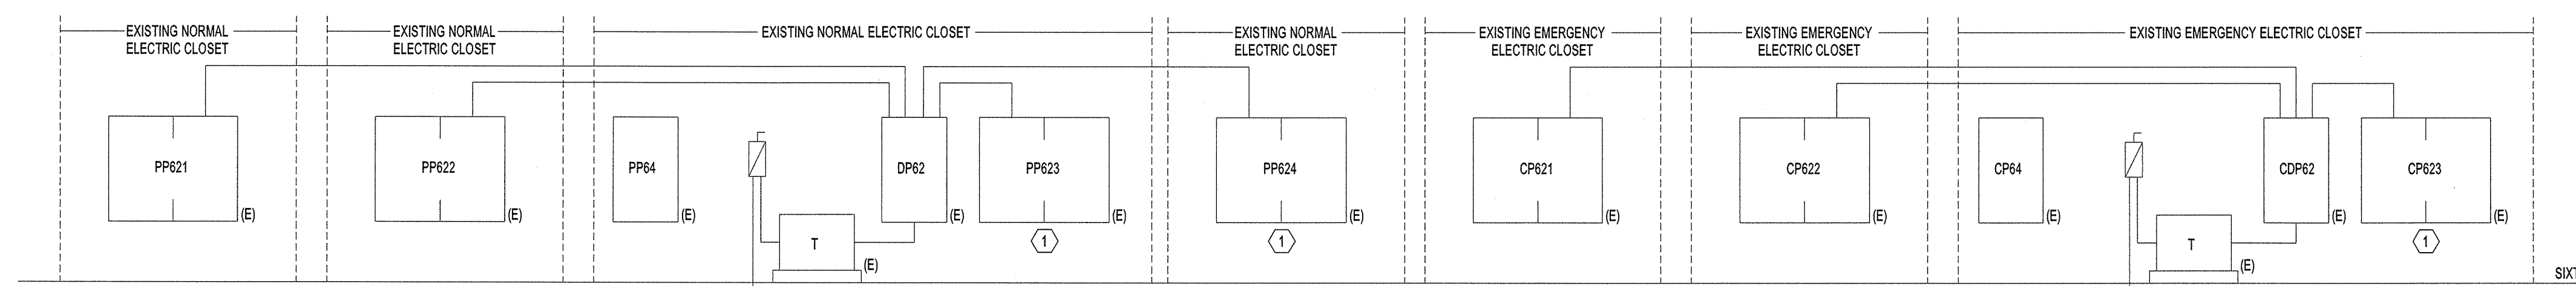

1 PARTIAL POWER RISER DIAGRAM  
SCALE: N.T.S.

RISER DIAGRAM KEY NOTES:

- 1 PRIOR TO TIE-IN ELECTRICAL CONTRACTOR SHALL METER EXISTING PANELBOARD PER NEC 2014 ARTICLE 220.87 AND HAVE THE FINDINGS COMPILED INTO A REPORT. A COPY OF THIS REPORT SHALL BE GIVEN TO THE ARCHITECT AND ENGINEER UPON METERING COMPLETION. ELECTRICAL CONTRACTOR SHALL NOT ROUGH-IN NEW FEEDER UNTIL REPORT HAS BEEN REVIEWED BY THE ENGINEER.