

Revisions


NO	ISSUE	DATE
1	ISSUED FOR PERMIT	06-08-15
1	ADDENDUM NO. 2	06-03-15

Sheet Information

Date	MAY 1, 2015
Job Number	B140185-000
Drawn	TU
Checked	DR
Approved	DR

**MECHANICAL
FLOOR PLAN
LEVEL 6 -
DEMOLITION
DUCTWORK**

Sheet
M01-06

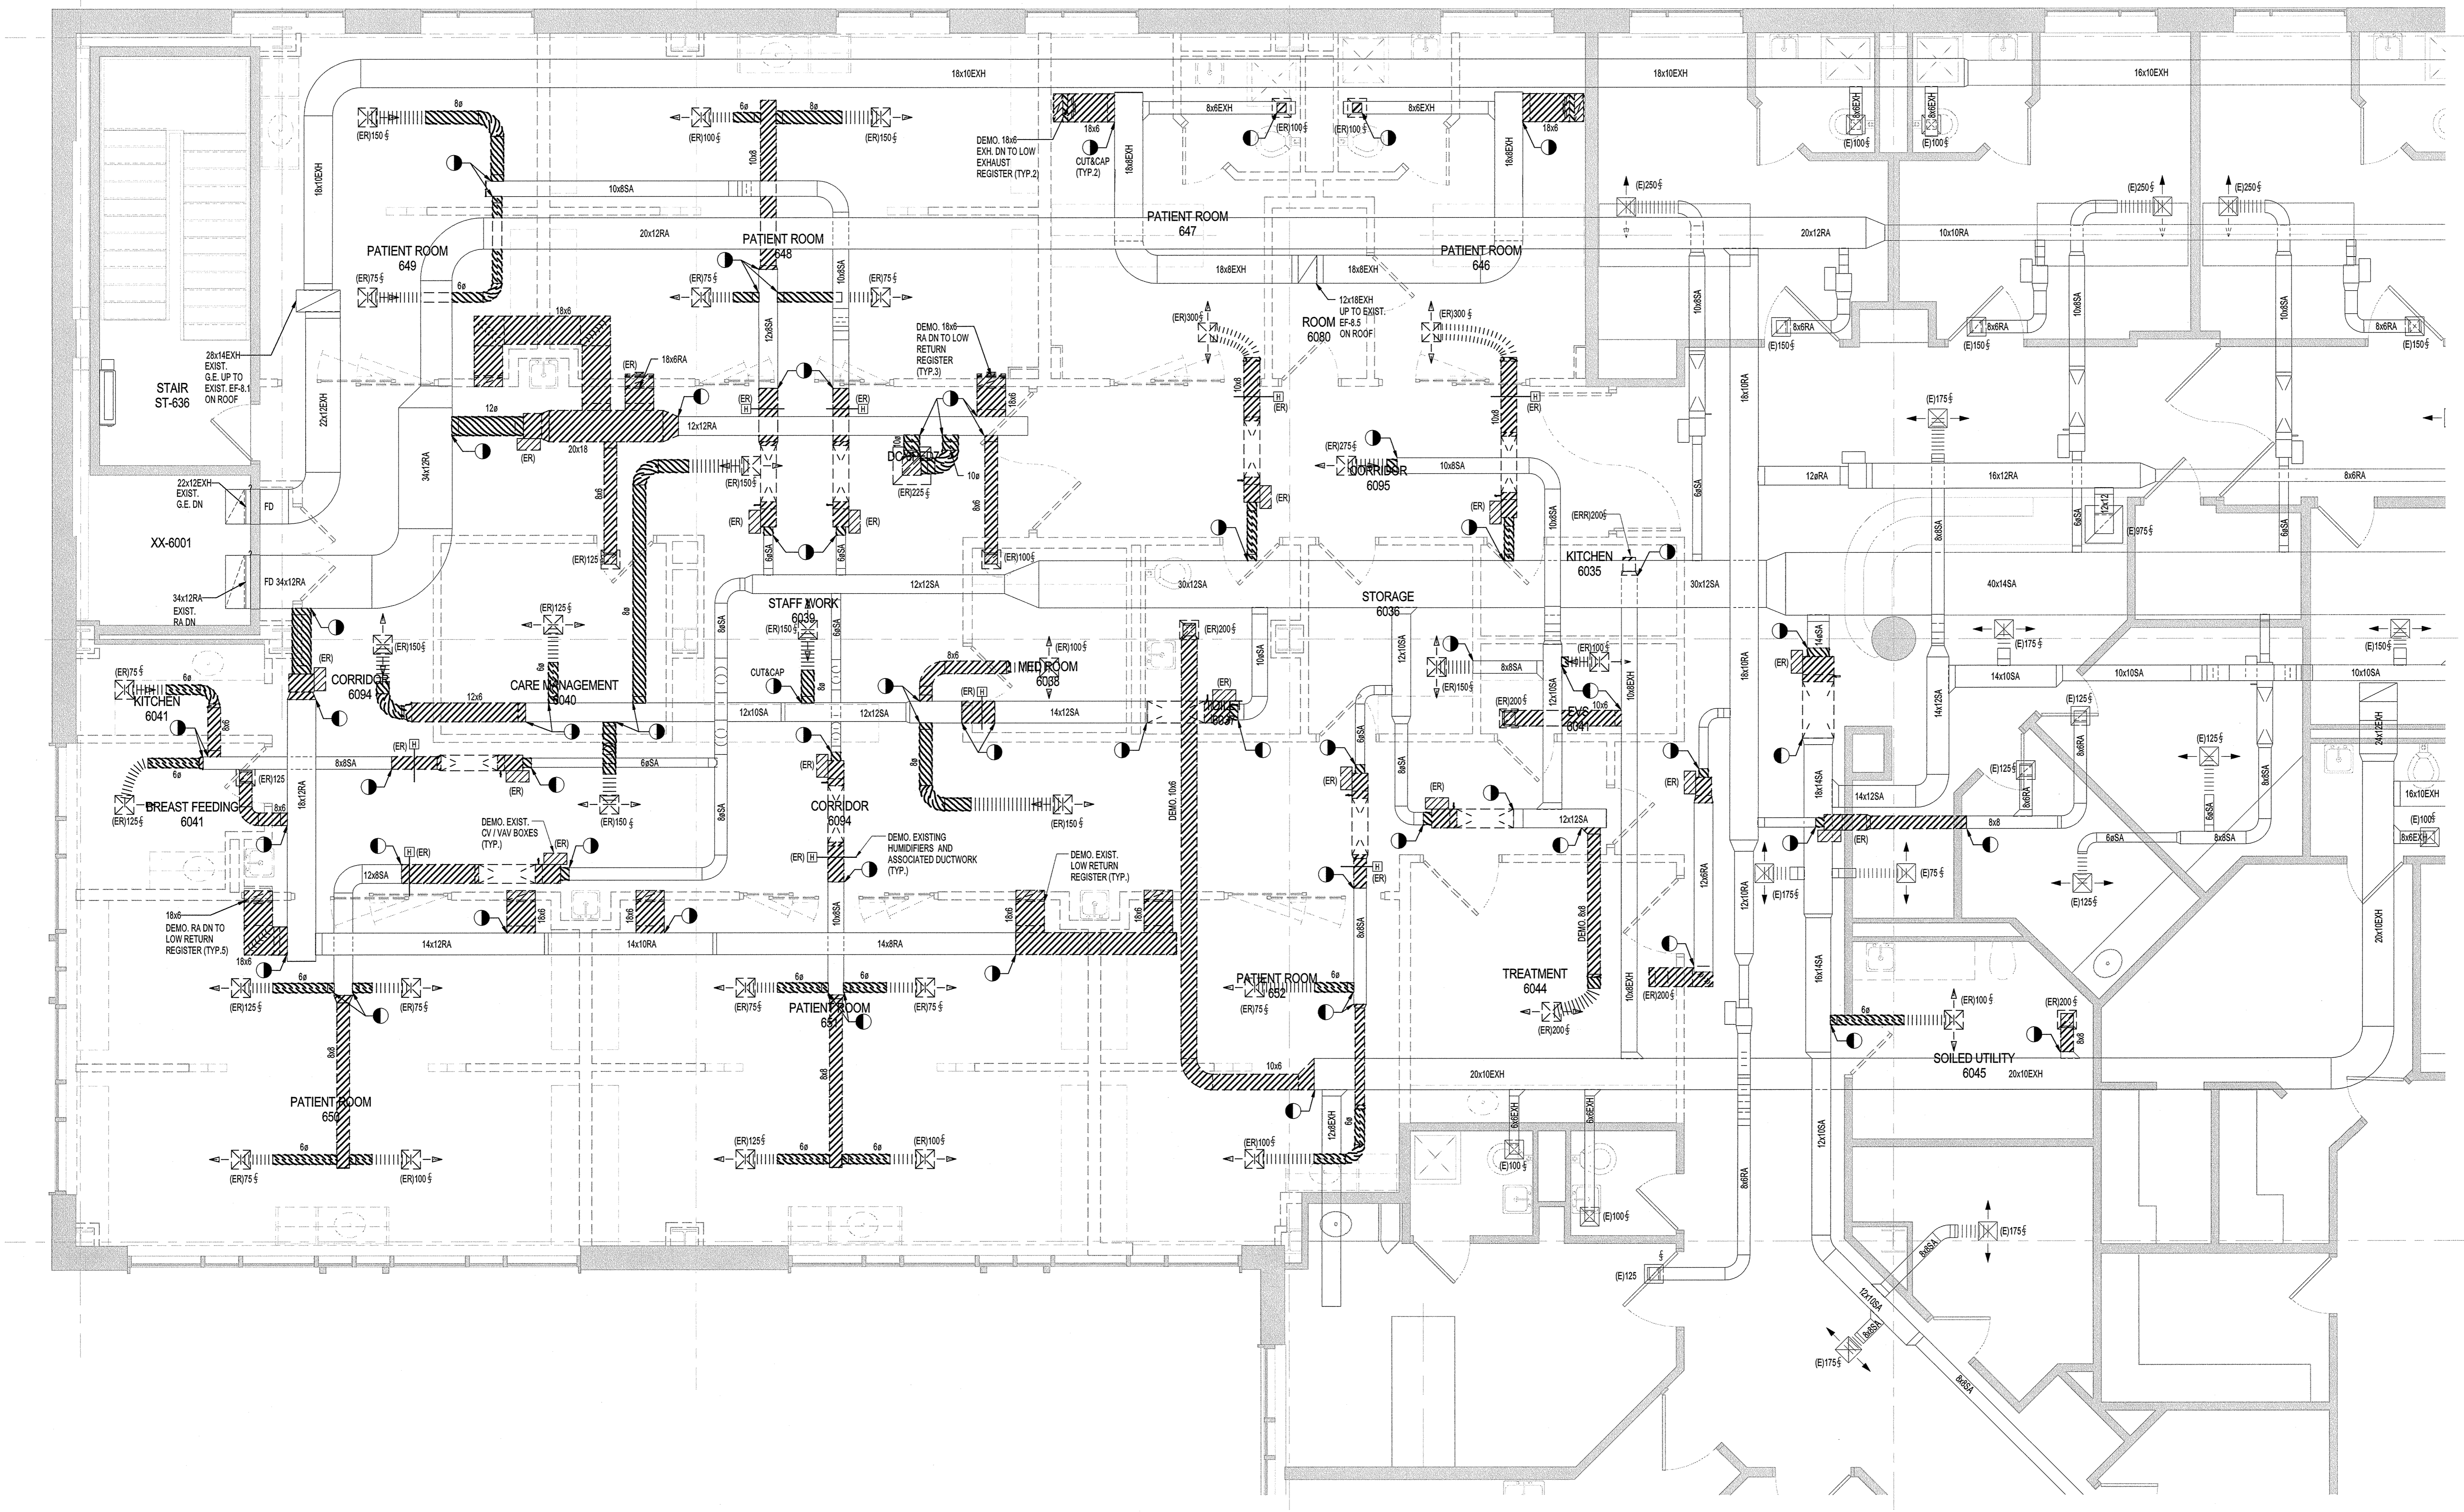

1 MECHANICAL DUCTWORK DEMOLITION PLAN
SCALE: 1/4" = 1'-0"

6/8/2015 10:55:50 AM
C:\P\it Local Files\B140185-000 MMC_PICU MEP FL 6 CENTRAL_gmbison.rvt