

Revisions


NO	ISSUE	DATE
1	ISSUED FOR PERMIT	06-09-15
2	ADDENDUM NO. 2	06-03-15

Sheet Information

Date	MAY 1, 2015
Job Number	B140185-000
Drawn	TU
Checked	DR
Approved	DR

**MECHANICAL
FLOOR PLAN
LEVEL 6 -
DEMOLITION
PIPING**

Sheet
M02-06

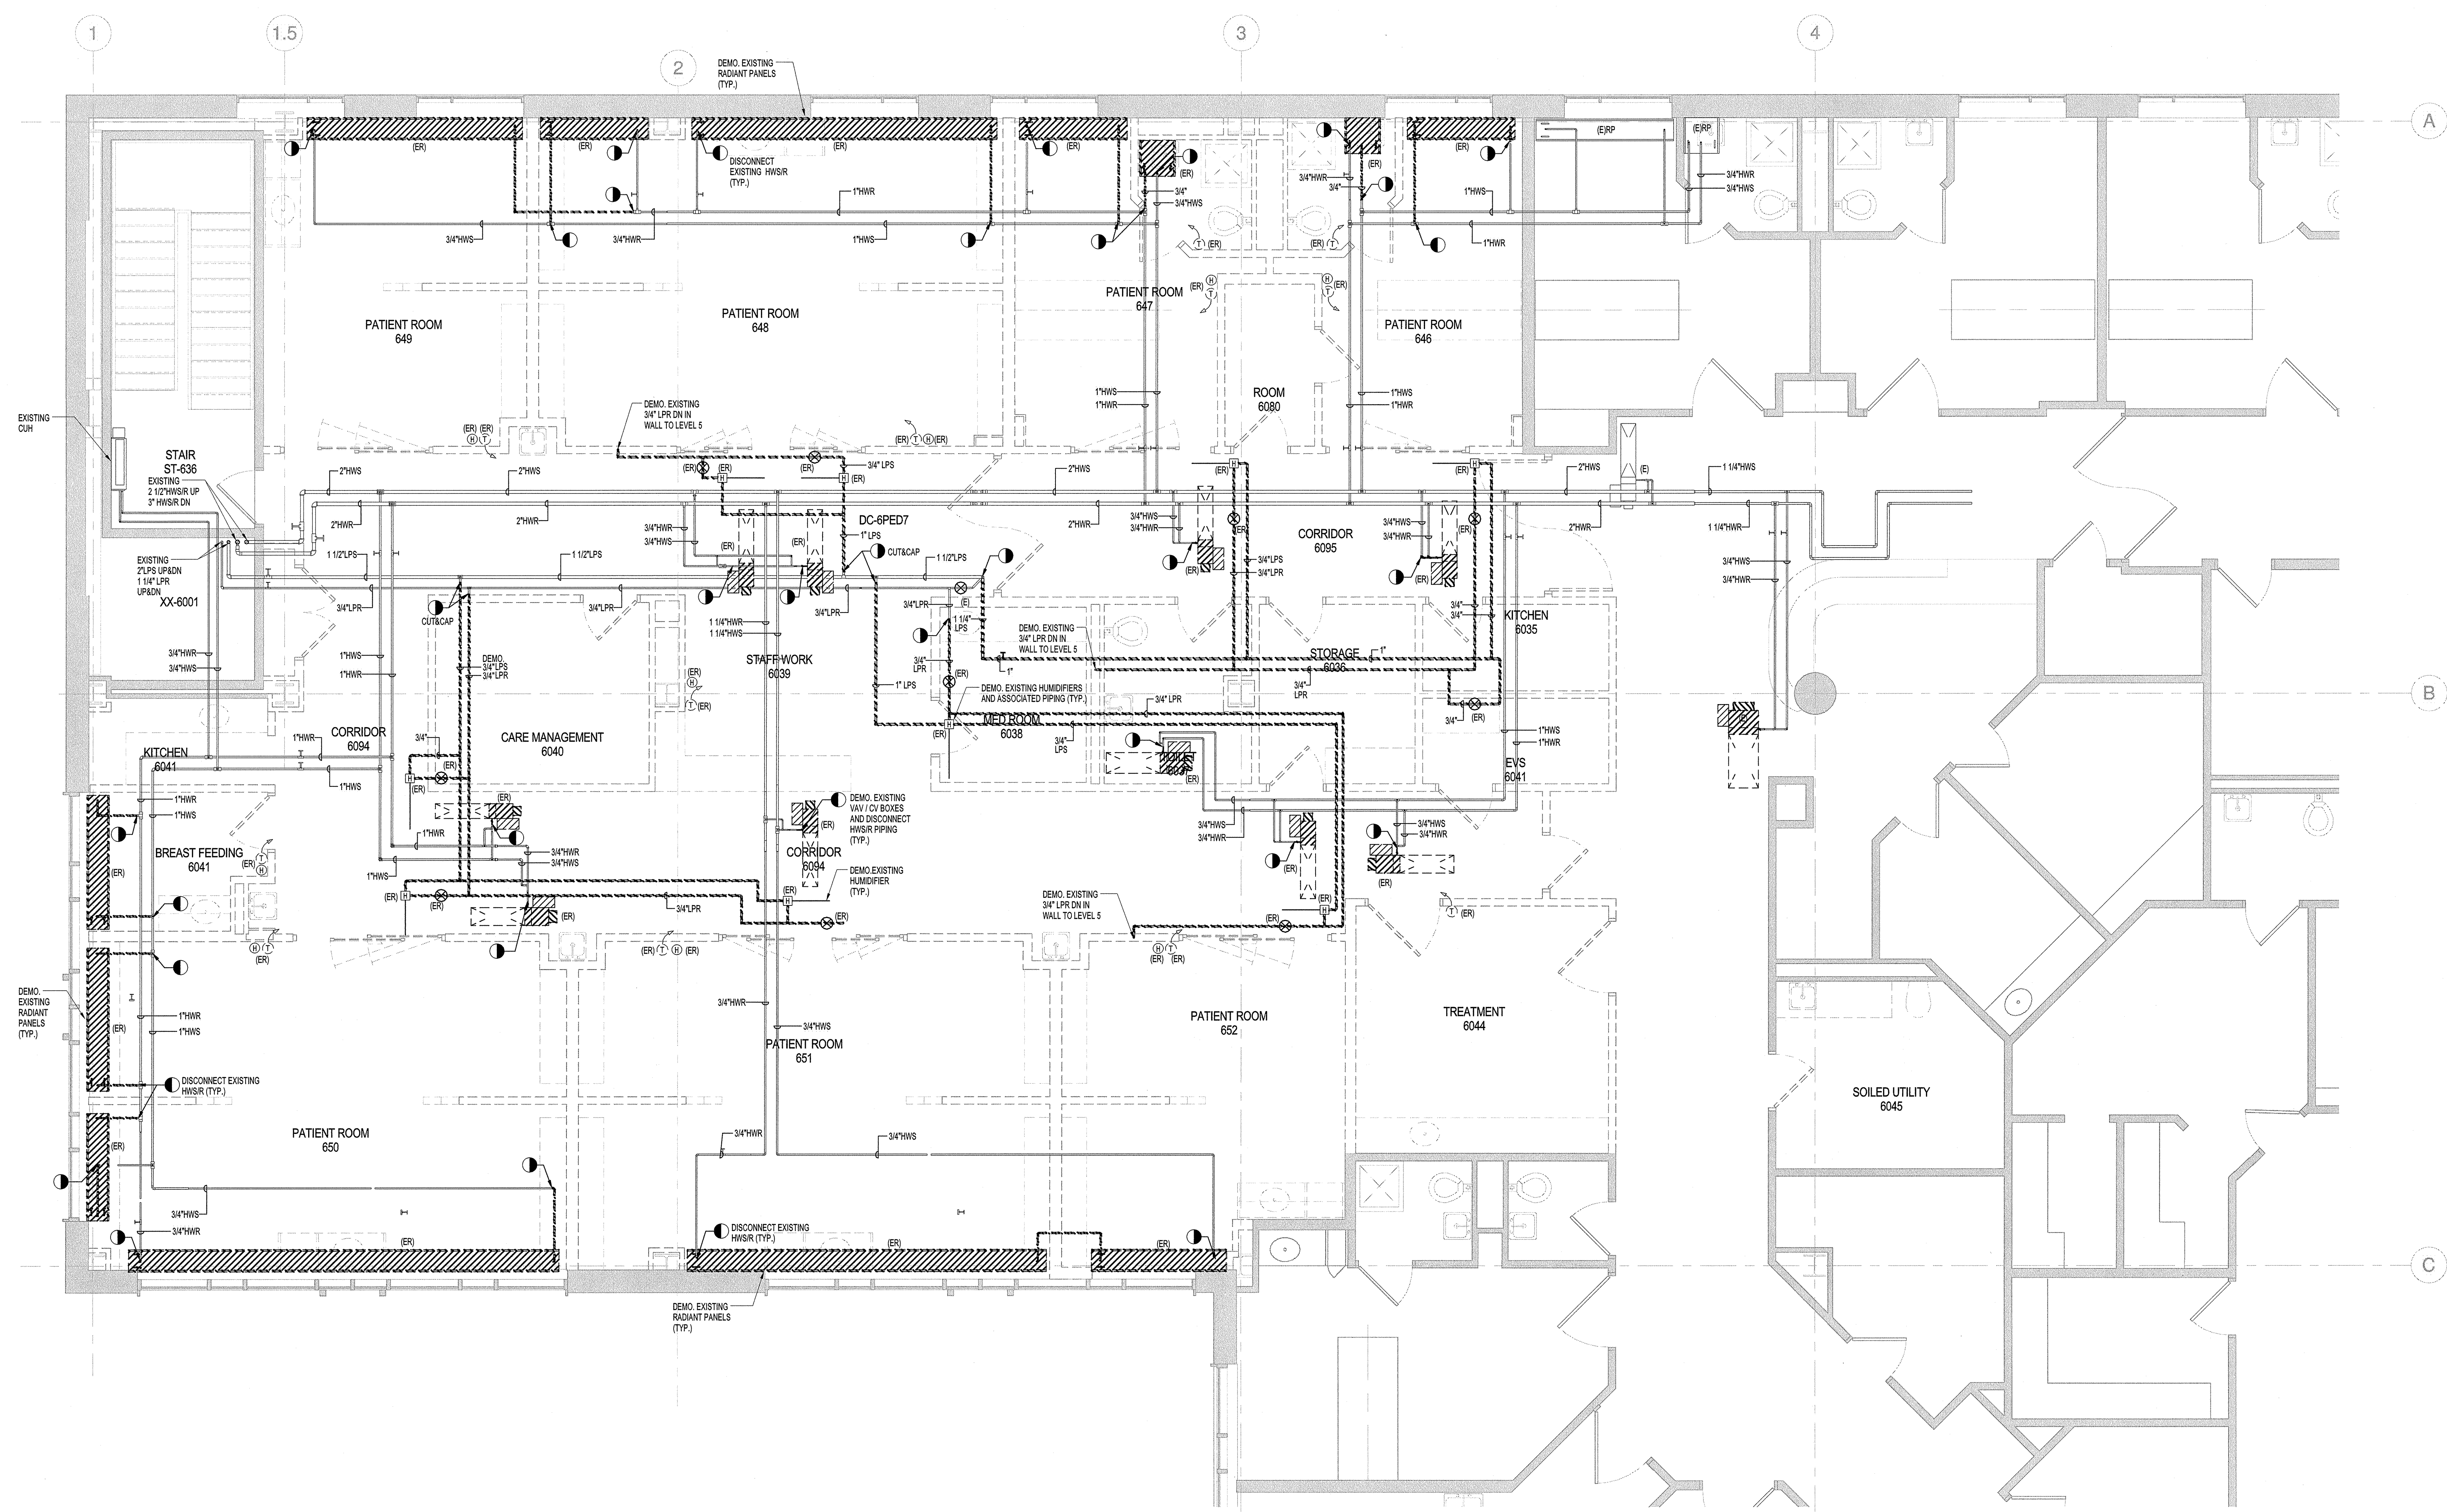

1 MECHANICAL PIPING DEMOLITION PLAN
SCALE: 1/4" = 1'-0"