

ISSUED FOR PERMIT	06-08-15
1 ADDENDUM NO. 2	06-03-15
NO.	ISSUE DATE

Sheet Information


Date	MAY 1, 2015
Job Number	B140185-000
Drawn	TU
Checked	DR
Approved	DR

Title

MECHANICAL
FLOOR PLAN
LEVEL 6 -
DUCTWORK

Sheet

M03-06

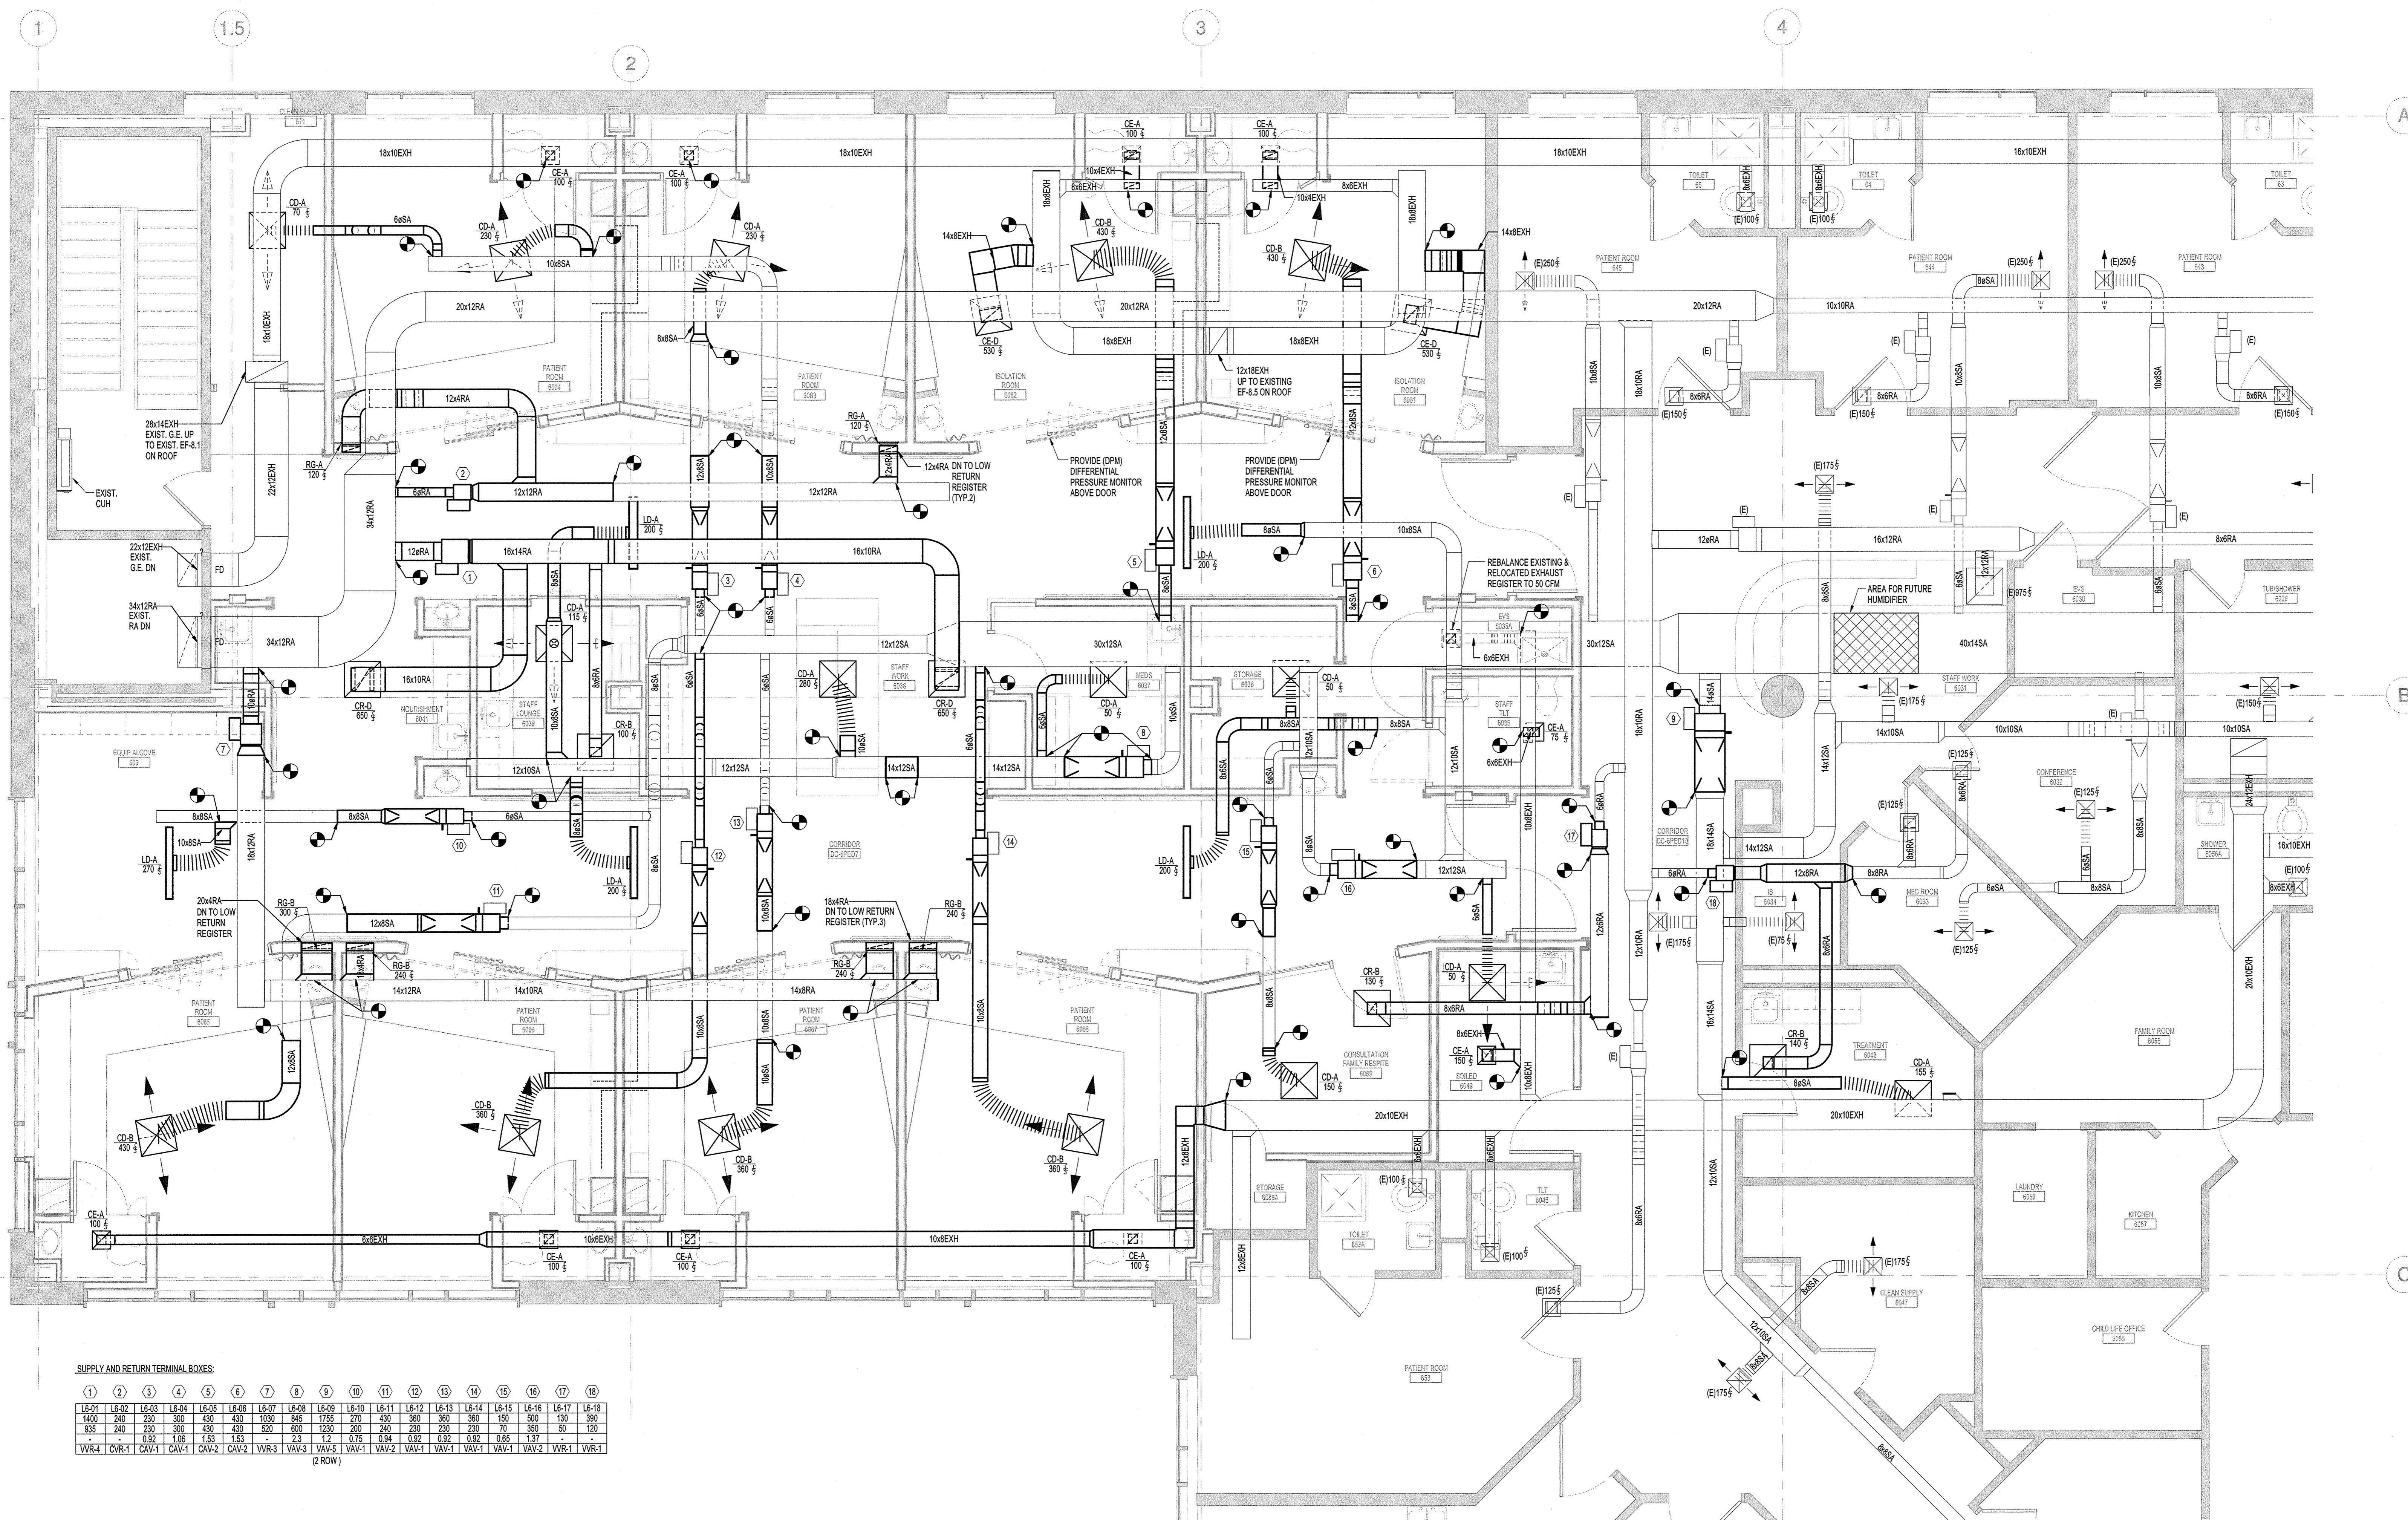

SUPPLY AND RETURN TERMINAL BOXES:

	1	2	3	4	5	6	7	8	9	10	11	12	13	14	15	16	17	18
L6-01	L6-02	L6-03	L6-04	L6-05	L6-06	L6-07	L6-08	L6-09	L6-10	L6-11	L6-12	L6-13	L6-14	L6-15	L6-16	L6-17	L6-18	
1400	240	300	450	450	1050	840	1150	270	450	360	360	360	150	360	150	360	150	
135	240	300	450	450	800	1100	260	450	350	350	350	140	350	140	350	140		
	0.92	1.08	1.53	1.53	2.3	1.2	0.75	0.84	0.92	0.92	0.92	0.65	1.37					
VR4	CR-1	CAV-1	CAV-1	CAV-2	CAV-2	VR-3	VAL-3	VAL-1	VAL-2	VAL-1	VAL-1	VAL-1	VAL-1	VAL-1	VAL-1	VAL-1	VAL-1	

MECHANICAL DUCTWORK PLAN

SCALE: 1/4" = 1'-0"