

MMC - PICU

Maine Medical  
Center

22 Branhall Street, Portland,  
ME 04102

MEP ENGINEER


AKF GROUP, LLC

99 Bedford Street, 2nd Floor

Boston, MA 02111

1 617 737 3111

1 617 737 4311

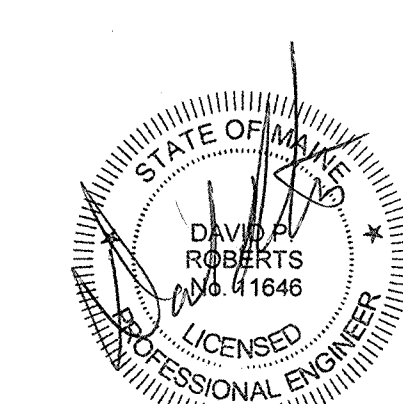

Revisions

NO.	ISSUE	DATE
1	ISSUED FOR PERMIT	06-09-15
1	ADDENDUM NO. 2	06-03-15
	NO.	ISSUE
	DATE	

**Sheet Information**


Date: MAY 1, 2015  
Job Number: B140185-000  
Drawn: TU  
Checked: DR  
Approved: DR

Title

MECHANICAL  
FLOOR PLAN  
LEVEL 6 - PIPING

Sheet

M04-06

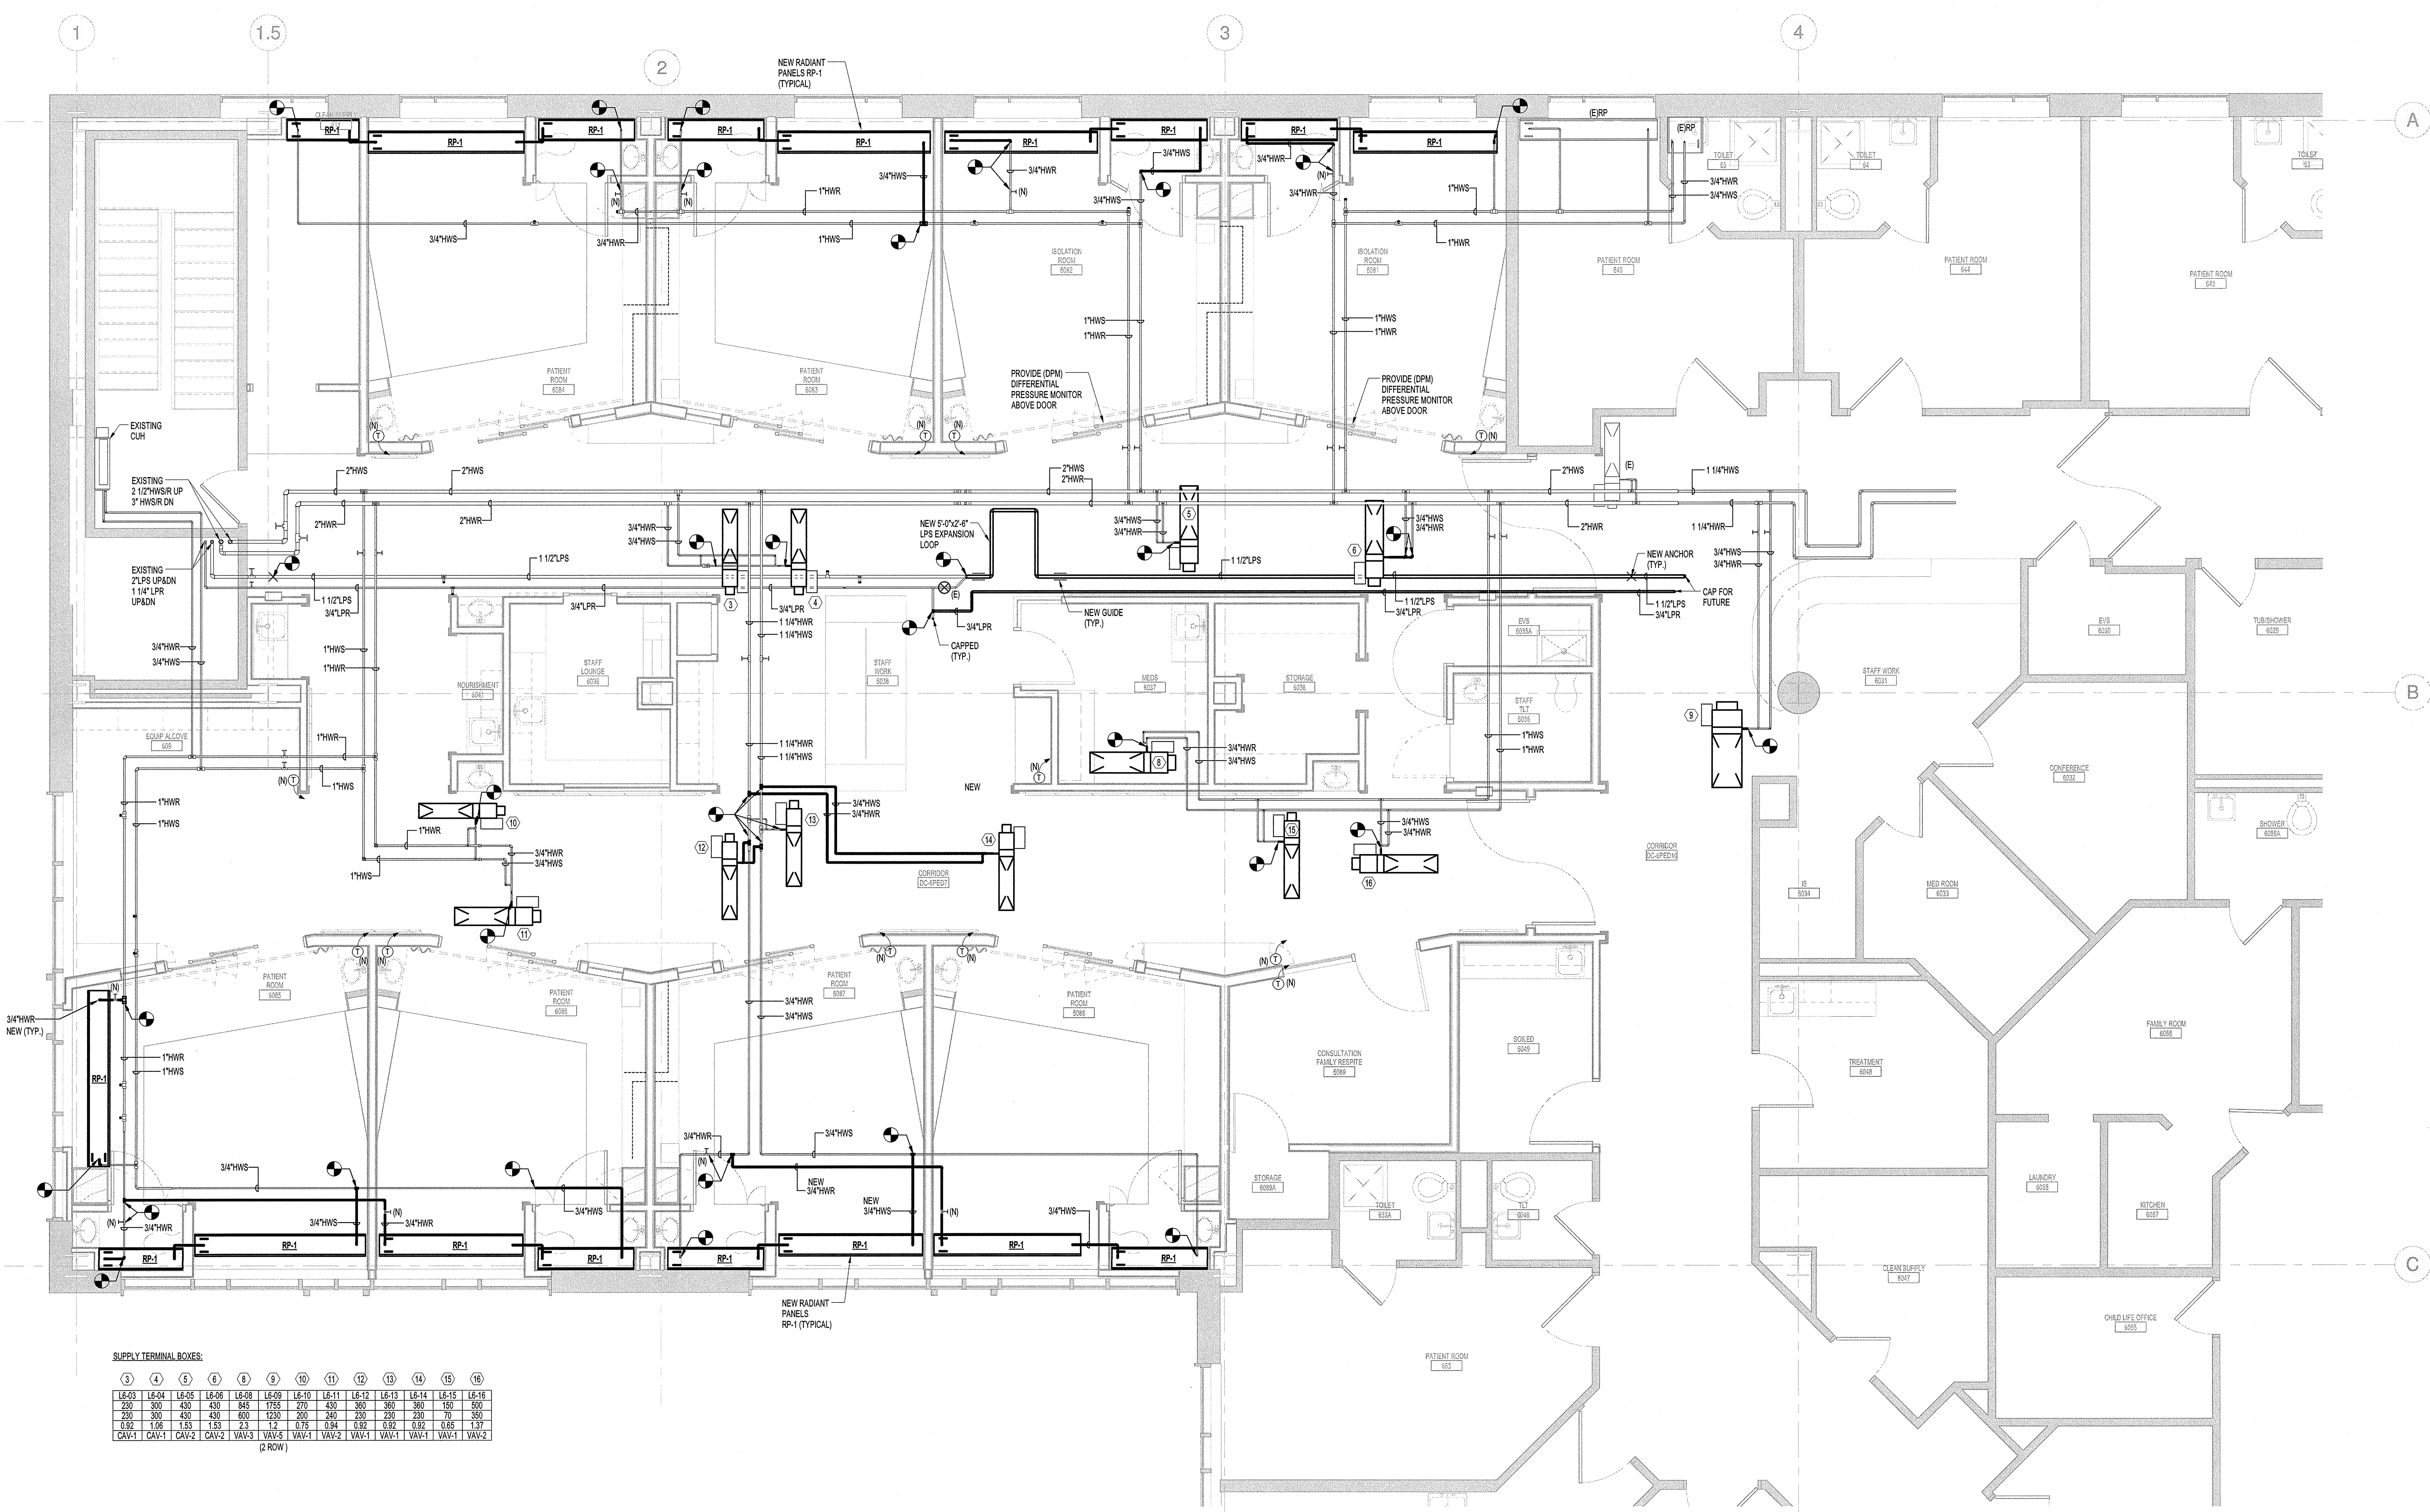

SUPPLY TERMINAL BOXES:

	3	4	5	6	7	8	9	10	11	12	13	14	15	16
L6-03	L6-04	L6-05	L6-06	L6-07	L6-08	L6-09	L6-10	L6-11	L6-12	L6-13	L6-14	L6-15	L6-16	
200	300	400	400	400	400	400	400	400	400	400	400	400	400	400
200	300	400	400	400	400	400	400	400	400	400	400	400	400	400
0.92	1.06	1.33	1.33	1.2	1.2	0.75	0.84	0.82	0.82	0.82	0.82	0.65	1.37	
CAV-1	CAV-1	CAV-2	CAV-2	CAV-2	CAV-2	CAV-1	CAV-1	CAV-1	CAV-1	CAV-1	CAV-1	CAV-1	CAV-2	

(2 ROW)

MECHANICAL PIPING PLAN  
SCALE: 1/4" = 1'-0"