

© 2015 RYAN SENATORE ARCHITECTURE

**PHARMACY RENOVATIONS**  
**MAINE MEDICAL CENTER**  
**PORTLAND, MAINE**



RYAN SENATORE ARCHITECTURE  
 565 CONGRESS STREET  
 PORTLAND, MAINE  
 207-650-6414  
 senatorearchitecture.com

CONSULTANTS:

REVISIONS:

DATE: JULY 7, 2015

PROJECT No. 1509


DRAWN BY:

CHECKED BY: RJS

SCALE: AS NOTED

SHEET TITLE:  
**REFLECTED CEILING PLAN**

**A1-2**

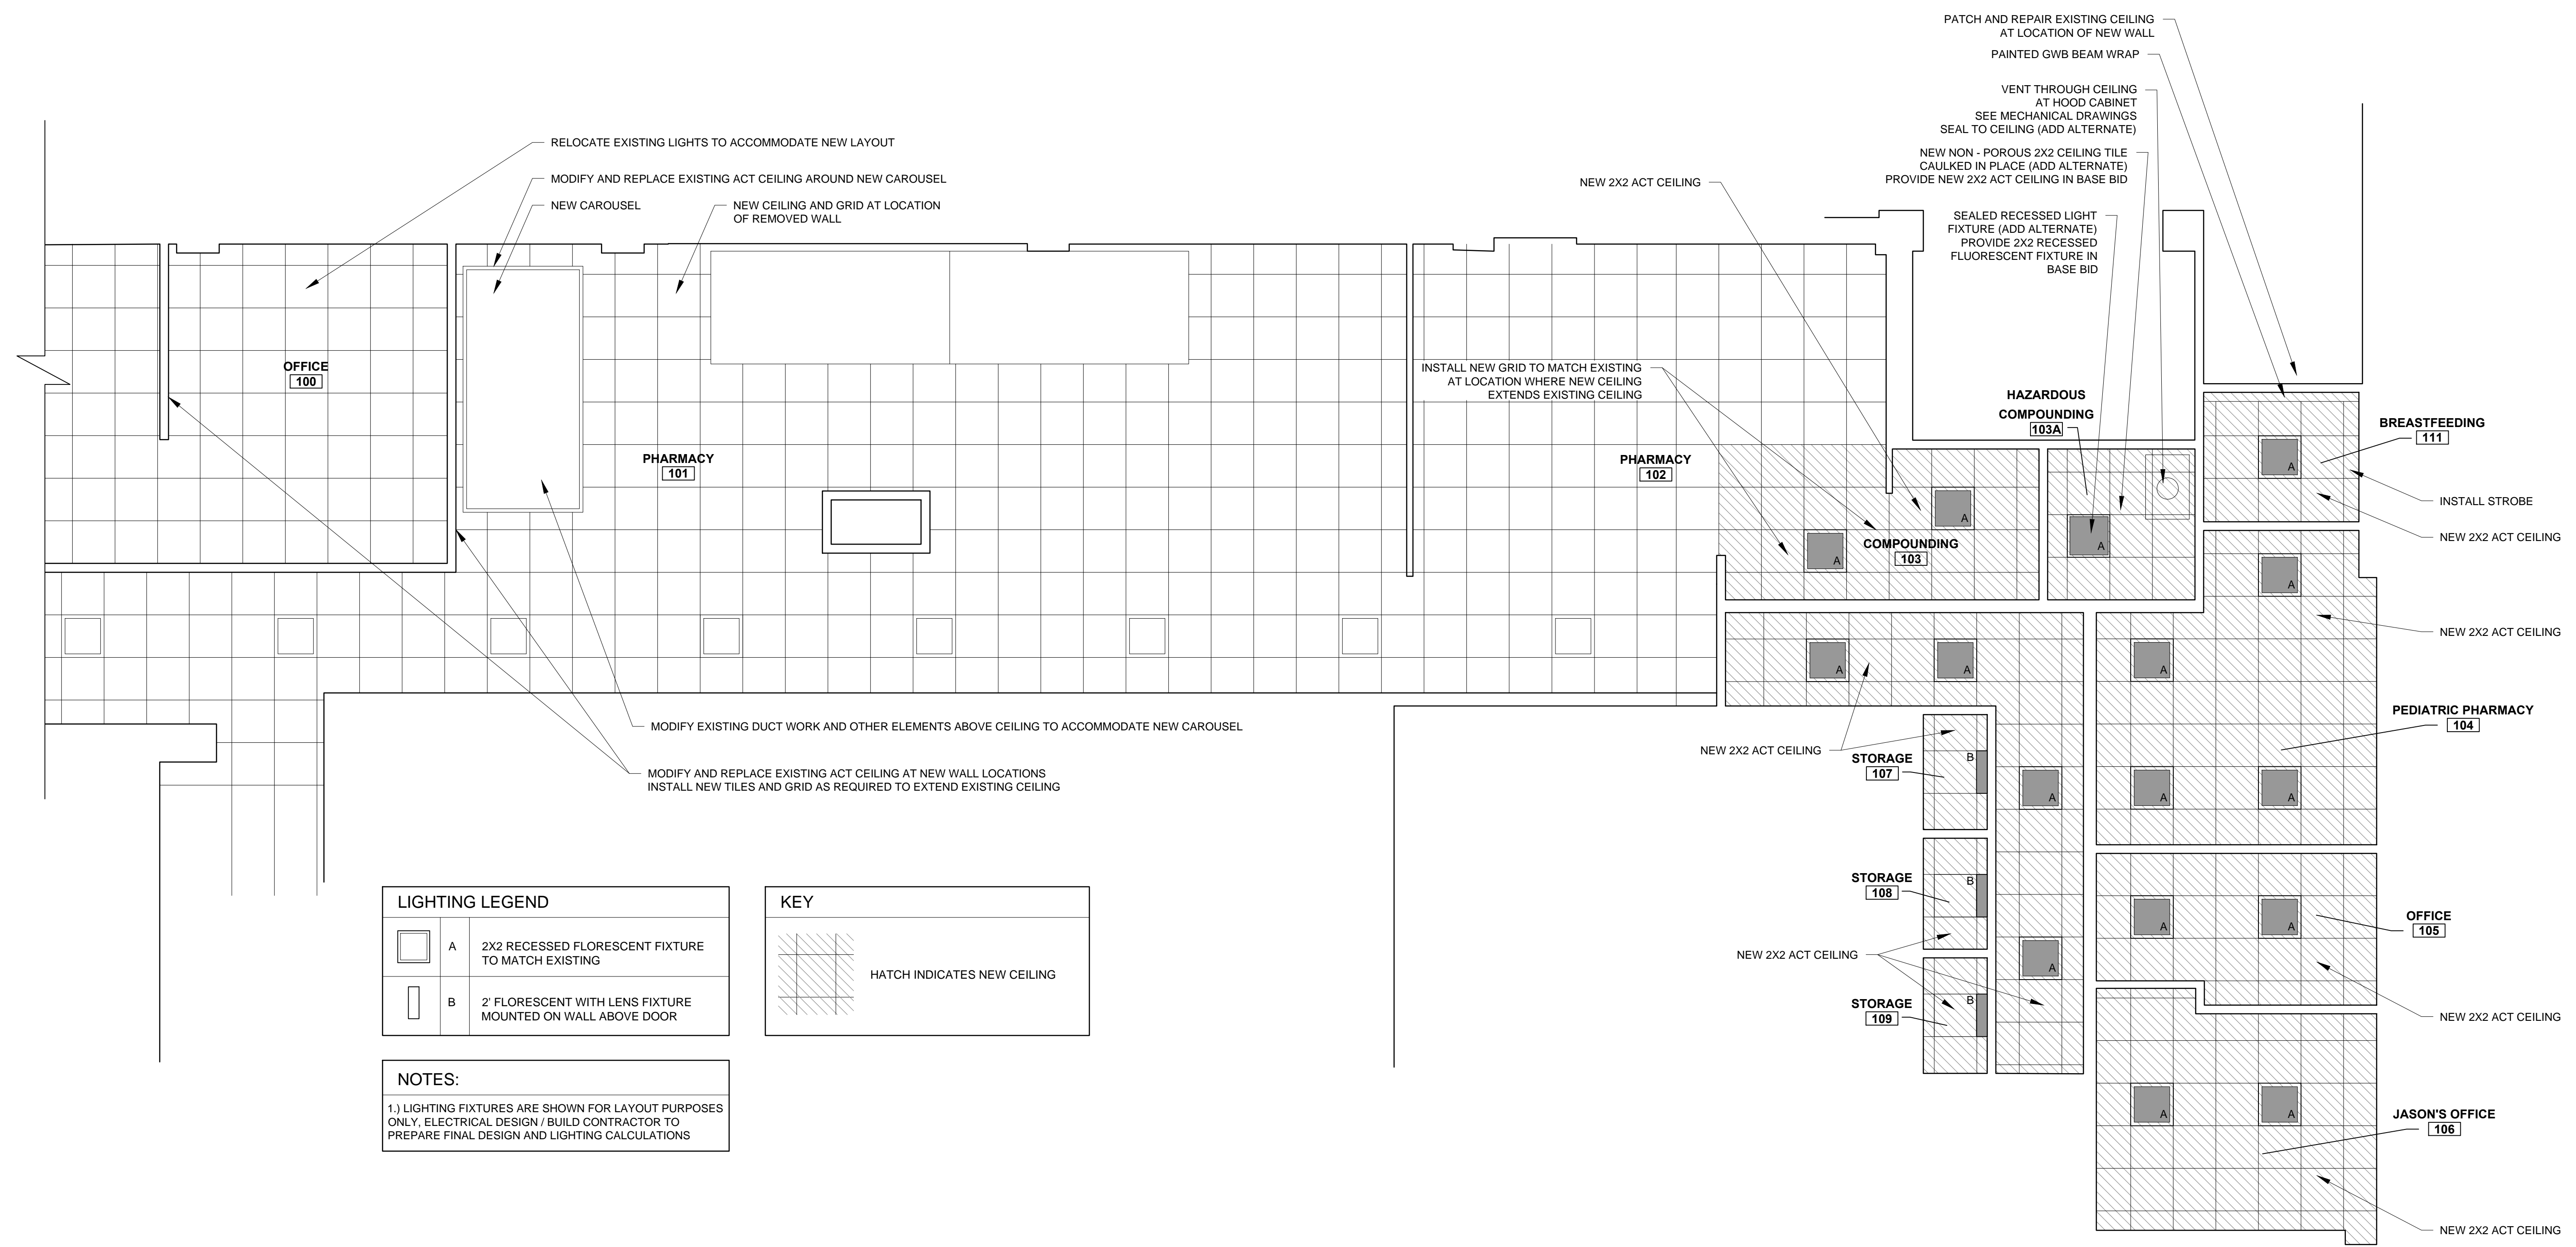

LIGHTING LEGEND		
□	A	2X2 RECESSED FLORESCENT FIXTURE TO MATCH EXISTING
□	B	2' FLORESCENT WITH LENS FIXTURE MOUNTED ON WALL ABOVE DOOR

KEY	
▨	HATCH INDICATES NEW CEILING

**NOTES:**  
 1) LIGHTING FIXTURES ARE SHOWN FOR LAYOUT PURPOSES ONLY. ELECTRICAL DESIGN / BUILD CONTRACTOR TO PREPARE FINAL DESIGN AND LIGHTING CALCULATIONS

**1 REFLECTED CEILING PLAN**  
 1/4" = 1'-0"

