


8/21/2015 1:02:36 PM
C:\Revit Local Files\B150155-000 - MMC NEW HYBRID OR - MEP\4_Central_Location.rvt

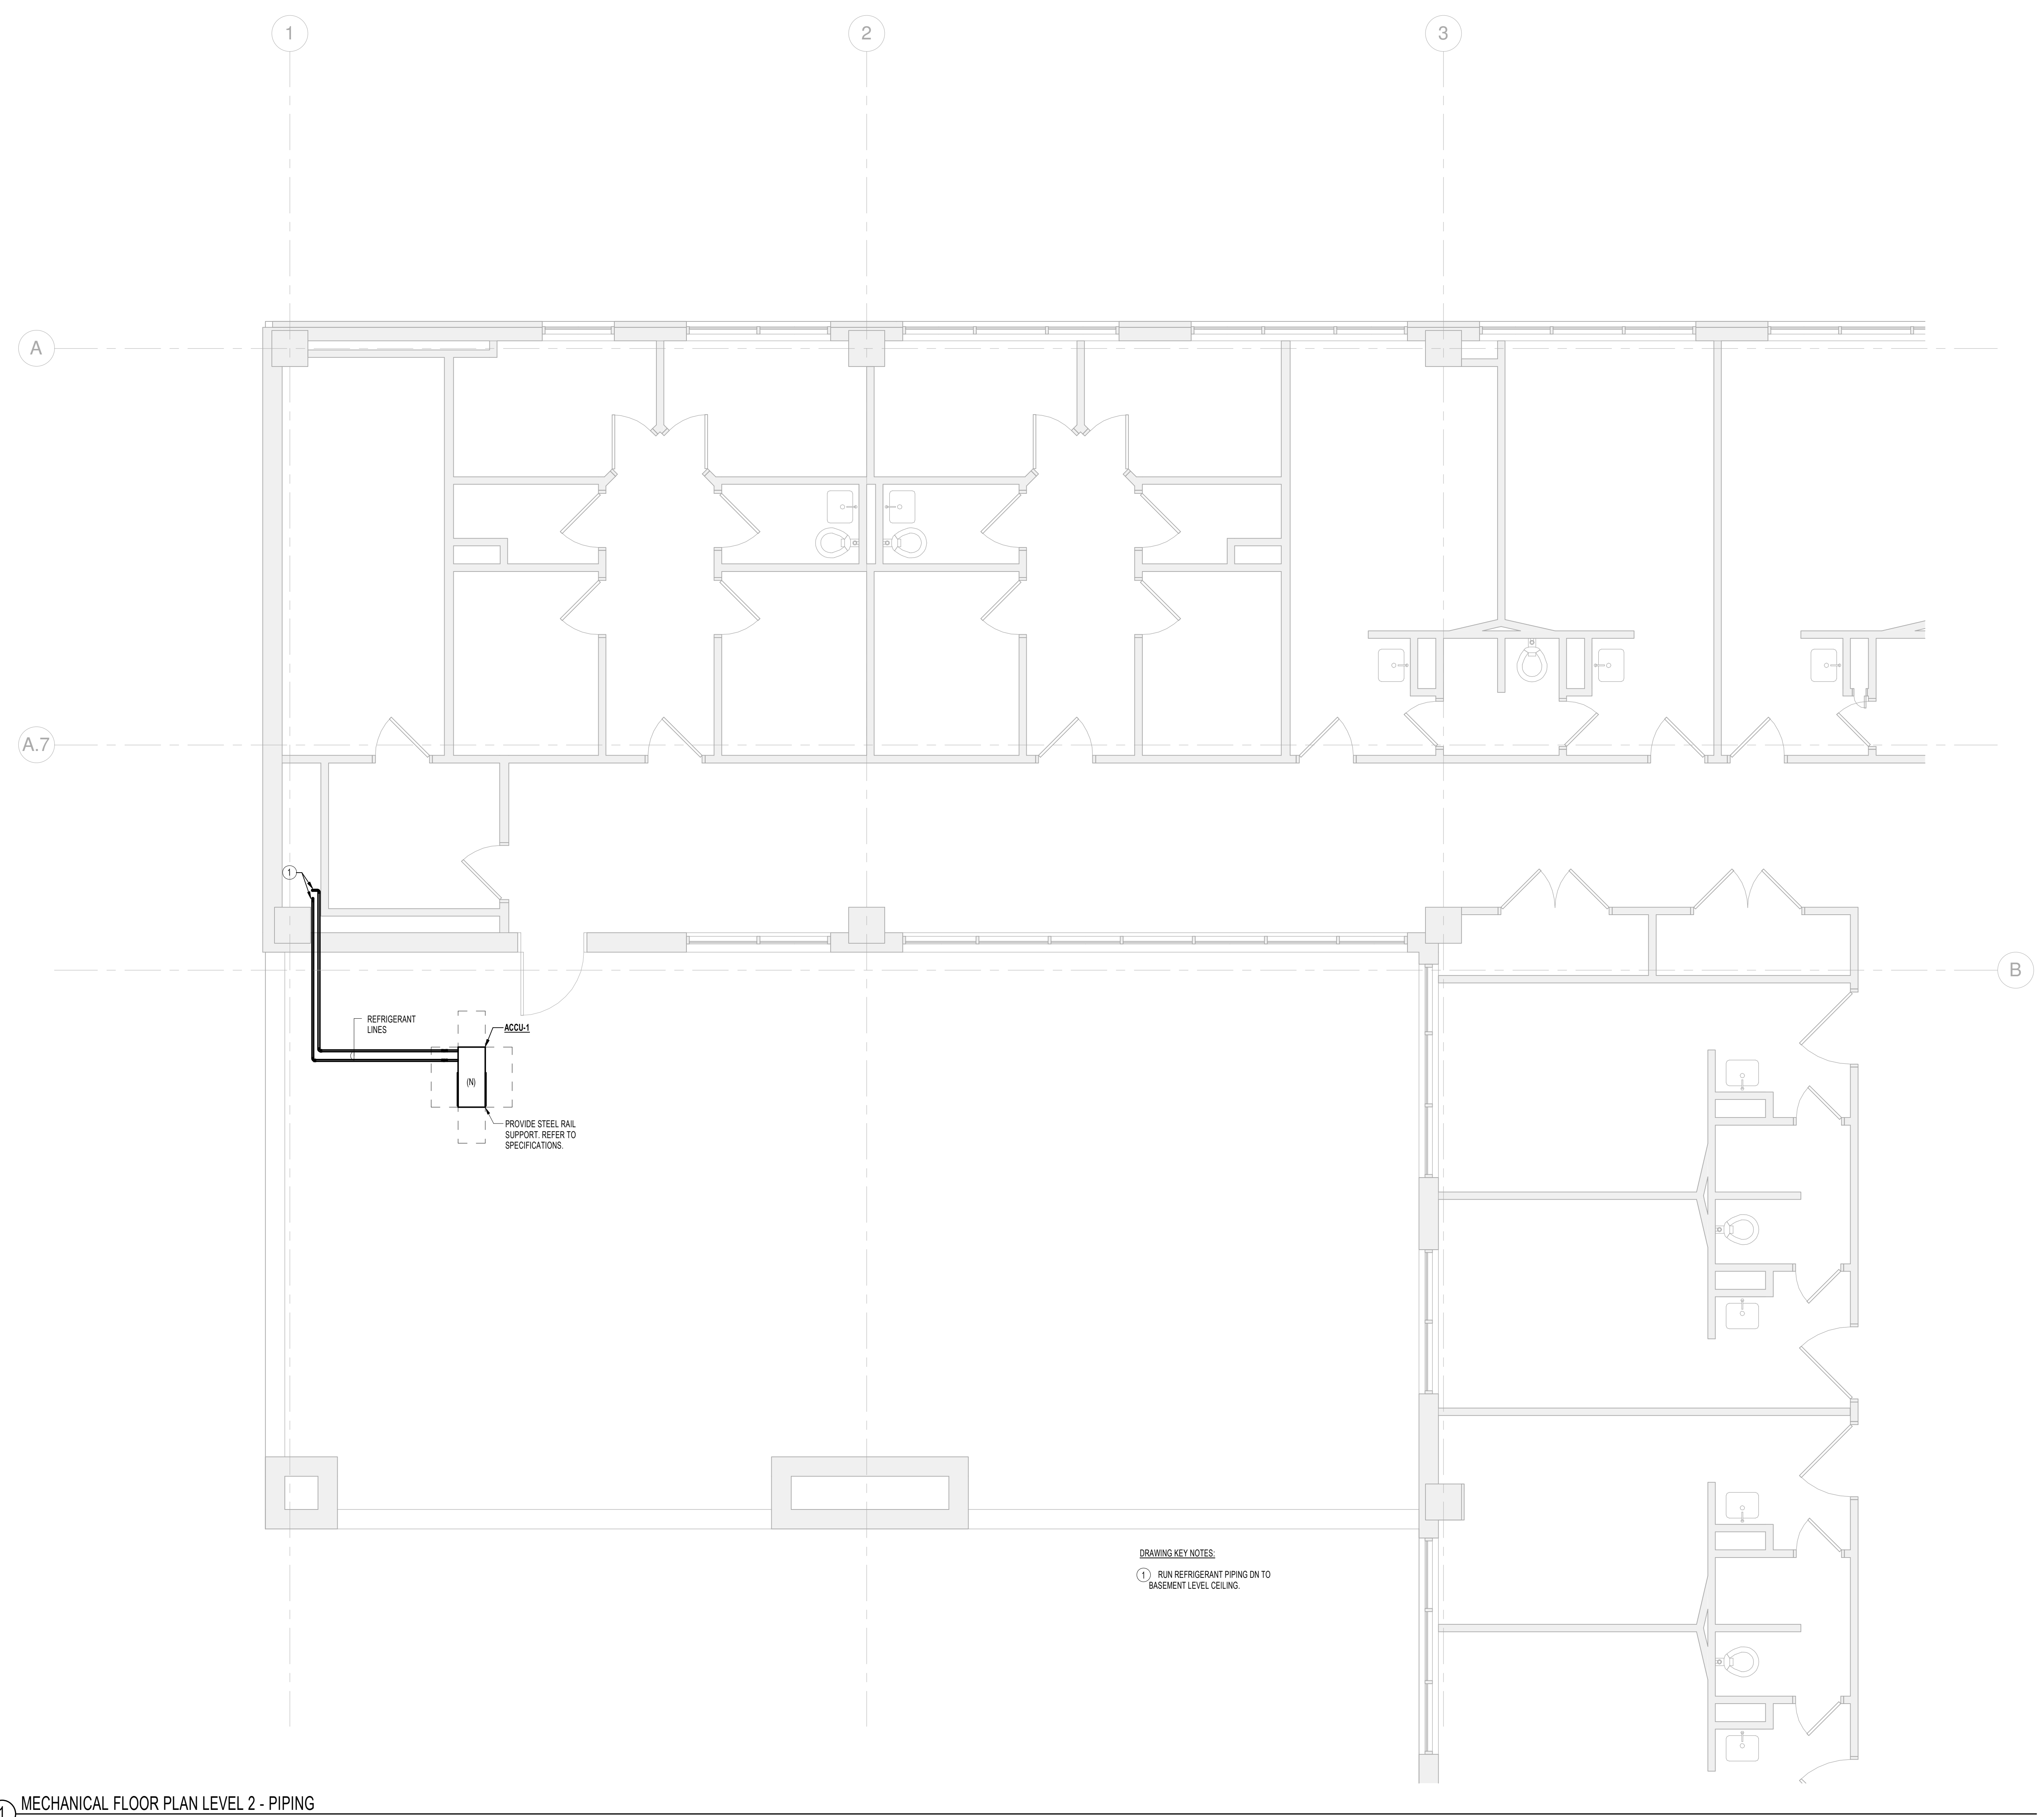

1 MECHANICAL FLOOR PLAN LEVEL 2 - PIPING
SCALE: 1/4" = 1'-0"

DRAWING KEY NOTES:
1 RUN REFRIGERANT PIPING ON TO BASEMENT LEVEL CEILING.

**PERKINS
+ WILL**

225 Franklin St., Suite 1100
Boston, MA 02110
617.478.0300
617.478.0321
www.perkinswill.com





**HYBRID OR &
OR #6**
22 Bramhall Street, Portland,
Maine 04102

MEP ENGINEER
AKF GROUP, LLC

99 Bedford Street, 2nd Floor
Boston, MA 02111
617.737.1111
617.737.4311

STRUCTURAL ENGINEER

SIMPSON GUMPERTZ &
HEGER
41 Seyon Street, Building 1, Suite 500
Waltham, MA 02453
781.907.9000
781.907.9009

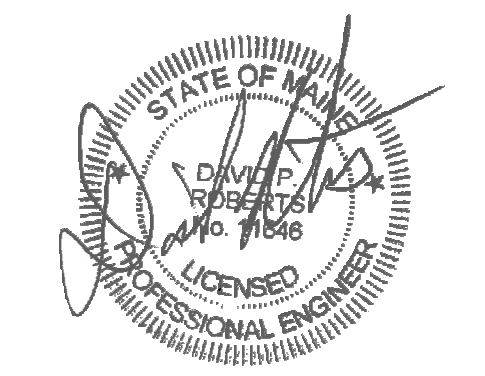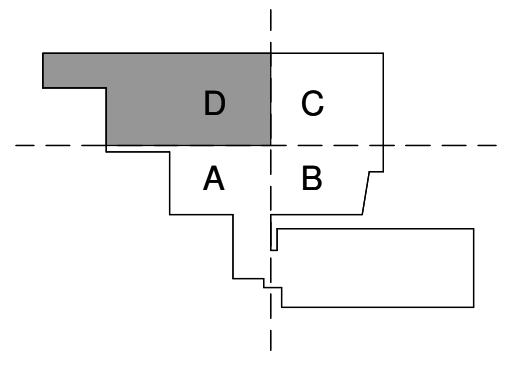

Revisions

ISSUED FOR PERMIT	08.21.2015
1 ADDENDUM 1	08.21.2015
NO	DATE
Sheet Information	
Date	JULY 31, 2015
Job #	B150155-000
Drawn	TU
Checked	DPR
Approved	DPR
Title	

**MECHANICAL
LEVEL 2 PIPING
PLAN**

Sheet

M04-02

