
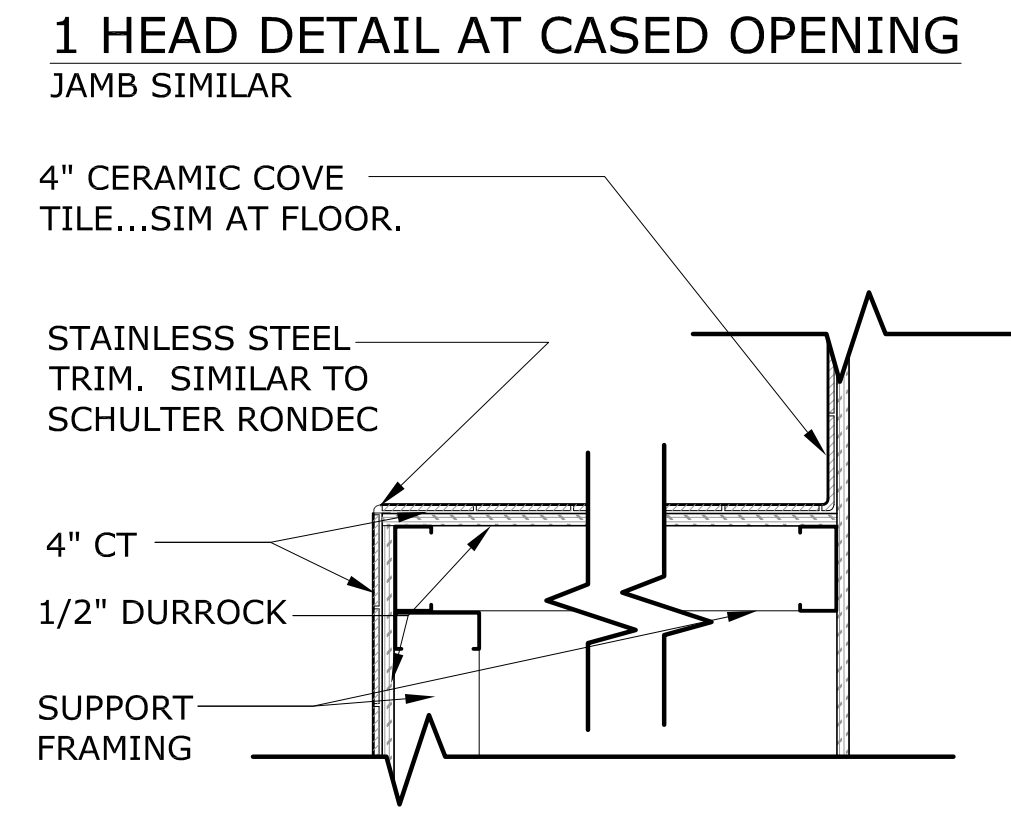
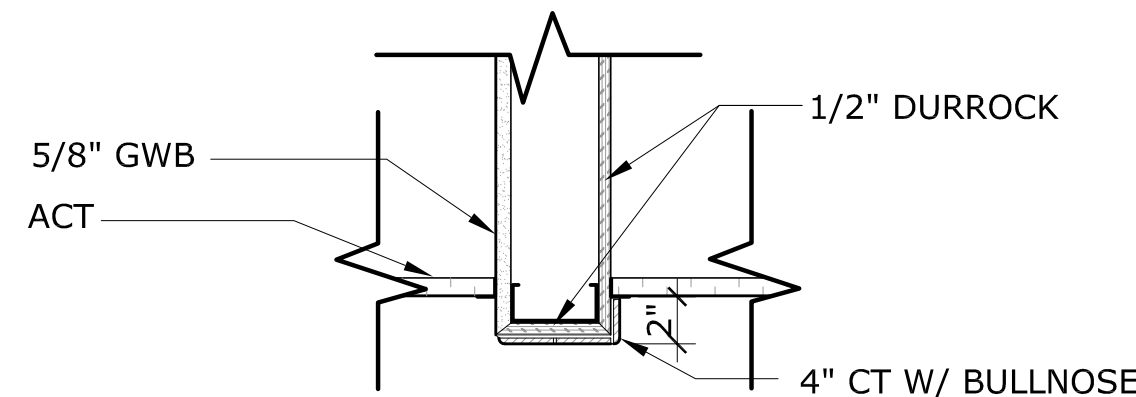
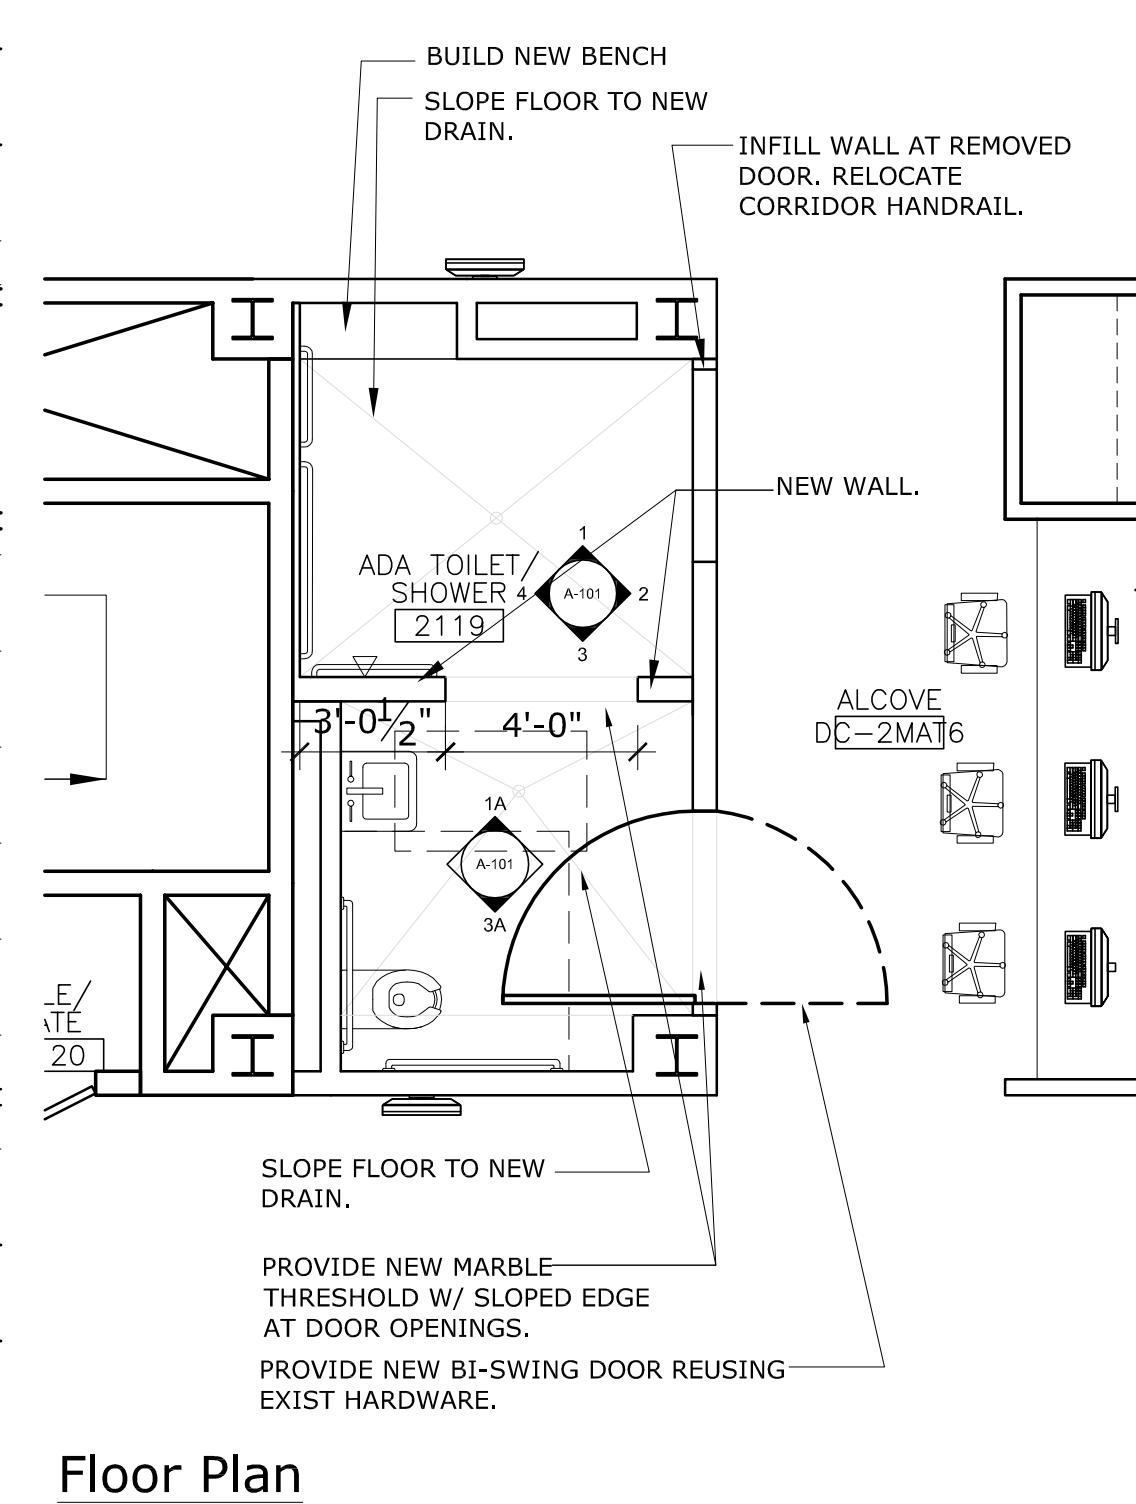
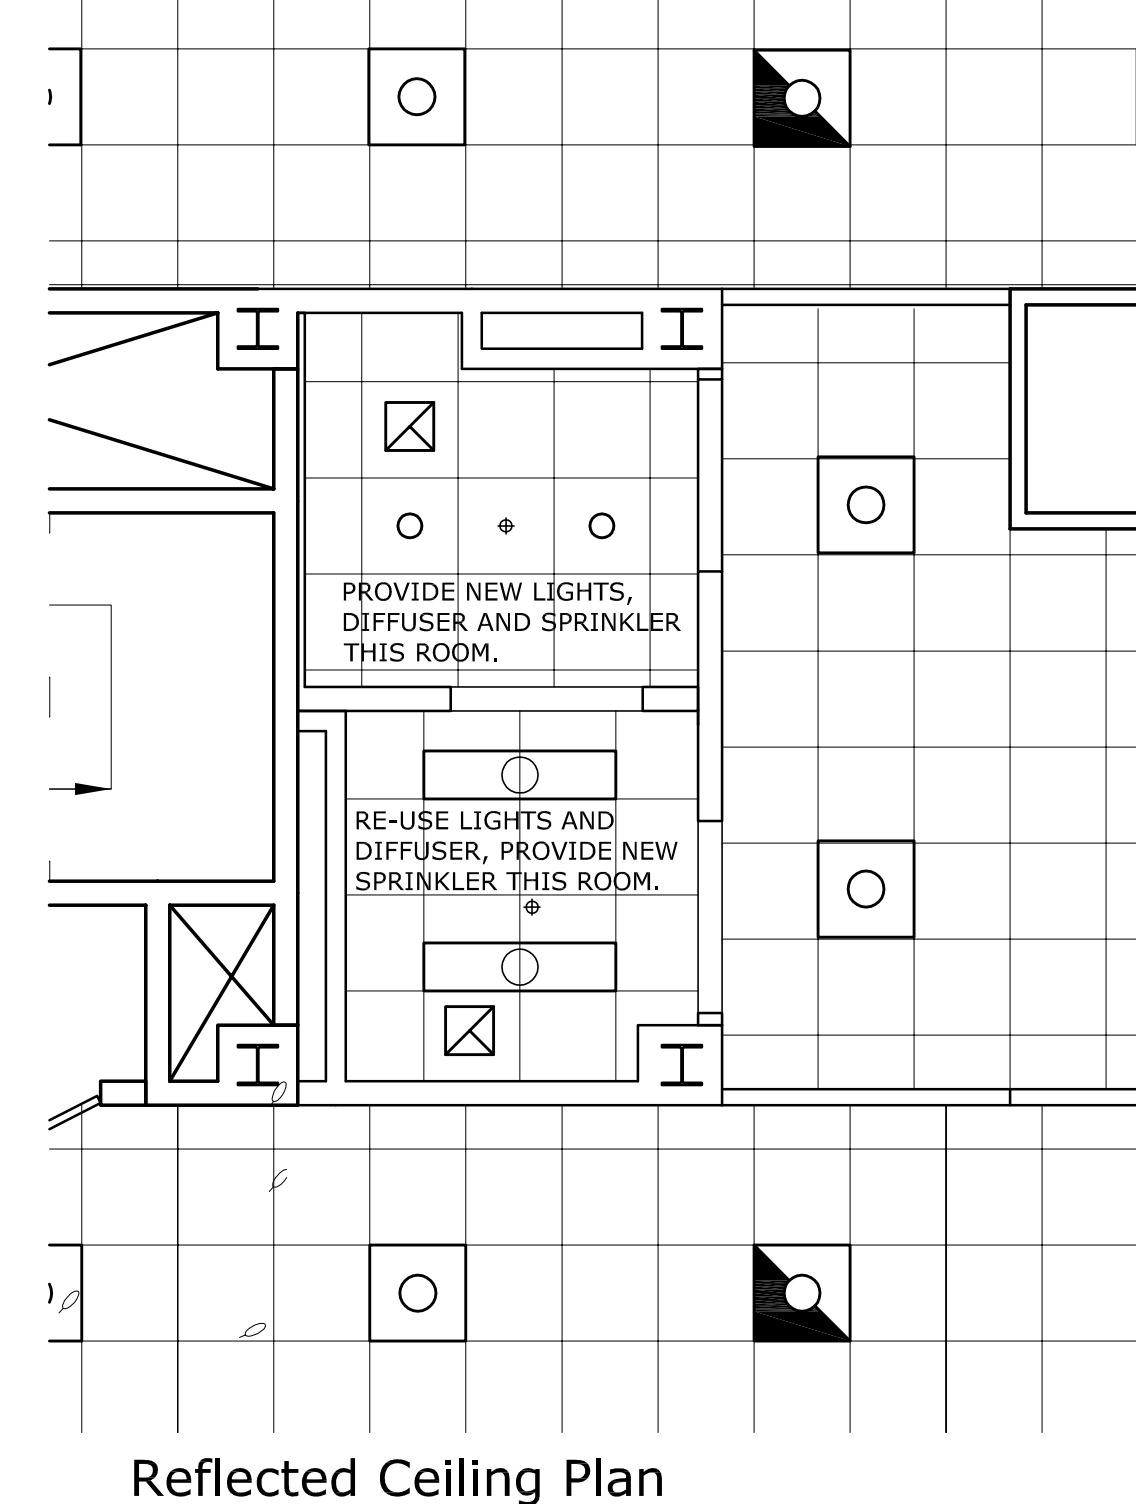
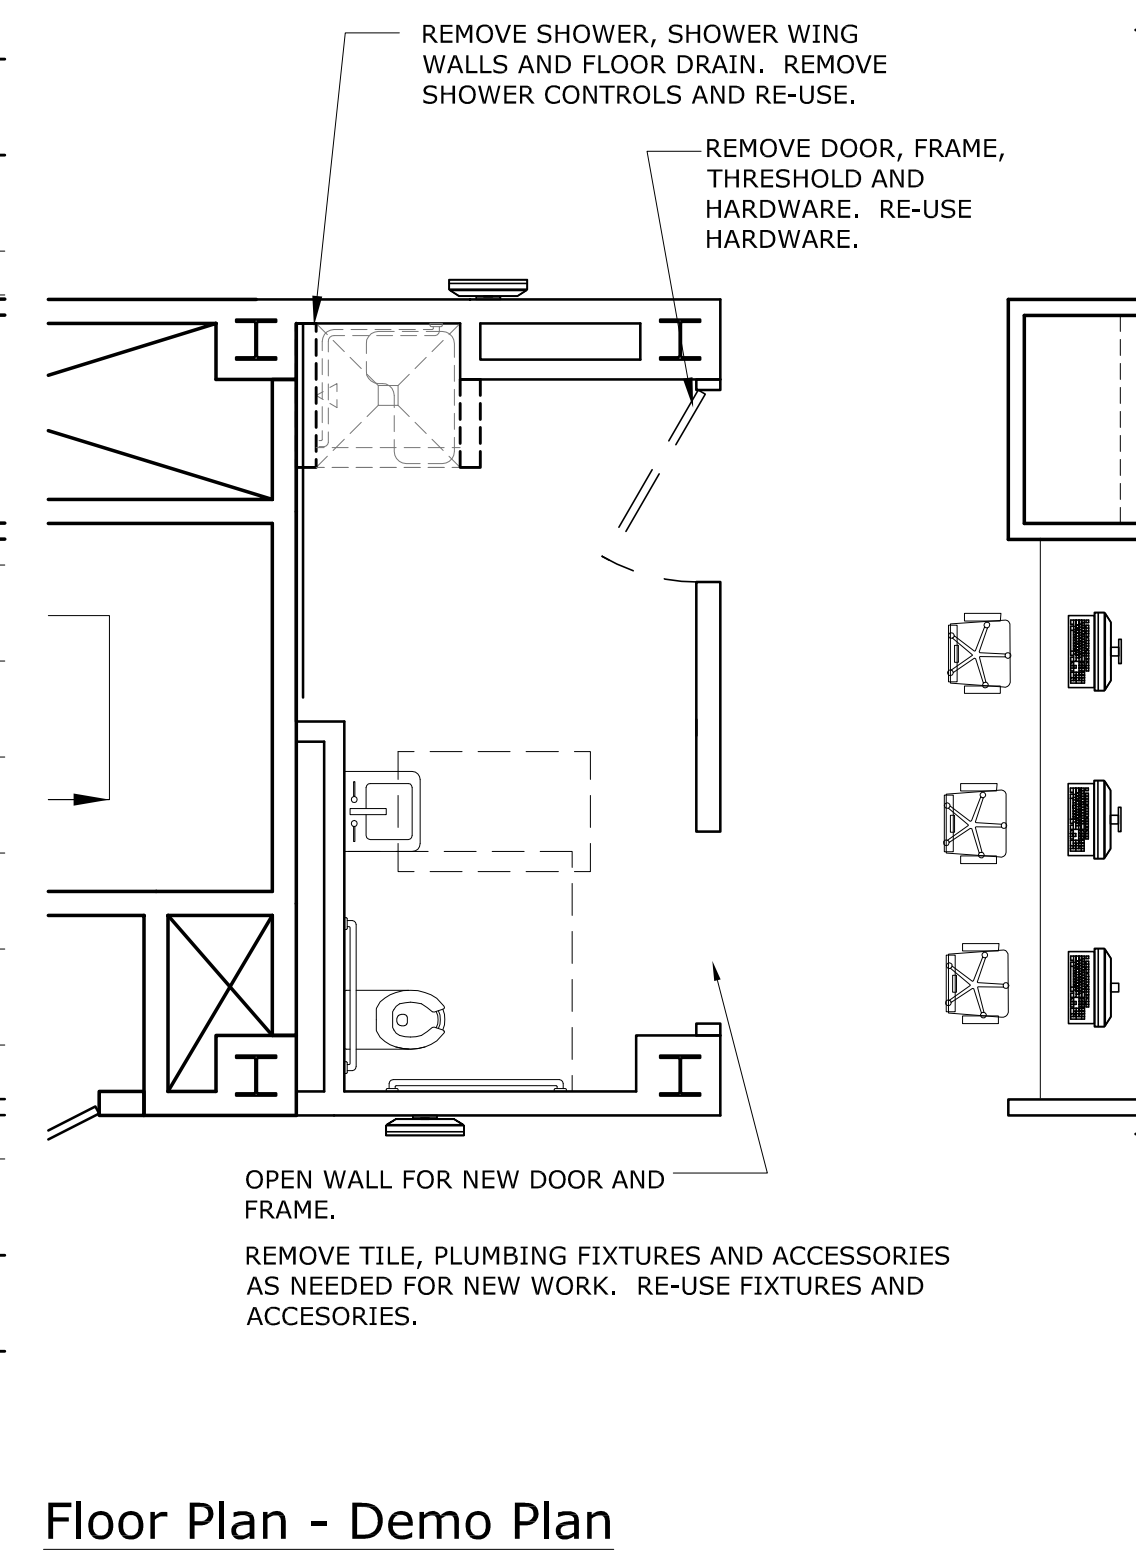
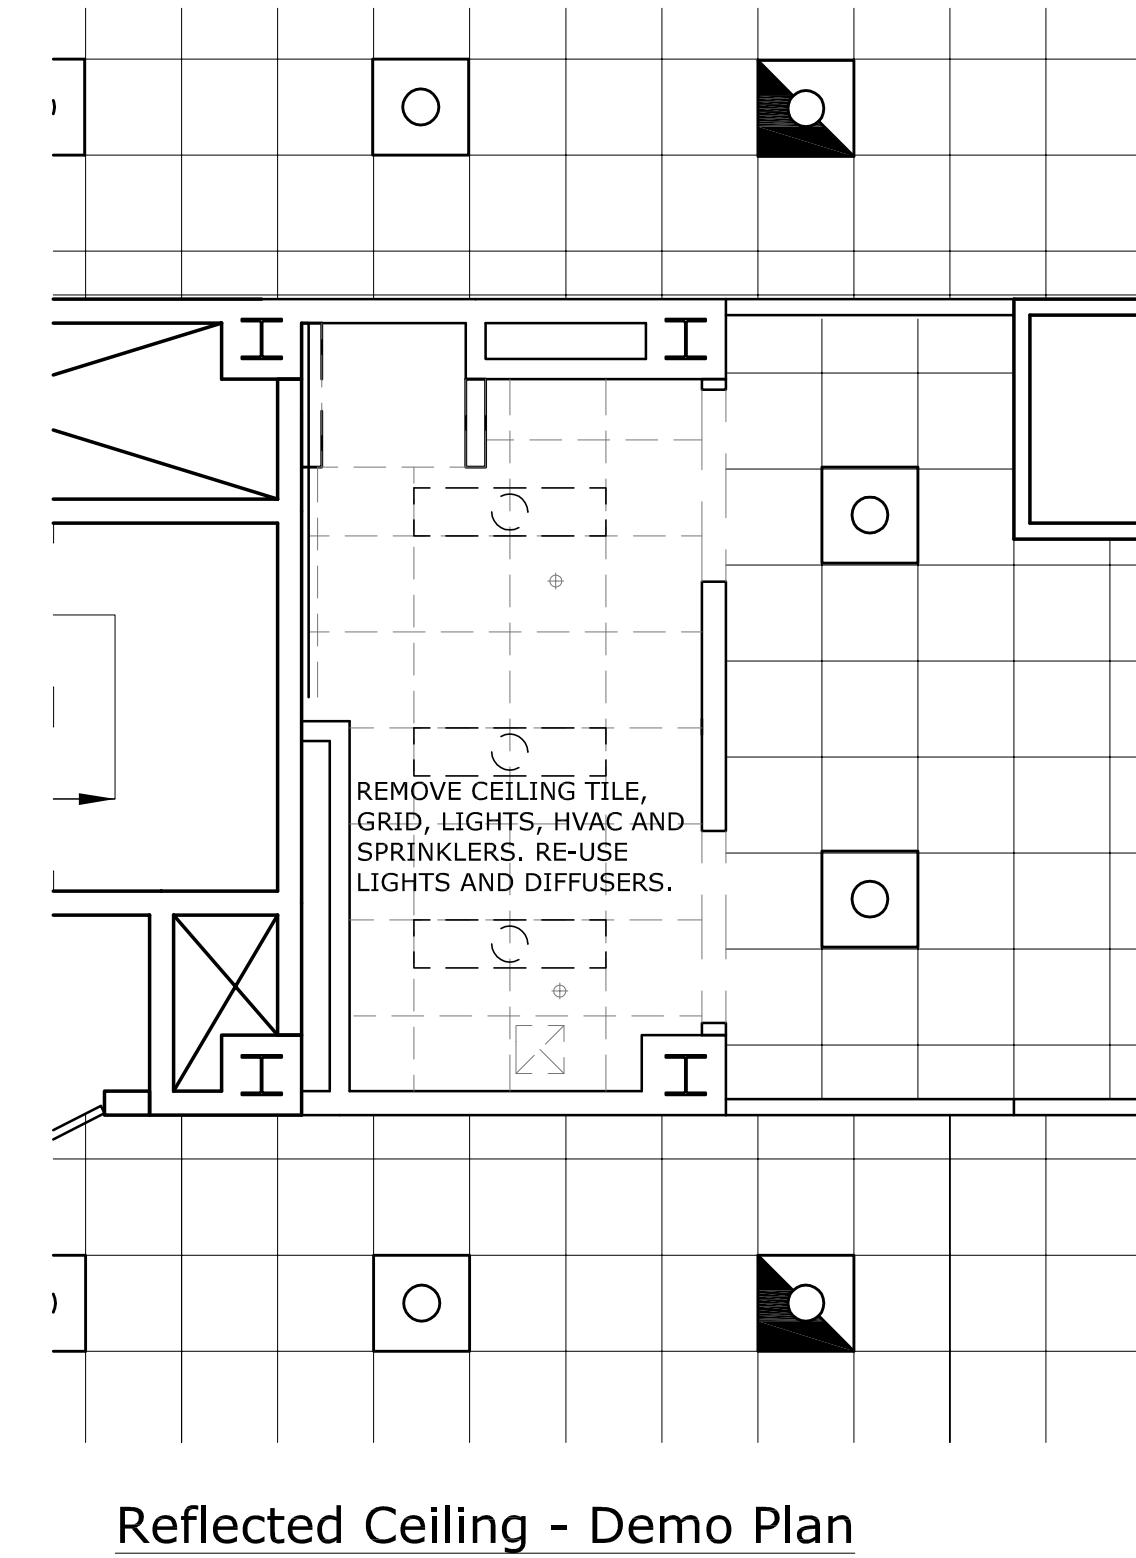
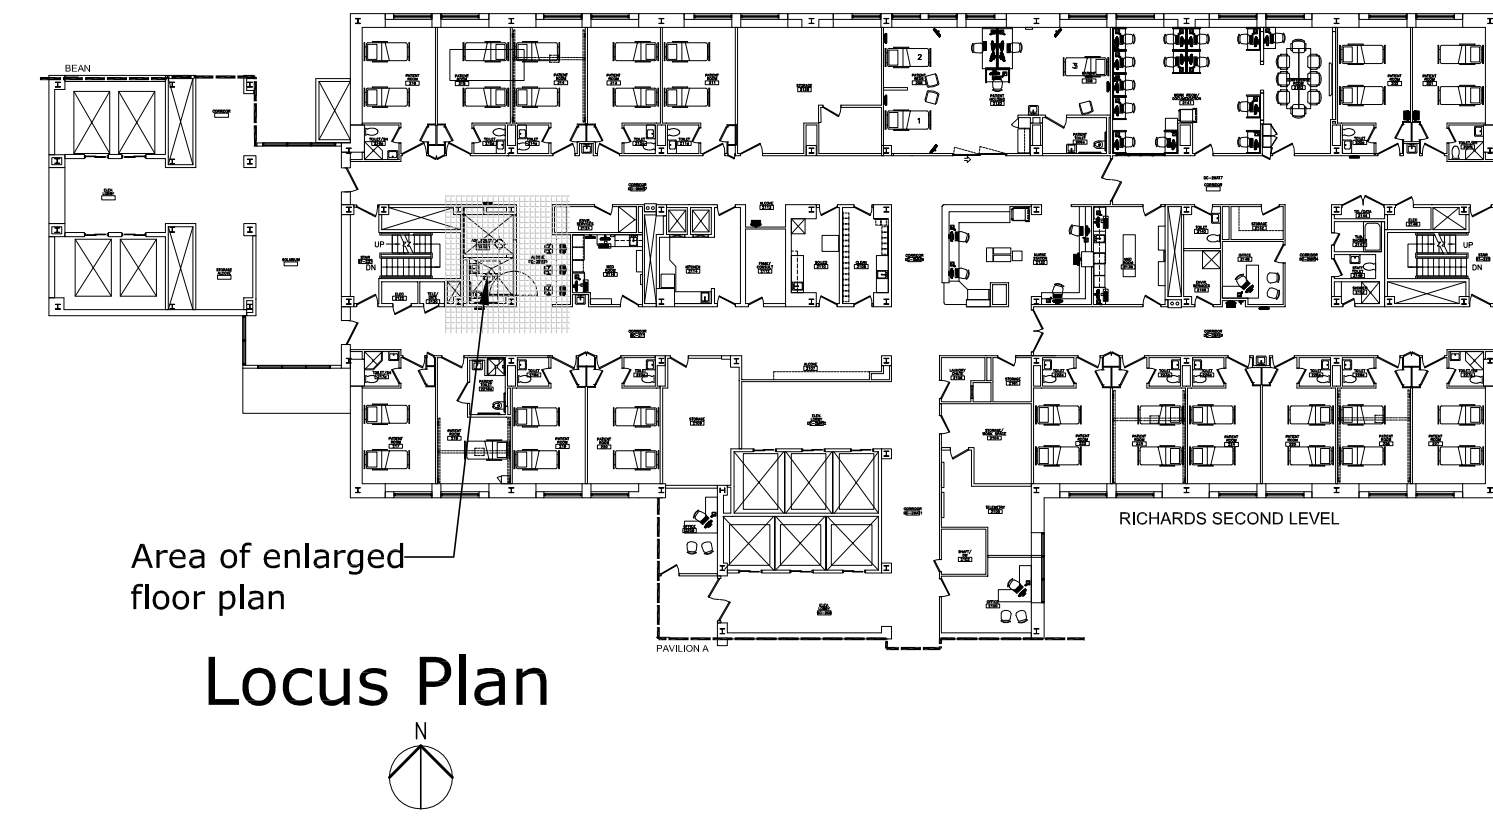
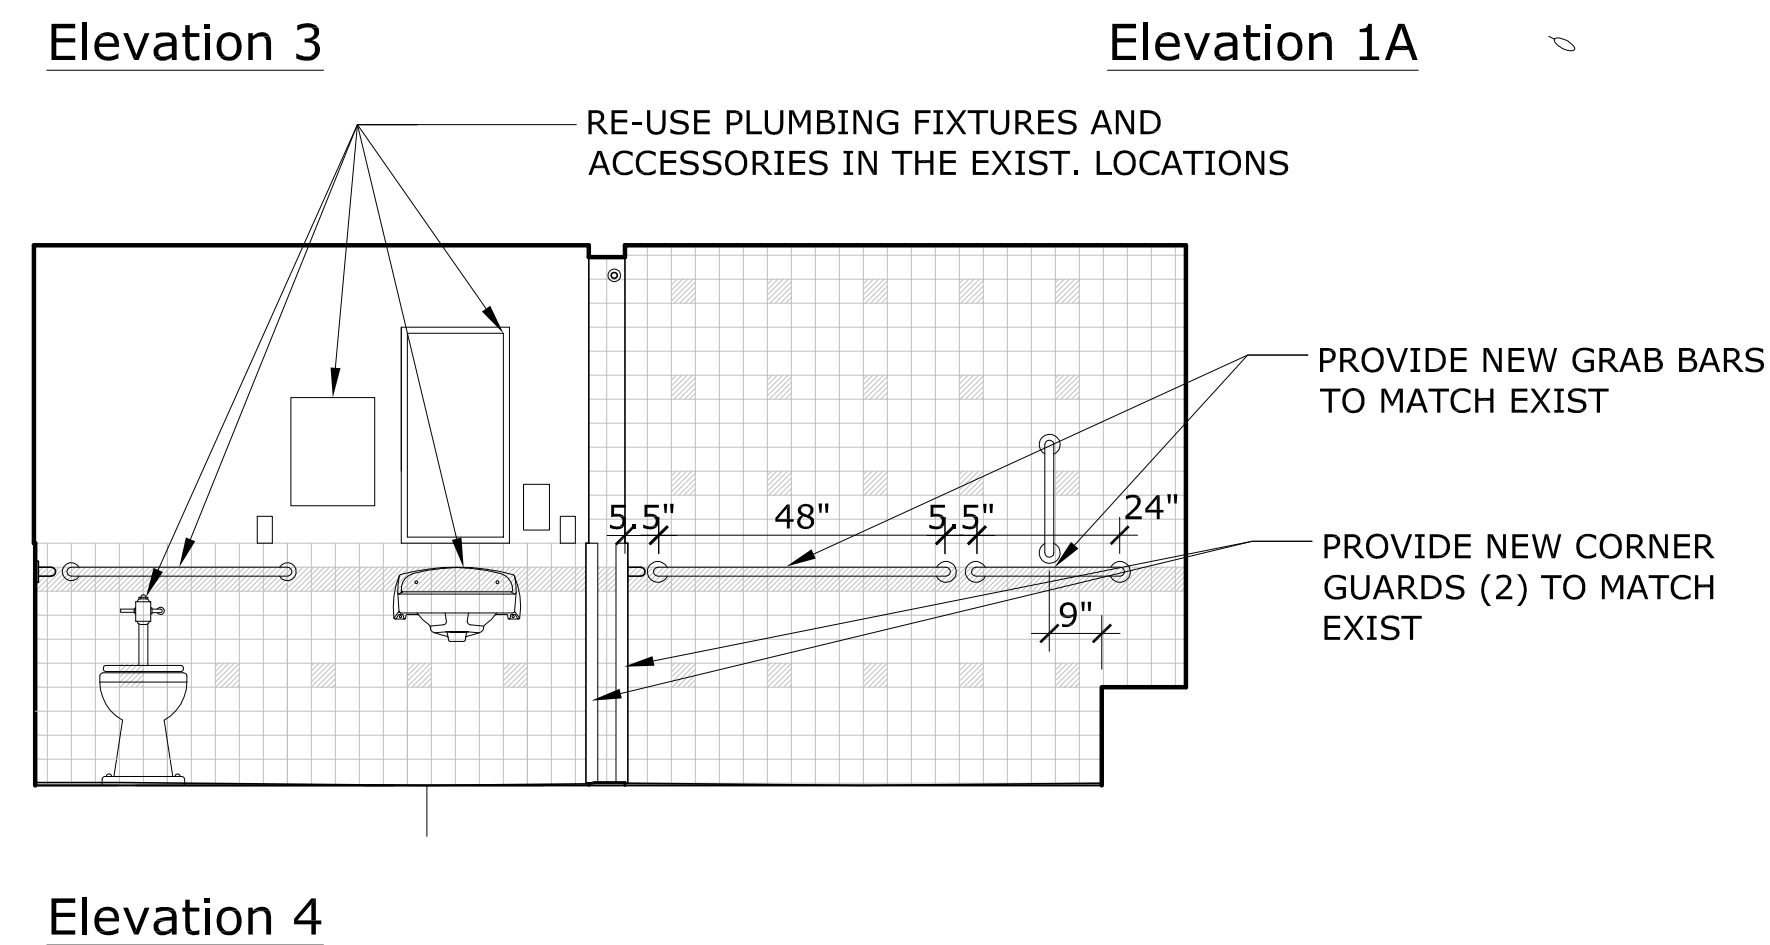
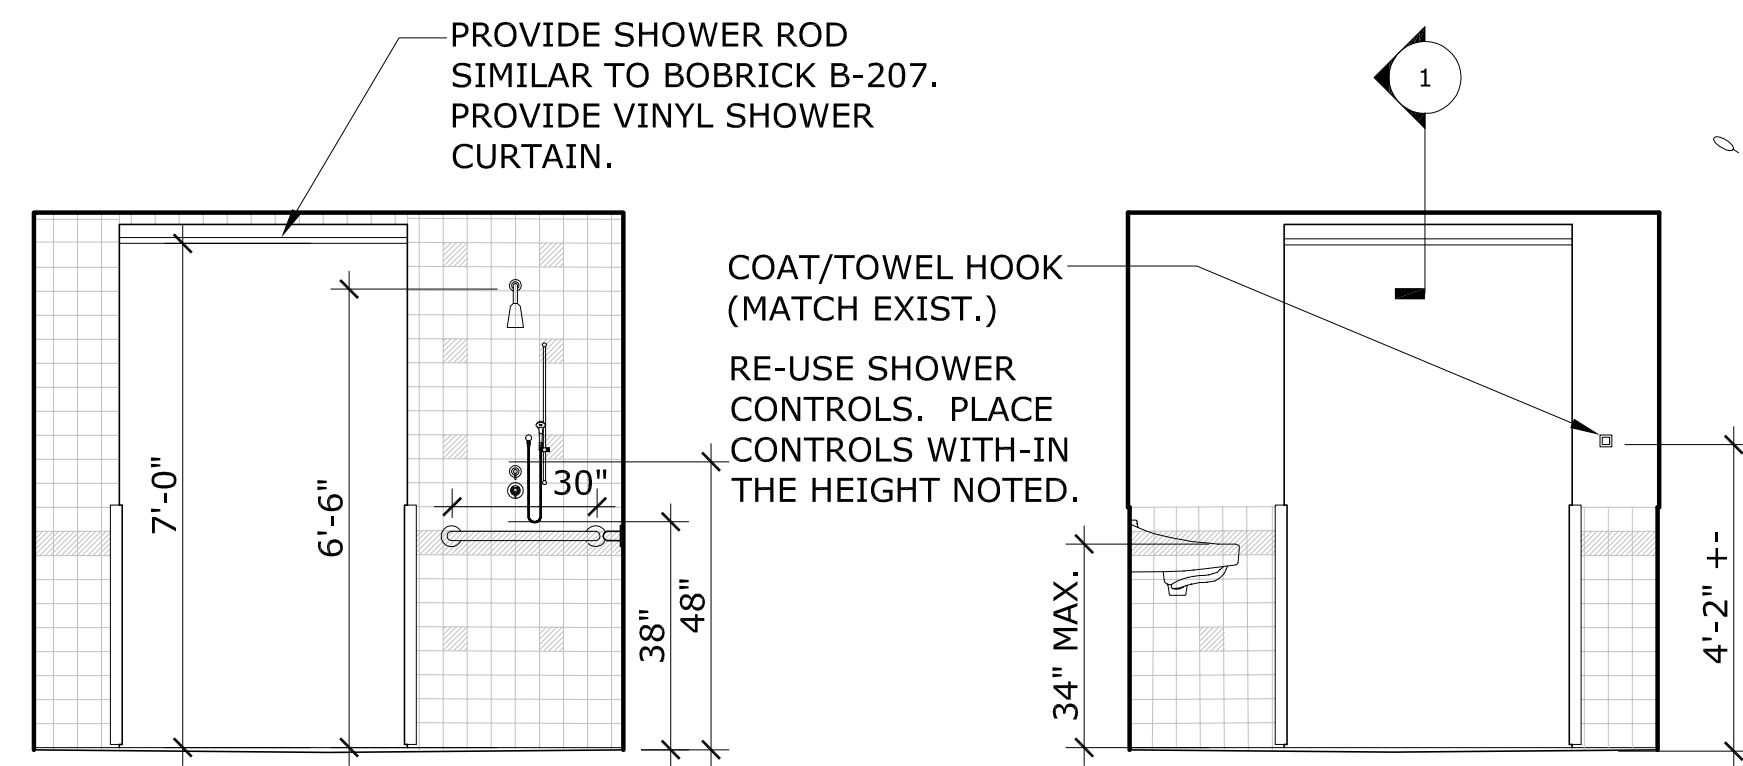
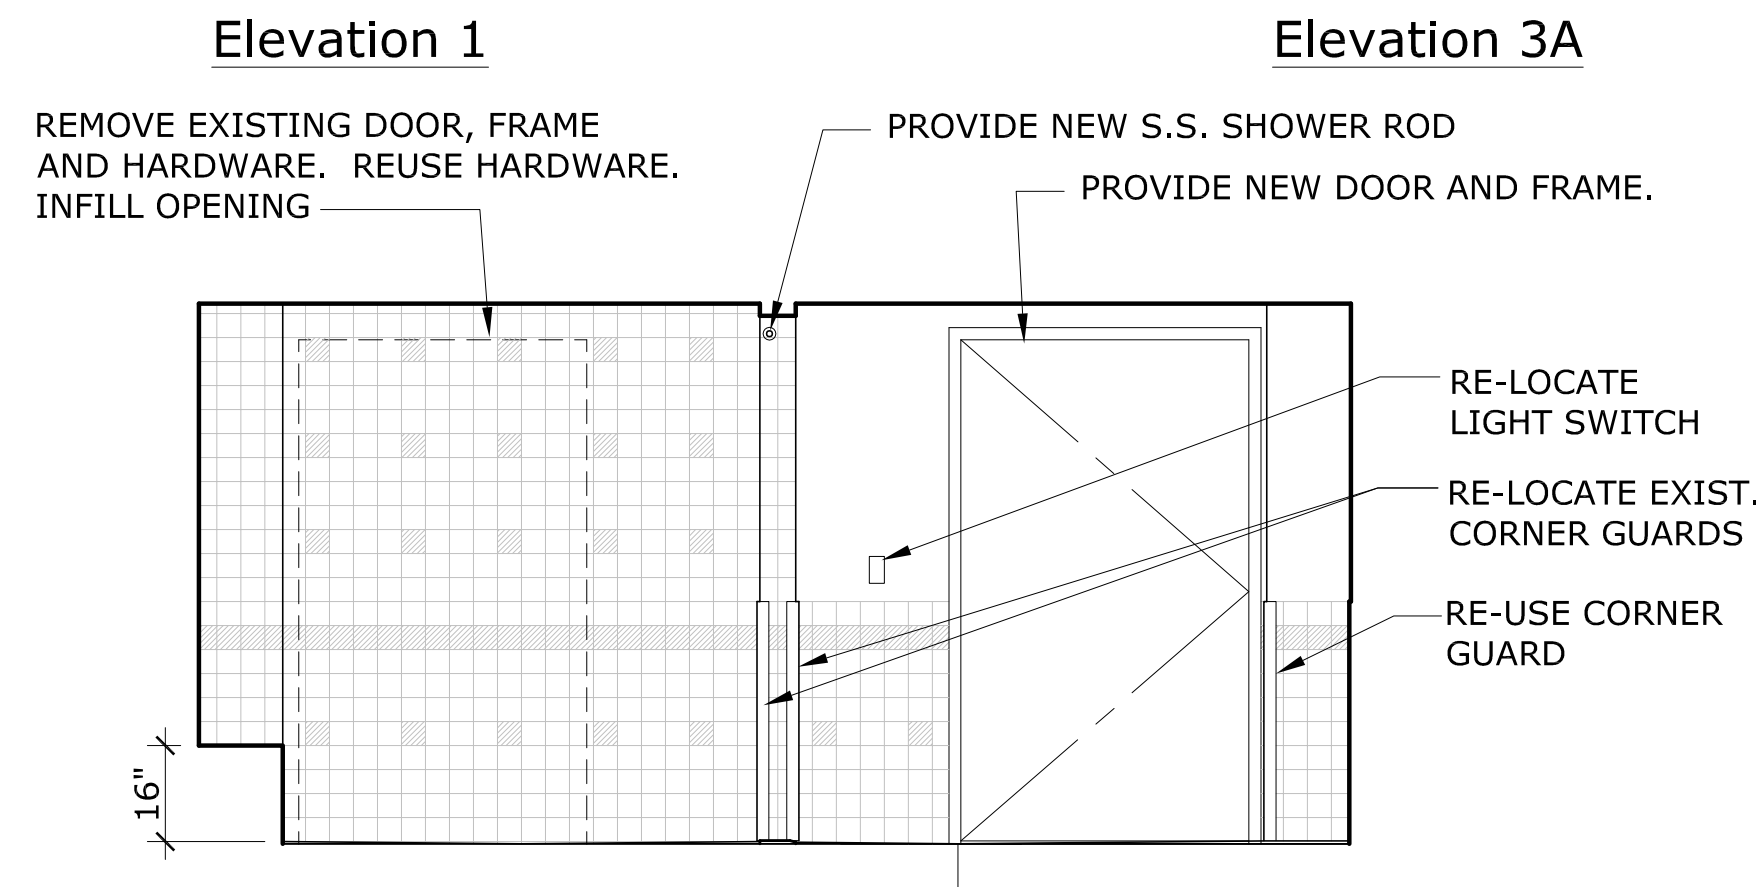


General Notes:

- The intent of these drawing is to give enough information to the tradesperson to provide a complete job.
- The contract is for a complete project. The Contractor and/or Subcontractors shall provide all labor, materials and equipment to perform the work in a complete and craftsman like manner.
- The project shall be performed following the MMC Standards for Construction.
- Dust protection shall be provided for the full term of the project to prevent any dust or debris from getting out of the work area.
- Patch and match floor and base at removals in corridor.
- Floor tile shall be 2"x2" similar to existing tile.
- Wall tile shall be 4"x4" tile similar to existing. Cove base shall be used at vertical to horizontal intersections. Bull nose shall be used to finish top of walls. Consult Architect for use of inside corner cove trim.
- Ceiling grid to be 3/4" width white aluminum. Ceiling tile to be Armstrong Cermaguard.
- Re-use plumbing fixtures, handrails and accessories. Where additional are needed, match existing.
- Provide self priming floor trap for toilet room area. Provide bariatric adapter for toilet. Verify products with MMC Mechanical shop.
- Repair ceilings in spaces on R1 where work is being done to provide floor drains for R2.
- Repair or replace poured in place floor waterproofing system.
- New can lights in shower area to be Halo H750ICAT-ML5609835-691WB, or Owner approved alternate.
- New door to be 4070 Maiman thermo fused door and Pemko double acting swing hinge with emergency stop/release.

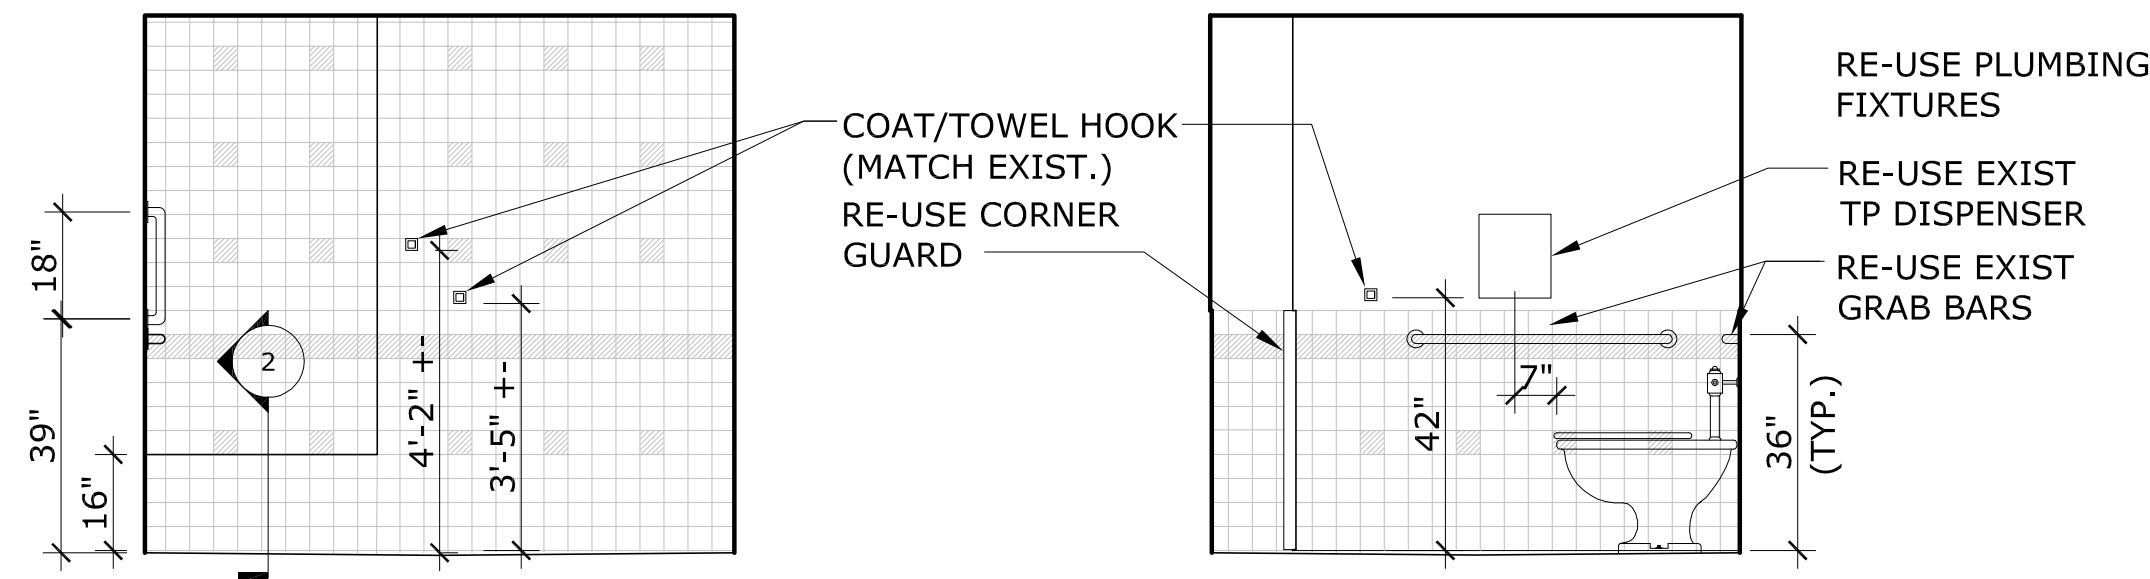

DETAILS
 SCALE 1 1/2" = 1'-0"

INTERIOR ELEVATIONS
 SCALE 3/8" = 1'-0"

Plans
 SCALE 1/4" = 1'-0"

RS Facilities Design Services LLC
 1 Marjorie Way
 Eliot, ME 03903
 207-450-5755

CONSULTANTS

**Maine Medical Center
 R2 Shower
 Renovation**

**Richards Building
 Second Floor
 22 Bramhall St.
 Portland, ME**

MARK	DATE	DESCRIPTION
ISSUE:	8/3/15 FOR PRICING	
PROJECT NO:	C1400154988	
CAD DWG FILE:	N/A	
DRAWN BY:	RJS	
CHECKED BY:	N/A	

SHEET TITLE
**PLANS, ELEVATIONS,
 DETAILS AND NOTES**

A101
 Sheet 1 of 1