


**DRAWING NOTES:**  
 1. REFER TO DRAWING E-000 FOR LEGEND, SYMBOLS, ABBREVIATIONS AND ADDITIONAL GENERAL NOTES.



225 Franklin Street, Suite 1100  
 Boston, MA 02110  
 617.476.0300  
 617.476.0321  
 www.perkinswill.com

**CONSULTANTS**

**AKF Group, LLC**  
 99 Bedford Street, 2nd Floor  
 Boston, MA 02111  
 617.737.1111  
 617.737.4311

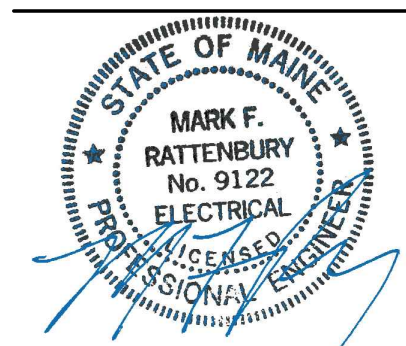


**PROJECT**

**MMC Cath Lab 4**  
 22 Bramhall Street  
 Portland, ME 04102



**Maine Medical Center**  
 22 Bramhall Street  
 Portland, ME 04102

**KEYPLAN**

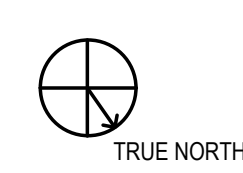


**ISSUE FOR BID**  
 01/15/2016  
**ISSUE CHART**


NO	ISSUE	DATE
Job Number	B150268-000	
Checked	MFR	
Approved	MFR	

**TITLE**  
**ELECTRICAL**  
**8TH FLOOR**  
**LIGHTING & POWER**  
**DEMOLITION PLANS**  
**SHEET NUMBER**

**E-100**

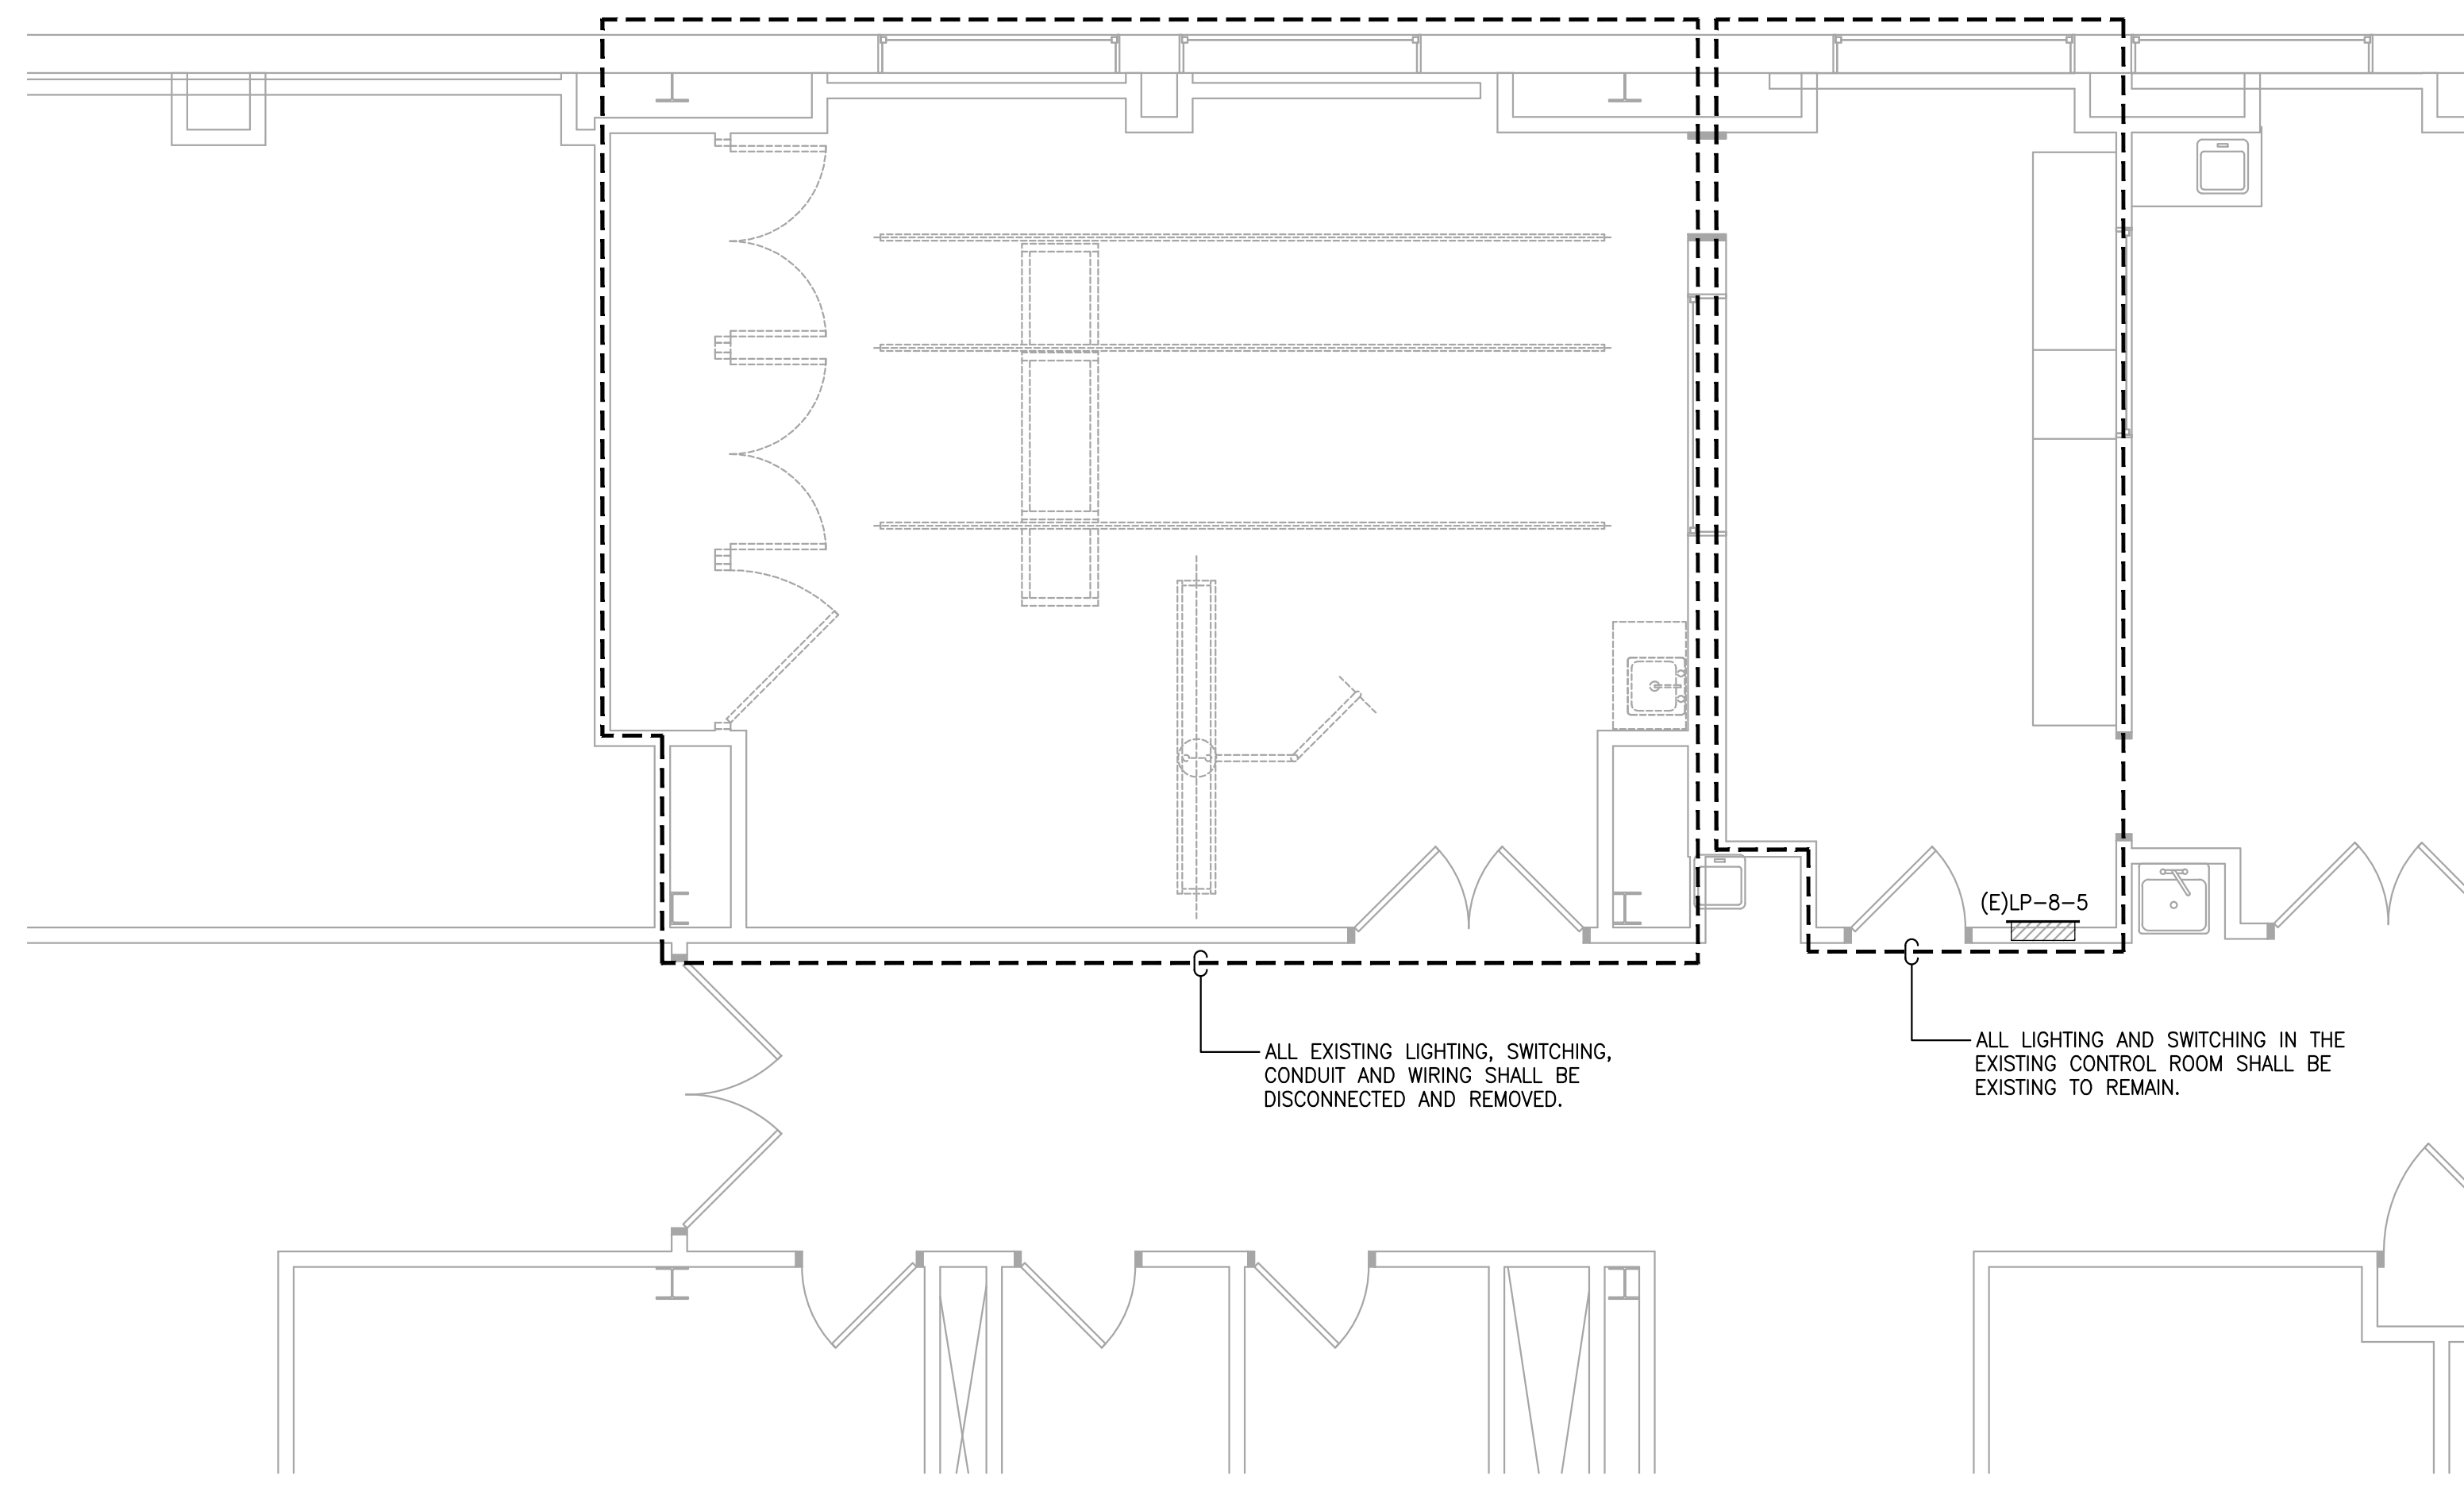

**1 DEMOLITION 8TH FLOOR LIGHTING PLAN**  
 SCALE: 1/4"=1'-0"

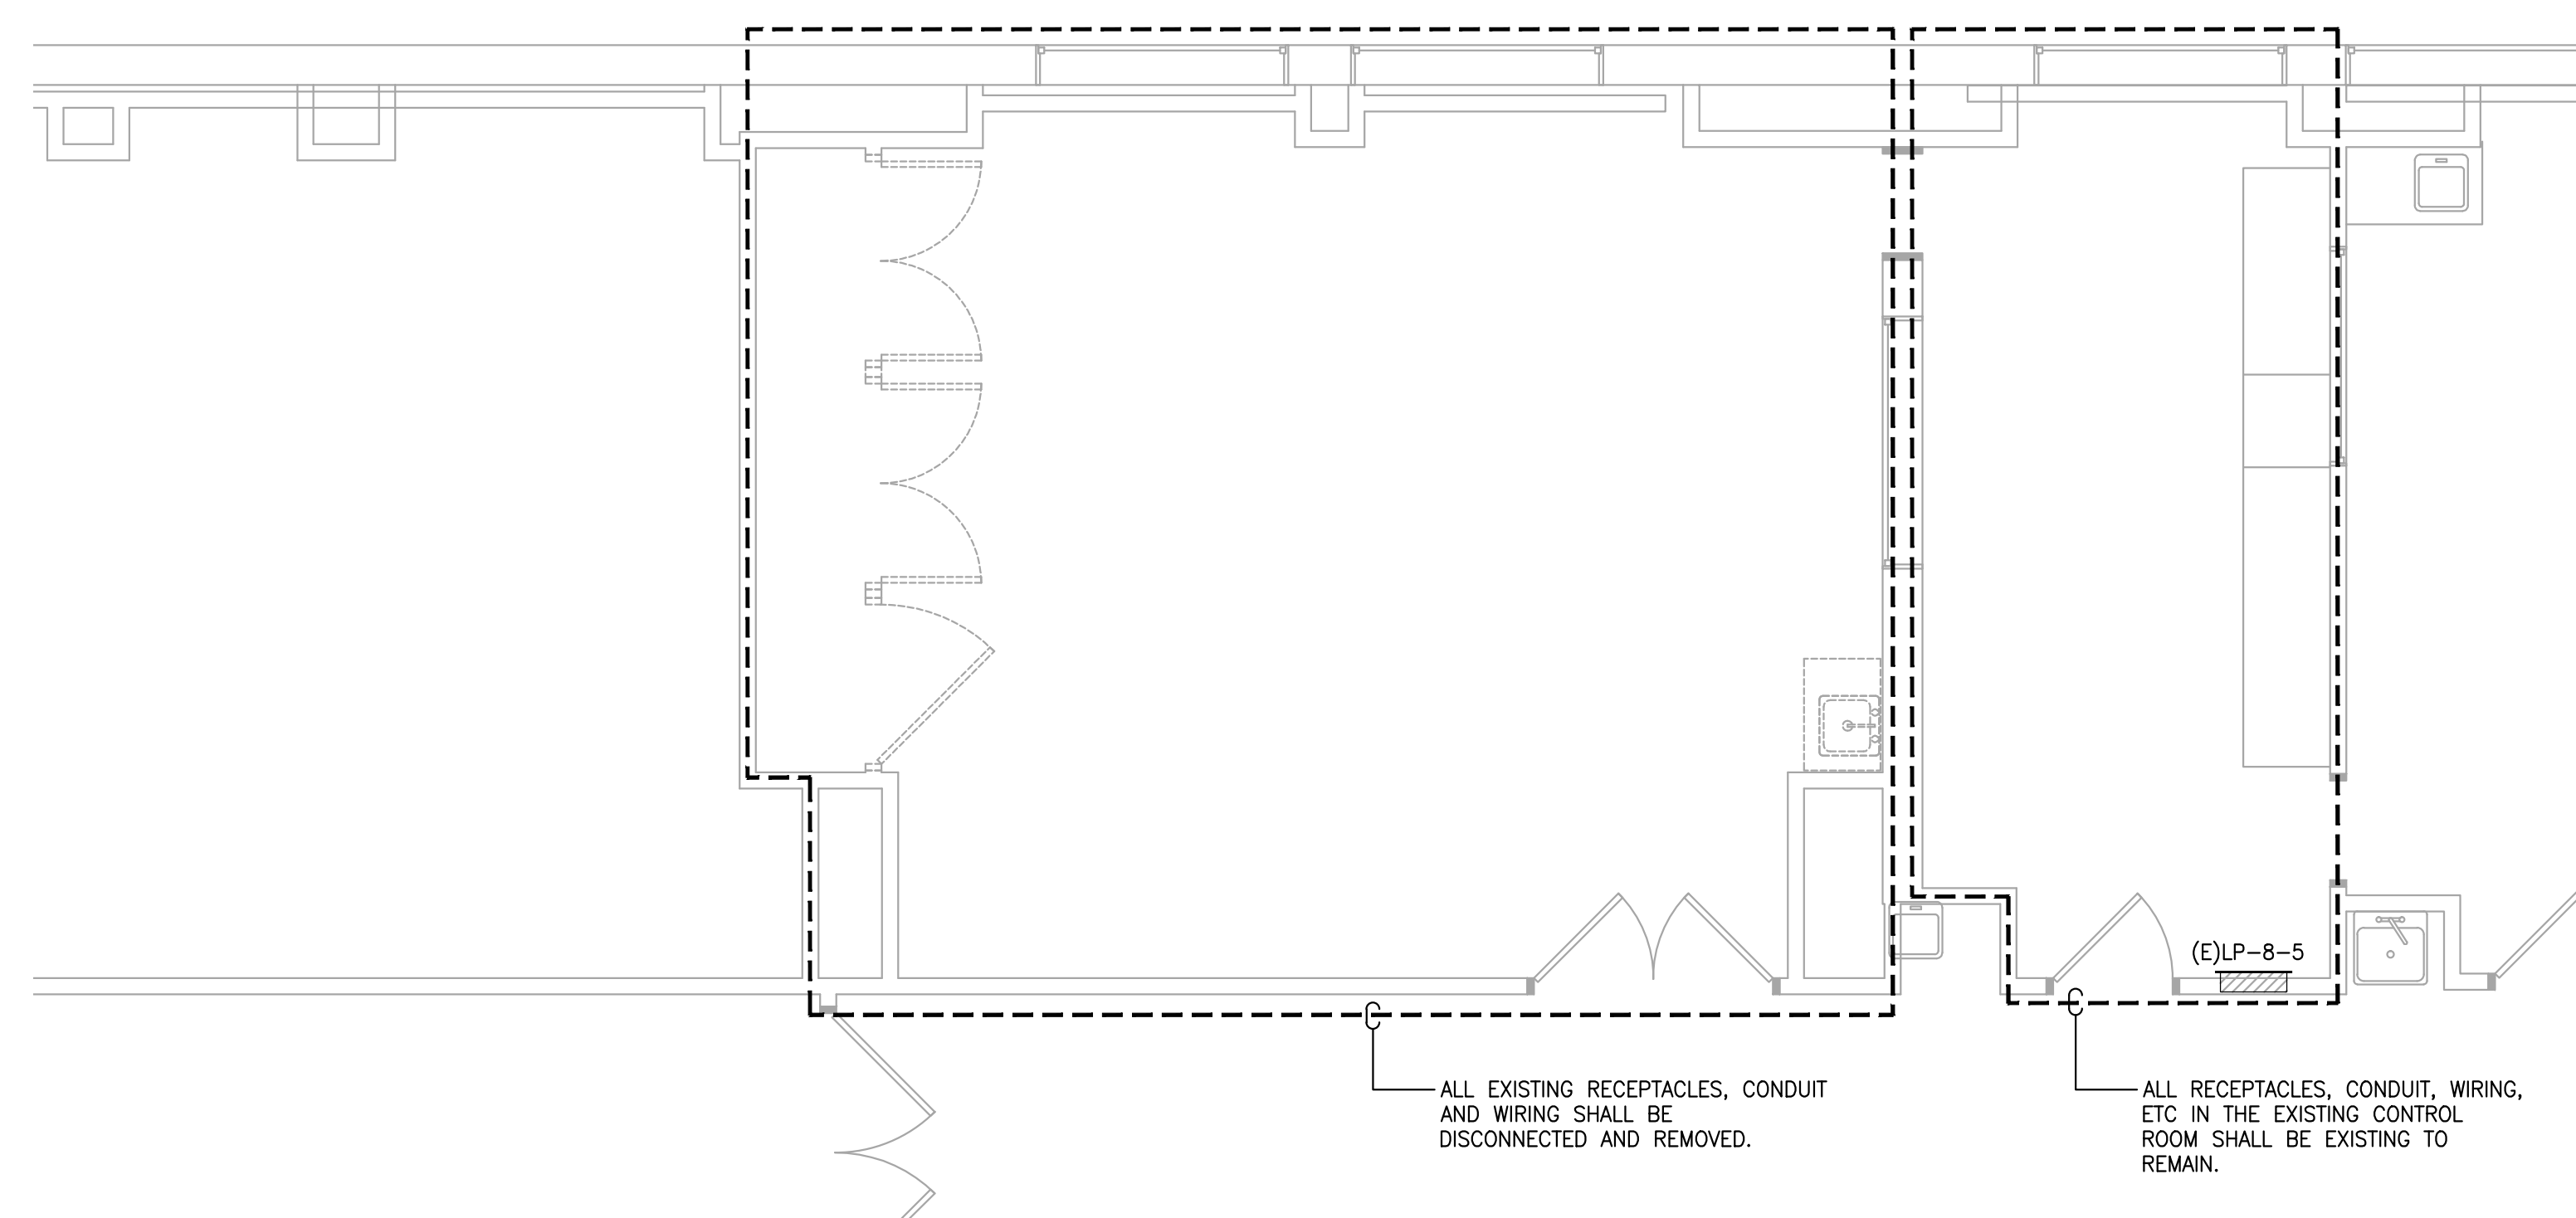

**2 DEMOLITION 8TH FLOOR POWER PLAN**  
 SCALE: 1/4"=1'-0"

P:\Projects\B1500001\B150268-000\Drawings\Elect\B150268-000\_LE\_100\_DEMO LIGHTING & POWER.dwg  
 LOGIN: Cousineau, Christopher PLOT DATE: 1/27/2016 3:14 PM SAVE DATE: 1/14/2016 2:59 PM