



SAVE DATE: 1/14/2016 3:01 PM

LOGIN: Cousseaux, Christopher PLOT DATE: 1/27/2016 3:16 PM


P:\Projects\B150268\000\Drawings\Electrical\B150268-000_E-400_FIRE_ALARM.dwg

DRAWING NOTES:


1. REFER TO DRAWING E-000 FOR LEGEND, SYMBOLS, ABBREVIATIONS AND ADDITIONAL GENERAL NOTES.

KEY NOTES:

① NEW FIRE ALARM DEVICES SHALL BE MANUFACTURED BY BASE BUILDING FIRE ALARM MANUFACTURER. NEW DEVICES SHALL BE WIRED TO EXISTING FIRE ALARM LOOPS SERVING AREA. ELECTRICAL CONTRACTOR SHALL PROVIDE ALL NECESSARY POWER SUPPLIES, BOOSTERS AND REPROGRAMMING OF SYSTEM TO ACCOMMODATE NEW DEVICES. COORDINATE WITH BUILDING FIRE ALARM VENDOR PRIOR TO SUBMITTING BID TO ENSURE SCOPE IS FULLY COVERED.

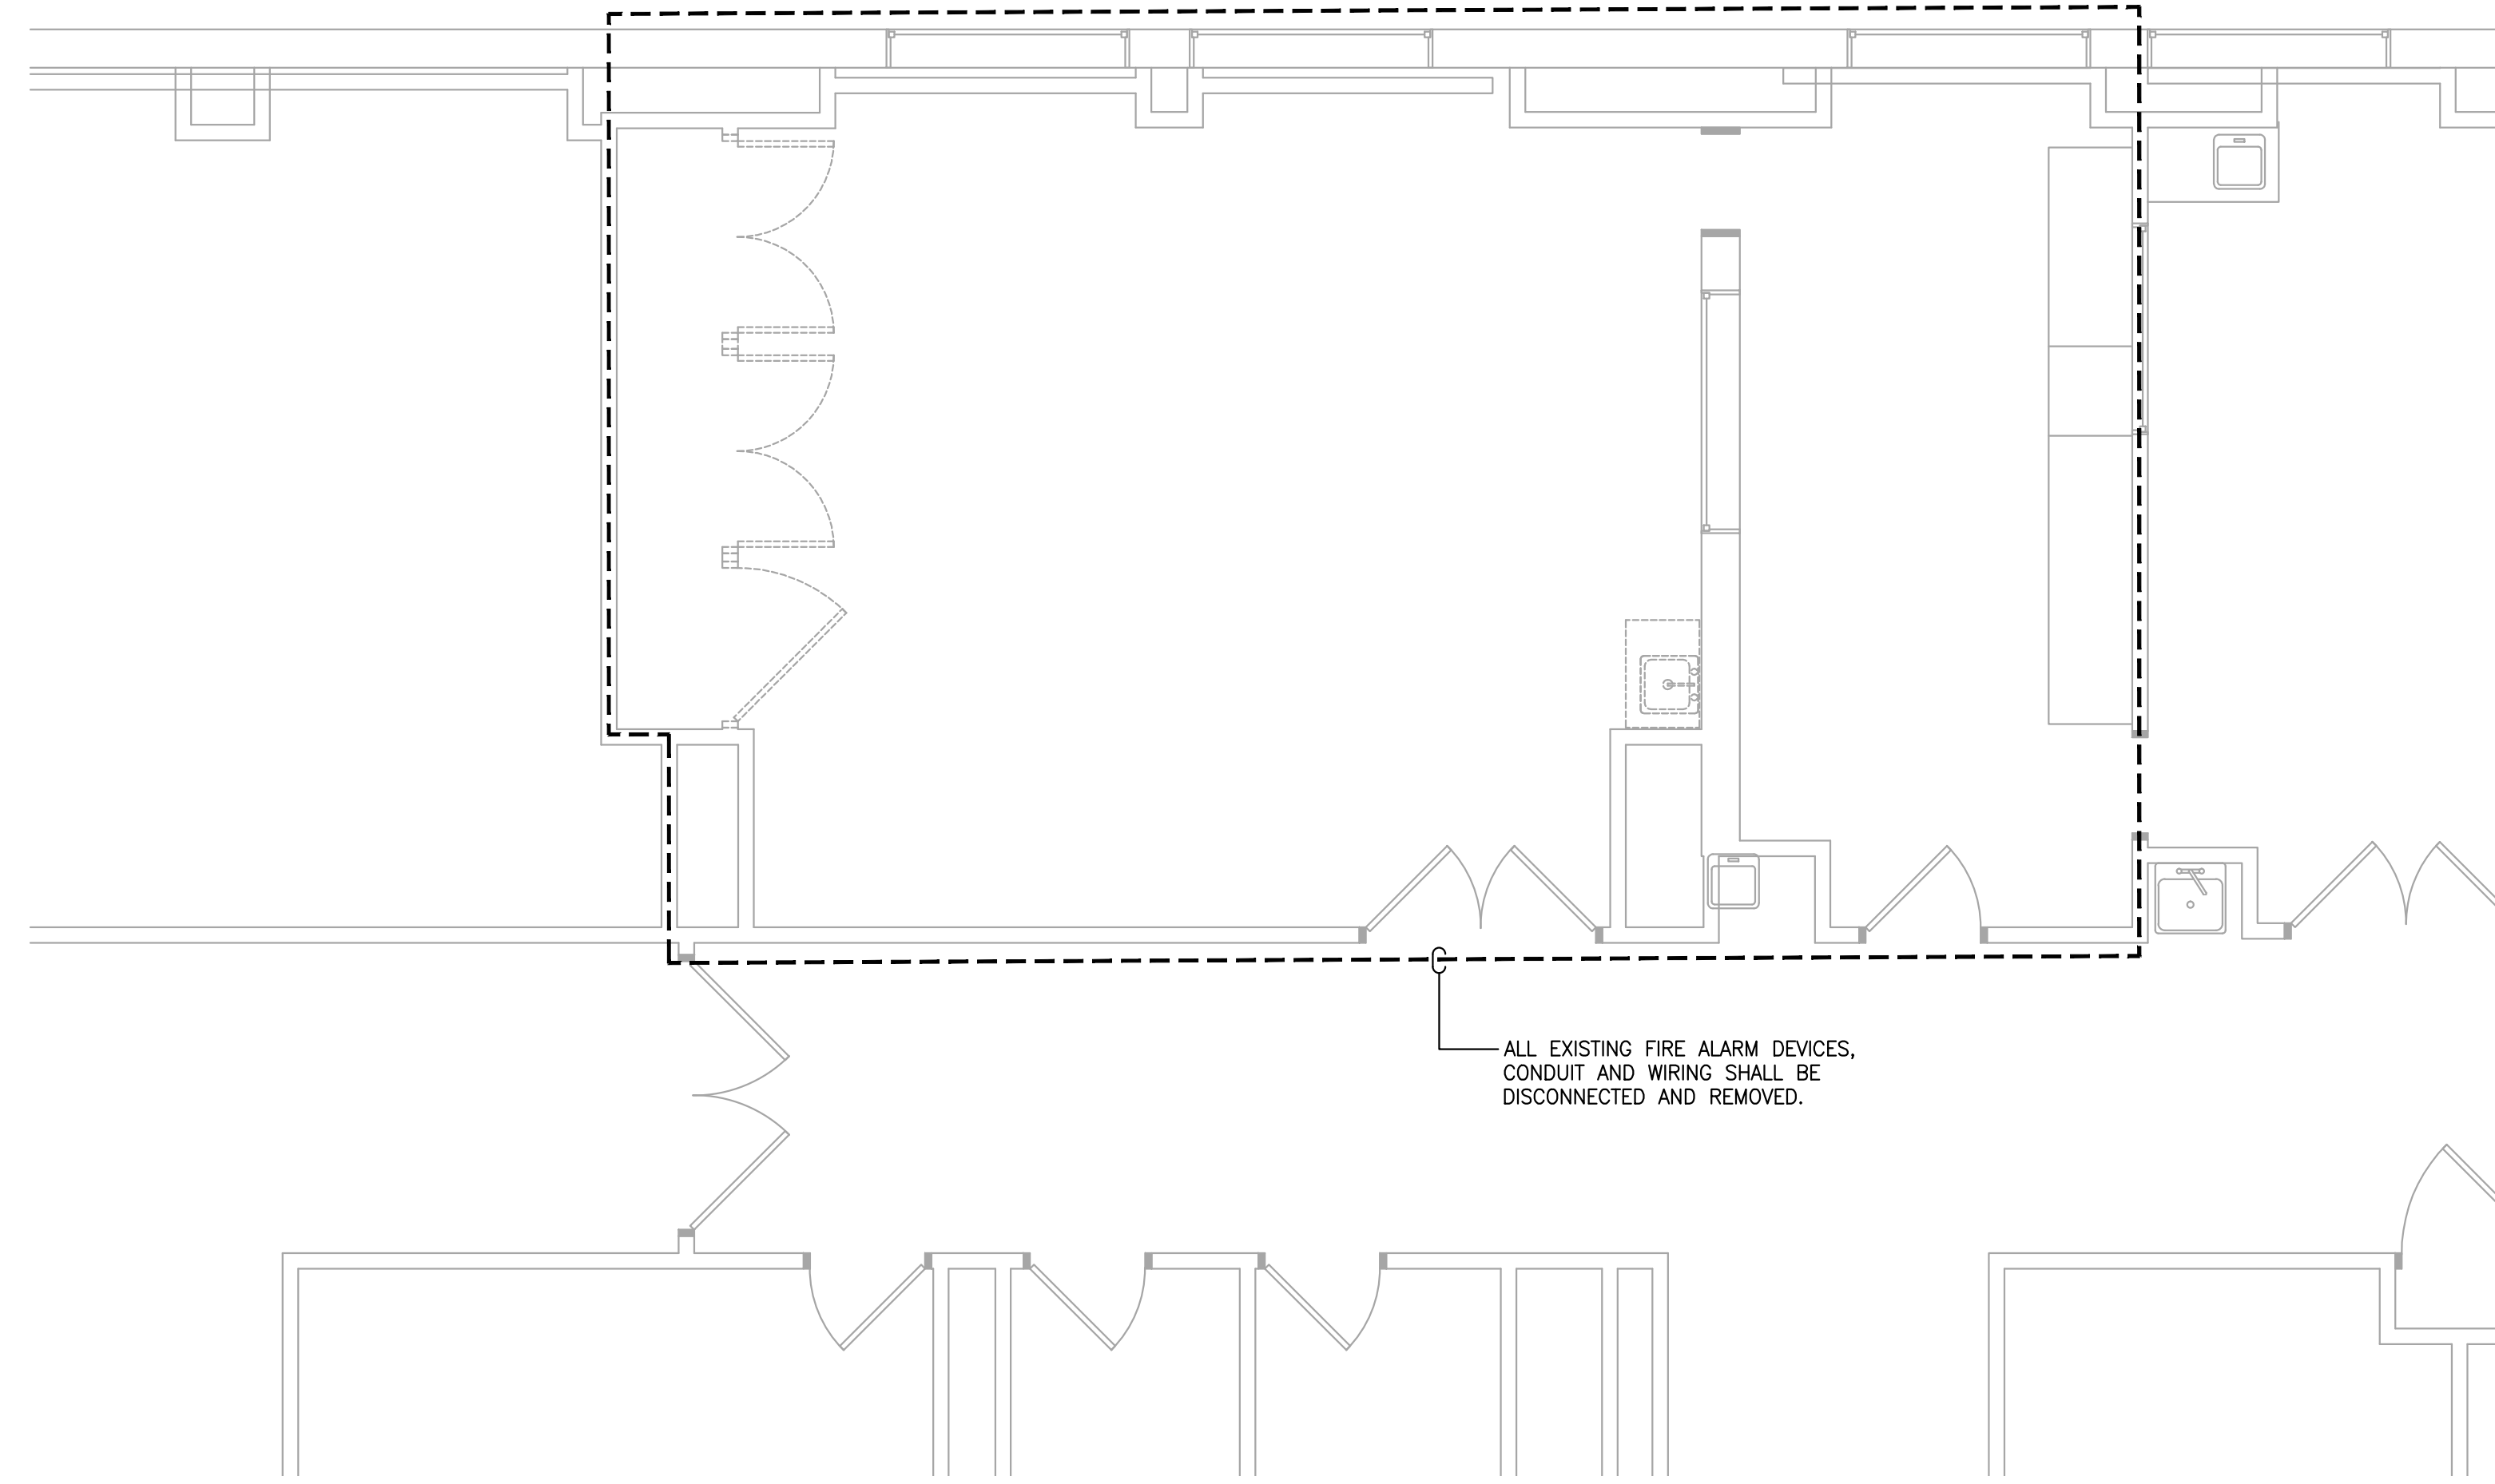

1 DEMOLITION 8TH FLOOR FIRE ALARM PLAN
SCALE: 1/4"=1'-0"

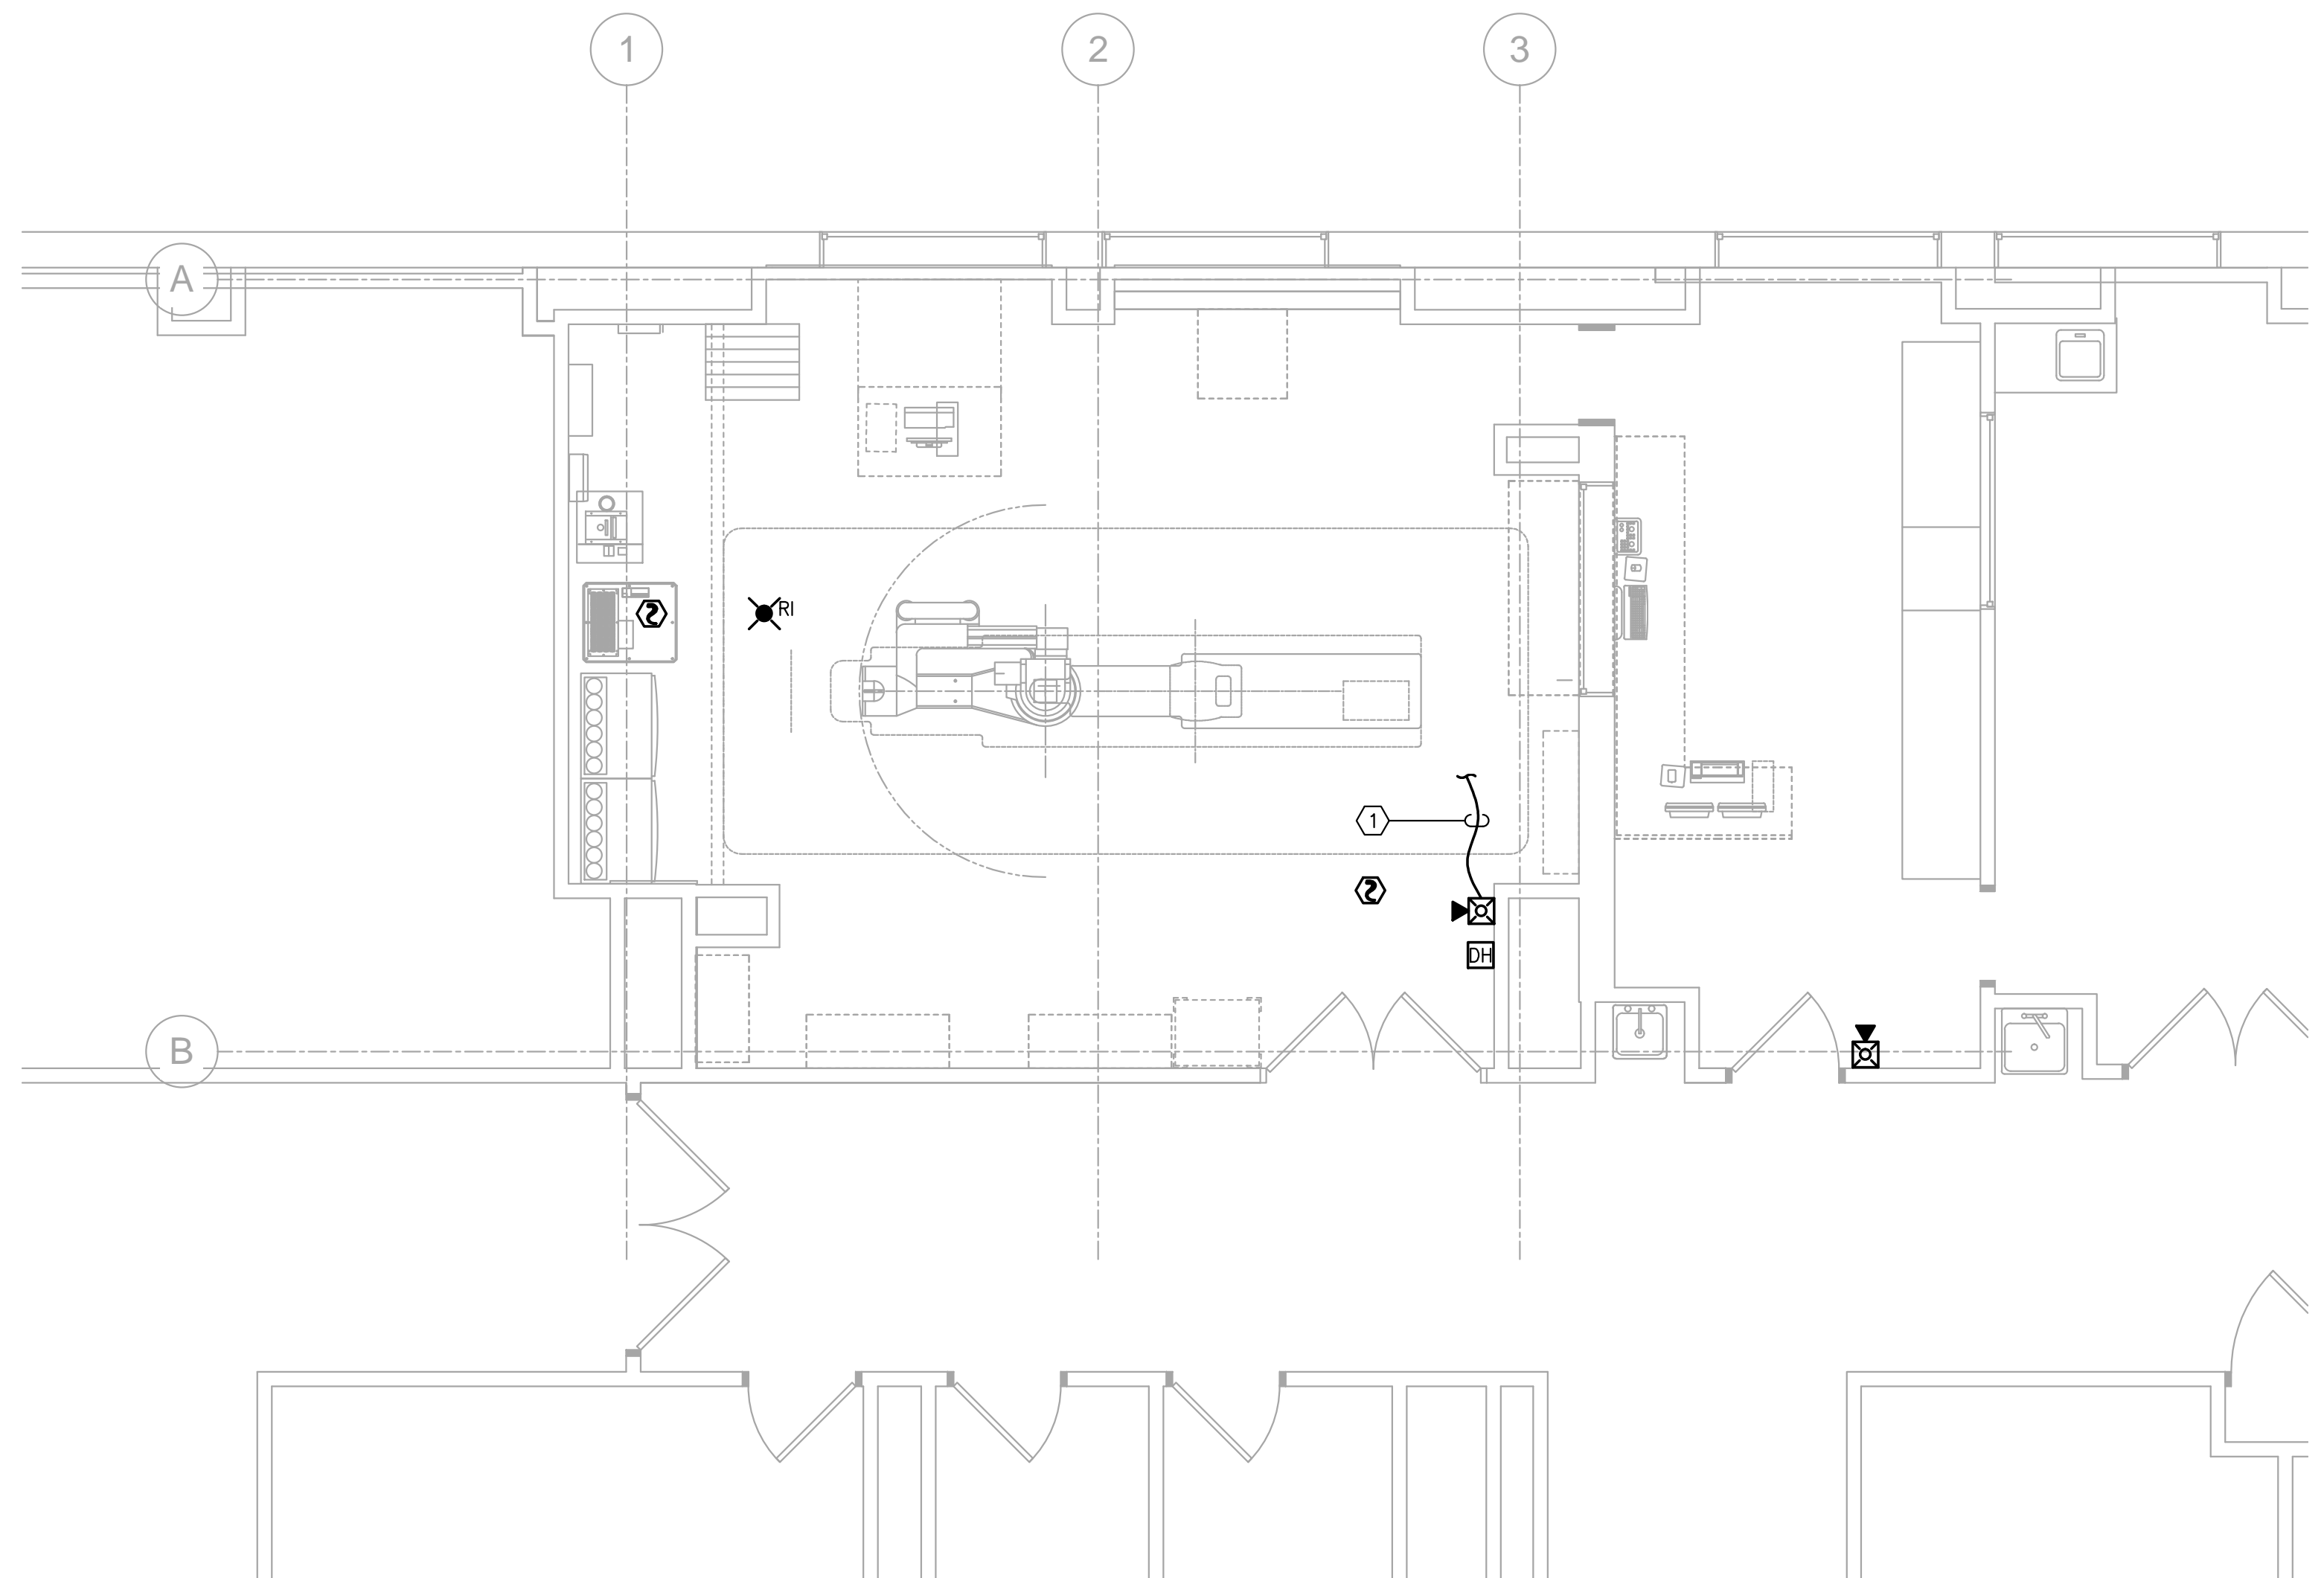


2 NEW 8TH FLOOR FIRE ALARM PLAN
SCALE: 1/4"=1'-0"



225 Franklin Street, Suite 1100
Boston, MA 02110
617.476.0300
617.476.0321
www.perkinswill.com

CONSULTANTS

AKF Group, LLC
99 Bedford Street, 2nd Floor
Boston, MA 02111
617.737.1111
617.737.4311

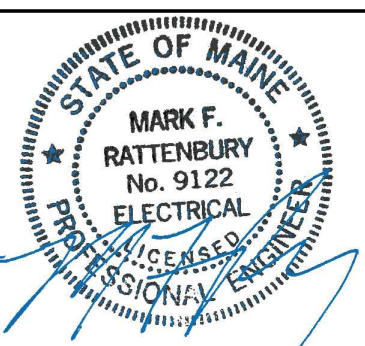

PROJECT

MMC Cath Lab 4
22 Bramhall Street
Portland, ME 04102



Maine Medical Center
22 Bramhall Street
Portland, ME 04102

KEYPLAN



ISSUE FOR BID

01/15/2016

ISSUE CHART

NO	ISSUE	DATE
Job Number	B150268-000	
Checked	MFR	
Approved	MFR	

TITLE
ELECTRICAL
8TH FLOOR
FIRE ALARM
PLANS
SHEET NUMBER

E-400