


CEILING LEGEND		
00 00 00 ACOUSTICAL CEILING TILE		
ACT-1	TYPE: ACT CEILING TILE MANUF: ARMSTRONG SERIES: - WIDTH/SIZE: 2'x2' COLOR: WHITE	
ACT-2	TYPE: - MANUF: - SERIES: - WIDTH/SIZE: - COLOR: TBD	

NOTE: MATCH EXISTING CEILING GRID HEIGHTS IN ALL PATIENT ROOMS.

- 2 x 2 ACT
- SUPPLY AIR DIFFUSER
- RETURN AIR GRILLE
- LINEAR DIFFUSER
- CURTAIN / IV TRACK
- 2 x 2 FLUORESCENT LIGHT FIXTURE
- PATIENT EXAM LIGHT FIXTURE 2x4
- RECESSED LIGHT FIXTURE
- WALL MOUNTED LIGHT FIXTURE (SCONCE)
- RECESSED LIGHT FIXTURE
- WALL MOUNTED LIGHT FIXTURE
- CEILING MOUNTED EXIT SIGN
- CEILING HEIGHT
- SMOKE DETECTOR

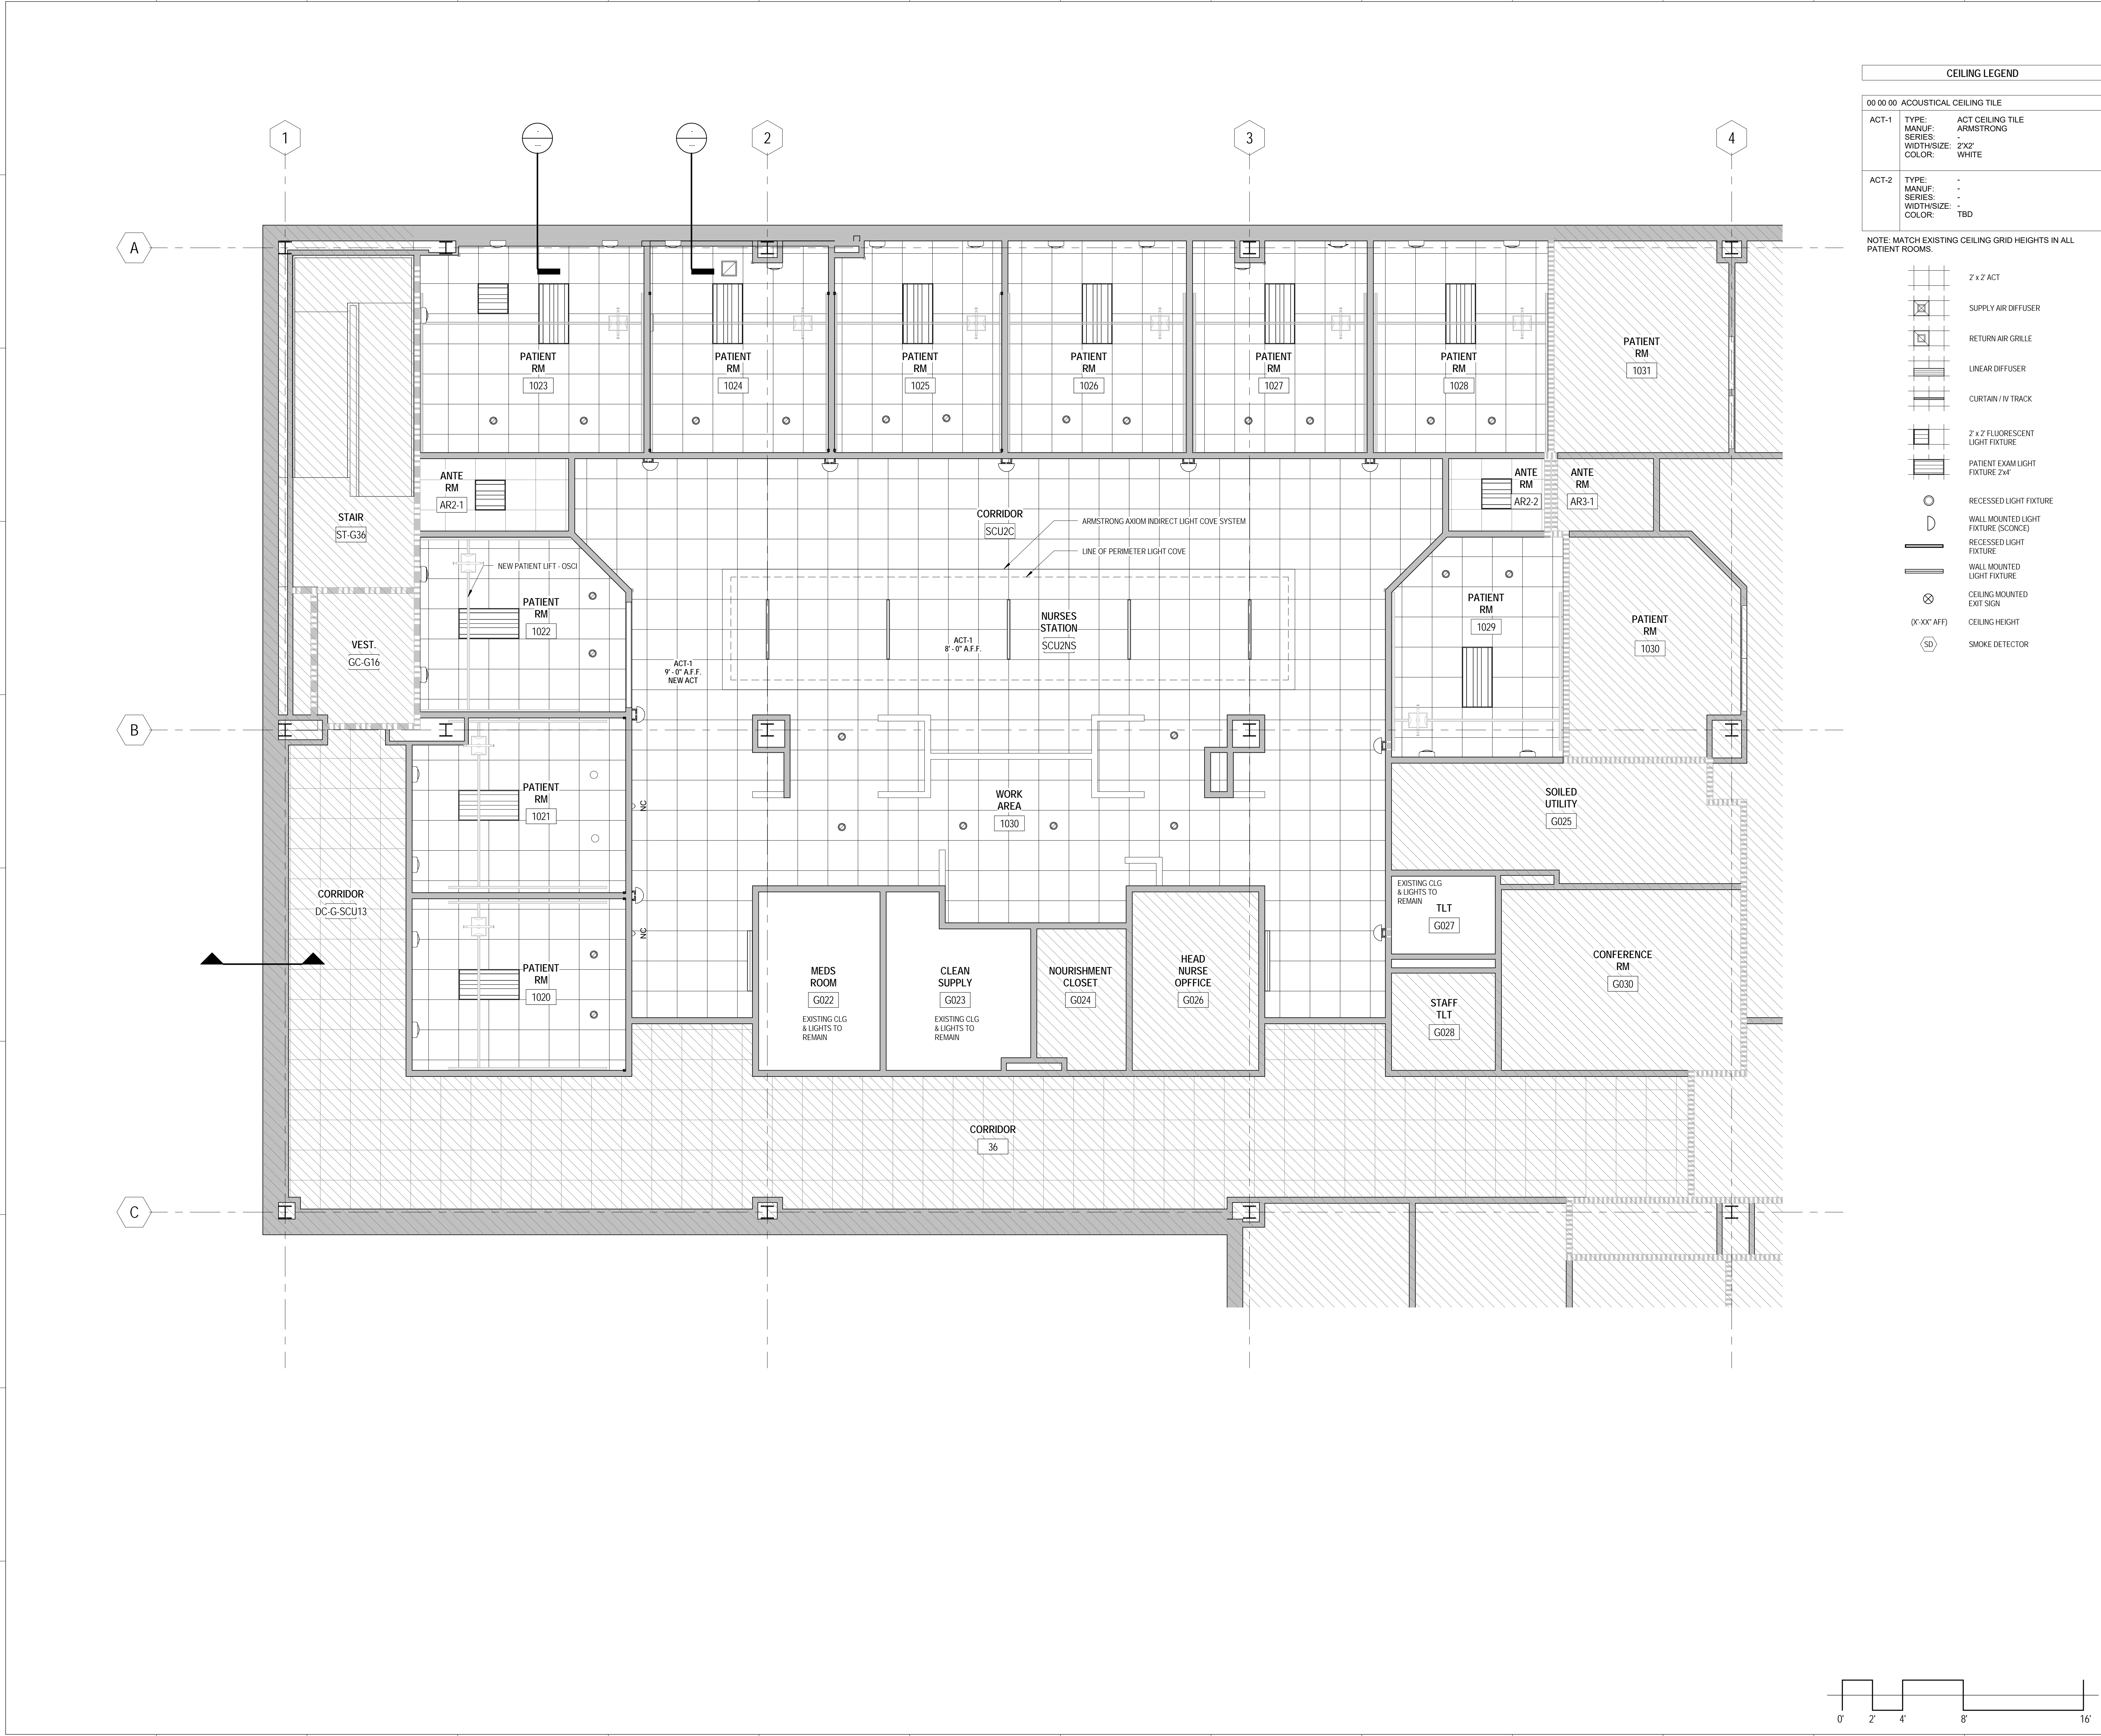

MAINE MEDICAL CENTER

**MMC SCU2
RENOVATIONS**

22 Bramhall Street, Portland, ME,
04102

NO.	DESCRIPTION	DATE

N


FOR ADDITIONAL INFORMATION, REFER TO PROJECT MANUAL.

CONTENT: GROUND FLOOR REFLECTED CEILING PLAN	
DRAWN BY:	RH
PROJECT NO.:	15-072-00
DATE:	01/22/16
REVISED:	
SCALE:	As Indicated

A1.4s

Project Phase
ISSUED FOR PERMIT

COPYRIGHT © 2016 BY LAVALLEE/BRENSINGER PROFESSIONAL ASSOCIATION. ALL RIGHTS RESERVED. NO REPRODUCTION WITHOUT PERMISSION.

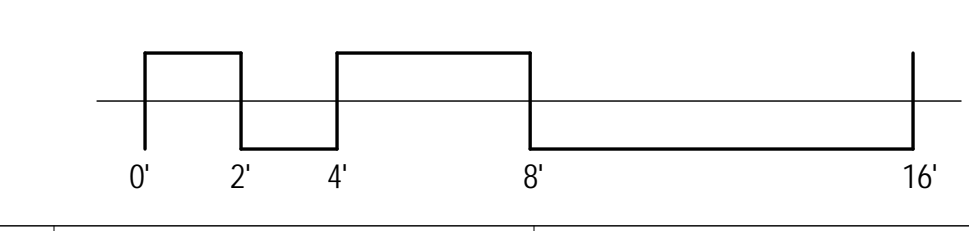

1/22/2016 4:11:00 PM C:\projects\15072-00 MMC SCU2\2\ceiling\A1.4s.dwg