

PERKINS + WILL

225 Franklin Street, Suite 1100
Boston, MA 02110
t 617.478.0300
f 617.478.0321
www.perkinswill.com

ACCU RELOCATION

22 Bramhall Street
Portland, Maine 04102




MAINE MEDICAL CENTER

22 Bramhall Street
Portland, Maine 04102

MEPFP
AKF GROUP LLC
41 Farnsworth Street, 3rd Floor
Boston, MA 02210
t 617.737.1111
f 617.737.4311

Index of Drawings	
SHEET NUMBER	SHEET NAME
01-GENERAL	
G00-00	COVER SHEET
G01-01	CODE COMPLIANCE PLAN
05-ARCHITECTURAL	
A04-10	DEMOLITION PLAN - MGB 01
A10-10	NEW WORK PLAN - MGB 01
A12-01	REFLECTED CEILING PLAN - MGB 01
A15-01	FURNITURE & ELECTRICAL PLAN
10-MECHANICAL	
M000	MECHANICAL COVER SHEET
M100	MECHANICAL DUCTWORK FLOOR PLAN
M200	MECHANICAL PIPING FLOOR PLAN
M300	MECHANICAL SCHEDULES

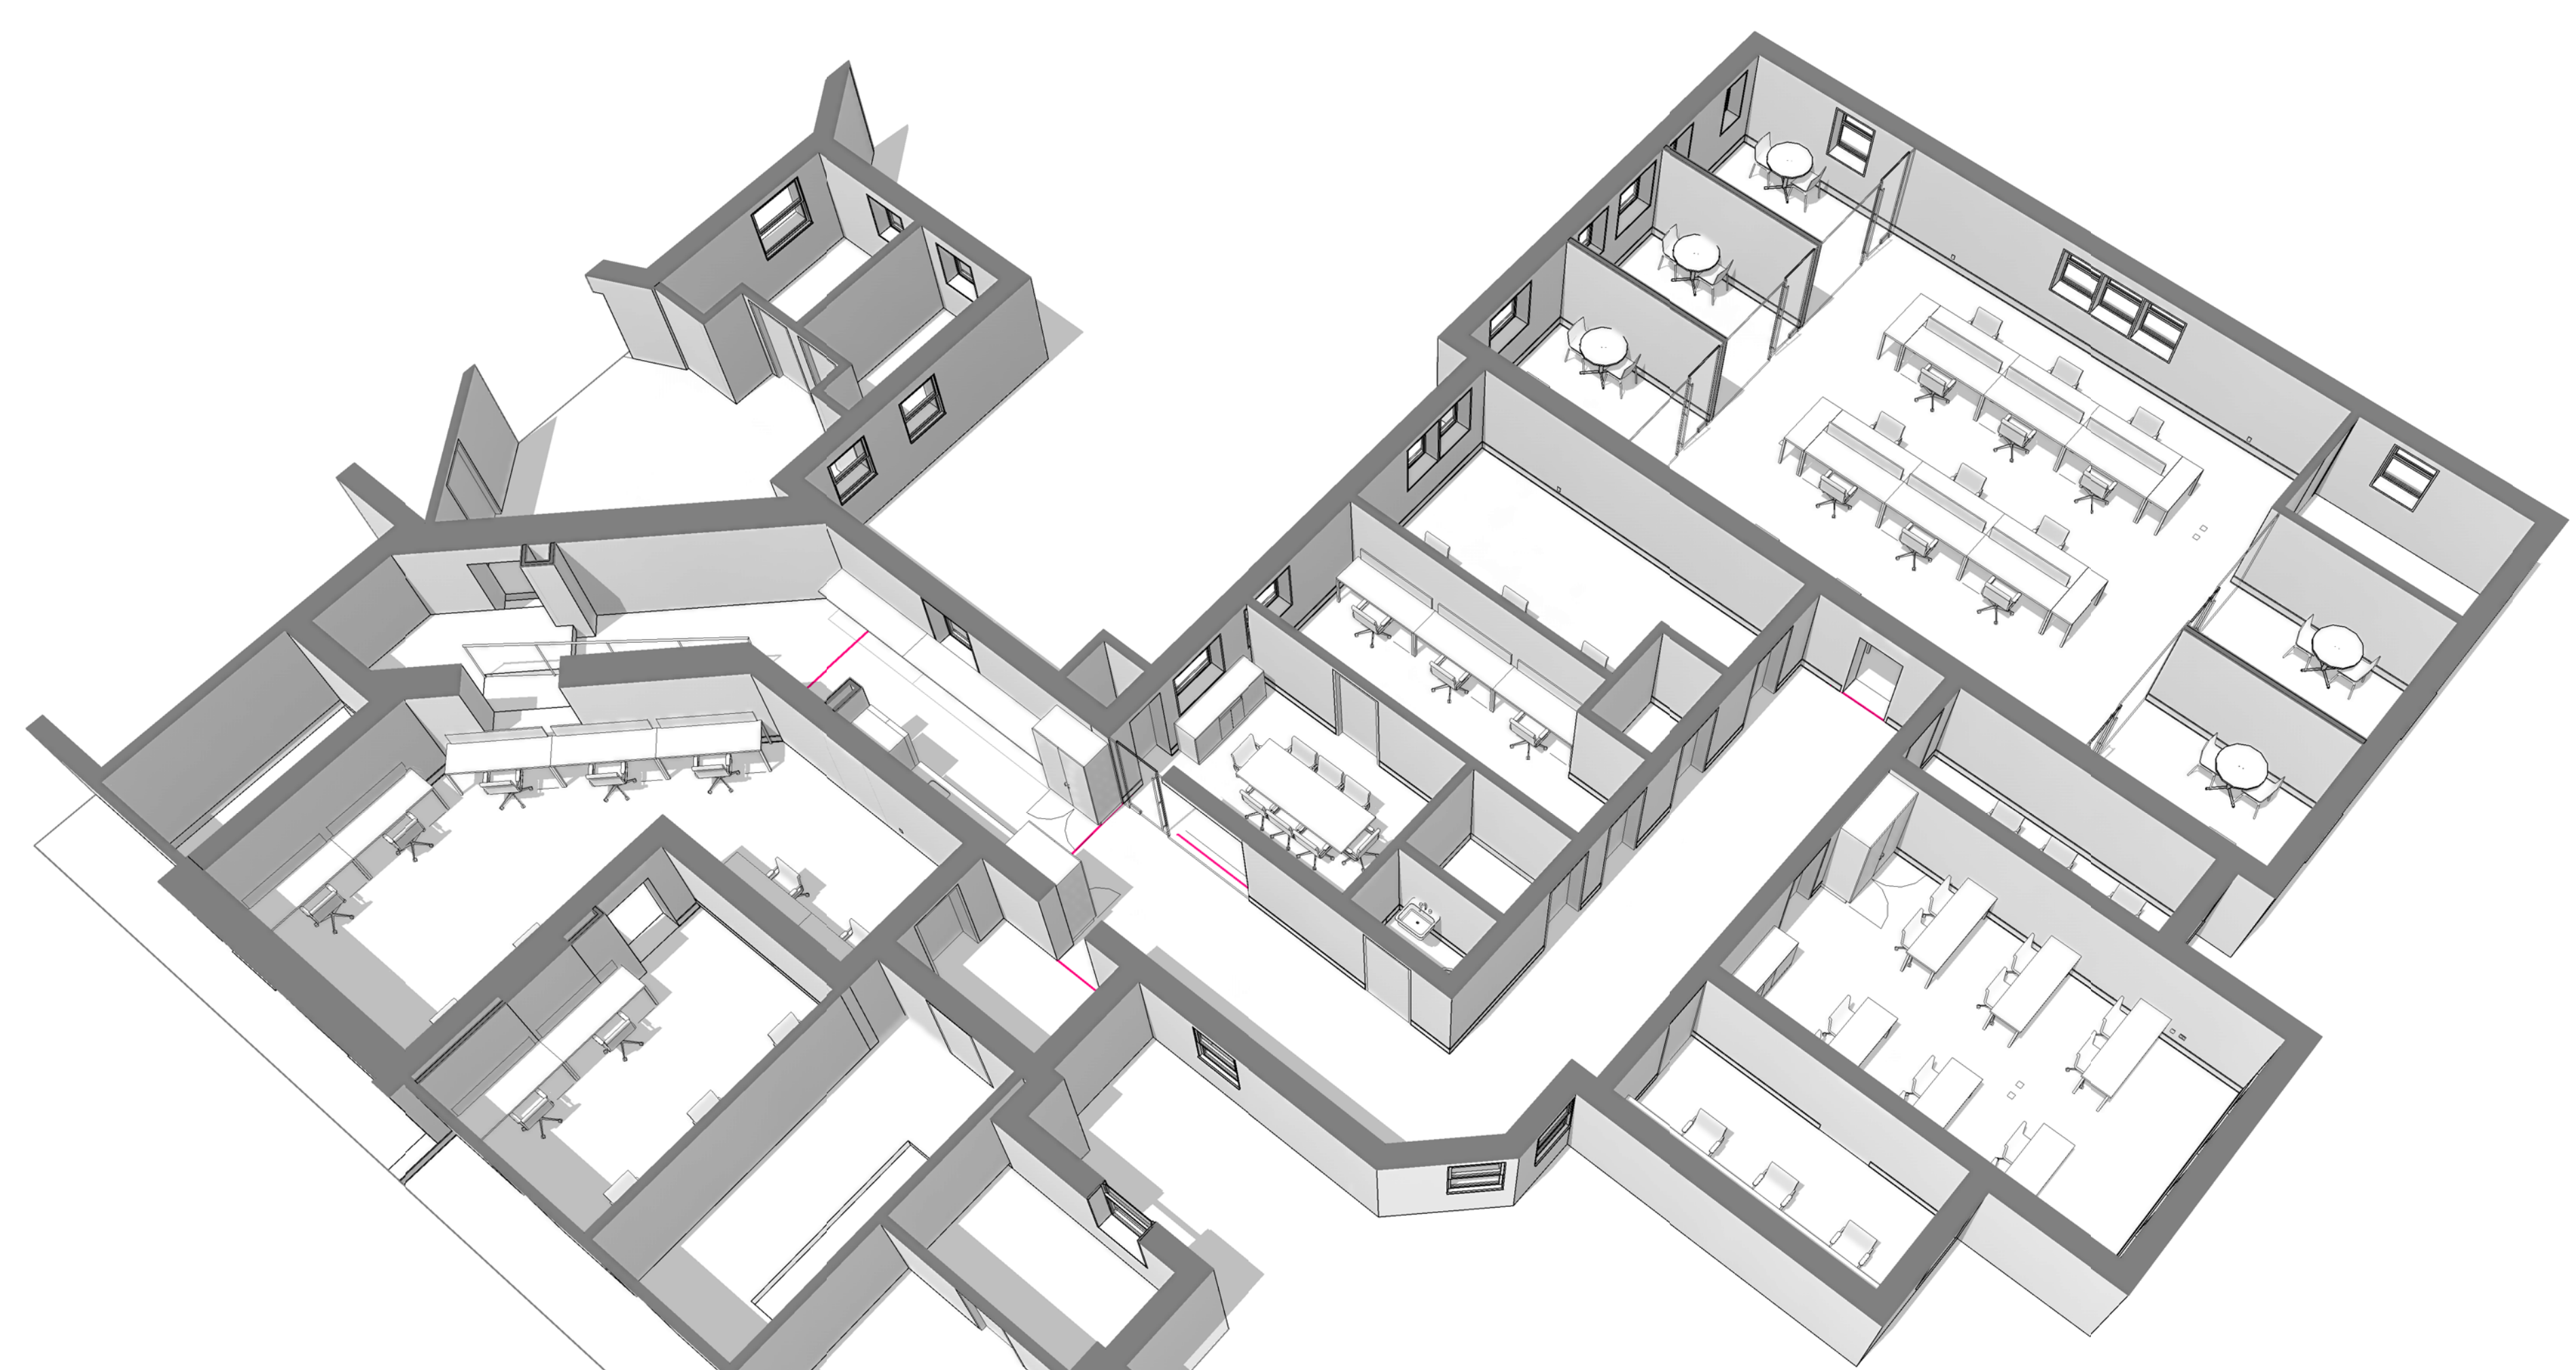

4/1/2016 6:25:07 PM
c:\temp\152188 - ACCU\MGB - 02016_estevesa.rvt

CONSTRUCTION DOCUMENTS 04/01/2016