


PL: Project: B1600008160008-000-D-Design Mgmt: CAD: M: B16008-000_M-100.dwg
LOGIN: Cavendish, David
PLOT DATE: 4/12/2016 4:23 PM
SAVE DATE: 4/12/2016 2:49 PM

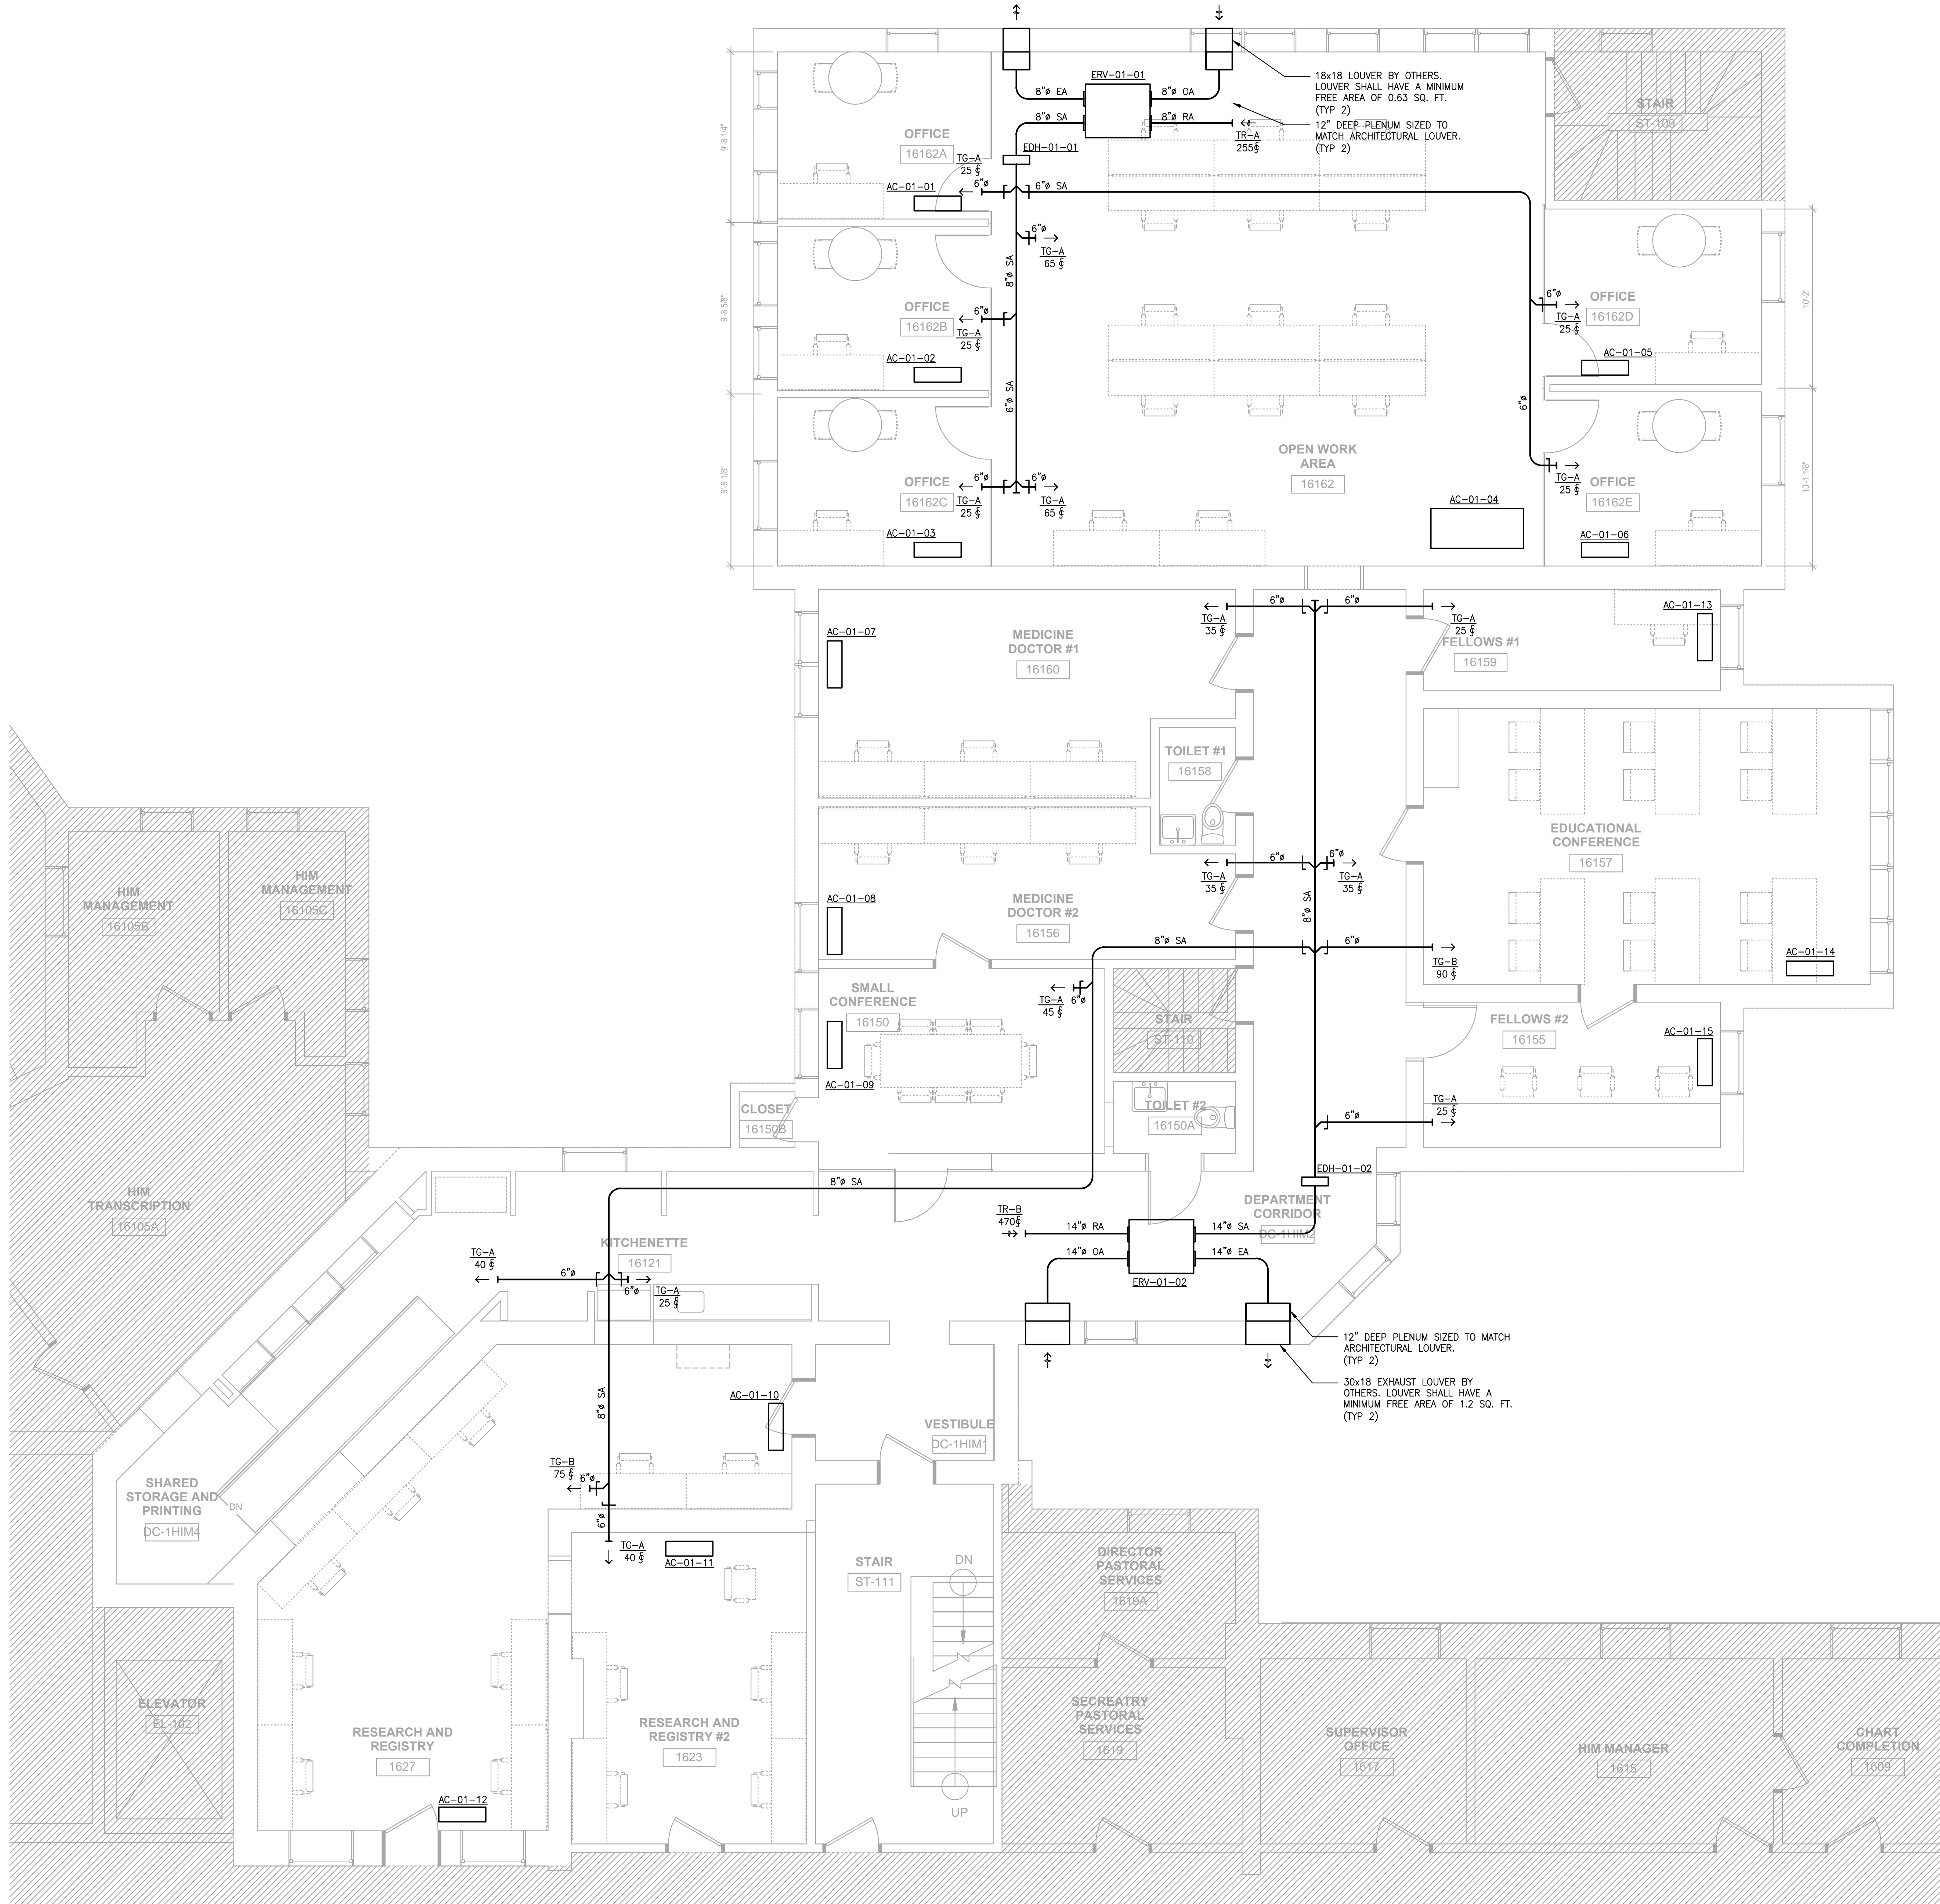

PERKINS+WILL
225 Franklin Street, Suite 1100
Boston, MA 02110
1617.478.0300
1617.478.0321
www.perkinswill.com

CONSULTANTS
MEPP
AKF GROUP LLC
89 Bedford St., 2nd Floor
Boston, MA 02111
1617.737.1111
1617.737.4311



PROJECT
ACCU RELOCATION
22 Bramhall Street
Portland, Maine 04102



MAINE MEDICAL CENTER
22 Bramhall Street
Portland, Maine 04102

ISSUED FOR PERMIT
04/01/2016
ISSUE CHART

NO.	ISSUE	DATE
1	Job Number	B160089-000
2	Checked	
3	Approved	

TITLE
MECHANICAL DUCTWORK FLOOR PLAN

SHEET NUMBER

M-100

Copyright © 2016 Perkins+Will